


D SIZE 22" x 34" (559mm x 864mm)

PLOT: 06/09/12 10:32:07 AM

UMA FILE NAME: 0265-388-00_01-E-0002_RX.dwg Saved By: jnberg

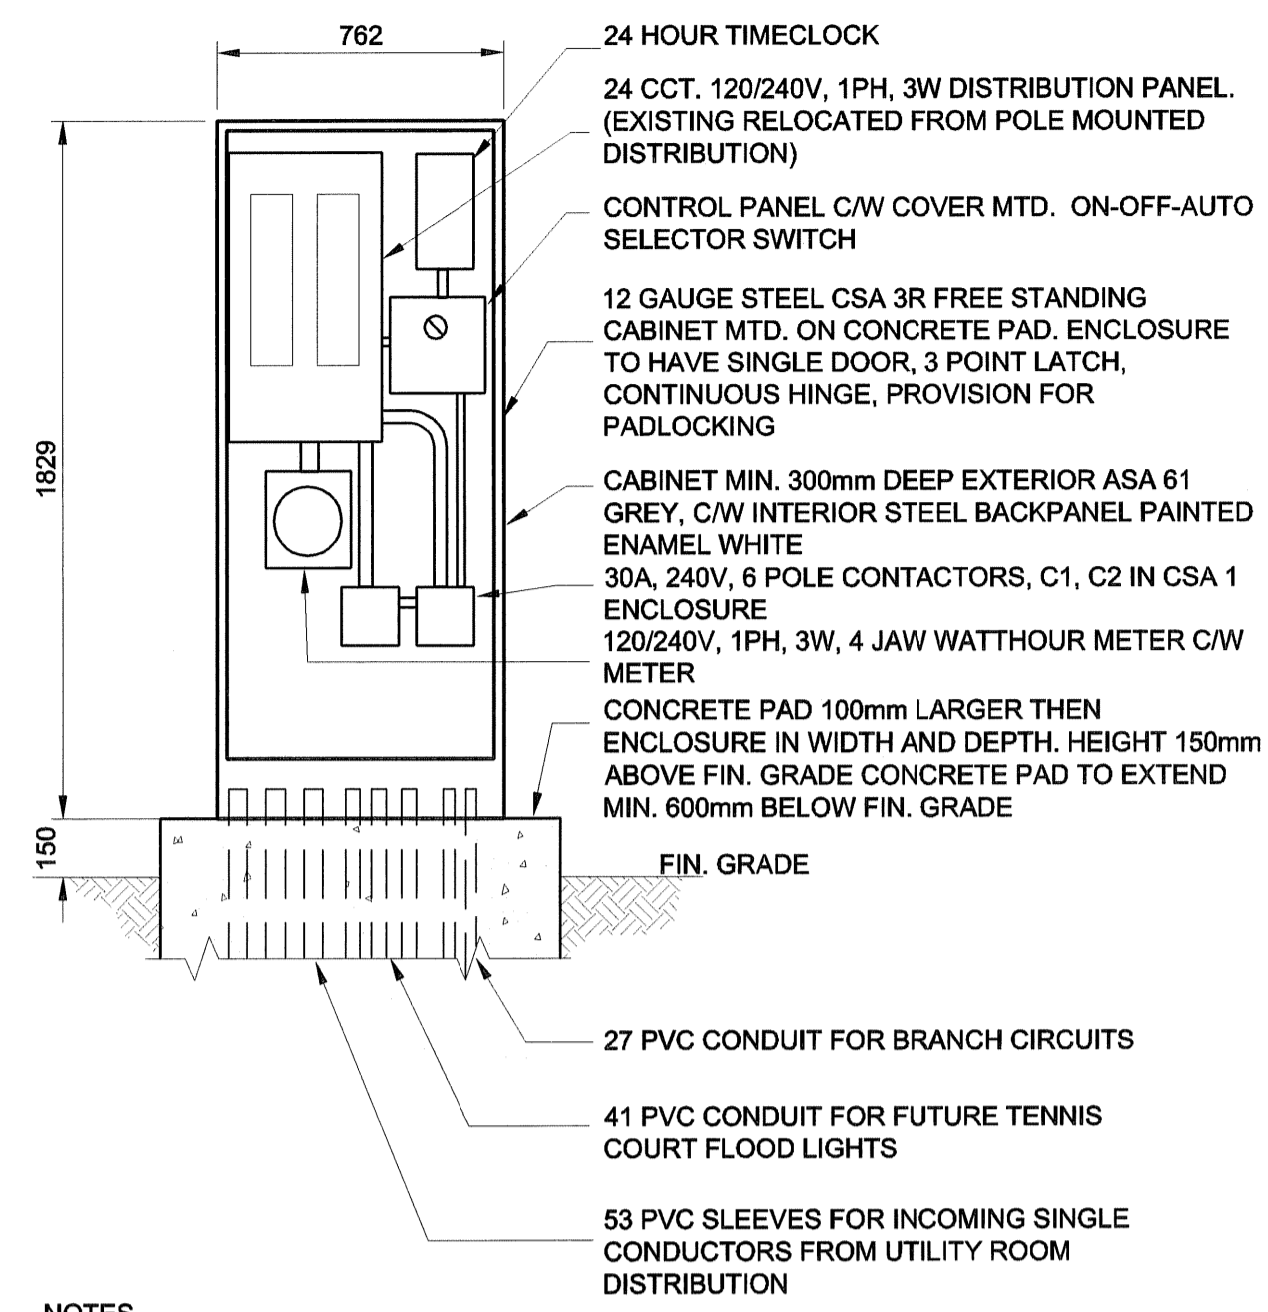


NOTES
SEAL ALL CONDUITS AFTER INSTALLATION OF CABLES. CAP SPARE CONDUITS. ALL WIRING TO BE CONCEALED.

DETAIL 1 E-1

0 200 400 600 mm SCALE 1:20

DISTRIBUTION / CONTROL ENCLOSURE SHOWN WITH FRONT DOOR REMOVED

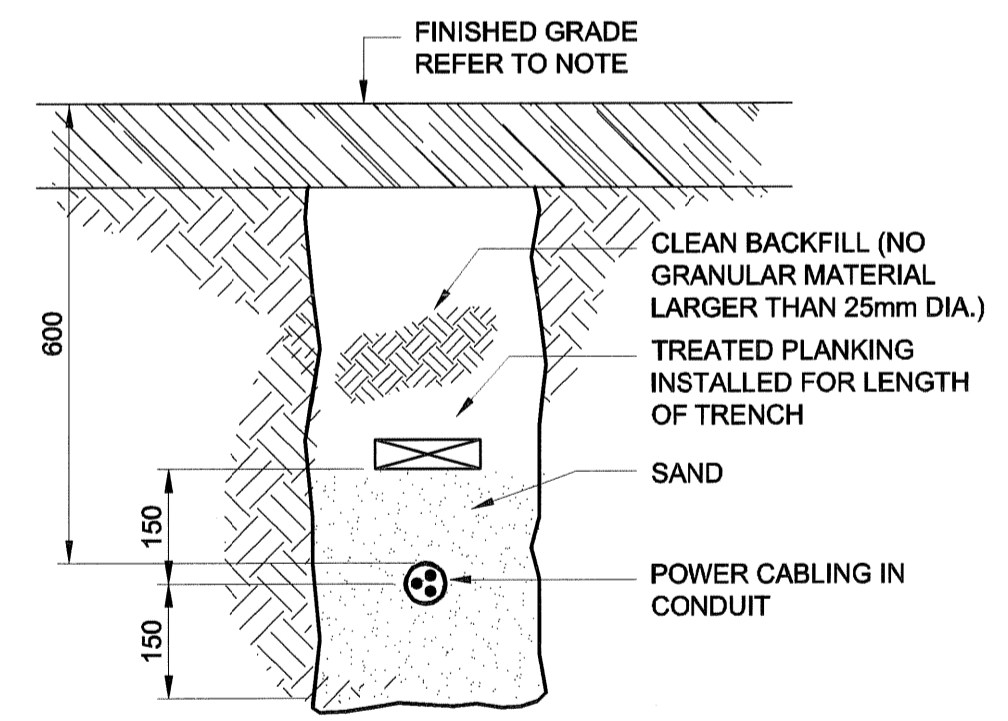


NOTE
CONTRACTOR TO FINISH GRADE OUTSIDE TENNIS COURT AREA, 100mm SOIL TOPPING C/W GRASS SEED. TENNIS COURT ASPHALT CONTRACTOR TO FINISH GRADE OVER TRENCHING IN TENNIS COURT BOUNDARY


DETAIL 2 E-1

0 100 200 300 mm SCALE 1:10

TRENCH FLOOD LIGHTING POWER CABLES

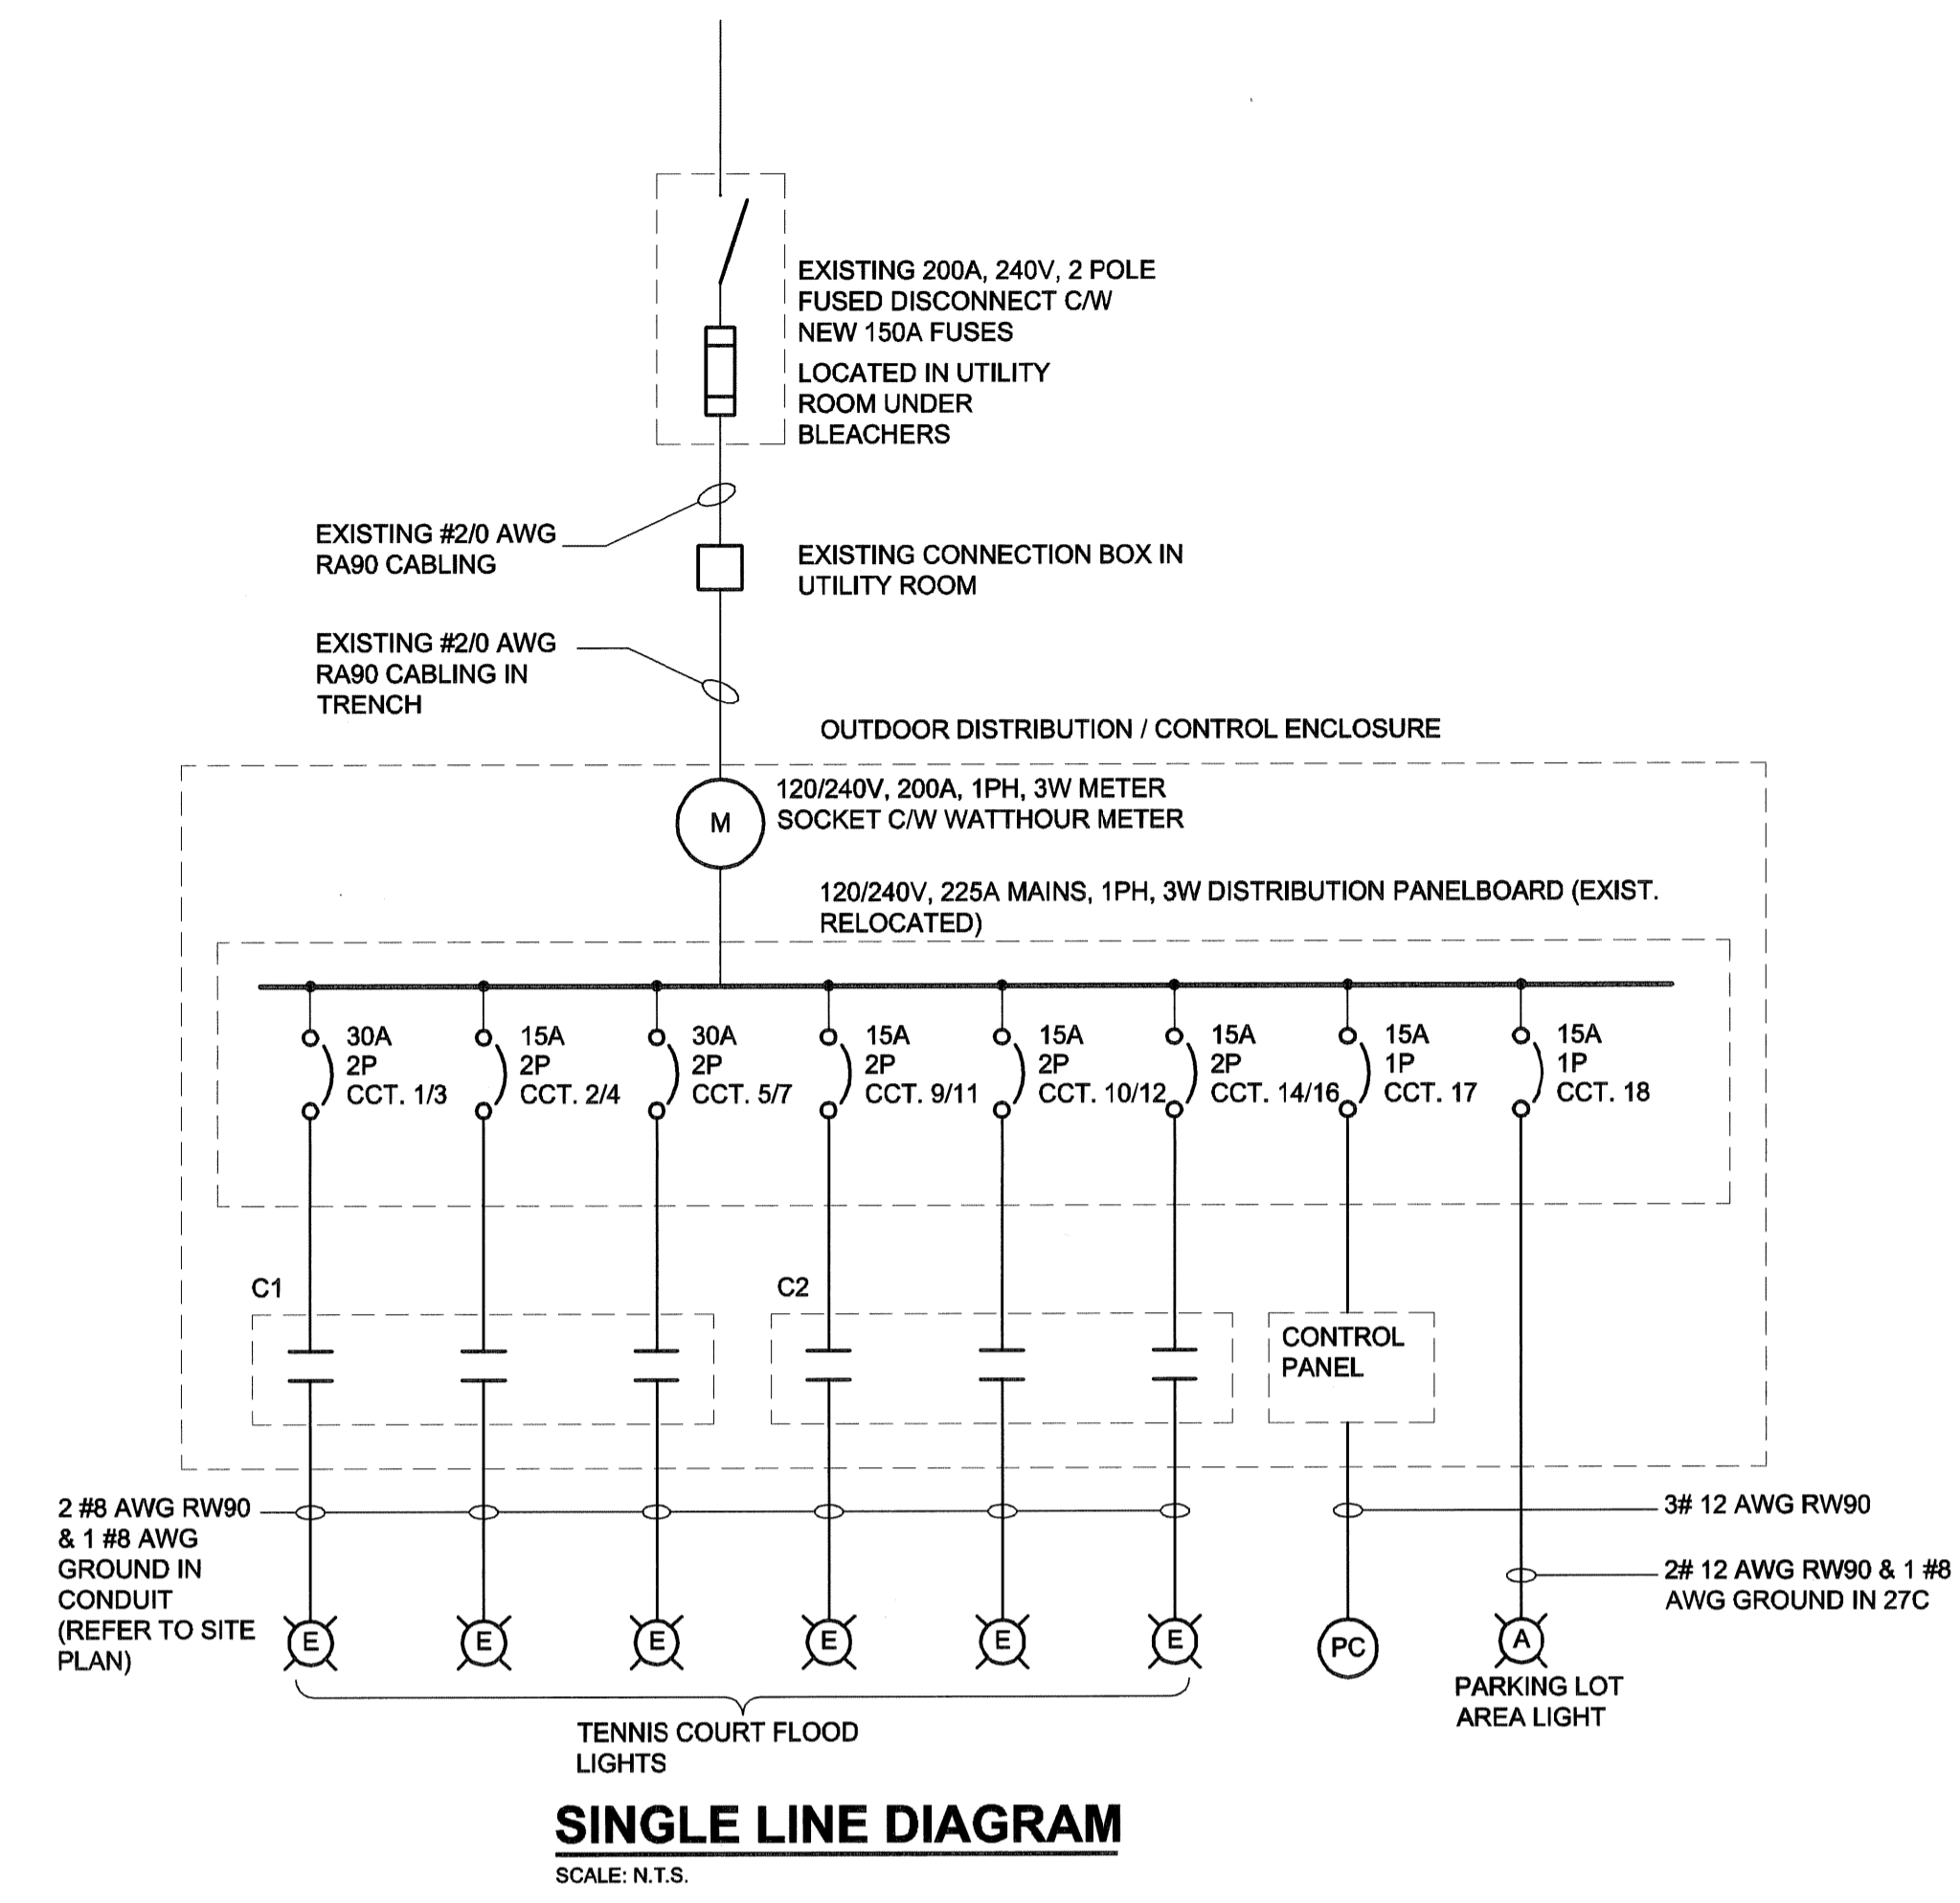

SINGLE LINE DIAGRAM
SCALE: N.T.S.

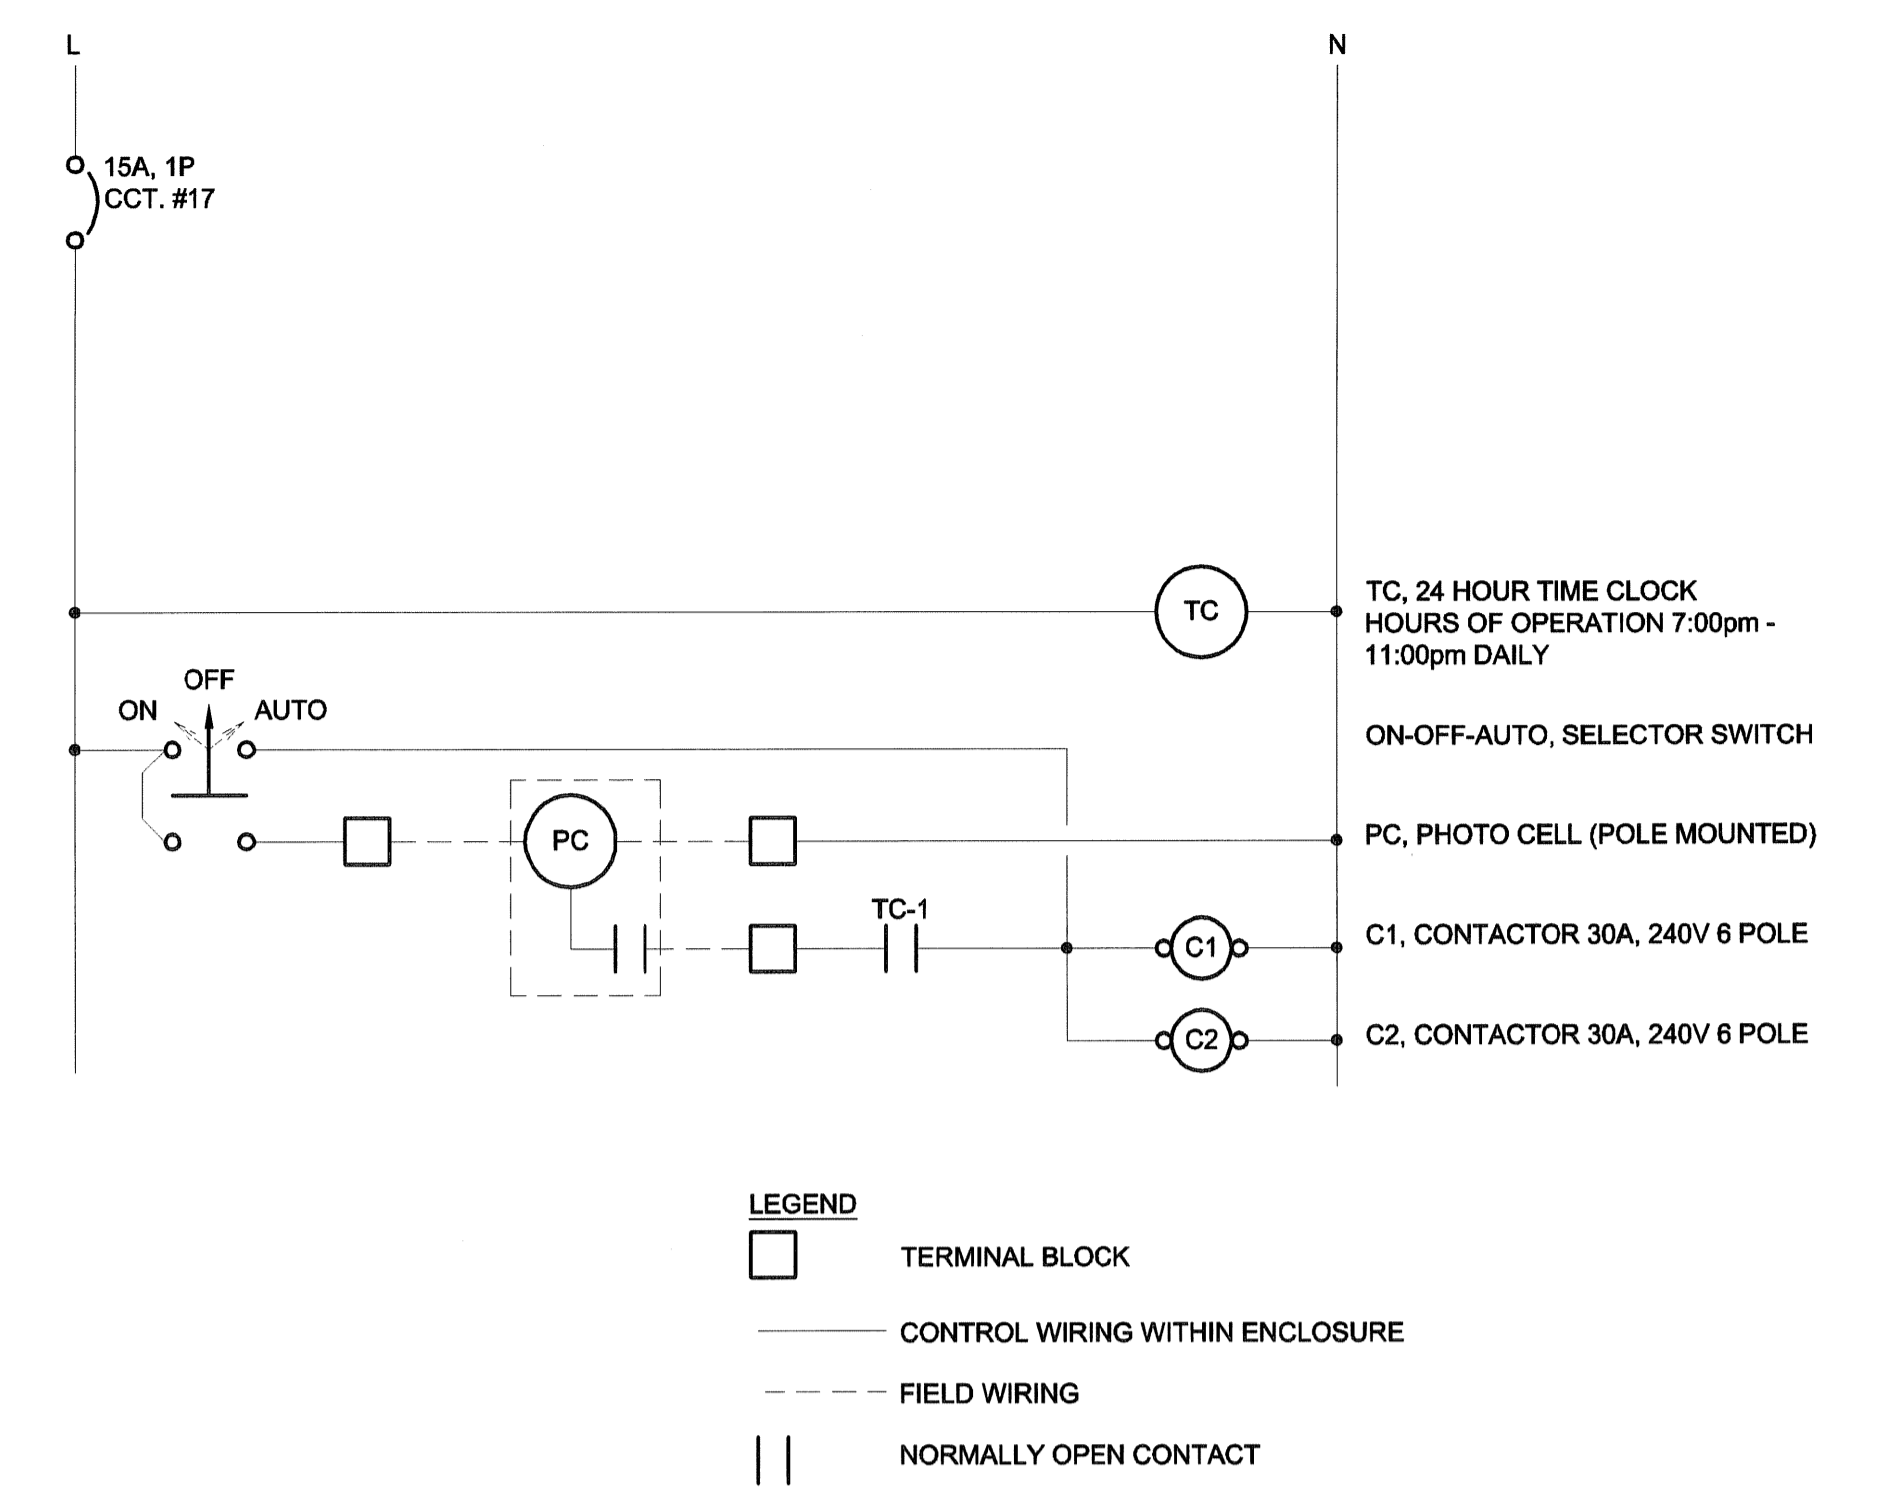

LEGEND


□ TERMINAL BLOCK

— CONTROL WIRING WITHIN ENCLOSURE

- - - FIELD WIRING


|| NORMALLY OPEN CONTACT

CONTROL SCHEMATIC
SCALE: N.T.S.

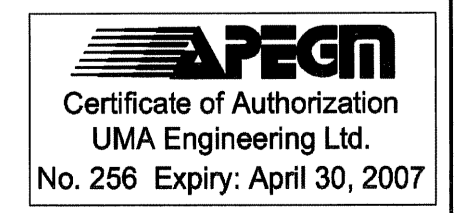

LOCATION APPROVED UNDERGROUND STRUCTURES		DATE	
SUPR. U/G STRUCTURES COMMITTEE		DATE	
NOTE: LOCATION OF UNDERGROUND STRUCTURES AS SHOWN ARE BASED ON THE BEST INFORMATION AVAILABLE. BUT NO GUARANTEE IS GIVEN THAT ALL EXISTING UTILITIES ARE SHOWN OR THAT THE GIVEN LOCATIONS ARE EXACT. CONFIRMATION OF EXISTENCE AND EXACT LOCATION OF ALL SERVICES MUST BE OBTAINED FROM THE INDIVIDUAL UTILITIES BEFORE PROCEEDING WITH CONSTRUCTION.			
NO.	ISSUED FOR CONSTRUCTION	06/09/11	SCK
NO.	REVISIONS	YY/MM/DD	BY

UMA AECOM	
© 2006 UMA ENGINEERING LTD. ALL RIGHTS RESERVED.	
DESIGNED BY SCK	CHECKED BY
DRAWN BY SCK	APPROVED BY
HOR. SCALE AS SHOWN	RELEASED FOR CONSTRUCTION
VERT. SCALE	DATE

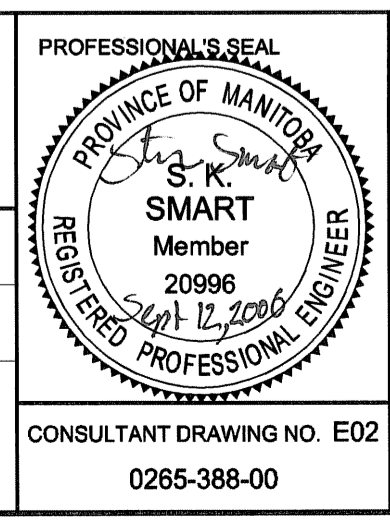

TENDER NO. 585-2006

THE CITY OF WINNIPEG
PUBLIC WORKS DEPARTMENT

CINDY KLASSEN RECREATION COMPLEX
TENNIS COURT REDEVELOPMENT

DISTRIBUTION / CONTROL ENCLOSURE
SINGLE LINE, CONTROL SCHEMATIC & DETAILS

CITY DRAWING NUMBER X000-00-00
SHEET 2 OF 2
REV E2 0

CONSULTANT DRAWING NO. E02
0265-388-00