


NOTES:

- 1. EXISTING STARTERS ARE IN MCC. NEW STARTERS TO BE MOUNTED AT LOCATION SHOWN.

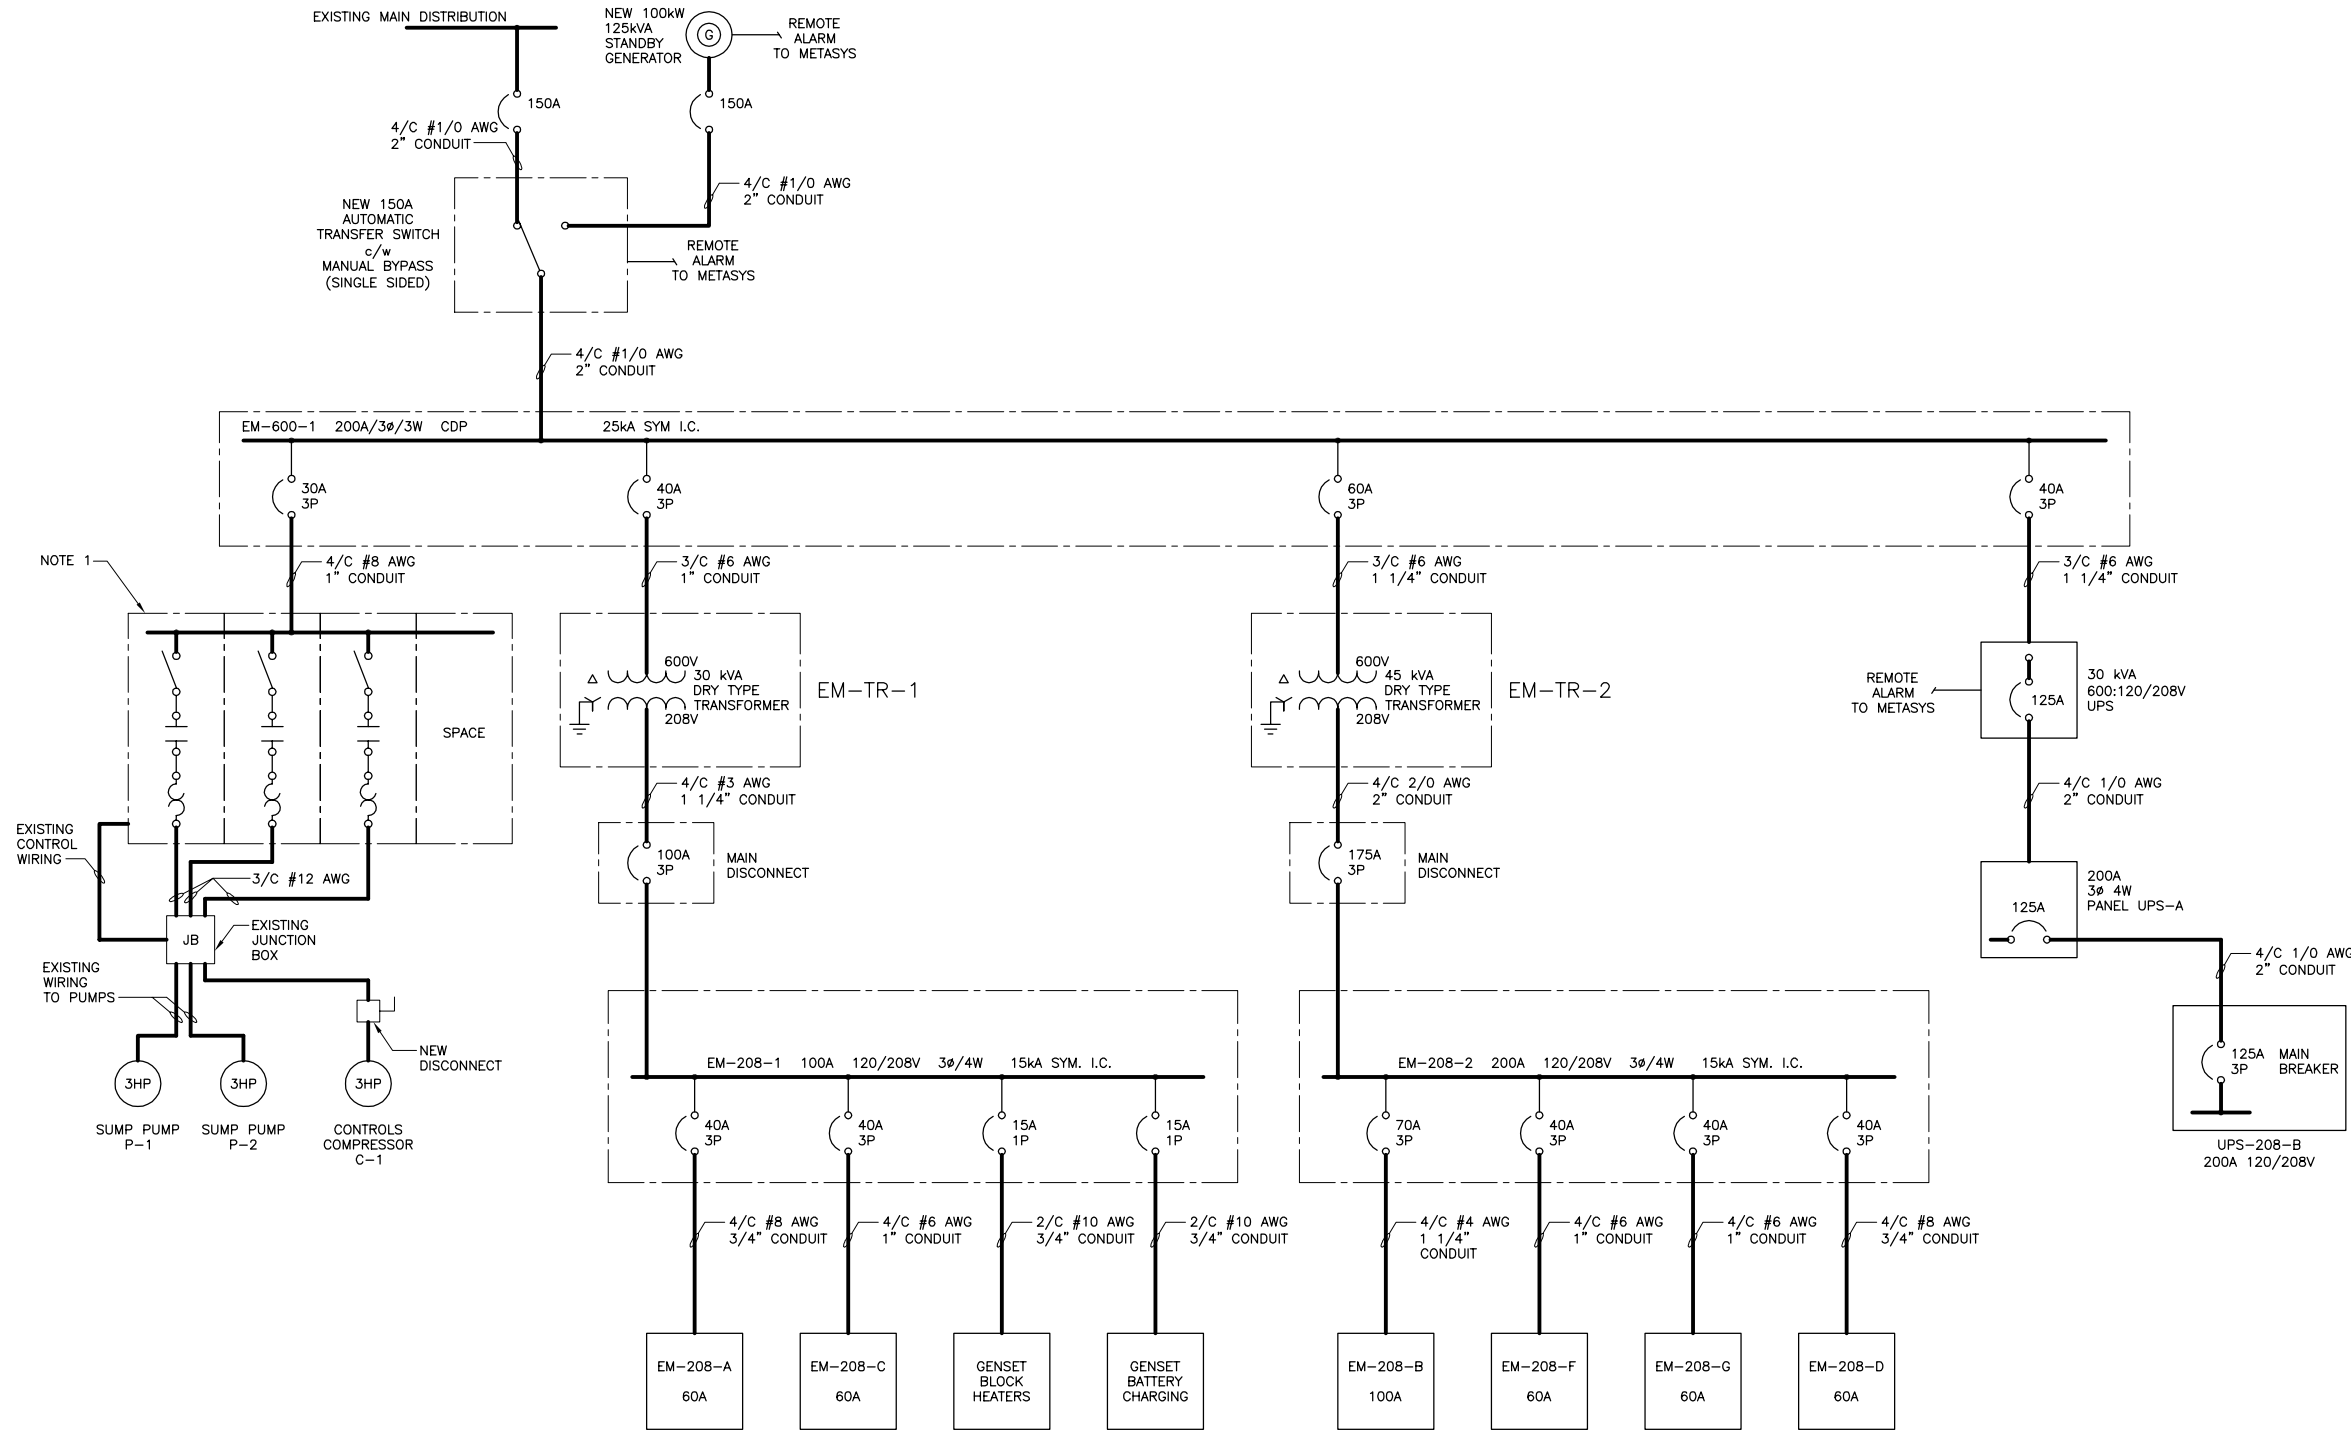

NOTE 1

**A** SINGLE LINE DIAGRAM  
 SCALE: N.T.S.

0	23/10/06	ISSUED FOR TENDER	
NO.	D / M / Y	DESCRIPTION	BY

REVISIONS / ISSUE	
A	SECTION LETTER OR DETAIL NUMBER
B	DRAWING WHERE SECTION OR DETAIL IS DRAWN
A	OR DRAWING WHERE SECTION OR DETAIL WAS INDICATED
-	SECTION OR DETAIL SHOWN ON SAME DRAWING

**KGS GROUP** CONSULTING ENGINEERS & PROJECT MANAGERS  
 WINNIPEG (204) 896-1209  
 THUNDER BAY (807) 345-2233

CLIENT: **CITY OF WINNIPEG**  
 PUBLIC WORKS DEPARTMENT

PROJECT: **INSTALLATION OF EMERGENCY GENERATOR AT PAN-AM POOL - 25 POSEIDON BAY TENDER No. 663-2006**

DWG. DESCRIPTION: **ELECTRICAL SINGLE LINE DIAGRAM**

ENG. STAMP	DESIGNED: J.W.	DRAWN: B.G.O.
APPROVED:	CHECKED:	CHECKED:

SCALE: AS NOTED	DATE: OCT/2006
KGS DWG. NO. 06-0107-08	E5

CLIENT DWG. NO. 663-P-E05 REV: 0

