


FILE NAME:
DATE:
DESCRIPTION:
PROJECT No.:
ADDRESS:

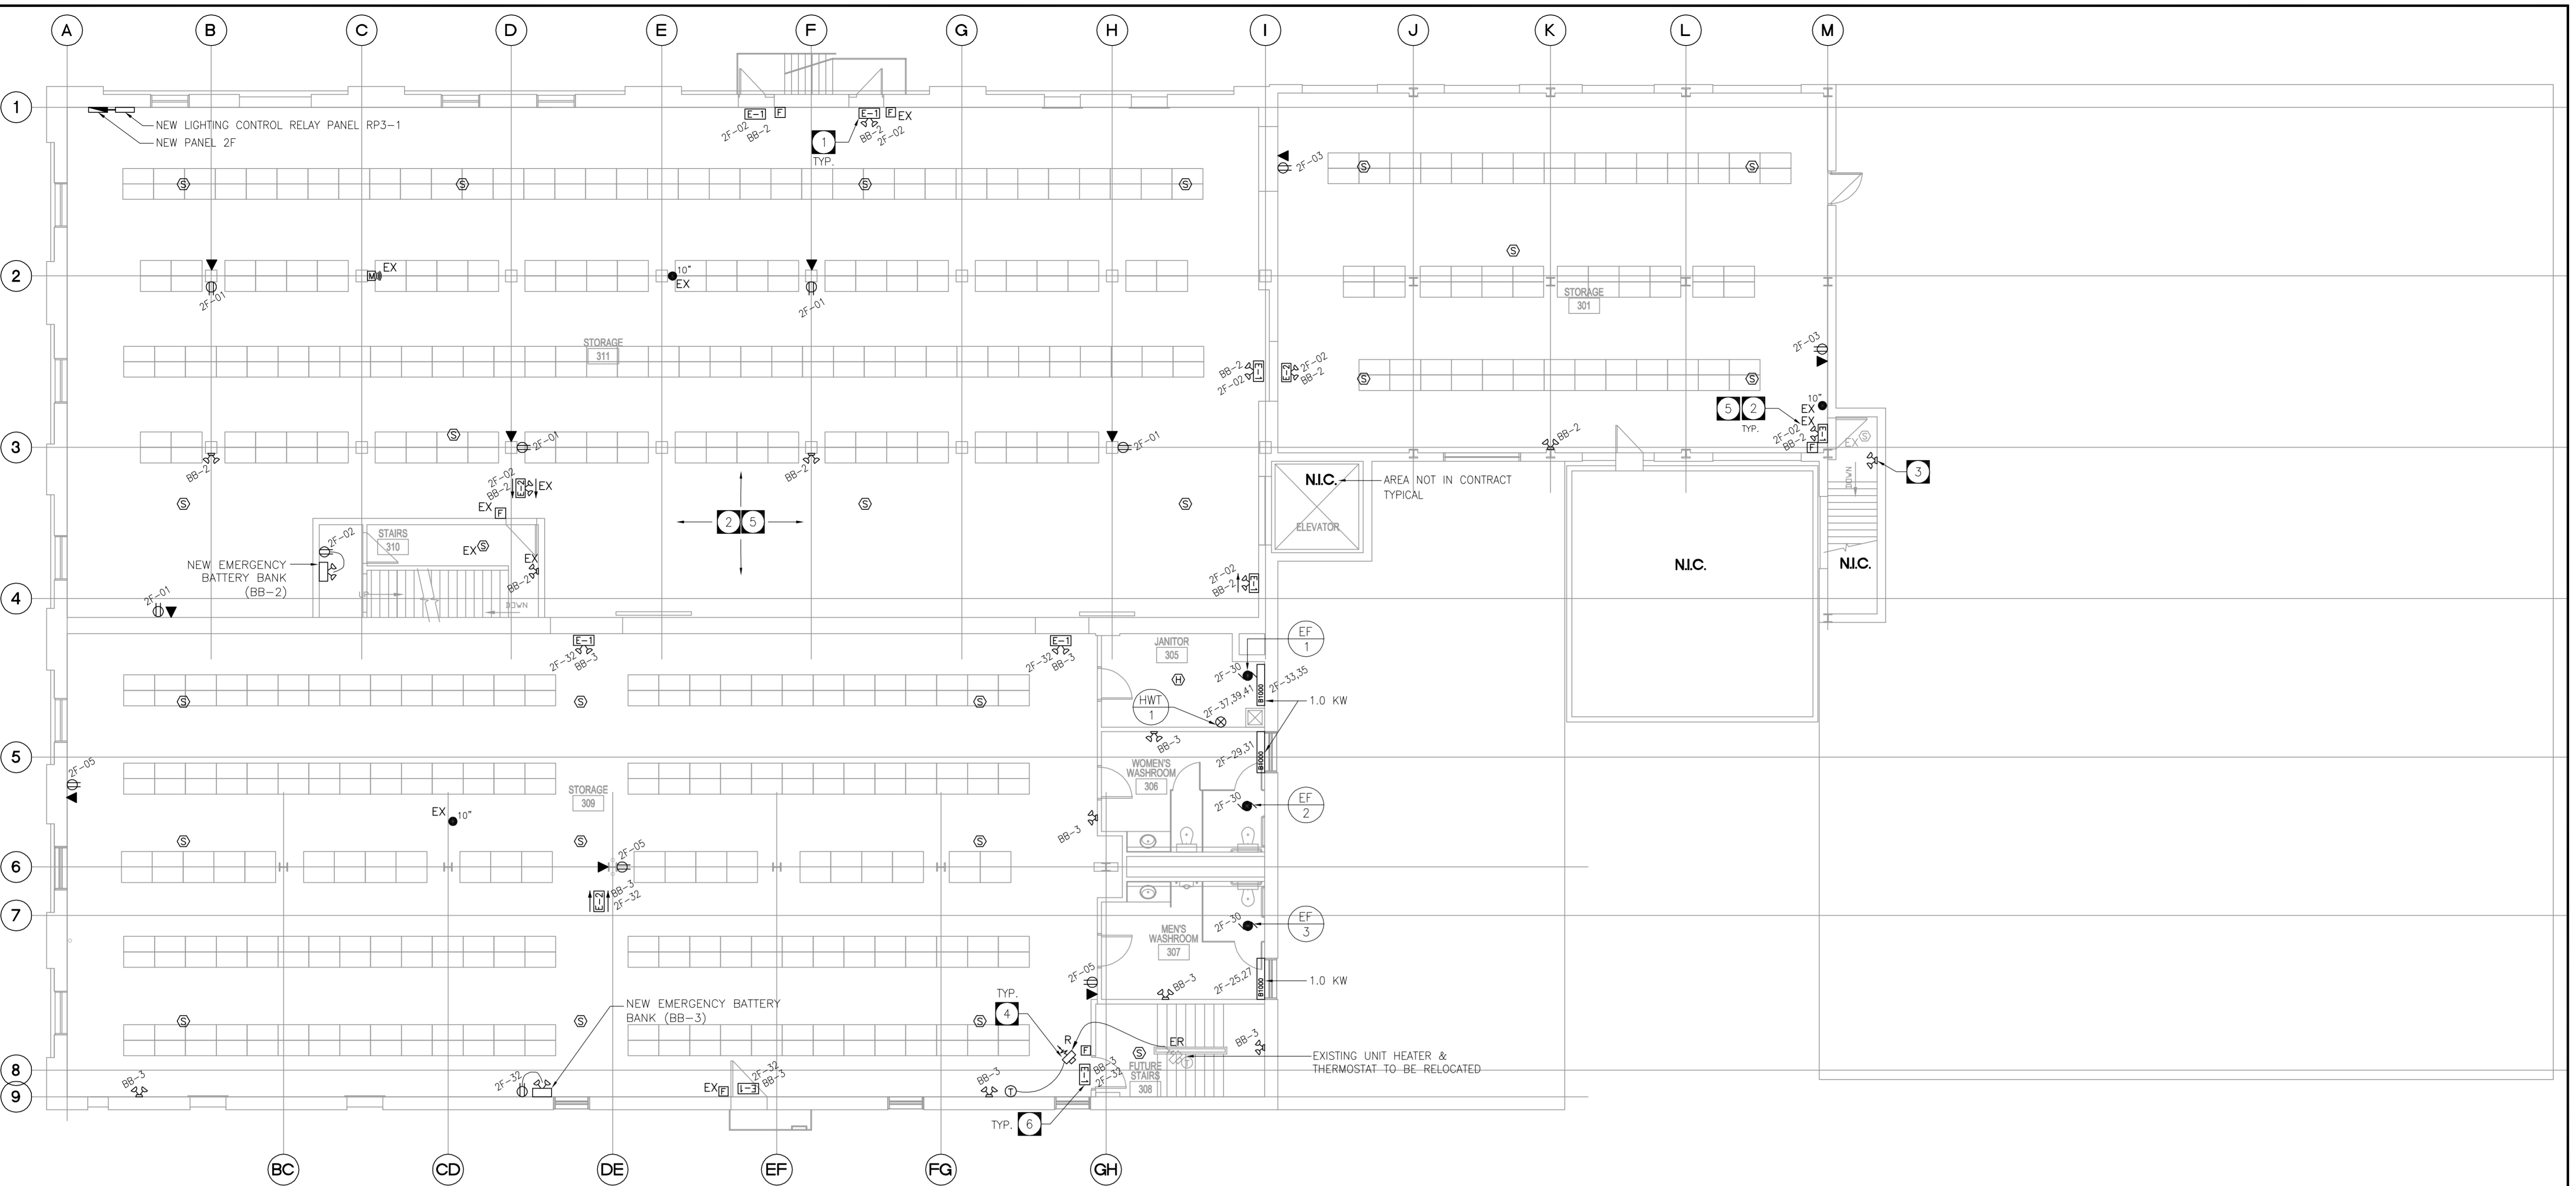

POWER + SYSTEM LAYOUT - 3RD FLOOR PLAN
SCALE: 1/8"=1'-0"

- DRAWING NOTES**
- 1 PROVIDE NEW EMERGENCY LIGHTING AND FIRE ALARM DEVICES AS INDICATED. PROVIDE MINIMUM SIZE 21mm CONDUIT FOR ALL NEW DEVICES.
 - 2 MAKE ALL PROVISION TO REPLACE ALL EXISTING EMERGENCY LIGHTING DEVICES. WHERE EXISTING DEVICES ARE CODE COMPLIANCE AND IN SATISFACTORY CONDITION FOR RE-USE, THEY MAY BE RE-USED AND WARRANTED AS NEW.
 - 3 ALL NEW EMERGENCY LIGHTING DEVICES AS INDICATED IN N.I.C. AREA ARE TO COMPLY WITH MANITOBA BUILDING CODE.
 - 4 REFER TO MECHANICAL DRAWING FOR EXACT LOCATION OF ALL MECHANICAL EQUIPMENT PRIOR TO ROUGH-IN.
 - 5 MAKE ALL PROVISION TO REWIRE ALL EXISTING EMERGENCY LIGHTING SYSTEM AND EXIT SIGNS TO NEW NIGHT LIGHT CIRCUIT ON PANEL 2F AS INDICATED.
 - 6 PROVIDE EMERGENCY LIGHTING AND FIRE ALARM DEVICES AS INDICATED IN THE FUTURE STAIRS 308 AREA FOR FUTURE USES.

ORIGINAL STAMPED BY: T. TONTHAT, P. ENG.
DATE: 2006.11.30

NO.	REVISION/DESCRIPTION	DATE	BY
1	ISSUED FOR TENDER	11/30/06	TT
0	ISSUED FOR REVIEW	11/28/06	TT

DRAWN BY: LAN CHECKED BY: TT APPROVED BY: TT

CONSULTANT

These design documents are prepared solely for the use by the party with whom the design professional has entered into a contract and there are no representations of any kind made by the design professional to any party with whom the design professional has not entered into a contract. Any use of the drawing, disk, or electronic data without the expressed written permission of Tower Engineering Group is strictly prohibited. The contractor is responsible to verify all dimensions with conditions on the site and report discrepancies to Tower Engineering for adjustment. All prints to be returned.

TOWER ENGINEERING GROUP
208 - 897 CORYDON AVE. WINNEPEG, MB R3M 0W7
TEL: (204) 925-1150 FAX: (204) 925-1155
EMAIL: towereng@towereng.ca WEB: www.towereng.ca

TOWER PROJECT NO. :6179

CITY OF WINNIPEG
PLANNING, PROPERTY & DEVELOPMENT DEPARTMENT
CIVIC ACCOMMODATIONS DIVISION
300 - 65 GARRY ST. R3C 4K4

PROJECT
City of Winnipeg Surplus Storage Facility

311 ROSS AVENUE

SEALS

APEGM
Certificate of Authorization
Tower Engineering Group
No. 1918 Expiry: April 30, 2007

SHEET TITLE
**ELECTRICAL
POWER & SYSTEM LAYOUT -
THIRD FLOOR PLAN**

SCALE AS SHOWN PROJECT NO. SHEET NO. **E-2.1**