


LUMINAIRE SCHEDULE					
TYPE	MANUFACTURER	CAT. No.	LAMP	VOLTAGE	REMARKS
A	HUBBELL	NV2FG42AHG	42W FLUOR.	120V	NON-METALLIC CORROSION RESISTANT FIXTURE CLASS 1 DIV 2 WALL MOUNT FIXTURE W/CLEAR GLOBE AND GUARD AND WALL MOUNT FITTING
A1	HUBBELL	NV2FG42XHGG	42W FLUOR.	120V	NON-METALLIC CORROSION RESISTANT FIXTURE CLASS 1 DIV 2 CEILING MOUNT FIXTURE W/CLEAR GLOBE AND GUARD
B	CFI	SB248-120-SO-SB8G2-48	2 32W FLUOR.	120V	SURFACE MOUNT HEAVY DUTY STRIP FLUORESCENT C/W WIRE GUARD
C	CFI	VTS248-120-SO-VX	2 32W FLUOR.	120V	SURFACE MOUNT VAPOUR-TIGHT FLUORESCENT C/W POLYCARBONATE LENS
D	KEENE	313 070 MA-VP300 -PCB-120	1 - 70W MH	120V	EXTERIOR WALL PACK C/W INTEGRAL PHOTOCELL AND VANDAL RESISTANT LENS & WIRE GUARD

- NOTE**
1. FIXTURE 'A' AND 'C' TO BE MOUNTED 2100mm FROM BOTTOM OF FIXTURE TO FINISHED FLOOR.
 2. FIXTURE 'B' TO BE MOUNTED ON PENDANT SUSPENDED UNISTRUT AT 2800mm AFF.
 3. ALL FIXTURES TO COME COMPLETE WITH LAMPS.

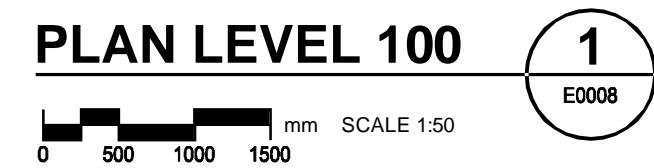

QL	RS	LK	BM	SS
DRN	CHK	DES	ENG	IDR
UMA REVIEW				

B.M. ELEV.	FIELD BOOK #:	UMA AECOM		ENGINEER'S SEAL
POSTED TO LBIS		© 2008 UMA ENGINEERING LTD. ALL RIGHTS RESERVED.		ISSUE / REVISION D ISSUED FOR BID WAS SEALED BY B.L. MOORE AND DATED 07/12/14
		DESIGNED BY: BM/LK	CHECKED BY: -----	
		DRAWN BY: QL	APPROVED BY: -	
C ISSUED FOR ADDENDUM 3	08/01/23	QL	HOR. SCALE AS NOTED	
B ISSUED FOR BID	07/12/14	LJV	VERTICAL AS NOTED	
A ISSUED FOR 100% REVIEW	07/11/09	SCK	DATE ----- DATE	
NO. REVISIONS	DATE	BY	FILENAME: D265-202-02_02-E-0101_RX.dwg	

THE CITY OF WINNIPEG
WATER AND WASTE DEPARTMENT

PERIMETER ROAD PUMPING STATION UPGRADES
Contract B - Building Upgrades

Electrical - Lighting Layout
LEVEL 100 FLOOR PLAN

CITY DRAWING NUMBER	SHEET	REV.	SIZE
1-0111L-E0007	001	C	D