



PLT: 08/01/24 10:59:08 AM

PLOT: 08/01/24 10:59:08 AM

UMA FILE NAME: D265-202-02_E-0401_RX.dwg Saved By: dll

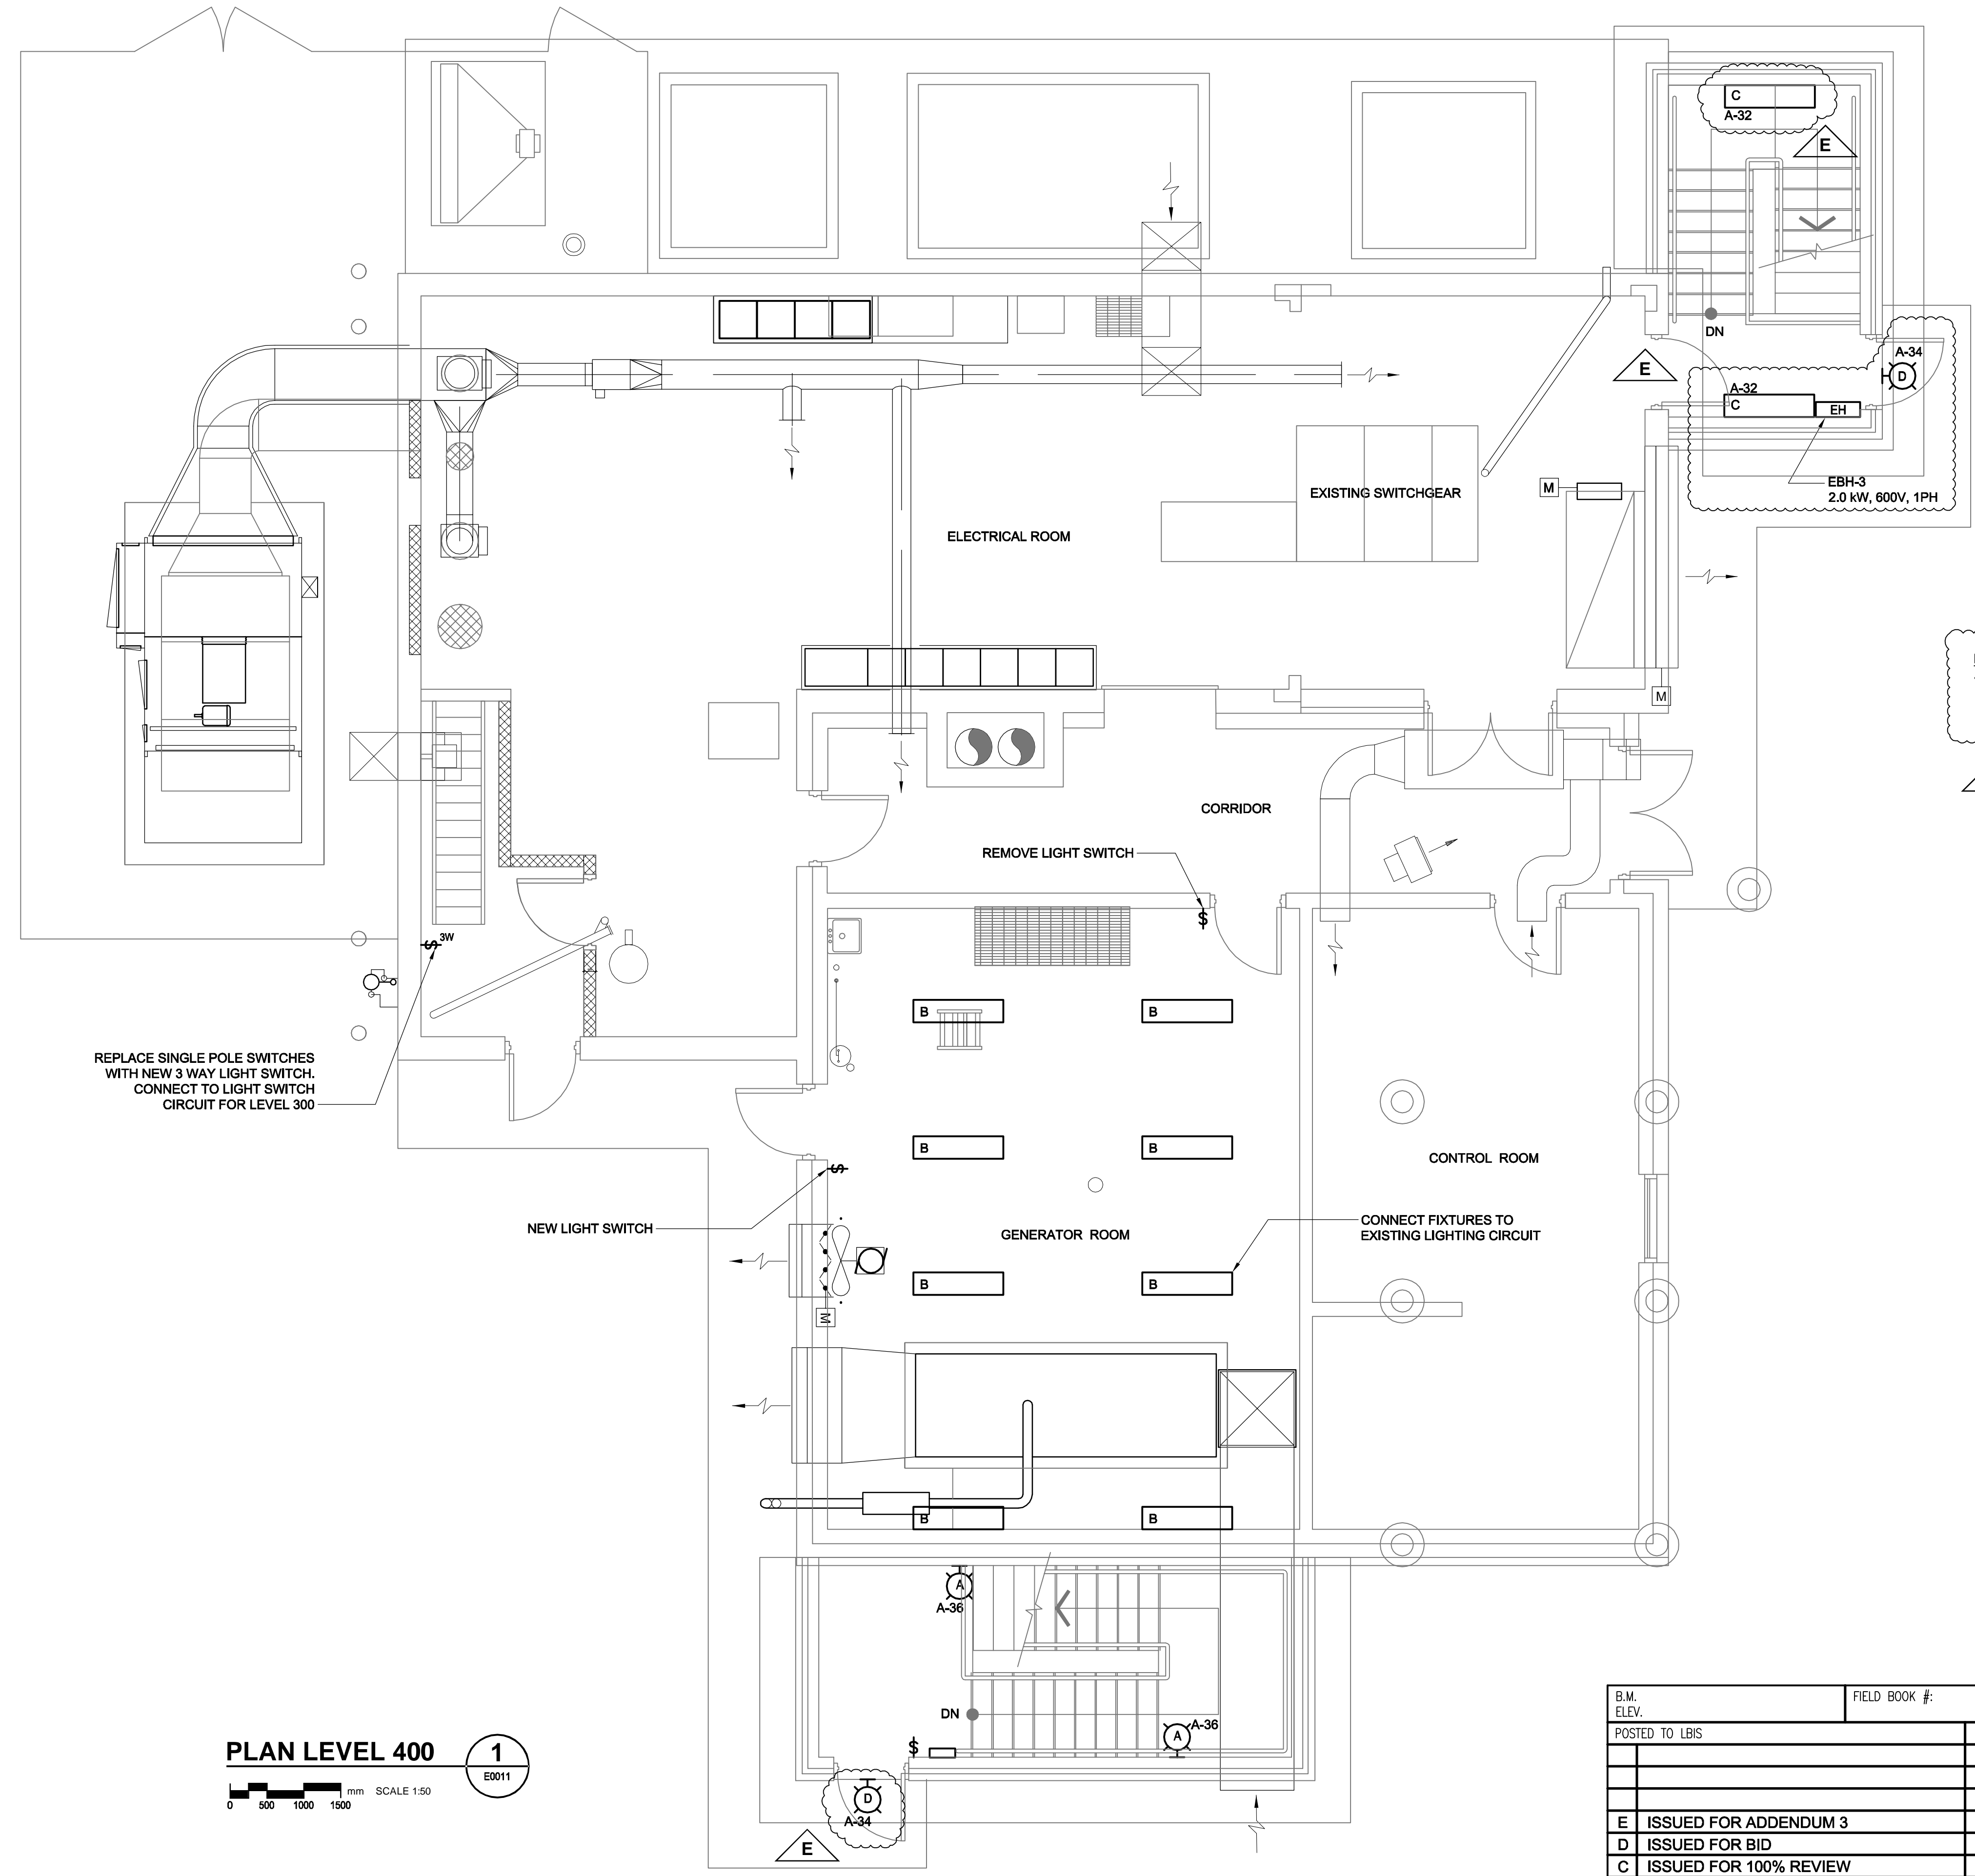

 NOTES:
 1. CONVECTION HEATERS EBH-1, EBH-2 AND EBH-3 SHALL BE CALORITECH MODEL XB2-420T2D C/W INTEGRAL THERMOSTAT AND CONTROL.




REPLACE SINGLE POLE SWITCHES WITH NEW 3 WAY LIGHT SWITCH. CONNECT TO LIGHT SWITCH CIRCUIT FOR LEVEL 300


NEW LIGHT SWITCH

REMOVE LIGHT SWITCH

CONNECT FIXTURES TO EXISTING LIGHTING CIRCUIT

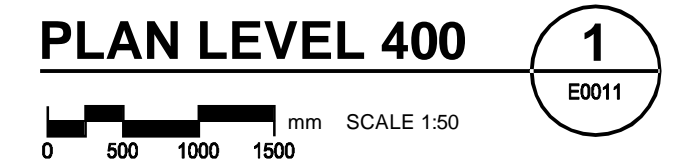

PLAN LEVEL 400

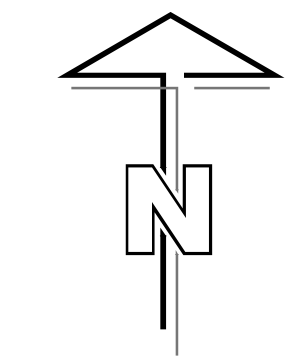

APEGM
 Certificate of Authorization
 UMA Engineering Ltd. (MB)
 No. 256 Date: 07/12/14

QL	RS	LK	BM	SS
DRN	CHK	DES	ENG	IDR
UMA REVIEW				

B.M. ELEV.	FIELD BOOK #:	UMA AECOM	
POSTED TO LBIS		DESIGNED BY: BM/LK	CHECKED BY: -----
		DRAWN BY: SCK	APPROVED BY: --
E ISSUED FOR ADDENDUM 3	08/01/23	QL	
D ISSUED FOR BID	07/12/14	LJV	
C ISSUED FOR 100% REVIEW	07/11/09	SCK	
B ISSUED FOR ZONING	07/08/21	SCK	
A ISSUED FOR 80% REVIEW	07/06/18	SCK	
NO. REVISIONS	DATE	BY	FILENAME: D265-202-02_E-0401_RX.dwg

© 2009 UMA ENGINEERING LTD. ALL RIGHTS RESERVED.	
HOR. SCALE AS NOTED	RELEASED FOR CONSTRUCTION
VERTICAL AS NOTED	
DATE 07/05/09	DATE

ENGINEER'S SEAL
 ISSUE / REVISION D
 ISSUED FOR BID
 WAS SEALED BY
 B.L. MOORE
 AND DATED
 07/12/14

THE CITY OF WINNIPEG
 WATER AND WASTE DEPARTMENT
PERIMETER ROAD PUMPING STATION UPGRADES
 Contract B - Building Upgrades
 Electrical - Lighting Layout
 LEVEL 400 FLOOR PLAN
 CITY DRAWING NUMBER: **1-01111L-E0010** SHEET: **001** REV: **E** SIZE: **D**