


1 FLOOR PLAN
Scale: 1:25

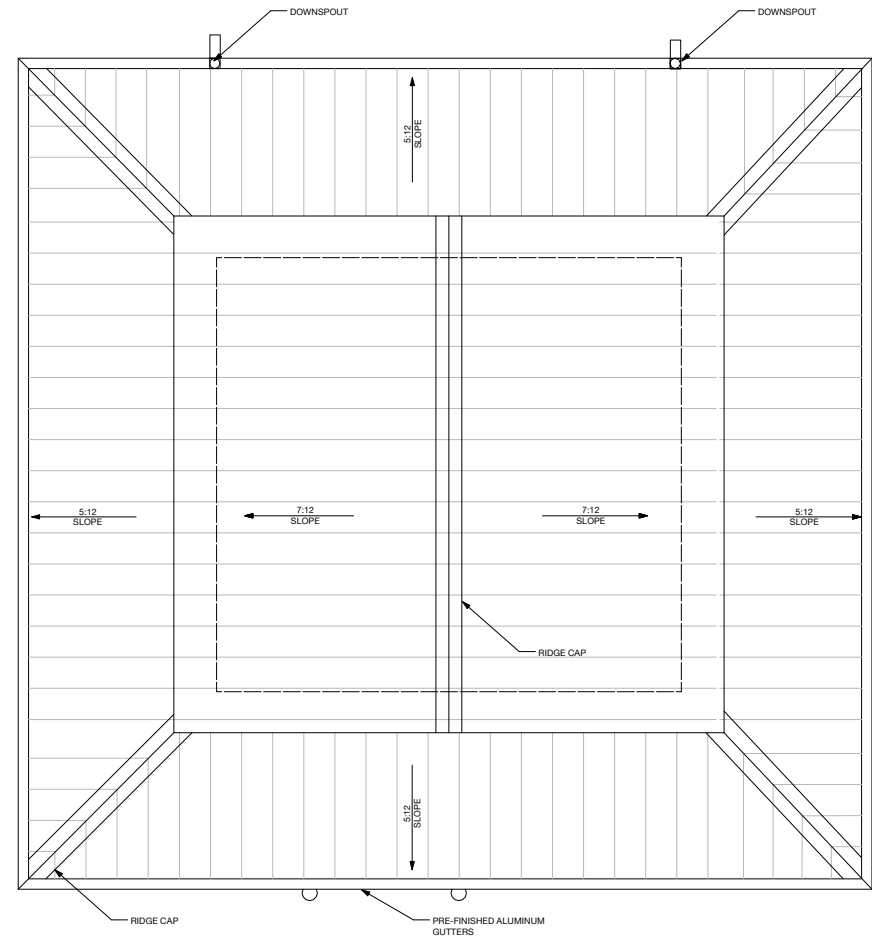


2 ROOF PLAN
Scale: 1:25

A = DETAIL/SECTION No.
B = DRAWING WHERE SHOWN
C = DRAWING WHERE TAKEN

NO.	REVISIONS	DATE	BY
1	ISSUED FOR ADDENDUM NO. 3	21.04.09	EN

SYVERSON MONTEYNE ARCHITECTURE			
www.sm-arc.com p-204 947 3156 f-204 947 3161 807-70 Arthur St Winnipeg, MB			
DESIGNED BY	DSy	CHECKED BY	EN
DRAWN BY	CWS AP	APPROVED BY	DSy
HOR. SCALE	AS SHOWN	RELEASED FOR CONSTRUCTION	signed by K. Zurek
DATE	2008 12 11	DATE	2009 03 27

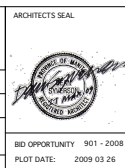

 THE CITY OF WINNIPEG WATER AND WASTE DEPARTMENT		CONSULTANT DRAWING NUMBER A2.0
REHABILITATION OF BOURNAIS WASTEWATER PUMPING STATION		SHEET 2 OF 14
MAIN FLOOR AND ROOF PLANS		CITY DRAWING NUMBER 8747