

CITY OF WINNIPEG 510 MAIN ST. EMERGENCY DISTRIBUTION UPGRADE PHASE 1

DRAWING LIST

G0.1 SITE PLAN AND DRAWING LIST

ARCHITECTURAL

A1.0 SUB-BASEMENT FLOOR PLAN

A2.0 SEVENTH (PENTHOUSE) AND INTERMEDIATE FLOOR PLAN

A3.0 SPECIFICATION, SCHEDULE AND NOTES

STRUCTURAL

S1.0 PARTIAL 7TH FLOOR FRAMING PLAN, PARTIAL ROOF FRAMING PLAN AND DETAILS/NOTES

MECHANICAL

M1.0 MECHANICAL 7TH FLOOR PROPOSED LOCATION FOR NEW EQUIPMENT

M2.0 SUB-BASEMENT MECHANICAL ROOM PROPOSED LOCATION FOR NEW EQUIPMENT

M3.0 SUB-BASEMENT AND BASEMENT PLANS PROPOSED LOCATION FOR FUEL OIL PIPING RUN

ELECTRICAL

E0.1 ELECTRICAL SYMBOL LEGEND


E1.0 SITE PLAN AND BASEMENT LEVEL PLAN

E2.0 ELECTRICAL 7TH FLOOR LOCATION FOR NEW EQUIPMENT

E3.0 NEW EMERGENCY GENERATOR SINGLE LINE SCHEMATIC OF NEW EMERGENCY SYSTEM UPGRADE

E3.1 NEW SINGLE LINE DISTRIBUTION OF NEW EMERGENCY SYSTEM UPGRADE

E3.2 EXISTING EMERGENCY GENERATOR SINGLE LINE SCHEMATIC

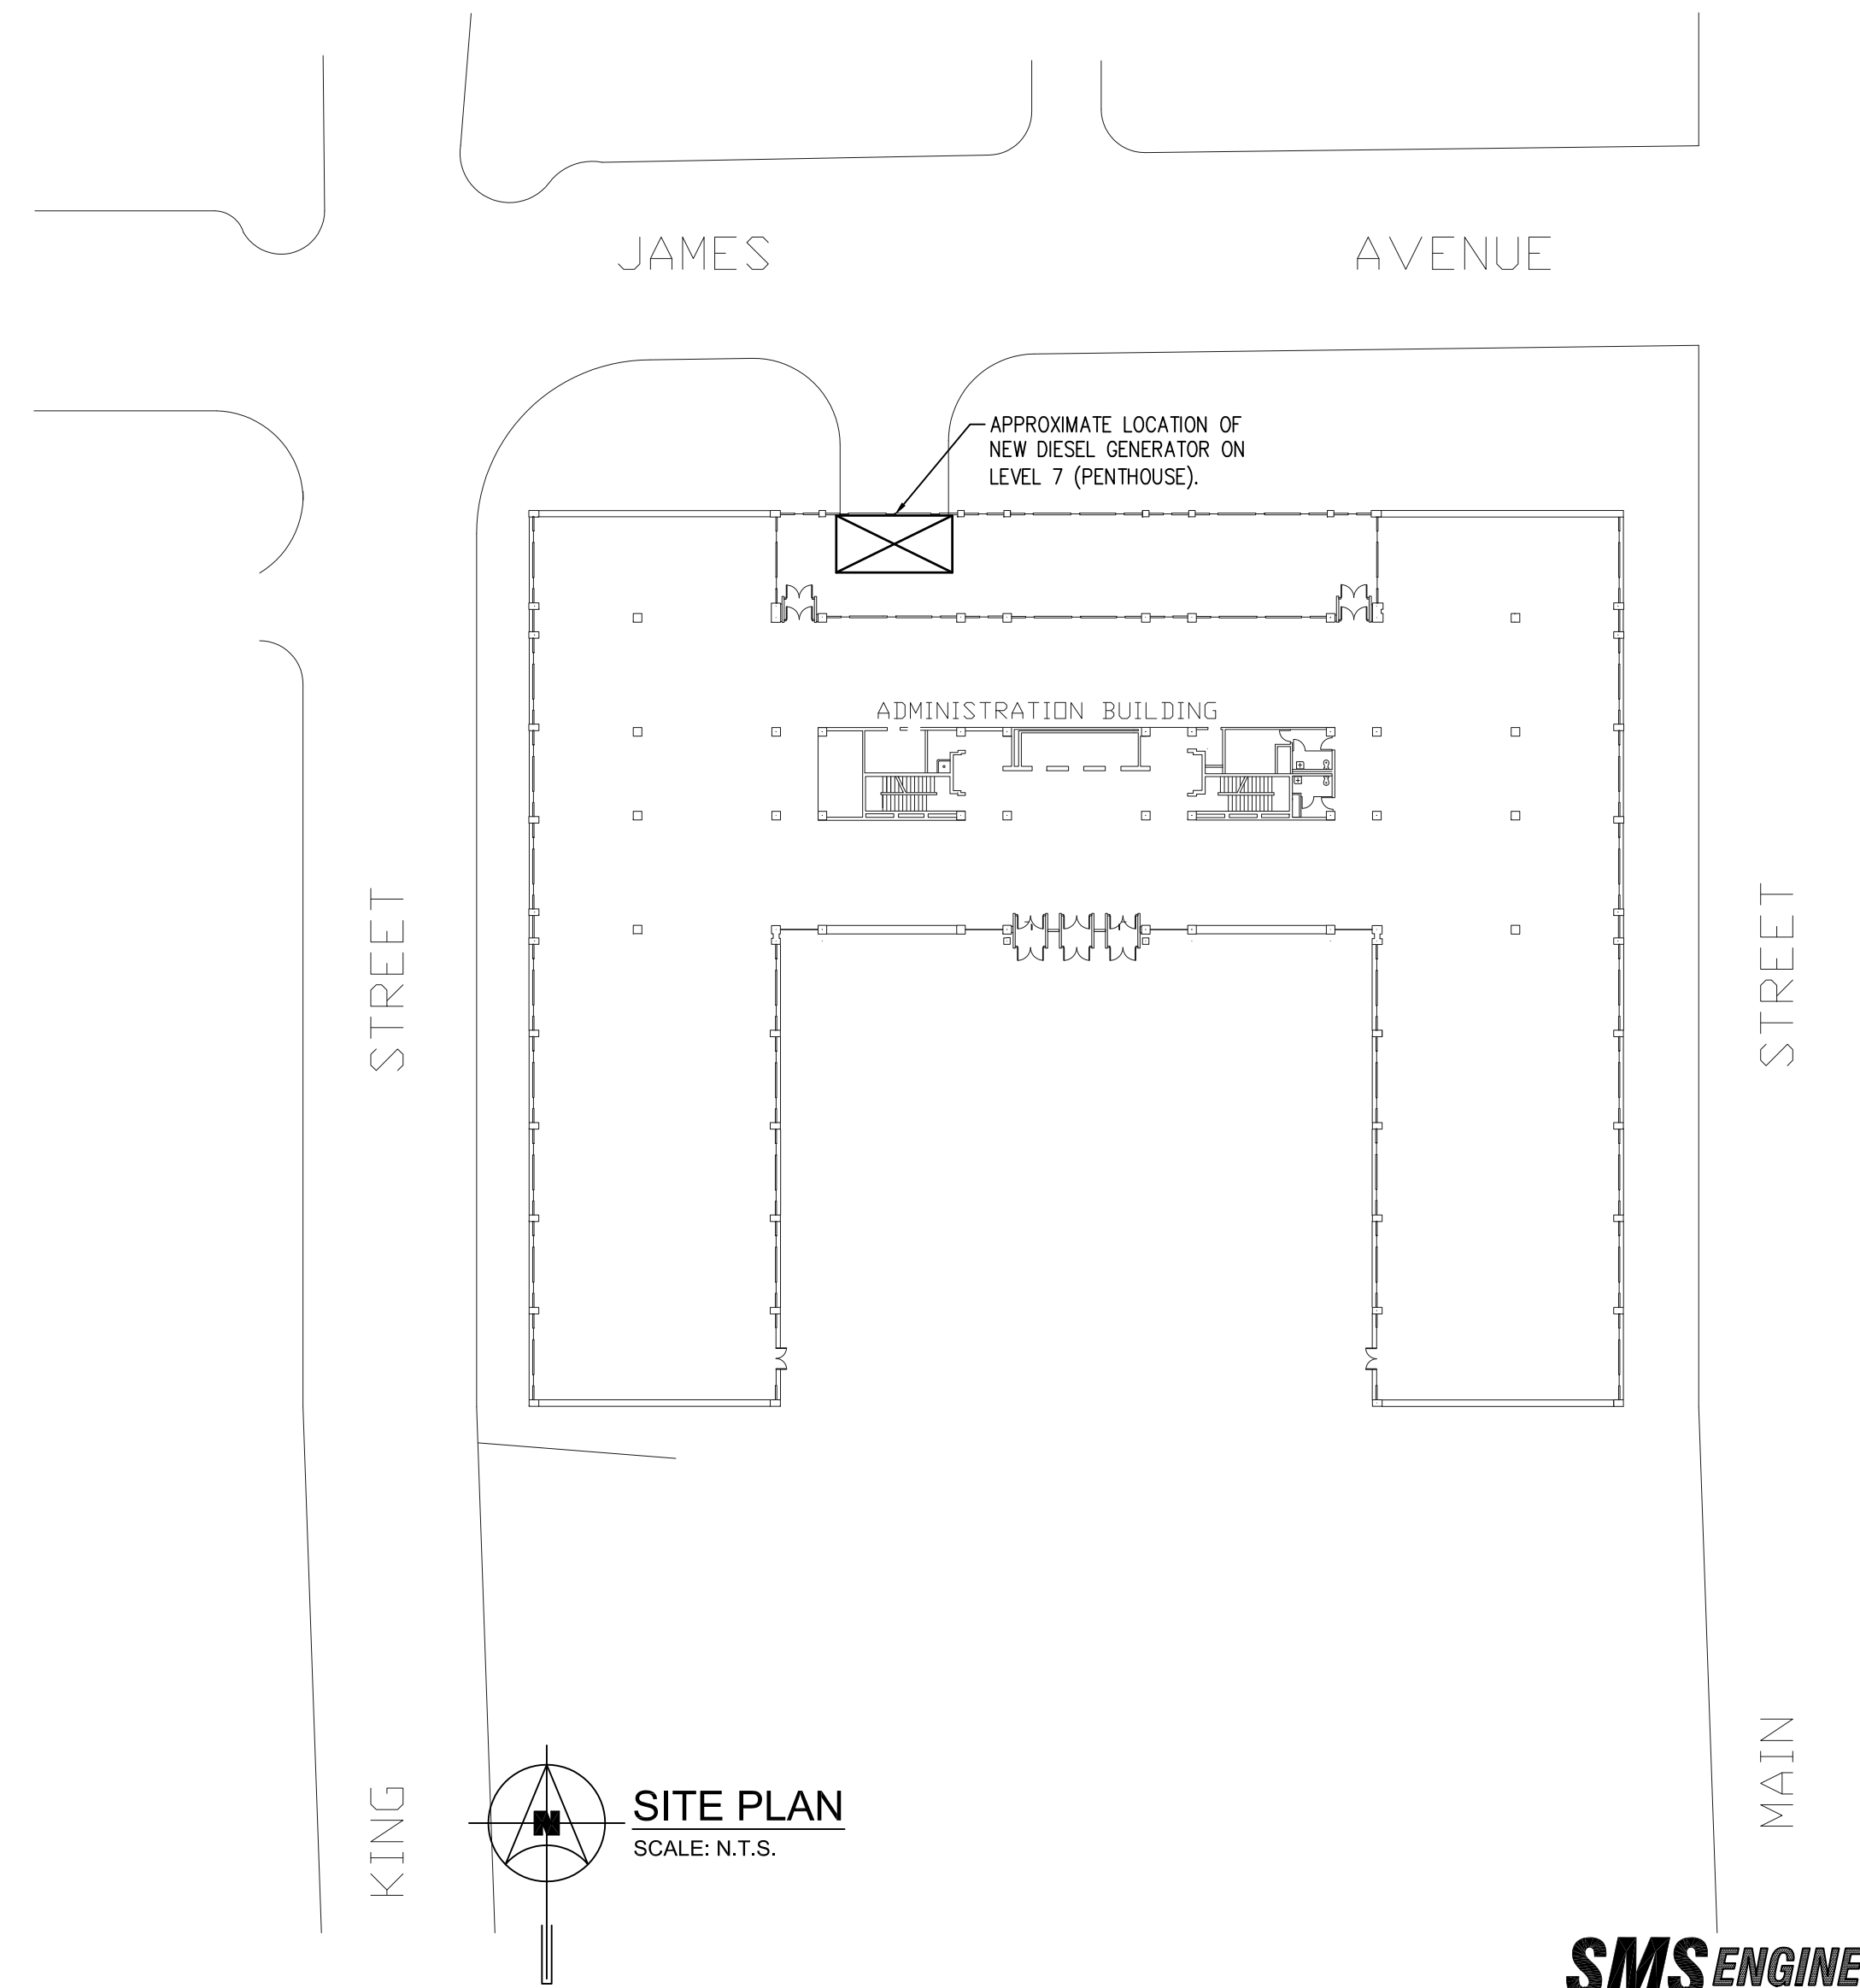

NOTES :

PRIME CONSULTANT



SMS Engineering Ltd. Consulting Engineers
770 Bradford Street Winnipeg MB Canada R3H 0N3
Telephone 204.775.0291 Fax 204.772.2153
sms@smseng.com

ARCHITECTURAL CONSULTANT



STRUCTURAL CONSULTANT



MECHANICAL CONSULTANT



SMS Engineering Ltd. Consulting Engineers
770 Bradford Street Winnipeg MB Canada R3H 0N3
Telephone 204.775.0291 Fax 204.772.2153
sms@smseng.com

ELECTRICAL CONSULTANT



SMS Engineering Ltd. Consulting Engineers
770 Bradford Street Winnipeg MB Canada R3H 0N3
Telephone 204.775.0291 Fax 204.772.2153
sms@smseng.com

SMS ENGINEERING
SMS Engineering Ltd. Consulting Engineers
770 Bradford Street Winnipeg MB Canada R3H 0N3
Telephone 204.775.0291 Fax 204.772.2153
sms@smseng.com

2.	ISSUED FOR ADDENDUM NO. 2	CB	09.07.27
1.	ISSUED FOR BID OPPORTUNITY	CB	09.06.19

NO.	REVISION/DESCRIPTION	BY	DATE
SEALS			



DRAWN BY	KAM	CHECKED BY	CR	APPROVED CH
DATE	2009.04.17	USER APPROVAL		

CITY OF WINNIPEG
PLANNING, PROPERTY &
DEVELOPMENT DEPARTMENT
CIVIC ACCOMMODATIONS DIVISION
300 - 65 GARRY ST. R3C 4K4

PROJECT
CITY OF WINNIPEG 510 MAIN ST.
EMERGENCY DISTRIBUTION UPGRADE
PHASE 1

SHEET TITLE
SITE PLAN & DRAWING LIST

SCALE	PROJECT NO.	SHEET NO.
NONE	07-232-01	G0.1