


A PARKING SECTION
1:50H 1:25V

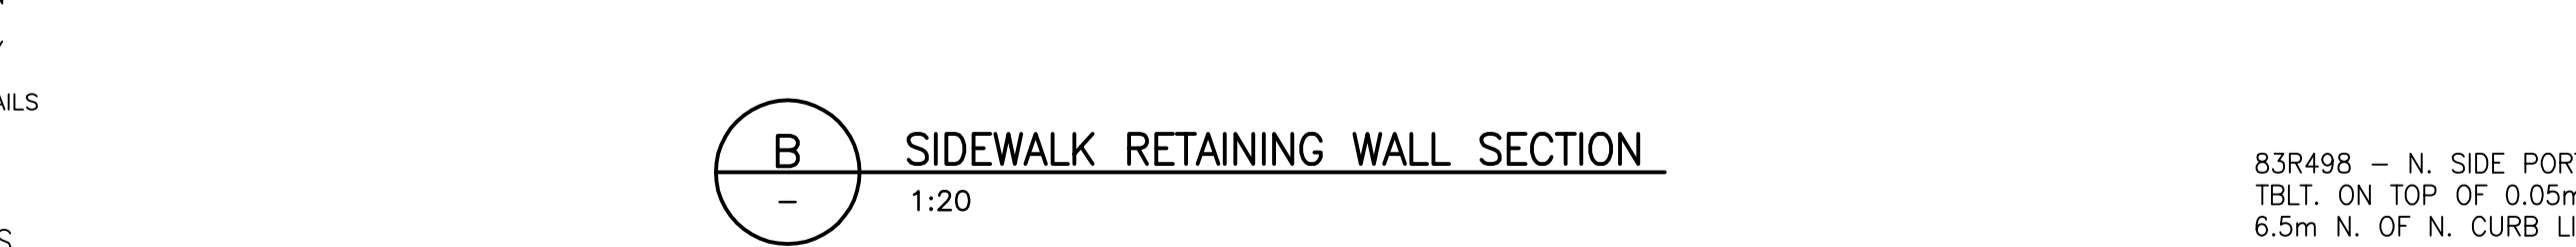

B SIDEWALK RETAINING WALL SECTION
1:20

WARNING

IF POWER EQUIPMENT OR EXPLOSIVES ARE TO BE USED FOR EXCAVATION ON THIS PROJECT THE CONTRACTOR MUST:
1) NOTIFY THE GAS COMPANY OF THE PROPOSED LOCATION OF EXCAVATION.
2) TAKE PRECAUTION TO AVOID DAMAGE TO GAS COMPANY INSTALLATIONS.
SEE PROVINCIAL REGULATION 140/92 FOR DETAILS

METRIC

WHOLE NUMBERS INDICATE MILLIMETRES
DECIMALIZED NUMBERS INDICATE METRES

83R498 - N. SIDE PORTAGE AVE. @ HARRIS BLVD., TBLT. ON TOP OF 0.05m DIA. X 2.4m IRON PIPE, 6.5m N. OF N. CURB LINE OF PORTAGE AVE., & 2.2m E. OF C.L. CONC. PAVT. OF HARRIS BLVD. PRODUCED FROM THE S.

EXISTING	LEGEND-PLAN	PROPOSED	EXISTING	LEGEND-PLAN	PROPOSED	EXISTING	LEGEND-PROFILE	PROPOSED
	WATERMAIN			HYDRO			WATERMAIN	
	HYDRANT			M.T.S.			HYDRANT, VALVE	
	VALVE			CONCRETE			LAND DRAINAGE SEWER	
	LAND DRAINAGE SEWER			ASPHALT			WASTE WATER SEWER	
	WASTE WATER SEWER			SIDEWALK			C PROFILE	
	MANHOLE			PROPERTY LINE			NORTH OR WEST GUTTER	
	CATCH BASIN			SURVEY BAR			SOUTH OR EAST GUTTER	
	CURB INLET			DITCH			NORTH OR WEST DITCH	
	JUNCTIONS			ELEVATION			SOUTH OR EAST DITCH	
	CULVERT			SIDEWALK RAMP			NORTH OR WEST DITCH	
	GAS						SOUTH OR EAST DITCH	

LOCATION APPROVED UNDERGROUND STRUCTURES

SUPV. U/G STRUCTURES COMMITTEE DATE

NOTE: LOCATION OF UNDERGROUND STRUCTURES AS SHOWN ARE BASED ON THE BEST INFORMATION AVAILABLE BUT NO GUARANTEE IS GIVEN THAT ALL EXISTING UTILITIES ARE SHOWN OR THAT THE GIVEN LOCATIONS ARE EXACT. CONFIRMATION OF EXISTENCE AND EXACT LOCATION OF ALL SERVICES MUST BE OBTAINED FROM THE INDIVIDUAL UTILITIES BEFORE PROCEEDING WITH CONSTRUCTION.

NO.	REVISIONS	DATE	BY
0	ISSUED FOR TENDER	11.12.15	V.M.M.

Stantec Consulting Ltd.
100-1355 Taylor Ave., Winnipeg, Manitoba
Tel 204-928-8840 Fax 204-284-4795

DESIGNED BY: V.M.M.
DRAWN BY: T.G.
HOR. SCALE: 1:150
VERTICAL: 1:10

CHECKED BY: V.M.M.
APPROVED BY: V.M.M.
RELEASED FOR CONSTRUCTION: _____
DATE: _____

DATE: 10.08.23

ENGINEER'S SEAL

CONSULTANT DRAWING NO. C-110

THE CITY OF WINNIPEG
PUBLIC WORKS DEPARTMENT
ENGINEERING DIVISION

STURGEON ROAD
BRIDGE REPLACEMENT
PORTAGE AVENUE TO HALLONQUIST DRIVE
PARKING

SHEET 73 OF 82
CAD FILE DRAWING NUMBER 31590c-110-767.dwg
CITY DRAWING NUMBER P-3331-II

APEGN
Certificate of Authorization
Stantec Consulting Ltd.
No. 1301 Date: _____

V:\137\action\1371590\winipeg\02_design\sheet\area\transportation\31590c-110-767.dwg
2011 September 20 2:28 p.m.