




File Name: P:\Projects\2011\11-0902-04_E11.0-Rev 1.dwg - Tab: E11.0 Plotted By: DDeroche 12/02/03 [Fri 2:45pm] 24x36 / PLOT SCALE: 1:1

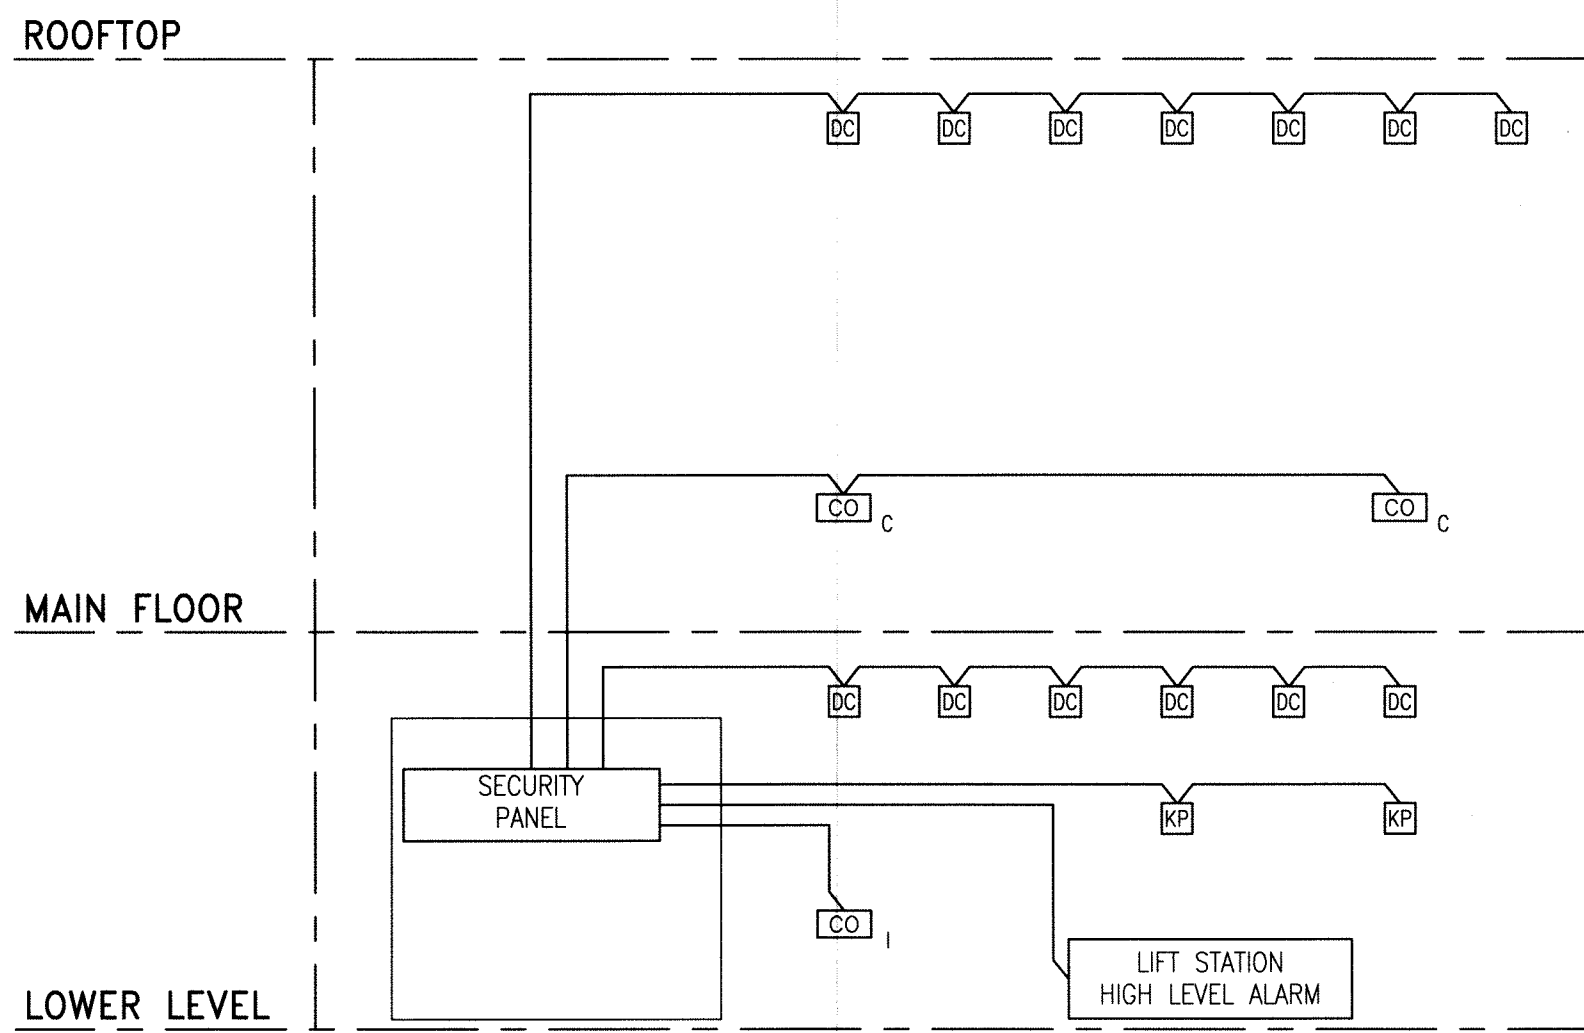


A SECURITY RISER DIAGRAM
SCALE: N.T.S.

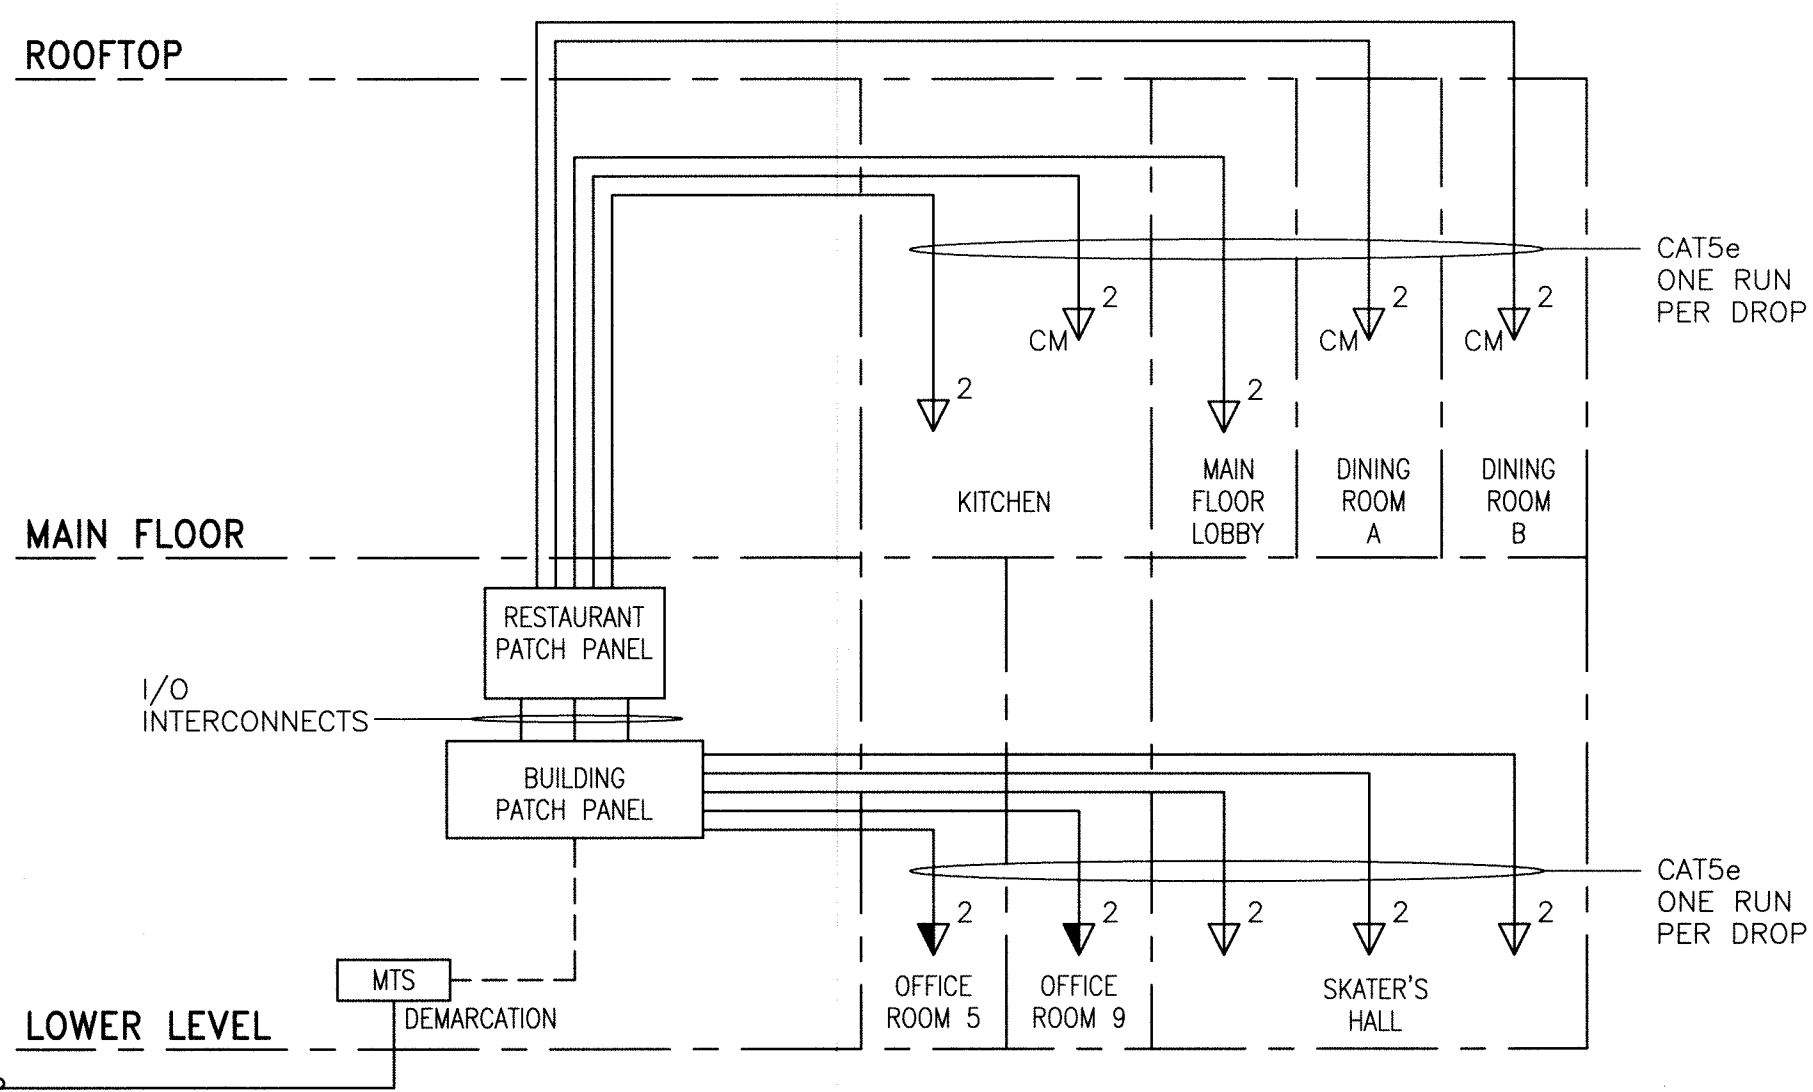


C VOICE/DATA STRUCTURED CABLE RISER DIAGRAM
SCALE: N.T.S.

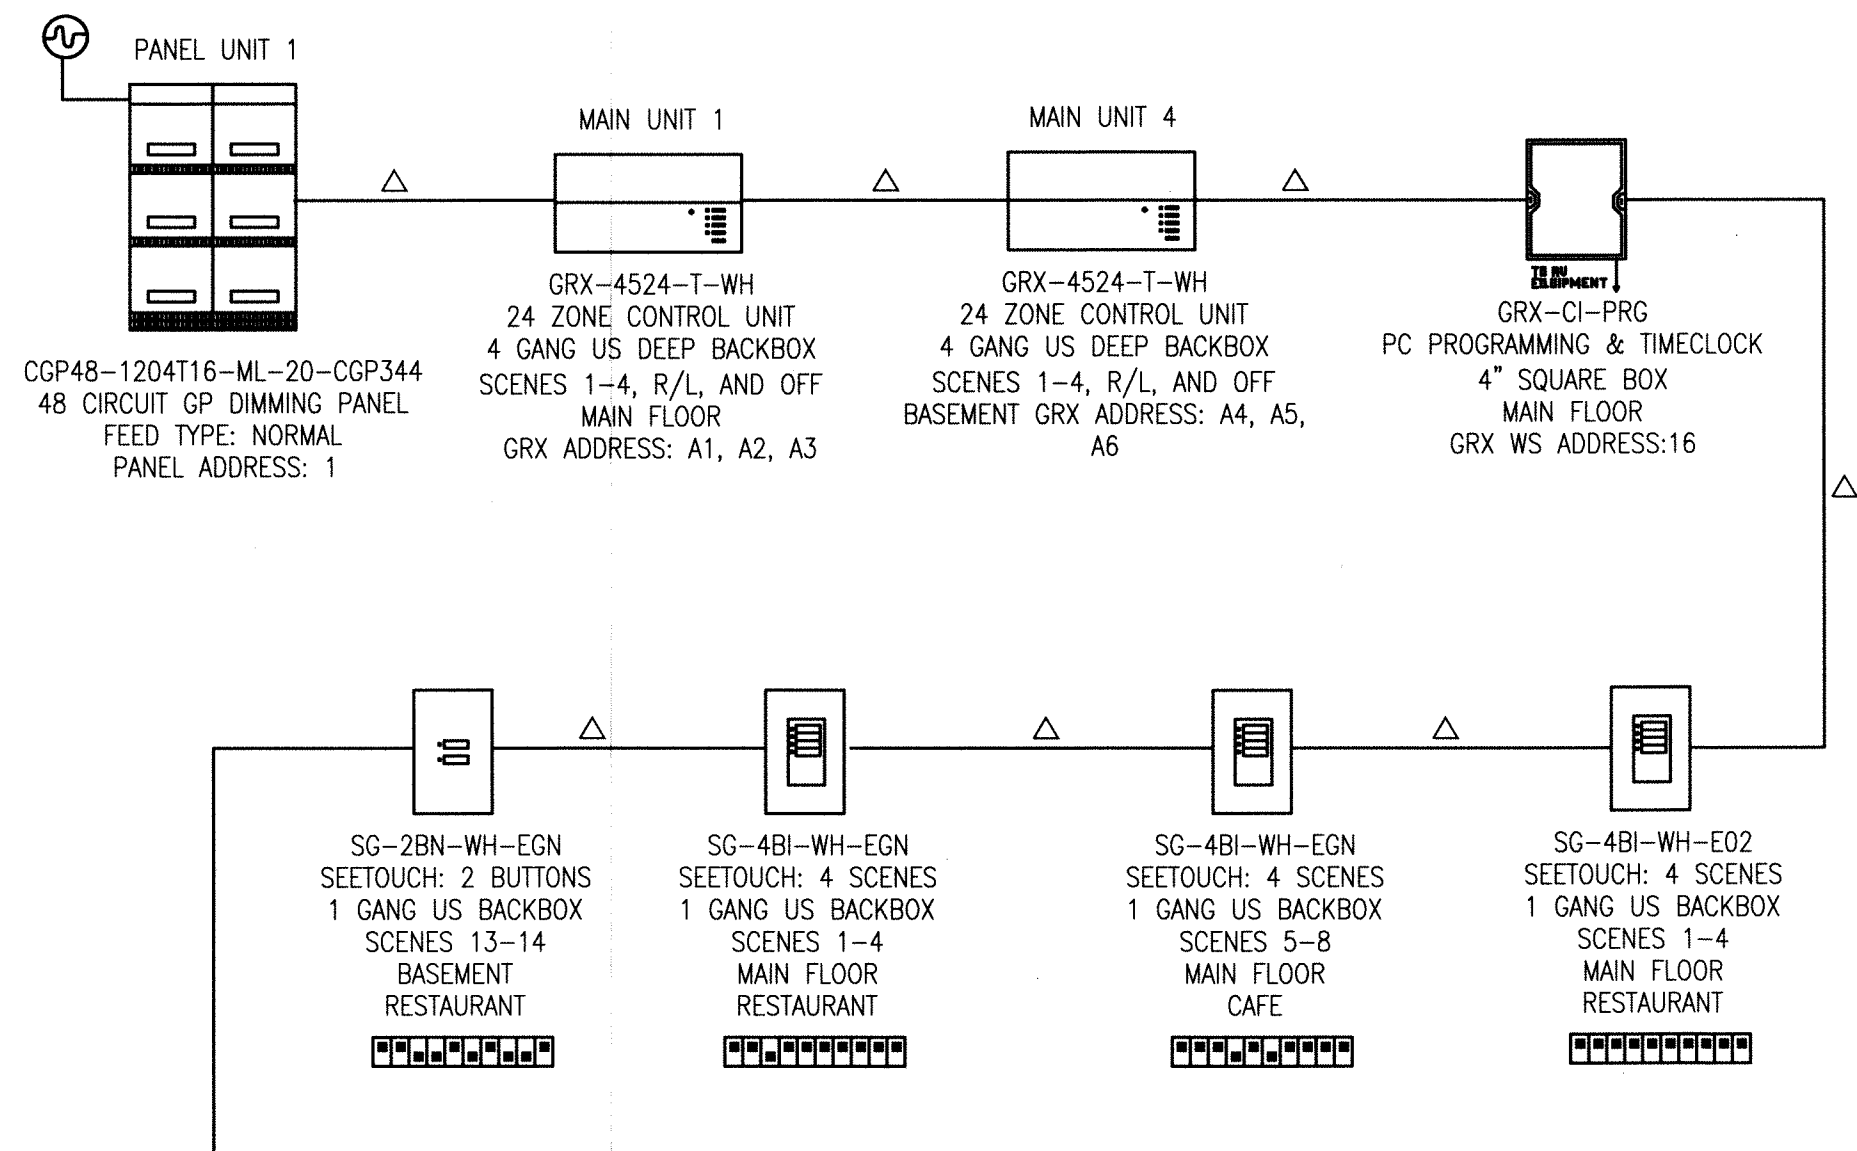


E LIGHTING CONTROLLER RISER DIAGRAM
SCALE: N.T.S.

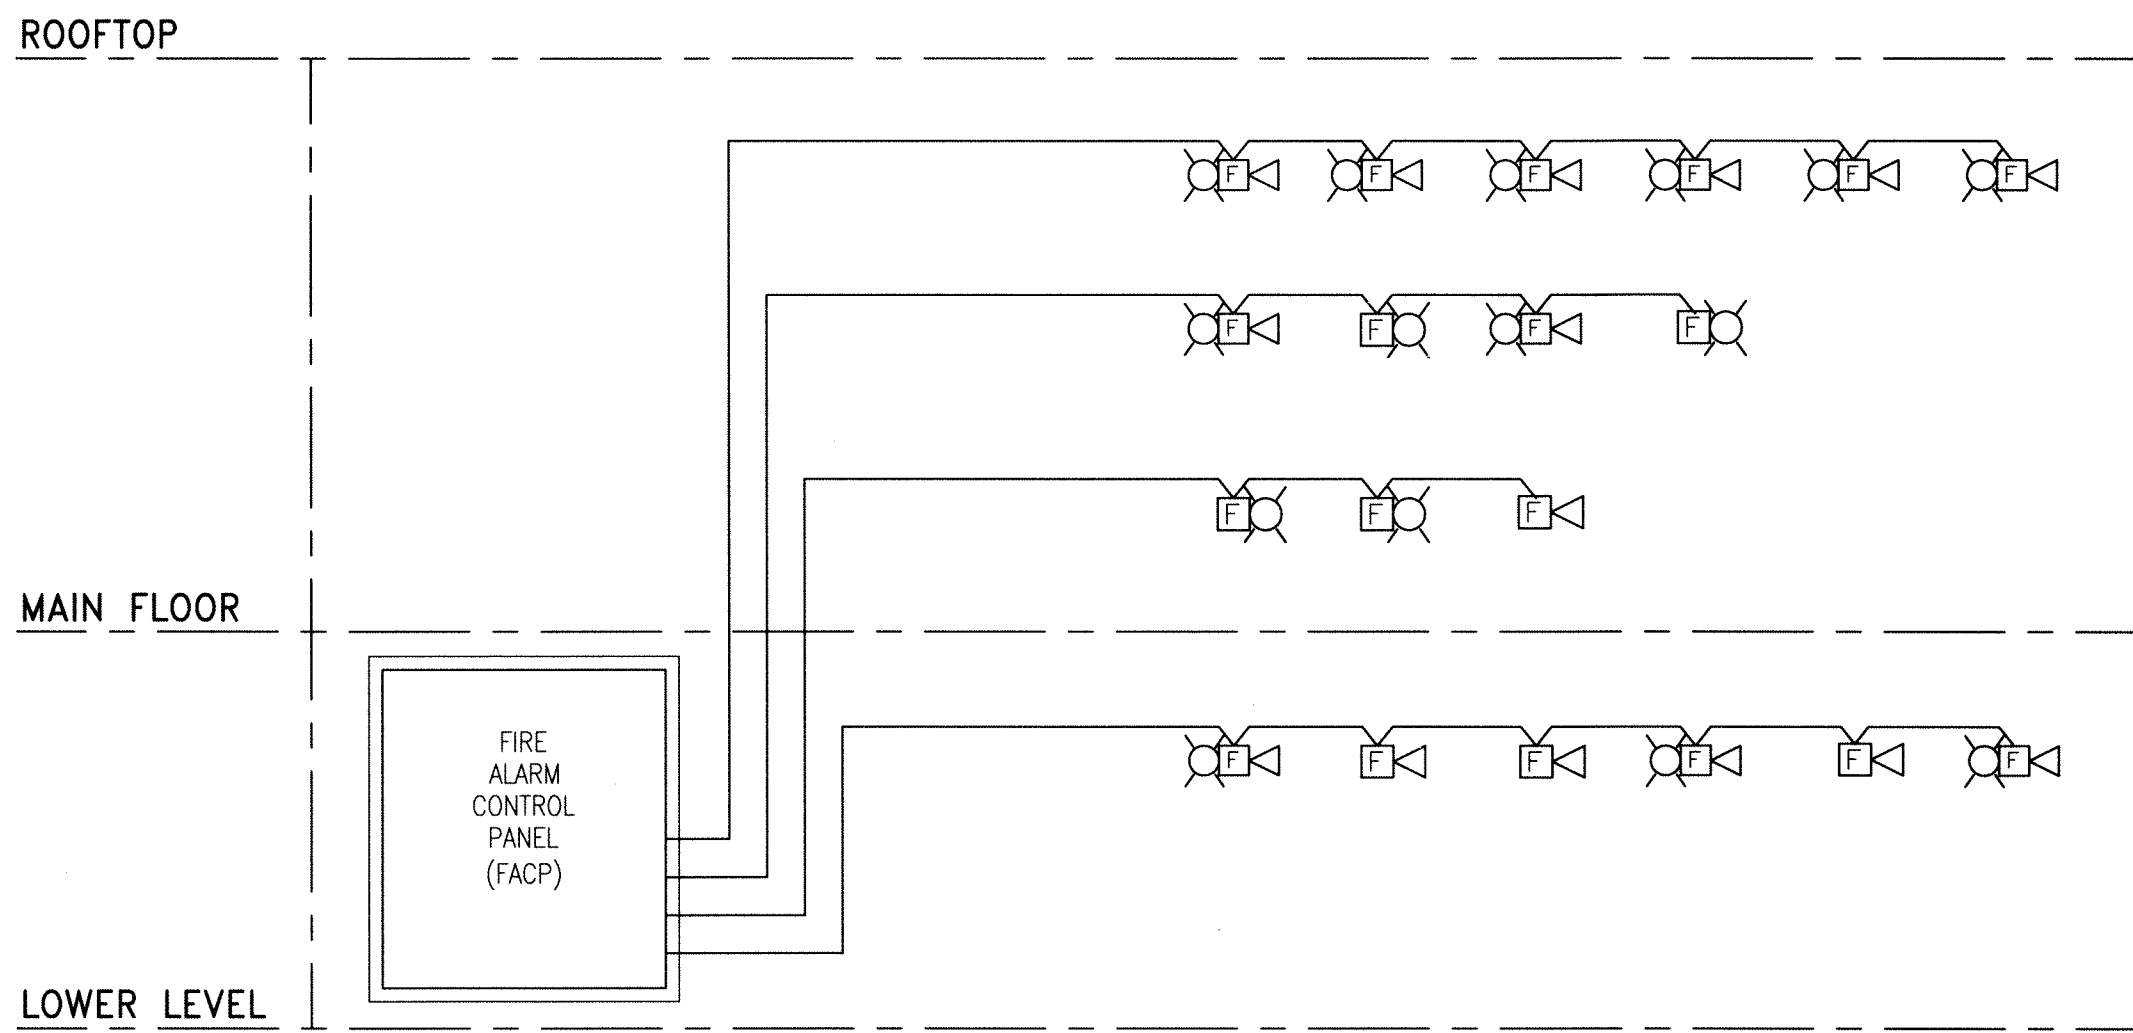

B FIRE ALARM AUDIBLE & VISIBLE DEVICE LOOPS
SCALE: N.T.S.

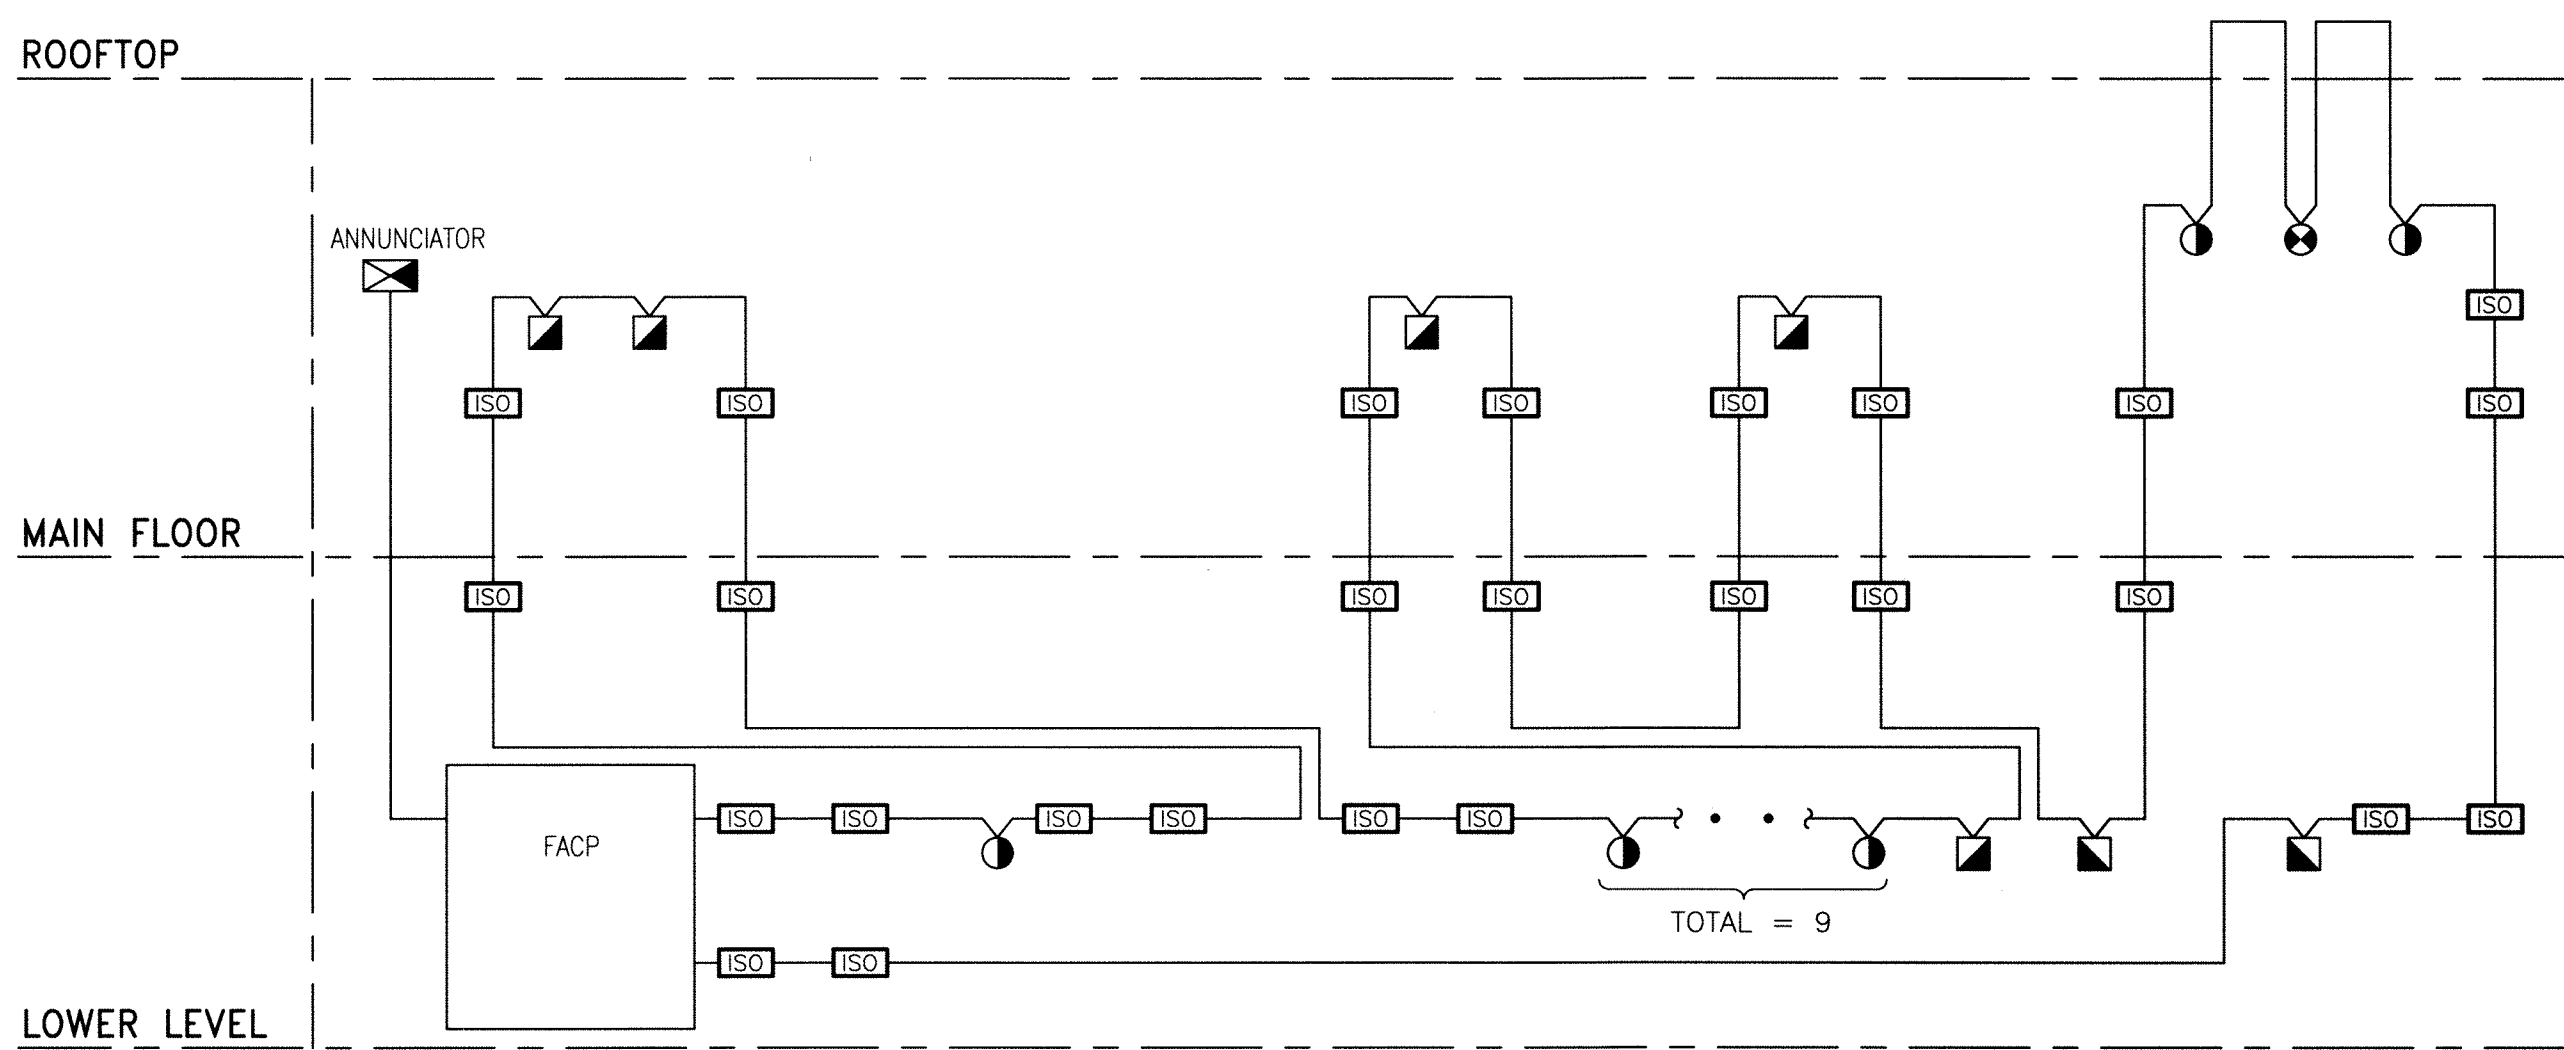

D FIRE ALARM ADDRESSABLE DEVICE LOOPS
SCALE: N.T.S.

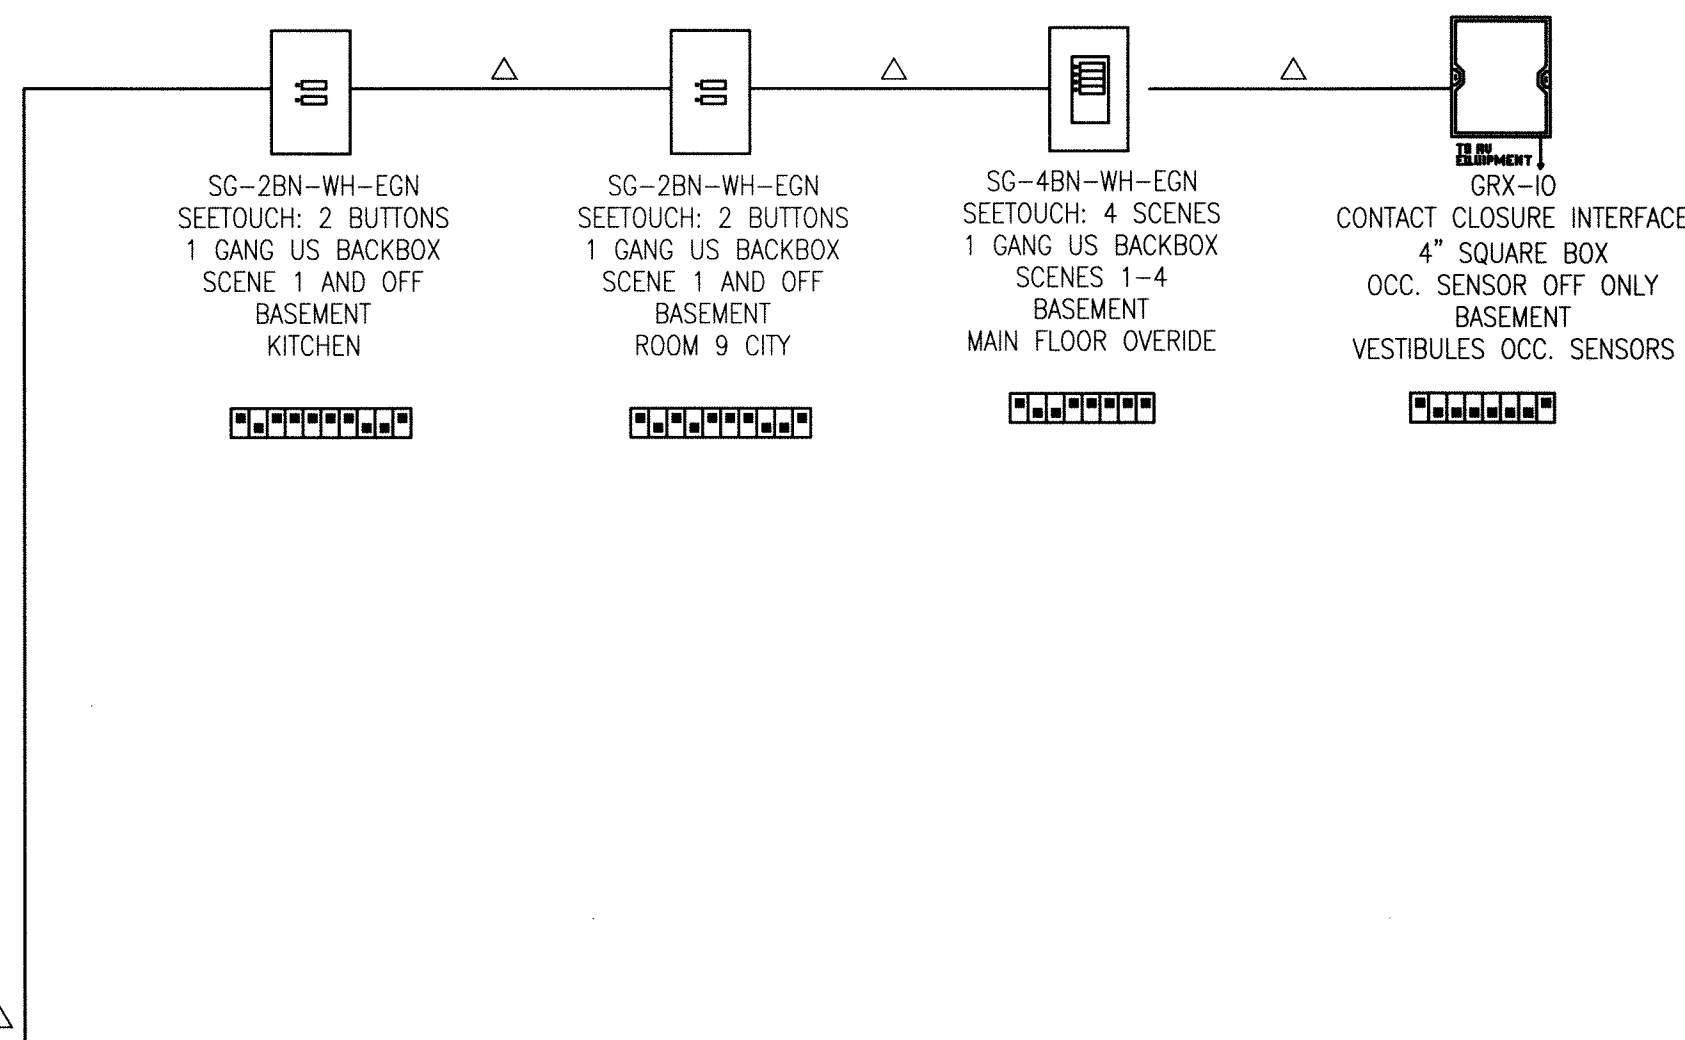

LEGEND (DETAIL E):

- △ LUTRON CABLE GRX-CBL-46L (NOTE 1)
- ⚡ MAIN FEED

THIS DRAWING MUST NOT BE SCALED.

THE GENERAL CONTRACTOR SHALL VERIFY ALL DIMENSIONS, DATINGS, AND LEVELS PRIOR TO COMMENCEMENT OF WORK. ALL ERRORS AND OMISSIONS TO BE REPORTED TO NUMBER TEN ARCHITECTURAL GROUP BEFORE PROCEEDING.

VARIATIONS AND MODIFICATIONS TO WORK SHOWN ON THESE DRAWINGS SHALL NOT BE CARRIED OUT WITHOUT WRITTEN PERMISSION OF NUMBER TEN ARCHITECTURAL GROUP.

THIS DRAWING IS THE EXCLUSIVE PROPERTY OF NUMBER TEN ARCHITECTURAL GROUP AND THE COPYRIGHT IN THE SAME BEING RESERVED TO THEM. IT MAY BE REPRODUCED ONLY WITH THE PERMISSION OF NUMBER TEN ARCHITECTURAL GROUP, IN WHICH CASE THE REPRODUCTION MUST BEAR THEIR NAME.

REVISED/ ISSUED/ PLOTTED	DATE
Rev. 1 - ISSUED FOR TENDER	FEBRUARY 03/2012
Rev. 0 - ISSUED FOR TENDER	NOVEMBER 21/2011

NOTES:

- LUTRON CABLE GRX-CBL-46L (NON-PLENUM) OR GRX-PCBL-46L (PLENUM RATED), OTHERWISE USE 2 #12AWG (2.5MM2), 1 BELDEN #9461 (OR EQUIVALENT), AND BETWEEN PANELS ADD 1 #18AWG (1.0MM2) FOR EMERGENCY SENSING.

numberTEN
architectural group

winnipeg MB regina SK victoria BC
204.942.0981 306.721.1501 250.360.2106

architecture • interior design • graphic design

PEGUIS PAVILION
UPGRADES AND ENTRY ADDITION
BIDDING #913-2011

project

LIFE SYSTEMS & COMMUNICATION
DETAILS AND RISER DIAGRAMS

sheet title

KGS GROUP CONSULTING
ENGINEERS

consultant

APCA
Certificate of Authorization
KGS Group
No. 245

PROFESIONALLY
REGISTERED
A.R.D.
PAUL KEWICH
Member
23235
PROFESSIONAL ENGINEER

scale: N.T.S.
date: November 03 2011
sheet no. **E11.0**
checked by:
project no. 2011026