



FOR DETAILS OF 1/4" PLATE COVER SEE DRAWING NO. 497

ENCLOSED GEAR PEDESTAL LIFT: ARMCO MODEL CPE-2


**ROOF PLAN**

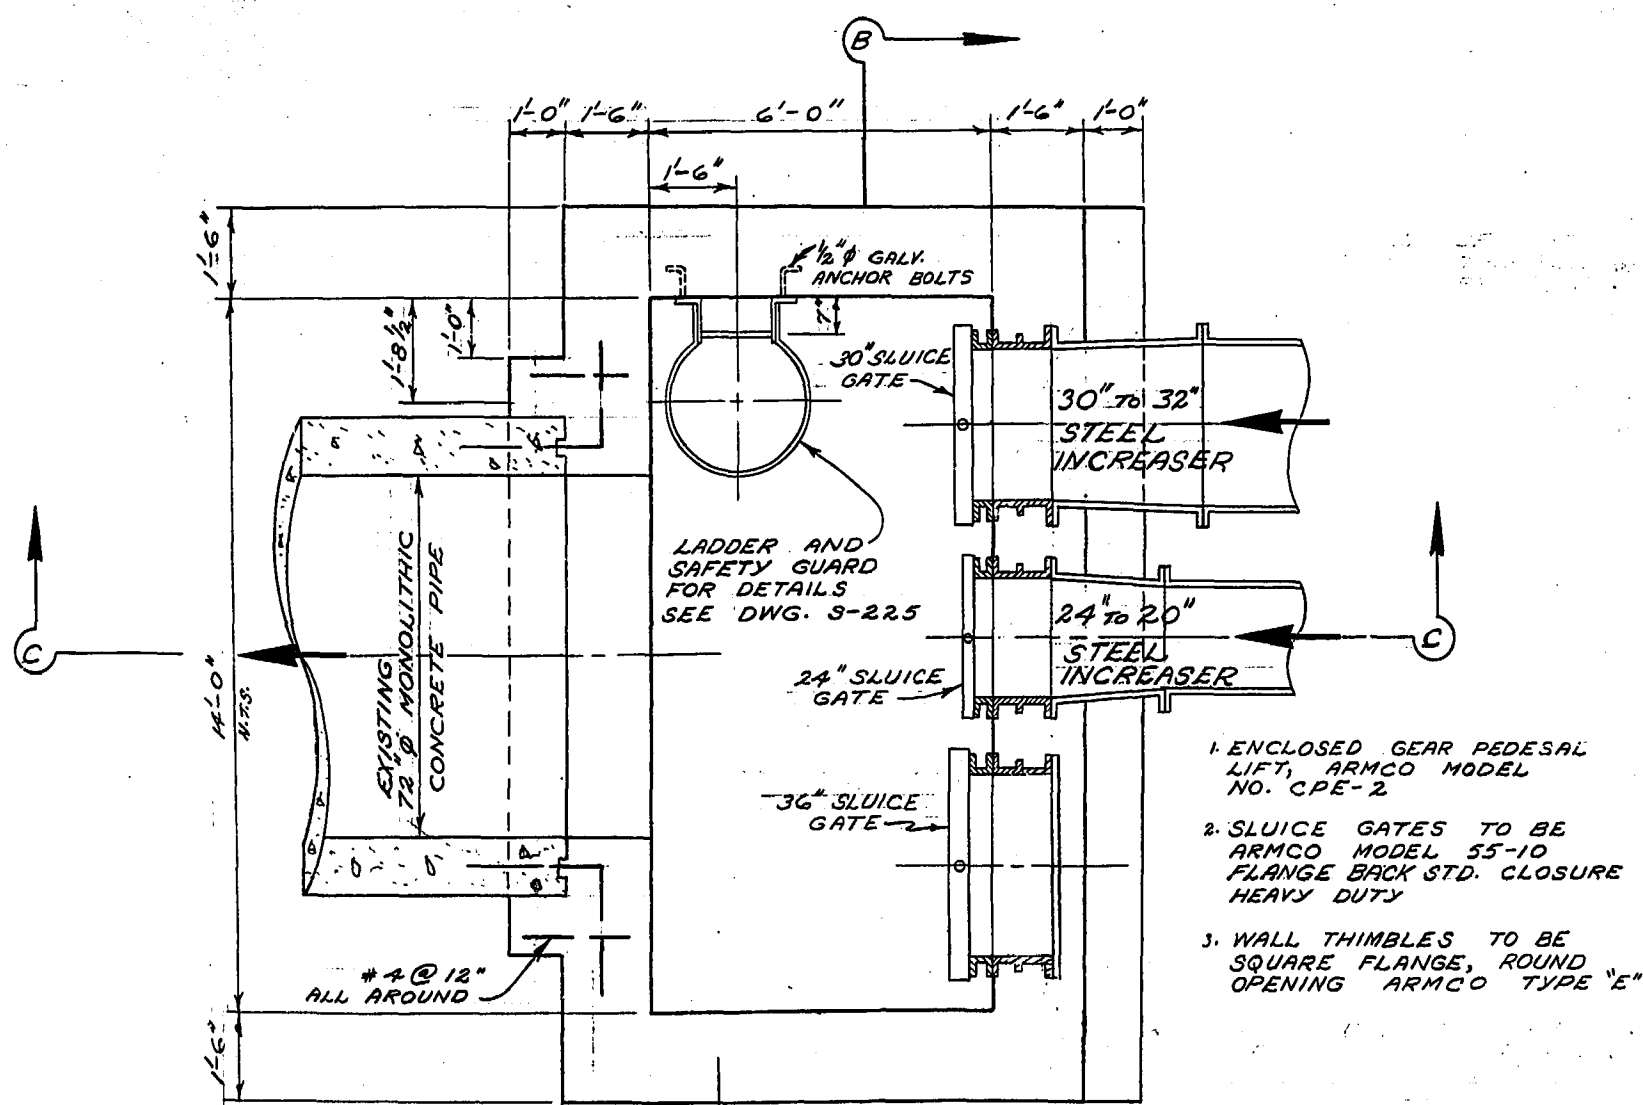

**SECTION "A-A"**

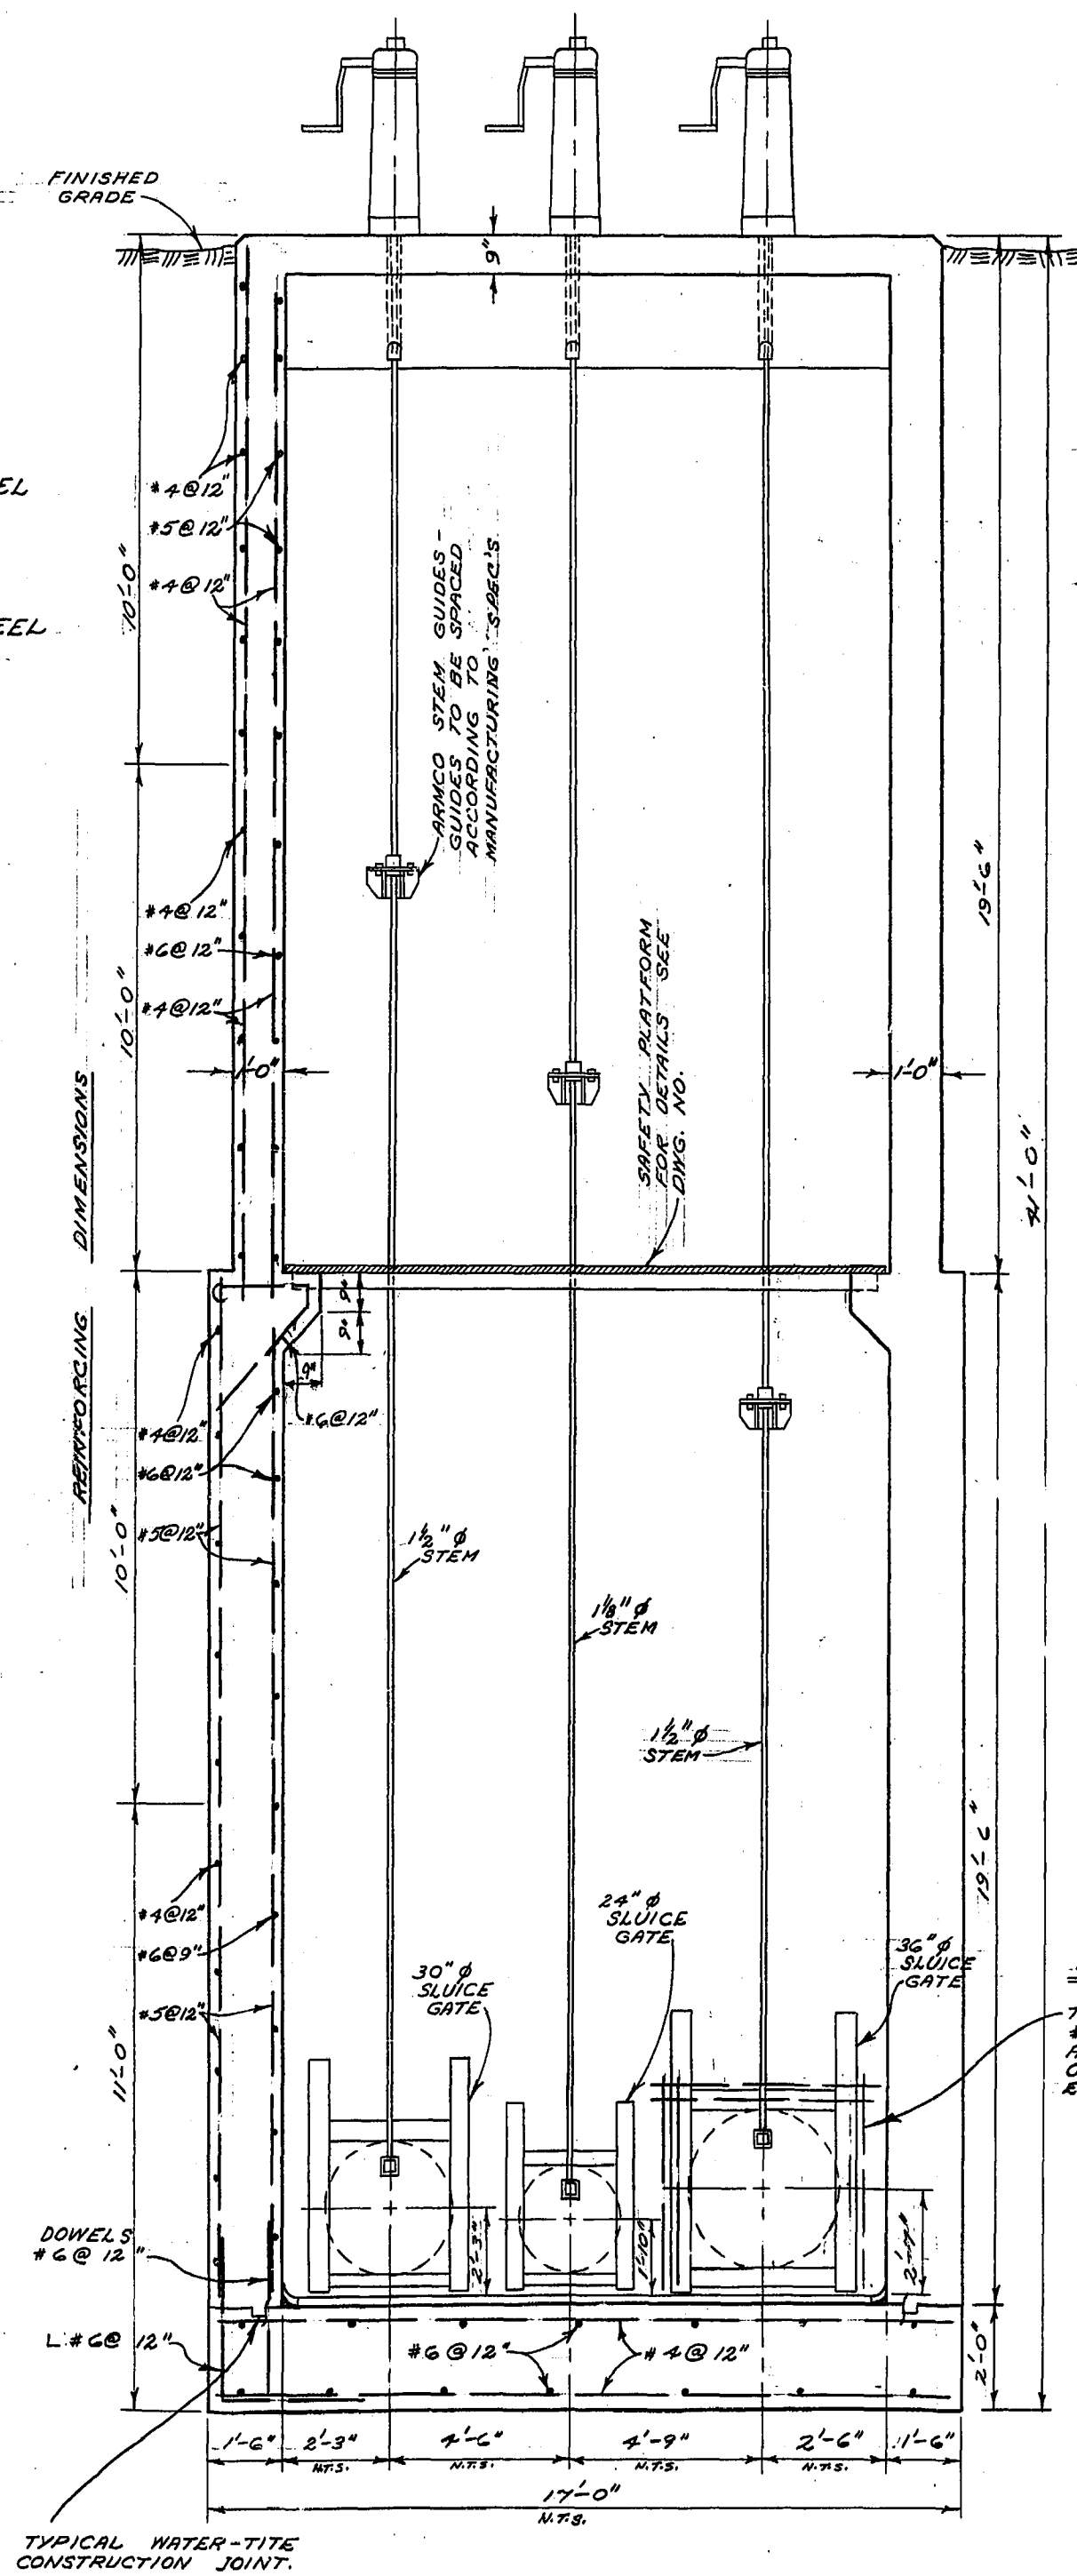

**SECTION "B-B"**

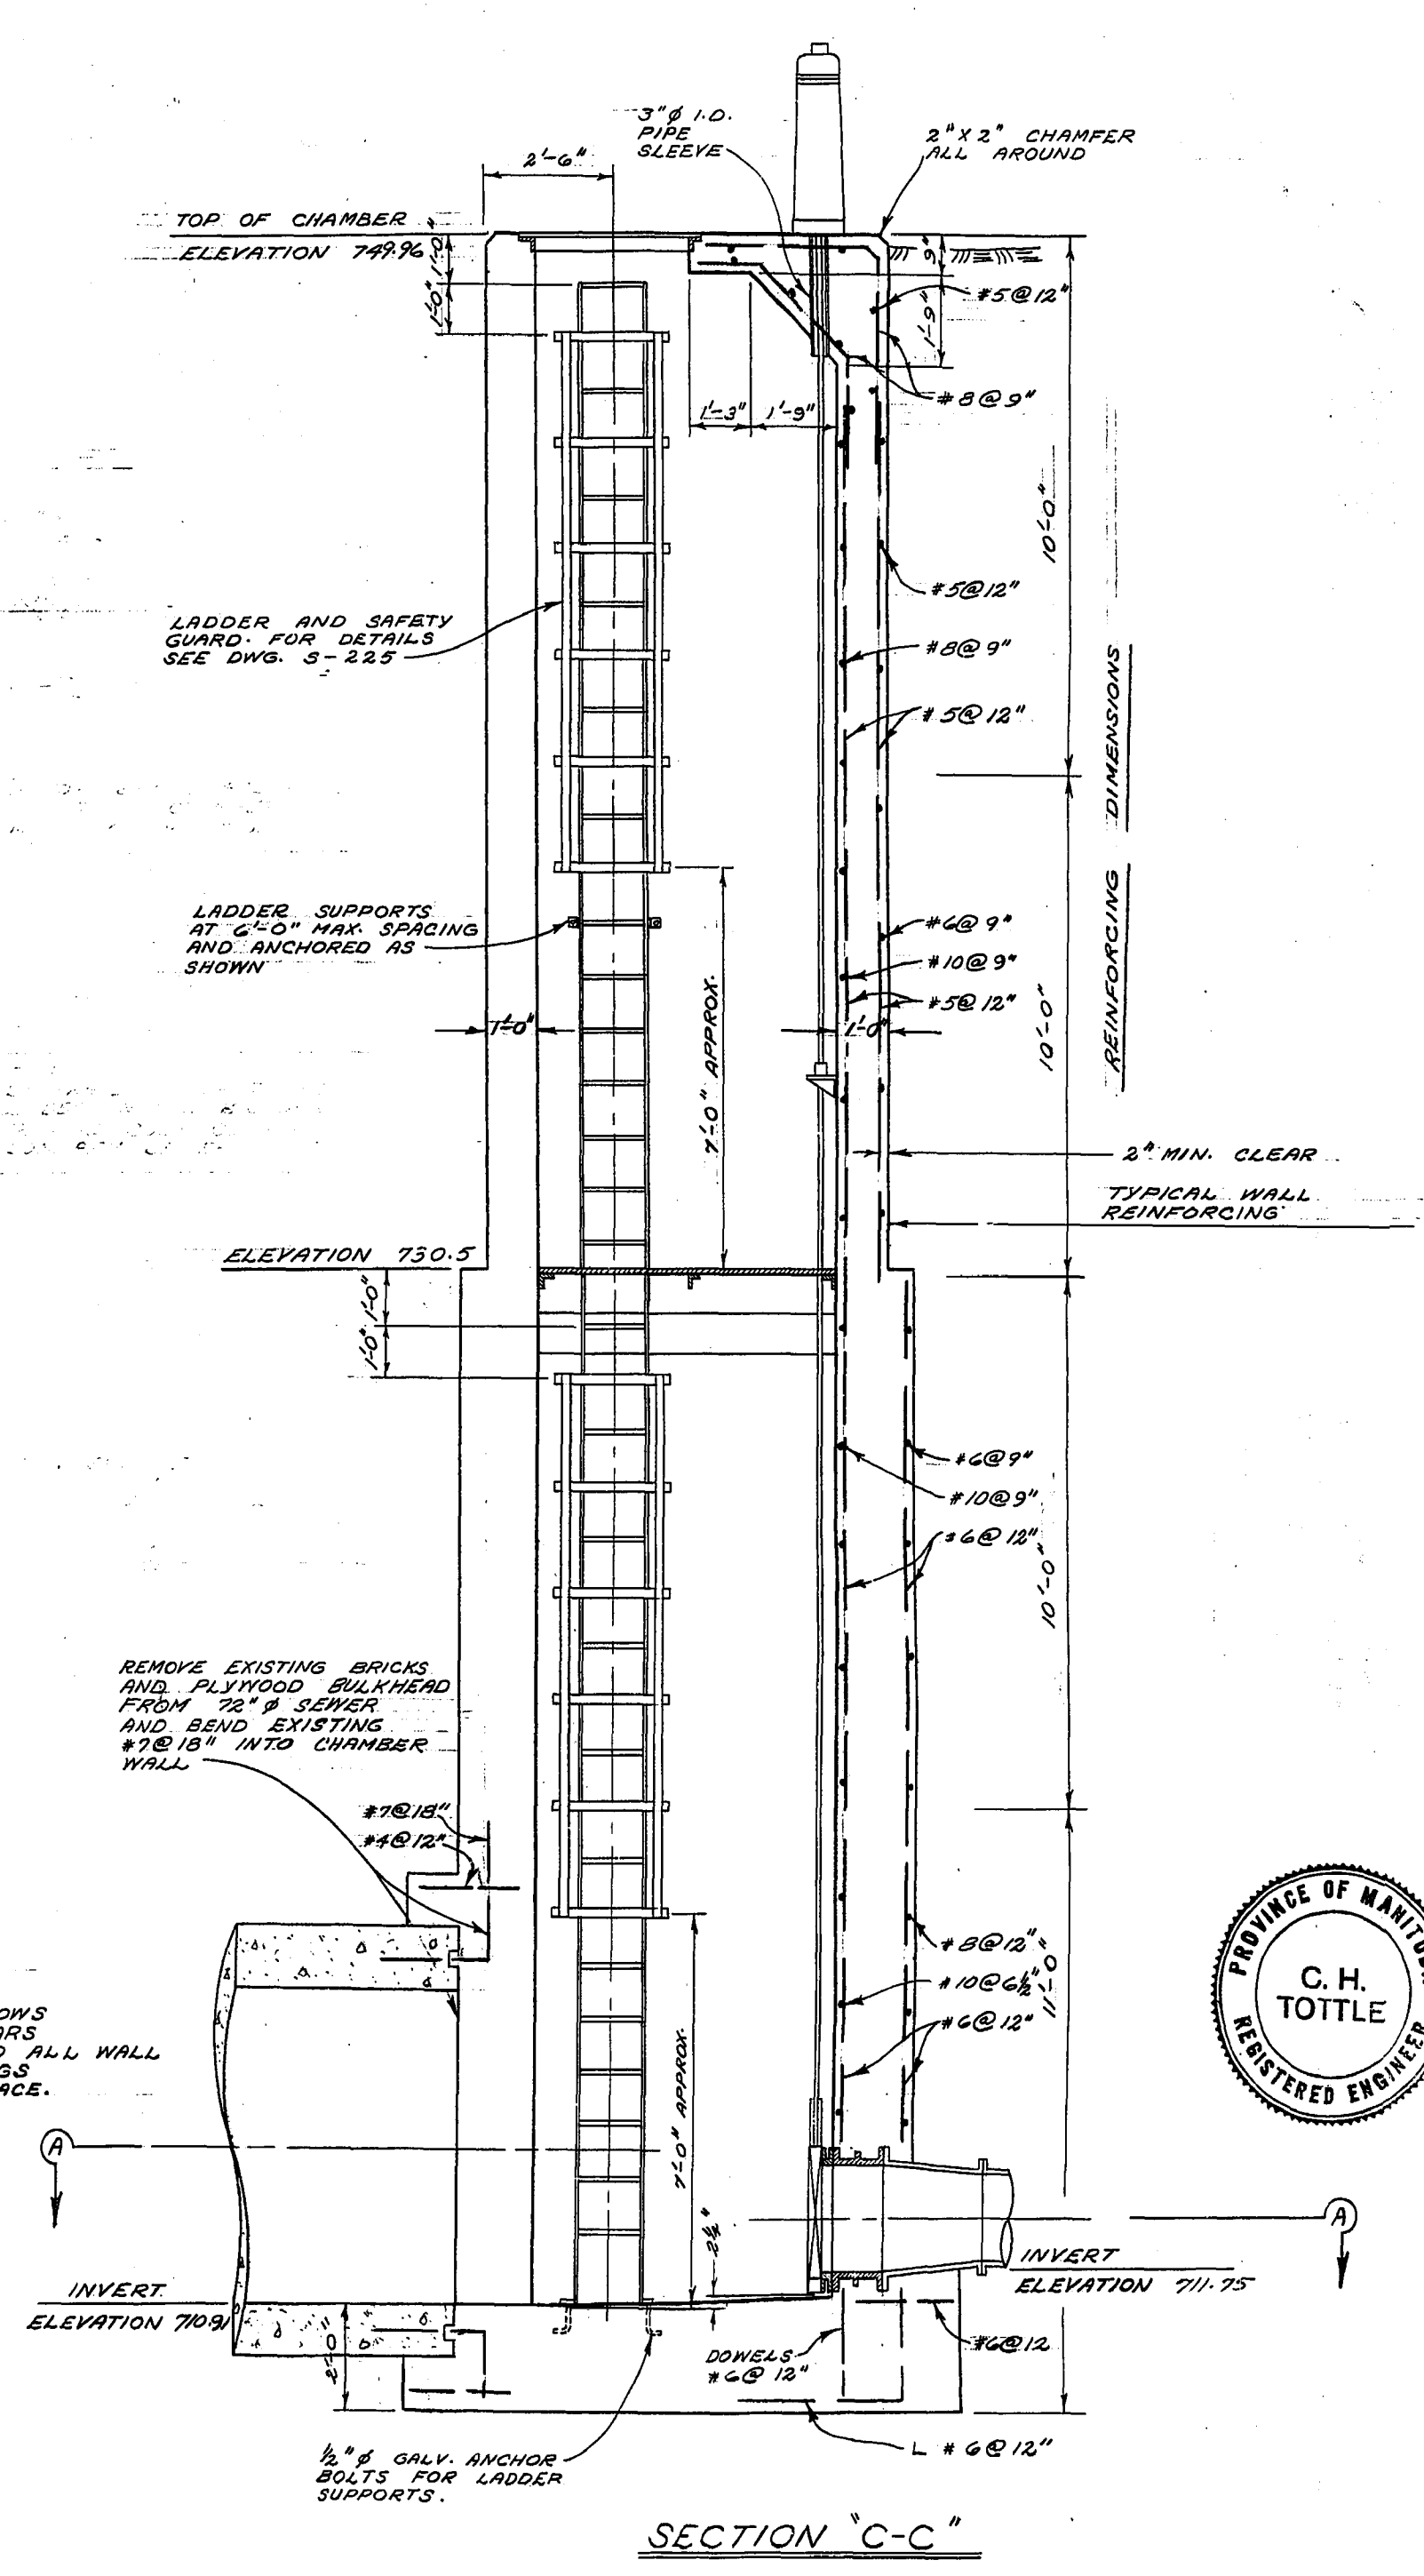


**SECTION "C-C"**

SURVEYED & PLAN CHECKED  
 BY: [Signature]  
 APPROVED AS BUILT  
 BY: M.D. O.S.  
 MAR. 1972

THE METROPOLITAN CORPORATION  
 OF GREATER WINNIPEG  
**WATERWORKS & WASTE  
 DISPOSAL DIVISION**  
 A. PENMAN - DIRECTOR

SEWERAGE DISPOSAL DEPT.  
**NORTH-EAST INTERCEPTOR  
 RIVER CROSSING  
 SIPHON OUTLET CHAMBER**

DESIGNED: [Signature] CH'KD.: [Signature]  
 DRN. V. DUMORE DATE JULY 170  
 ENG. DES. [Signature]  
 ENG. [Signature]  
 APPROVED: [Signature]

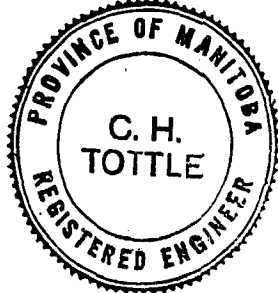

SCALE  
 3/8" = 1'-0"  
 DRAWING NO.  
**496**