


LIGHT SWITCH SCHEDULE						
SWITCH	LOCATION	Panel & cct#	LV Panel	TYPE(S) LUMINAIRES	QUANTITY	NOTES
LV1	SA-26	300-5		AIMLITE: VP4-T5HO-54-AC-347-CSA	12	Type W
LV2	Heavy Equipment Wash Bay			AIMLITE: VP4-T5HO-54-AC-347-CSA	18	Type X
LV3	SA-25 Vehicle Wash Bay	300-7		AIMLITE: VP4-T5HO-54-AC-347-CSA	18	Type X
LV4				AIMLITE: VP4-T5HO-54-AC-347-CSA	12	Type W
LV5	SM-09A Wash Equipment		400-5	GREEN-LIGHTS INC.: I-6-3-W	27	Type B or BOC
LV6			400-7			
LV7			400-9			
LV8			400-3			
LV9			300-9			
LV10						
LV11	BO-02 Bridge Work Area BO-03 Bridge Crane Bay BO-04 Shower Eyewash	600-1		GREEN-LIGHTS INC.: I-6-3-W	16	Type B
LV12	119 Multi Purpose Room	1100-11		PRUDENTIAL LIGHTING: S1-1T5HO-WA-TMW-347-CSA	30	Type U
LV13						
LV14	CS-09 Corridor	1000-1		LITHONIA: CB-2-54T5HO-347-CSA	3	Type J1
LV15	CS-09 Vehicle Storage	1000-1		GREEN-LIGHTS INC.: I-6-3-W	8	Type B
LV16						
LV17						
LV18	FM-01 Shops	800-7 800-9 800-11		GREEN-LIGHTS INC.: I-6-3-W	33	Type B
LV19						
LV20						
LV21M	181 Corridor	1000-1		LITHONIA:	5	Type J
LV22M	177 Corridor	800-13		SP5-G-2-54T5HO-A12-347-CSA		Master Control Light Switch
LV23	171 Storage	800-14		LITHONIA:	17	Type D
LV24					TZ 2-54T5HO-CSA-ZS5MR46	
LV25M	SA-03 Reception	1100-13		LITHONIA:	31	Type J
LV26M	121 Corridor			SP5-G-2-54T5HO-A12-347-CSA		

ISSUED FOR CITY REVIEW 11-06-2012

1
E2.5
PARTIAL SECOND FLOOR PLAN
FLEET MANAGEMENT - LIGHTING LAYOUT
SCALE: 1/100

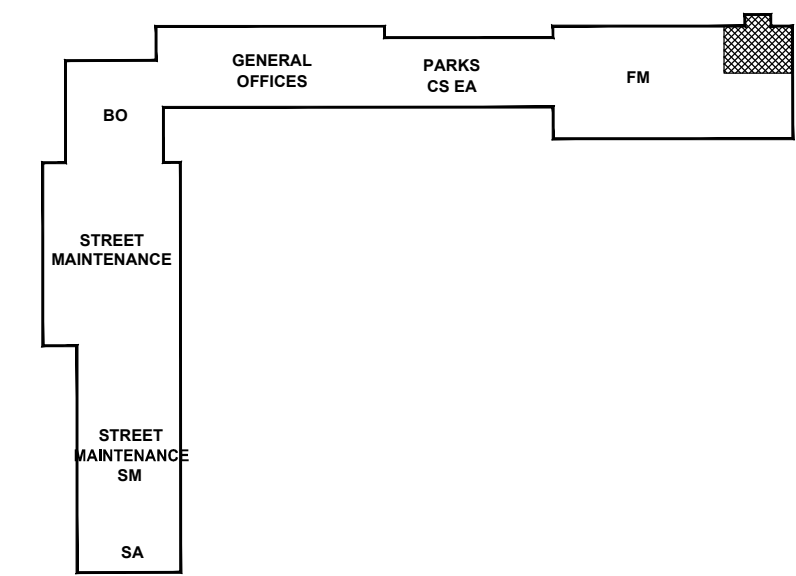

2
E2.5
KEY PLAN
SCALE: 1/2000

NOT FOR
CONSTRUCTION

REV	DESCRIPTION	DATE	BY
3	ISSUED FOR 99% REVIEW	2012.06.04	MZ
2	ISSUED FOR 66% REVIEW	2012.03.06	MZ
1	ISSUED FOR 33% REVIEW	2012.01.06	MZ

NOVA 3 ENGINEERING LTD.
CONSULTING ENGINEERS
201-120 FORT STREET WINNIPEG, MANITOBA R3C 1C7
TEL: (204) 943-8142 FAX: (204) 942-1276 JN.: 31-173
Certificate of Authorization
Nova 3 Engineering Ltd.
No. 962 Date: _____

ERNST HANSCH
CONSTRUCTION LTD.

3 TERRACON PLACE
WINNIPEG, CANADA R2J 4B3
TEL. (204) 233 7881
FAX (204) 233 4733
general@ehansch.com
www.ehansch.com

CLIENT: CITY OF WINNIPEG
PUBLIC WORKS DEPARTMENT
PROJECT NUMBER: 31-178E
DRAWN BY: KC
DATE: MARCH 06, 2012
SCALE: AS SHOWN

PROJECT TITLE:
CITY OF WINNIPEG
PUBLIC WORKS EAST YARD COMPLEX
MAIN OFFICE & GARAGES
SHEET TITLE:
SECOND FLOOR LIGHTING LAYOUT

SHEET NUMBER:
E2.5
REVISION NUMBER:
0