


1 ADMINISTRATIVE BLOCK 2ND LEVEL FLOOR PLAN - POWER AND SYSTEMS LAYOUT
 E3.3 SCALE: 1:100

SPECIFIC ELECTRICAL NOTES

- ① WIRE AND CONNECT TRANSFORMER FOR LAV. AND ASSOCIATED CONTROLS AS REQUIRED. CONFIRM EXACT ELECTRICAL REQUIREMENTS WITH MANUFACTURER'S SPECIFICATIONS PRIOR TO ROUGH IN.
- ② POWER AND DATA DEVICES LOCATED AT THIS LEVEL FOR PROJECTOR. WIRE AND CONNECT MOTORIZED GREEN AND ALL ASSOCIATED CONTROLS, AS REQUIRED. COORDINATE EXACT ELECTRICAL REQUIREMENTS WITH MANUFACTURER'S SPECIFICATIONS PRIOR TO ROUGH IN.

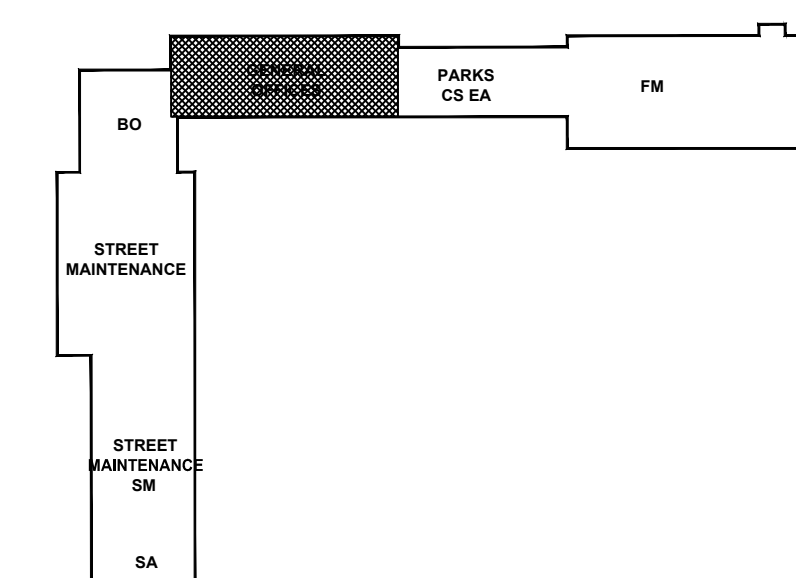

2 KEY PLAN
 E3.3 SCALE: 1:2000

NOT FOR CONSTRUCTION

REV	DESCRIPTION	DATE	BY
3	ISSUED FOR 99% REVIEW	2012.06.04	MZ
2	ISSUED FOR 66% REVIEW	2012.03.06	MZ
1	ISSUED FOR 33% REVIEW	2012.01.06	MZ

NOVA 3 ENGINEERING LTD.
 CONSULTING ENGINEERS
 201-120 FORT STREET TEL: (204) 943-8142
 WINNIPEG, MANITOBA FAX: (204) 942-1276
 R3C 1C7 JN.: 31-173
 THIS DRAWING IS THE EXCLUSIVE PROPERTY OF NOVA 3 ENGINEERING LTD. AND MAY ONLY BE REPRODUCED WITH THE WRITTEN PERMISSION OF NOVA 3 ENGINEERING LTD.
 THE CONCEPT AND DESIGN INCORPORATED INTO THIS DRAWING ARE BASED ON INFORMATION PROVIDED BY THE CLIENT AND OTHER RELATED SOURCES. PROFESSIONAL ENGINEER ACCEPTS NO RESPONSIBILITY FOR DRAWING AND DESIGN UNLESS DRAWING IS ACCOMPANIED BY ORIGINAL SEALED AND SIGNED LETTER OF INTENT AND CERTIFICATE OF INSPECTION. REFER TO WWW.NOVA3.CA FOR CAUTIONARY NOTES.

APEGM
 Certificate of Authorization
 Nova 3 Engineering Ltd.
 No. 962 Date: _____

ERNST HANSCH
 CONSTRUCTION LTD.

3 TERRACON PLACE
 WINNIPEG, CANADA R2J 4B3
 TEL. (204) 233 7881
 FAX (204) 233 4733
 general@ehansch.com
 www.ehansch.com

CLIENT: CITY OF WINNIPEG
 PUBLIC WORKS DEPARTMENT
 PROJECT NUMBER: 31-178E
 DRAWN BY: KC
 DATE: MARCH 06, 2012
 SCALE: AS SHOWN

PROJECT TITLE:
 CITY OF WINNIPEG
 PUBLIC WORKS EAST YARD COMPLEX
 MAIN OFFICE & GARAGES
 SHEET TITLE:
SECOND FLOOR POWER & SYSTEMS LAYOUT

SHEET NUMBER:

E3.3

REVISION NUMBER:

0