


FROM XFMR-M2
 (SEE DRAWING 1-0630M-E0002)

ARC FLASH VALUES ARE
 PRELIMINARY AND WILL BE
 FINALIZED DURING CONSTRUCTION.

LEGEND:
 ——— EXISTING
 ——— NEW WORK
 - - - FUTURE

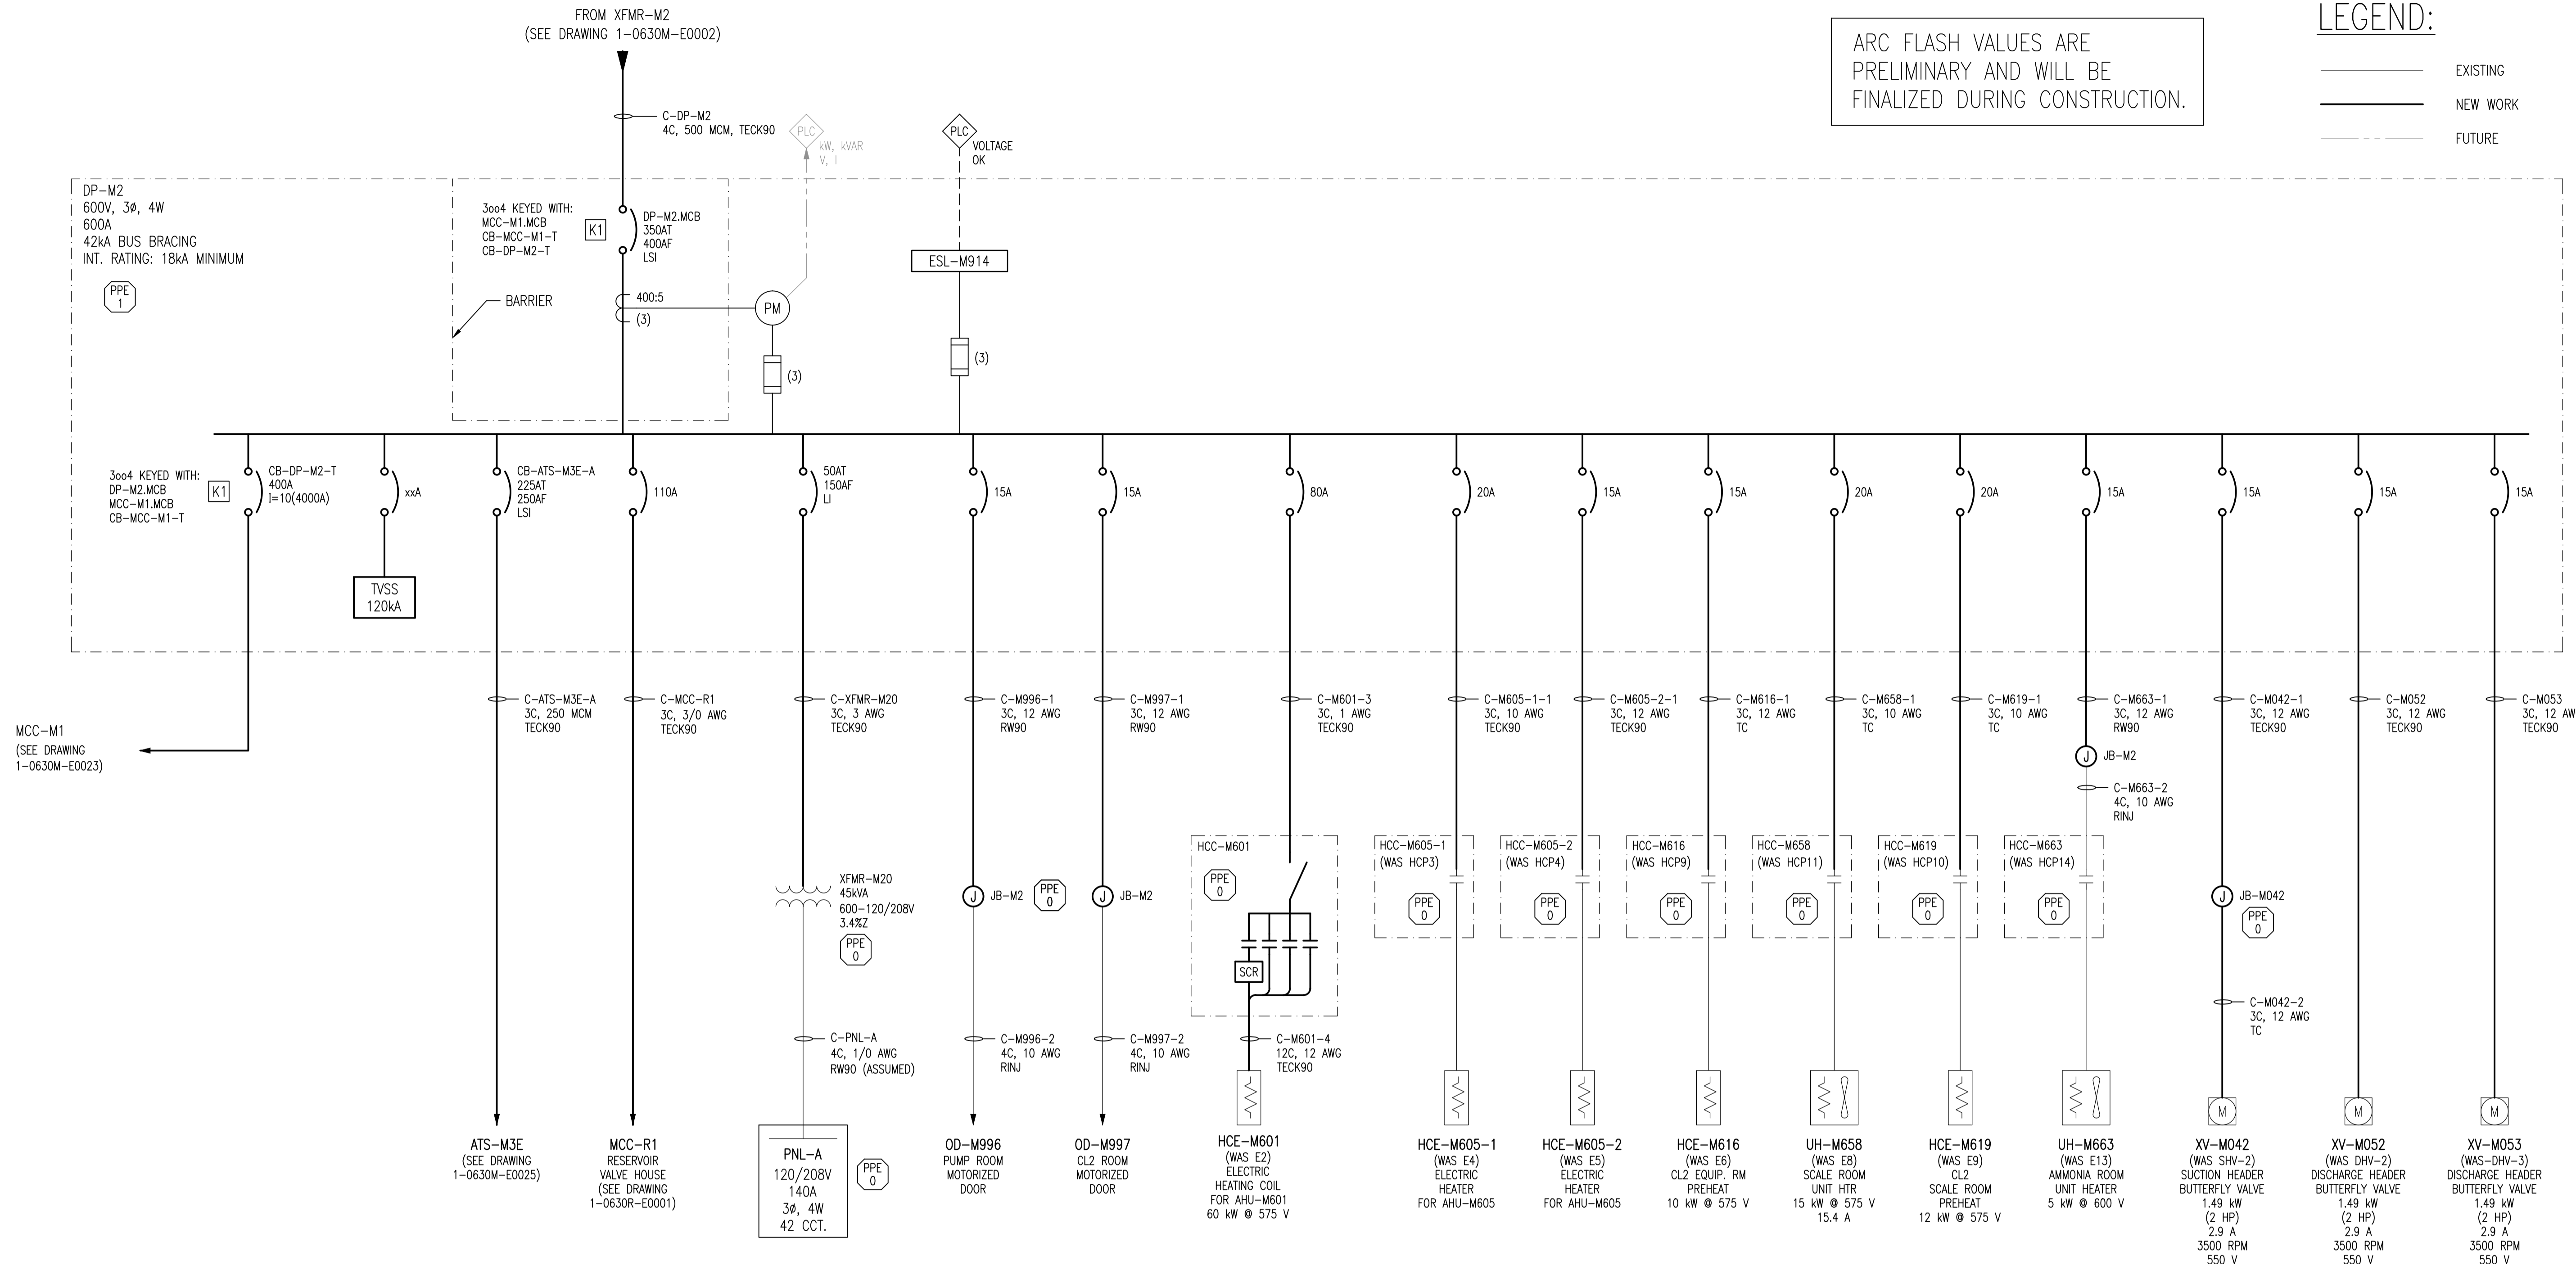

1-0630M-E0029	PANEL SCHEDULE AND DETAILS - DP-M2
1-0630M-E0001	ELECTRICAL SINGLE LINE DIAGRAM LEGEND AND DETAILS
DRAWING NUMBER	REFERENCE DRAWINGS



NO.	REVISIONS	DATE	DESIGN	CHECK
00	ISSUED FOR TENDER, BID OPP: 490-2012	2012/07/23	BJC	CJR

SNC-LAVALIN INC. 148 Nature Park Way Winnipeg, MB, Canada R3P 0X7 204-786-8080	
DESIGNED BY: B. CLEVEN	CHECKED BY: C. REIMER
DRAWN BY: S. FUNK	APPROVED BY: C. REIMER
SCALE: NTS	RELEASED FOR CONSTRUCTION BY: DATE: 2011/01/25
CONSULTANT NO.: 508955-0000-47DD-0024	

ENGINEER'S SEAL
PRELIMINARY
 NOT TO BE
 USED FOR
 CONSTRUCTION

THE CITY OF WINNIPEG WATER AND WASTE DEPARTMENT			
MACLEAN WATER PUMPING STATION			
ELECTRICAL SINGLE LINE DIAGRAM DP-M2			
CITY DRAWING NUMBER	SHEET	REV.	SIZE
1-0630M-E0024	001	00	A1