



LEGEND:

— EXISTING
— NEW WORK

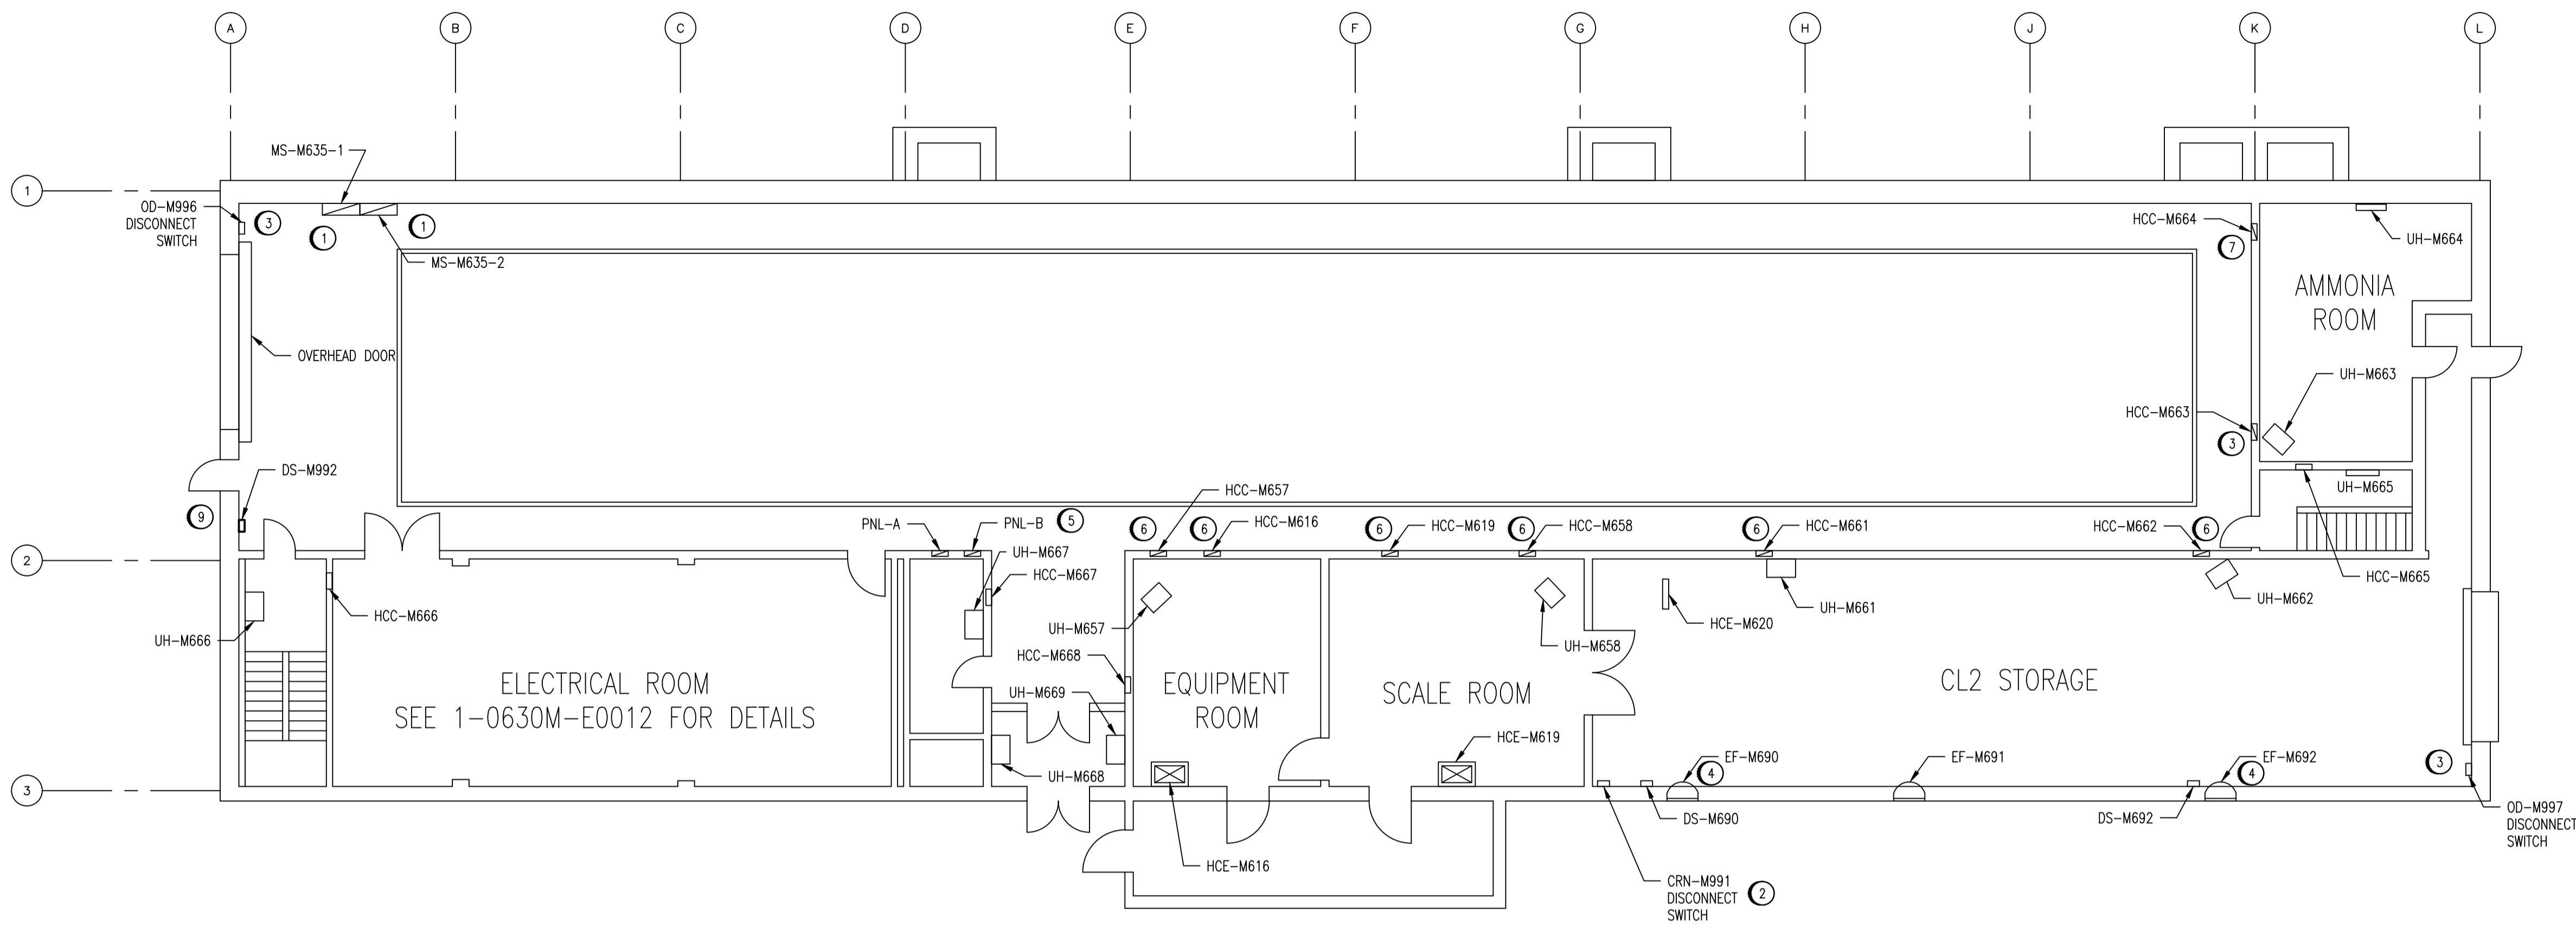

MAIN FLOOR - ELEV. 232.260
SCALE: 1 : 100

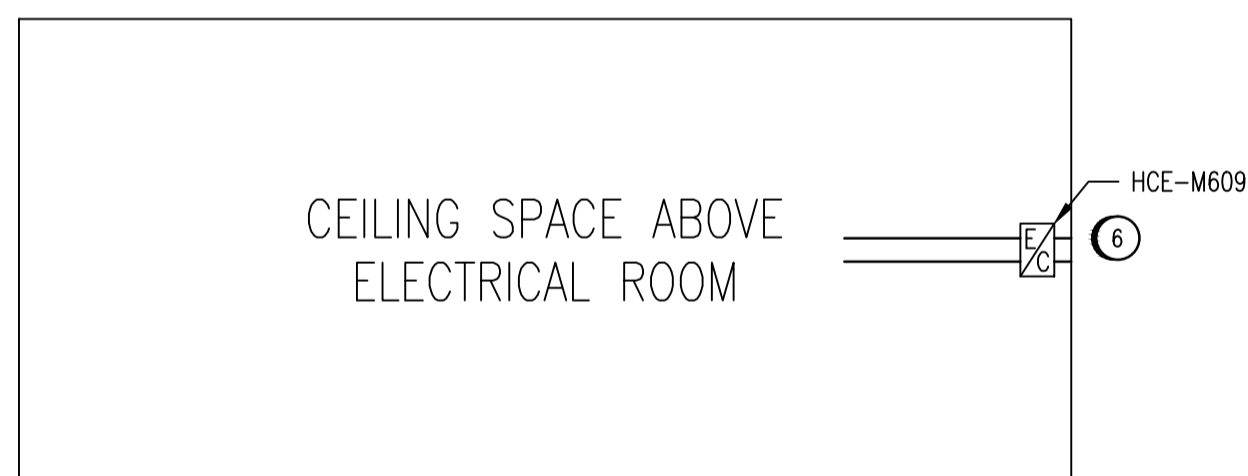

ELECTRICAL ROOM CEILING SPACE - ELEV. 235.967
SCALE: 1 : 100

SPECIFIC NOTES:

- ① REUTILIZE AND EXTEND EXISTING CONDUIT.
- ② CONNECT EXISTING WIRING TO JB-M1 AT MEZZANINE LEVEL. RE-FEED LOAD VIA JB-M1.
- ③ CONNECT EXISTING WIRING TO JB-M2 AT MEZZANINE LEVEL. RE-FEED LOAD VIA JB-M2.
- ④ CONNECT EXISTING WIRING TO JB-M3 AT MEZZANINE LEVEL. RE-FEED LOAD VIA JB-M3.
- ⑤ REPLACE PNL-B INTERIOR. LABEL AND RETERMINATE ALL LOADS.
- ⑥ REWIRE UTILIZING NEW TRAY CABLE IN EXISTING CONDUIT DOWN TO CABLE TRAY.
- ⑦ UNIT HEATER DISCONTINUED. CONNECT EXISTING WIRING TO JB-M1.
- ⑧ ROUTE TECK CABLE TO MCC VIA SURFACE MOUNTED UNISTRUT AND CABLE TRAY.
- ⑨ REPLACE DISCONNECT SWITCH AND WIRE VIA TECK CABLE FROM TRAY BELOW.

1-0630M-E0029	PANEL SCHEDULE AND DETAILS, DP-M2
1-0630M-E0028	MCC SCHEDULES, MCC-M1 AND MCC-M3E
DRAWING NUMBER	REFERENCE DRAWINGS



NO.	REVISIONS	DATE	DESIGN	CHECK
00	ISSUED FOR TENDER, BID OPP: 490-2012	2012/07/23	VE	CJR

SNC-LAVALIN INC.
148 Nature Park Way
Winnipeg, MB, Canada R3P 0X7
204-798-8080

DESIGNED BY: V. ELIMBAN
DRAWN BY: S. FUNK/M. TUGADE
SCALE: 1:100
DATE: 2010/10/06

CHECKED BY: C. REIMER
APPROVED BY: C. REIMER
RELEASED FOR CONSTRUCTION BY:
DATE:

CONSULTANT NO.: 508955-0000-47DD-0032

ENGINEER'S SEAL
PRELIMINARY
NOT TO BE
USED FOR
CONSTRUCTION

THE CITY OF WINNIPEG
WATER AND WASTE DEPARTMENT

MACLEAN WATER PUMPING STATION

ELECTRICAL EQUIPMENT PLAN
MAIN FLOOR

CITY DRAWING NUMBER: 1-0630M-E0032
SHEET: 001
REV: 00
SIZE: A1