


WET WELL AND FOYER

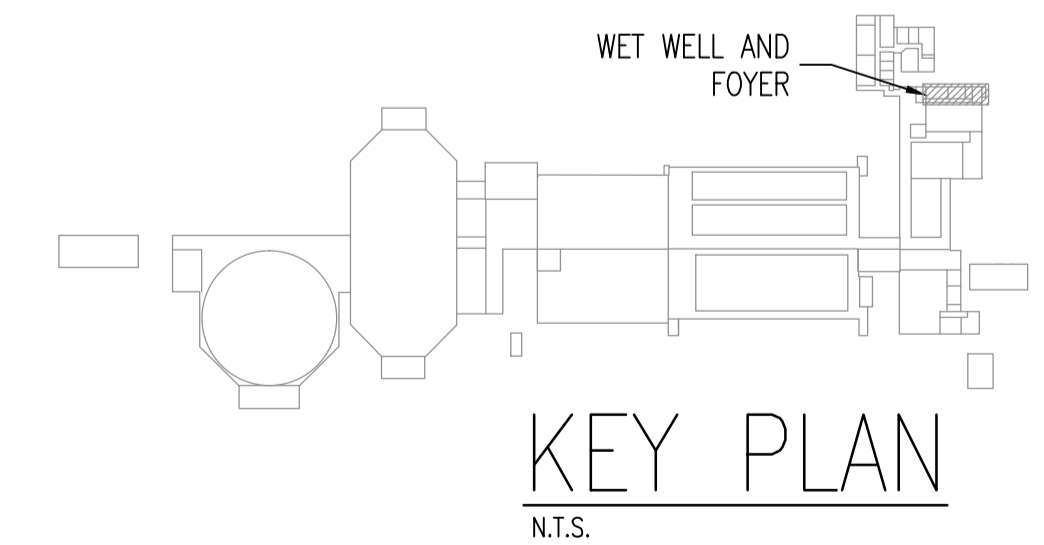

NO.	CONSTRUCTION NOTES
1	WIRE CONTACT ON EXISTING LIGHT SWITCH BACK TO LCP-G1. SEE DRAWING 1-0102G-A0090 FOR DETAILS.
2	TERMINATE IMPULSE LINE FOR PRESSURE TRANSMITTER 0.5m BELOW CEILING.



NOTES:

- THIS DRAWING SUPERCEDES PART OF SEP-837.



NO.	REVISIONS	DATE	DESIGN	CHECK
00	ISSUED FOR TENDER, BID OPP. 545-2012	2012/09/10	TMC	CJR

SNC-LAVALIN INC. 148 Nature Park Way Winnipeg, MB, Canada R3P 0X7 204-798-8080	
DESIGNED BY: T. CHURCH	CHECKED BY: C. REIMER
DRAWN BY: M.J. PERSSON	APPROVED BY: C. REIMER
SCALE: 1 : 30	RELEASED FOR CONSTRUCTION BY: N. HARRINGTON
DATE: 2012/01/16	DATE: 2012/09/10
CONSULTANT NO.: 112577-0116-48DD-0003	

ENGINEER'S SEAL

THE CITY OF WINNIPEG
 WATER AND WASTE DEPARTMENT

SOUTH END WATER POLLUTION CONTROL CENTRE
 VENTILATION & MISC UPGRADES
 INSTRUMENT LOCATION PLAN
 WET WELL AND FOYER

CITY DRAWING NUMBER	SHEET	REV.	SIZE
1-0102G-A0098	001	00	A1

1-0102G-A0093	P & ID, WET WELL VENTILATION
DRAWING NUMBER	REFERENCE DRAWINGS