



# THE CITY OF WINNIPEG



## WATER AND WASTE DEPARTMENT

# DEACON RESERVOIR INTERCONNECTOR CULVERT REHABILITATION

### BID OPPORTUNITY NO. 567-2012

#### DRAWING LIST

CITY DWG No.	REV.	DESCRIPTION
1-0620M-C0001-001	0	COVER SHEET
1-0620M-C0002-001	0	LOCATION AND STAGING PLAN
1-0620M-C0003-001	0	CELLS 1&2 NORTH INTERCONNECTOR CULVERT - EXISTING PLAN AND PROFILE
1-0620M-C0004-001	0	CELLS 1&2 SOUTH INTERCONNECTOR CULVERT - EXISTING PLAN AND PROFILE
1-0620M-C0005-001	0	CELLS 1&2 NORTH INTERCONNECTOR CULVERT - PROPOSED PROFILE AND DET/
1-0620M-C0006-001	0	CELLS 1&2 SOUTH INTERCONNECTOR CULVERT - PROPOSED PROFILE AND DET/
1-0620M-C0007-001	0	MISCELLANEOUS DETAILS

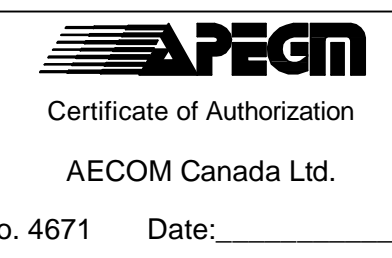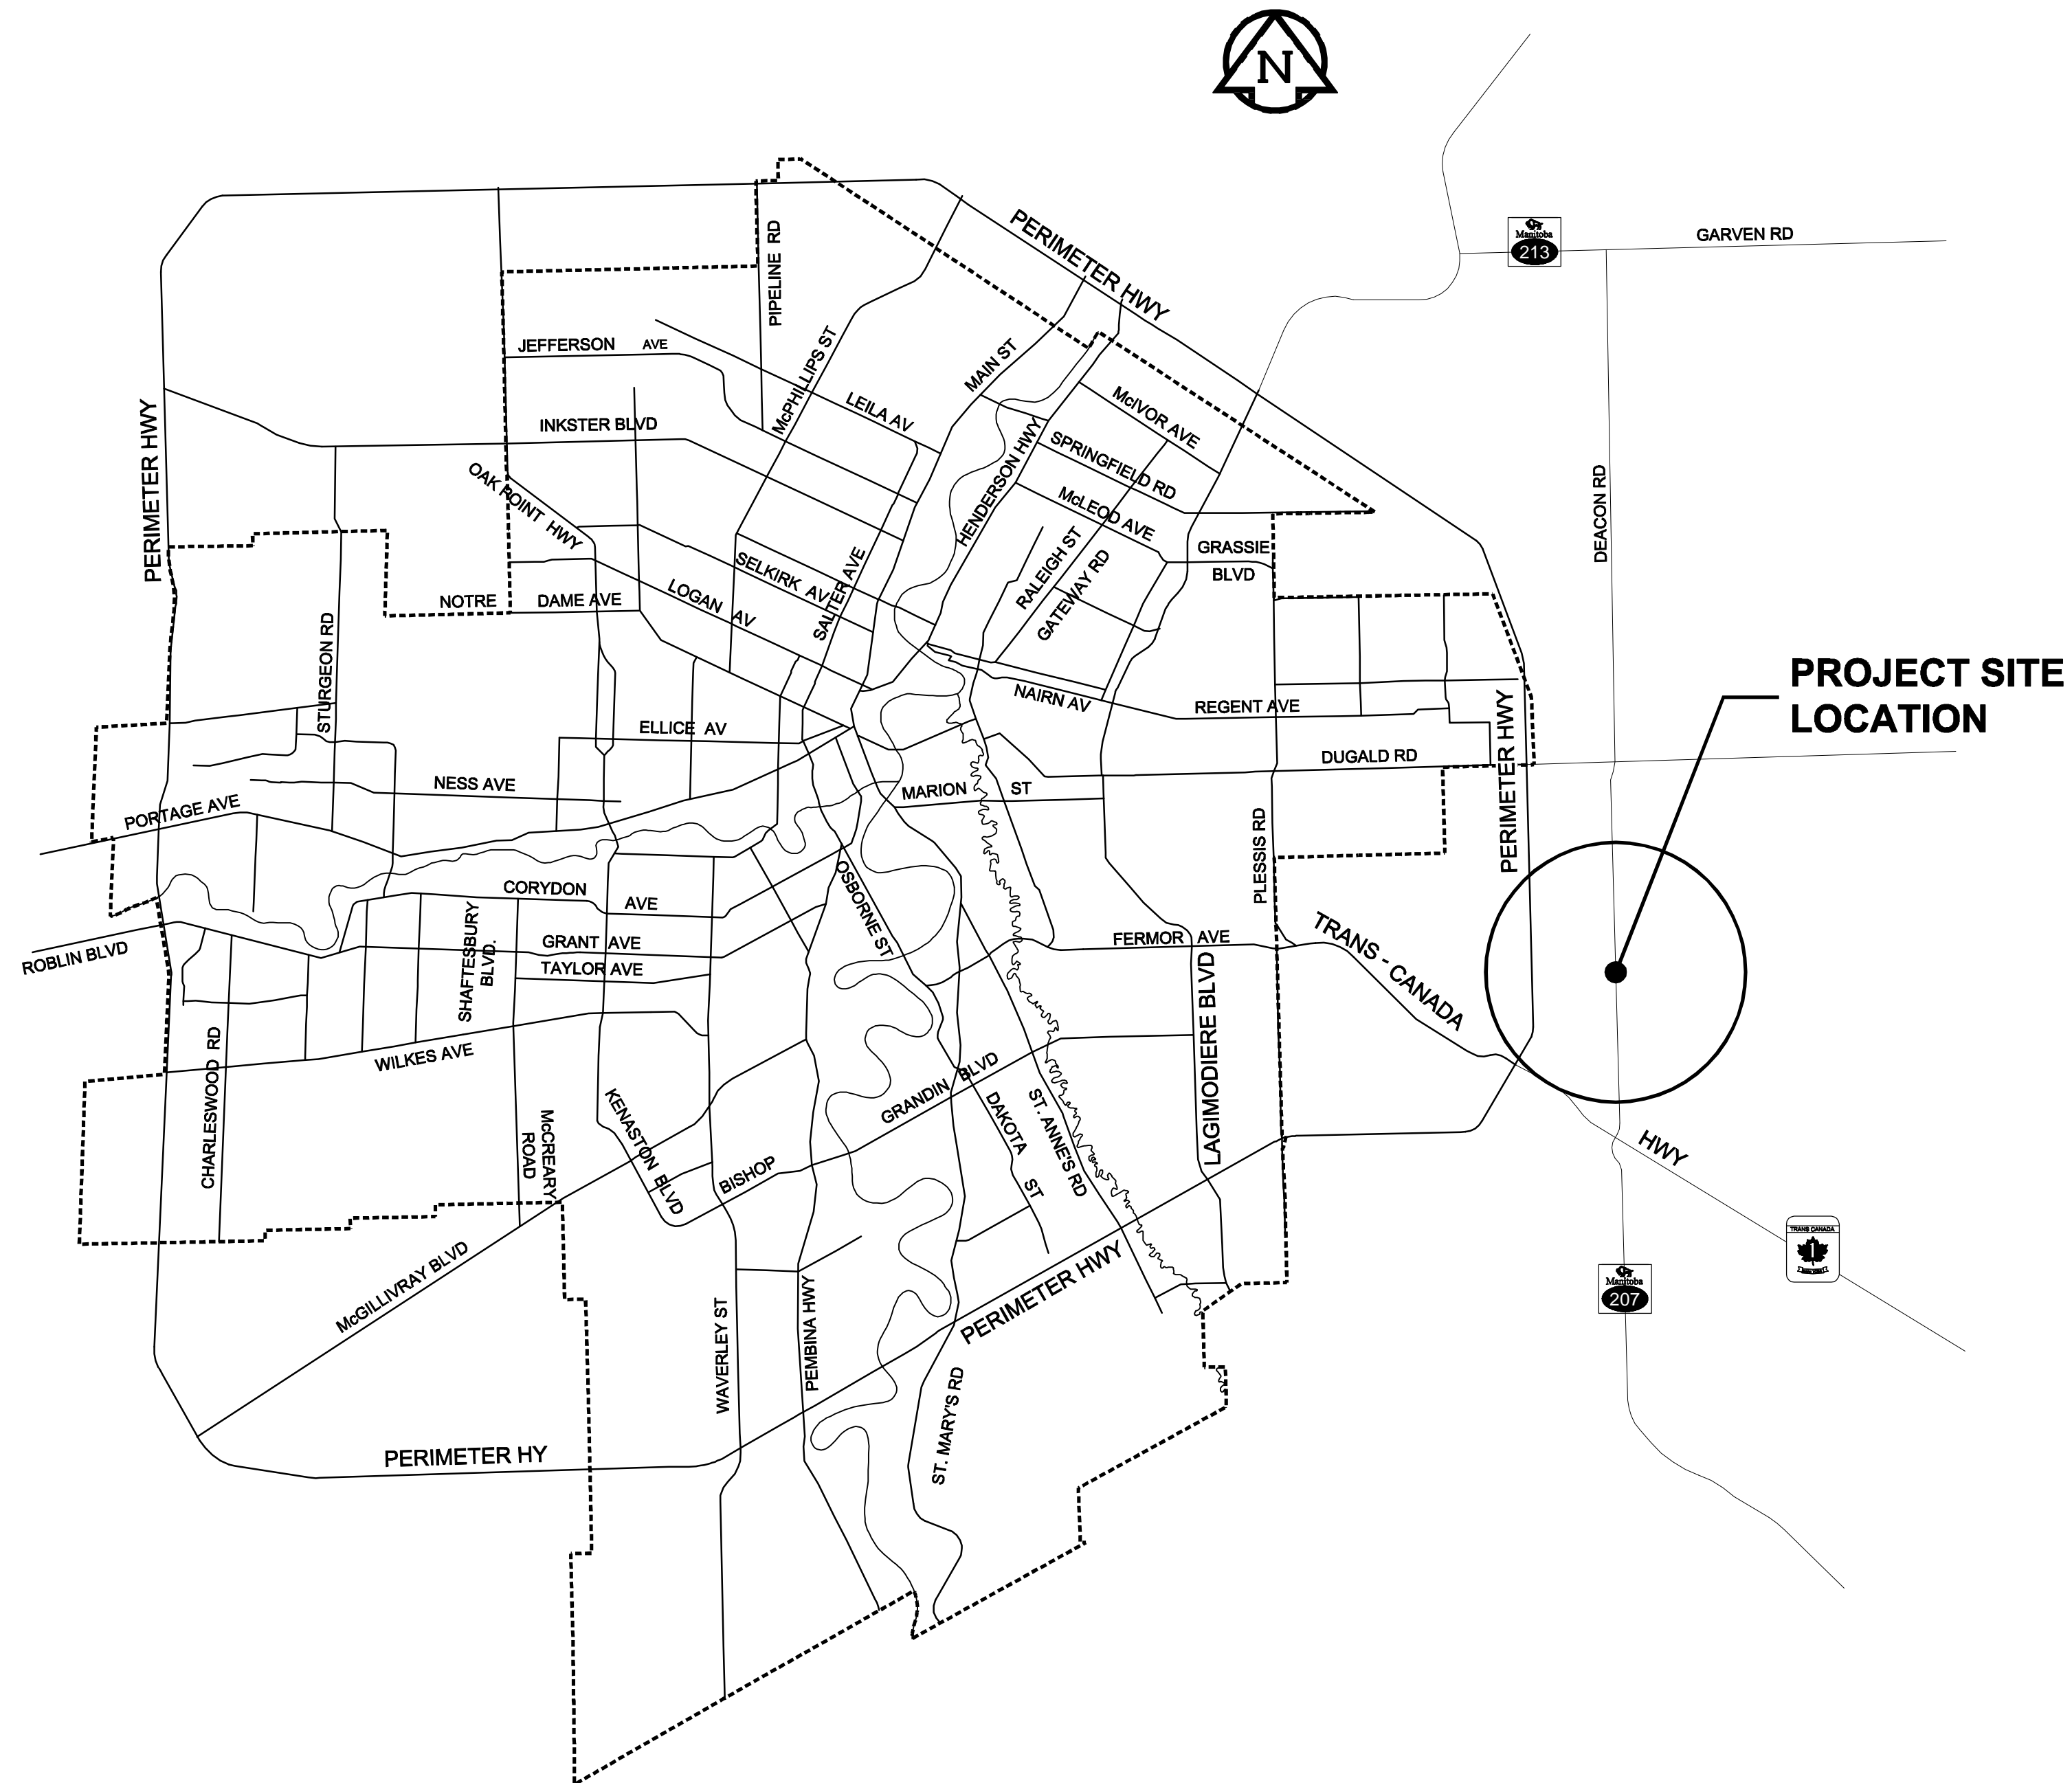

COVER SHEET	
CITY DRAWING NO. 1-0620M-C0001-001	REV 0
CONSULTANT NO. 60195708-00-C-000-R0X.dwg	

No. 4671 Date: \_\_\_\_\_