



NOTES:
SEE NOTES ON SHEET E1.

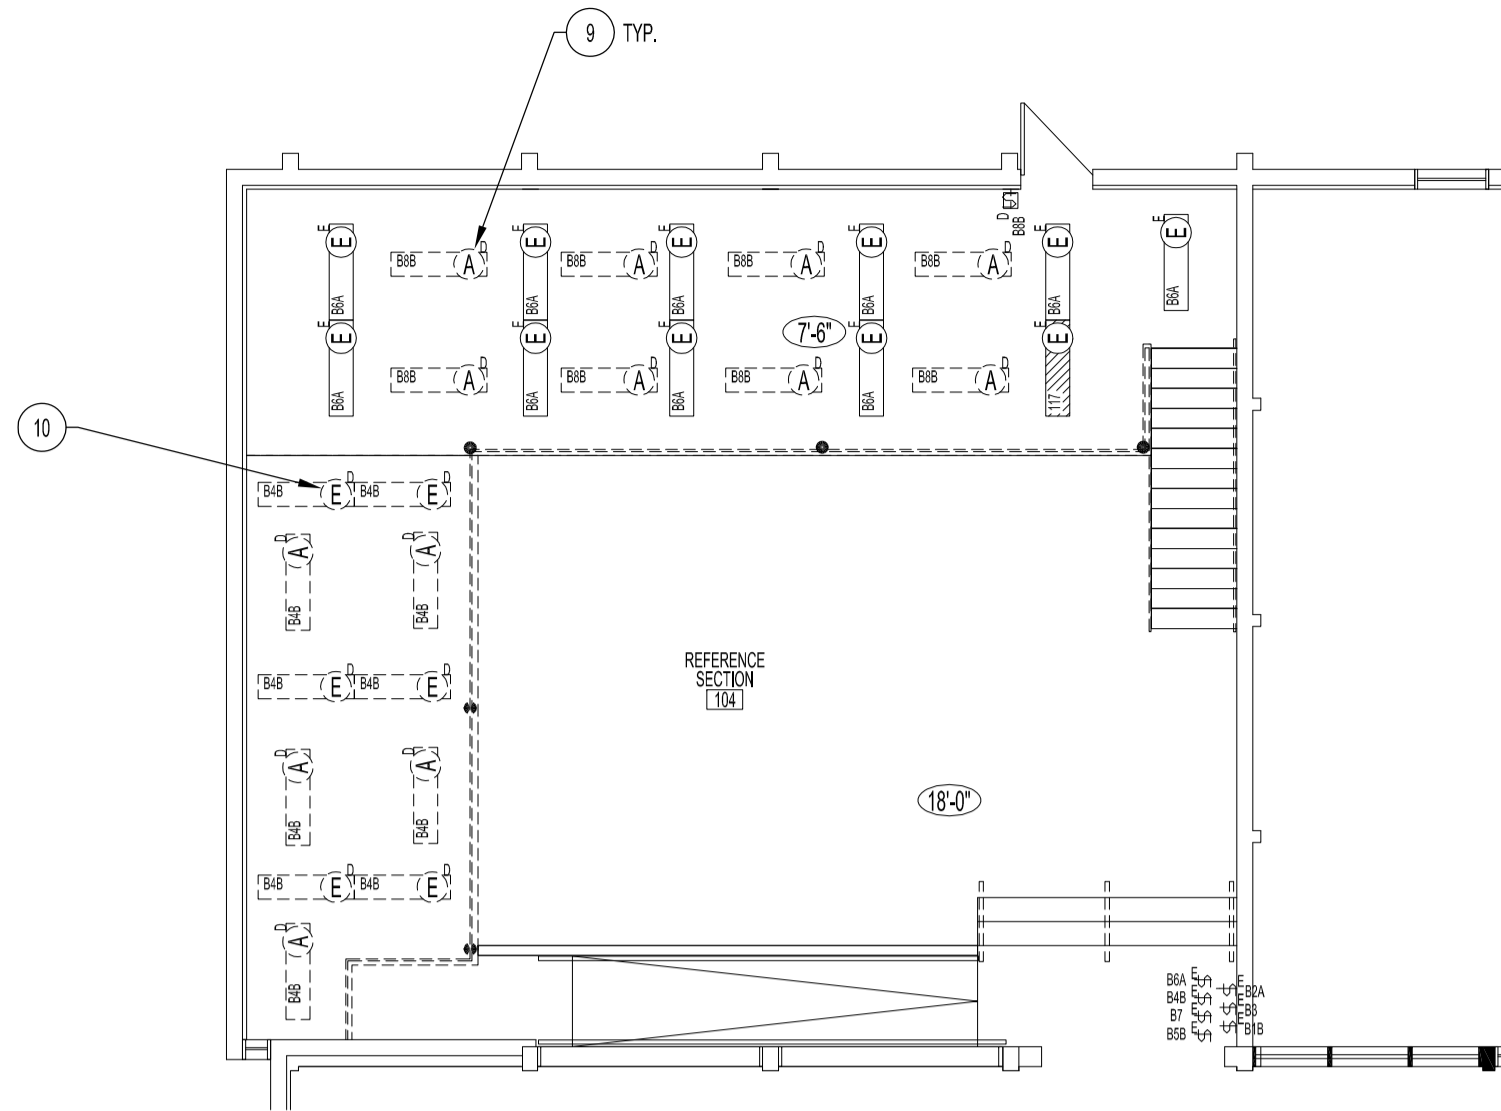

UNDERSIDE MEZZANINE REFLECTED CEILING PLAN - DEMOLITION - ELECTRICAL LIGHTING
SCALE: 1/8"=1'-0"

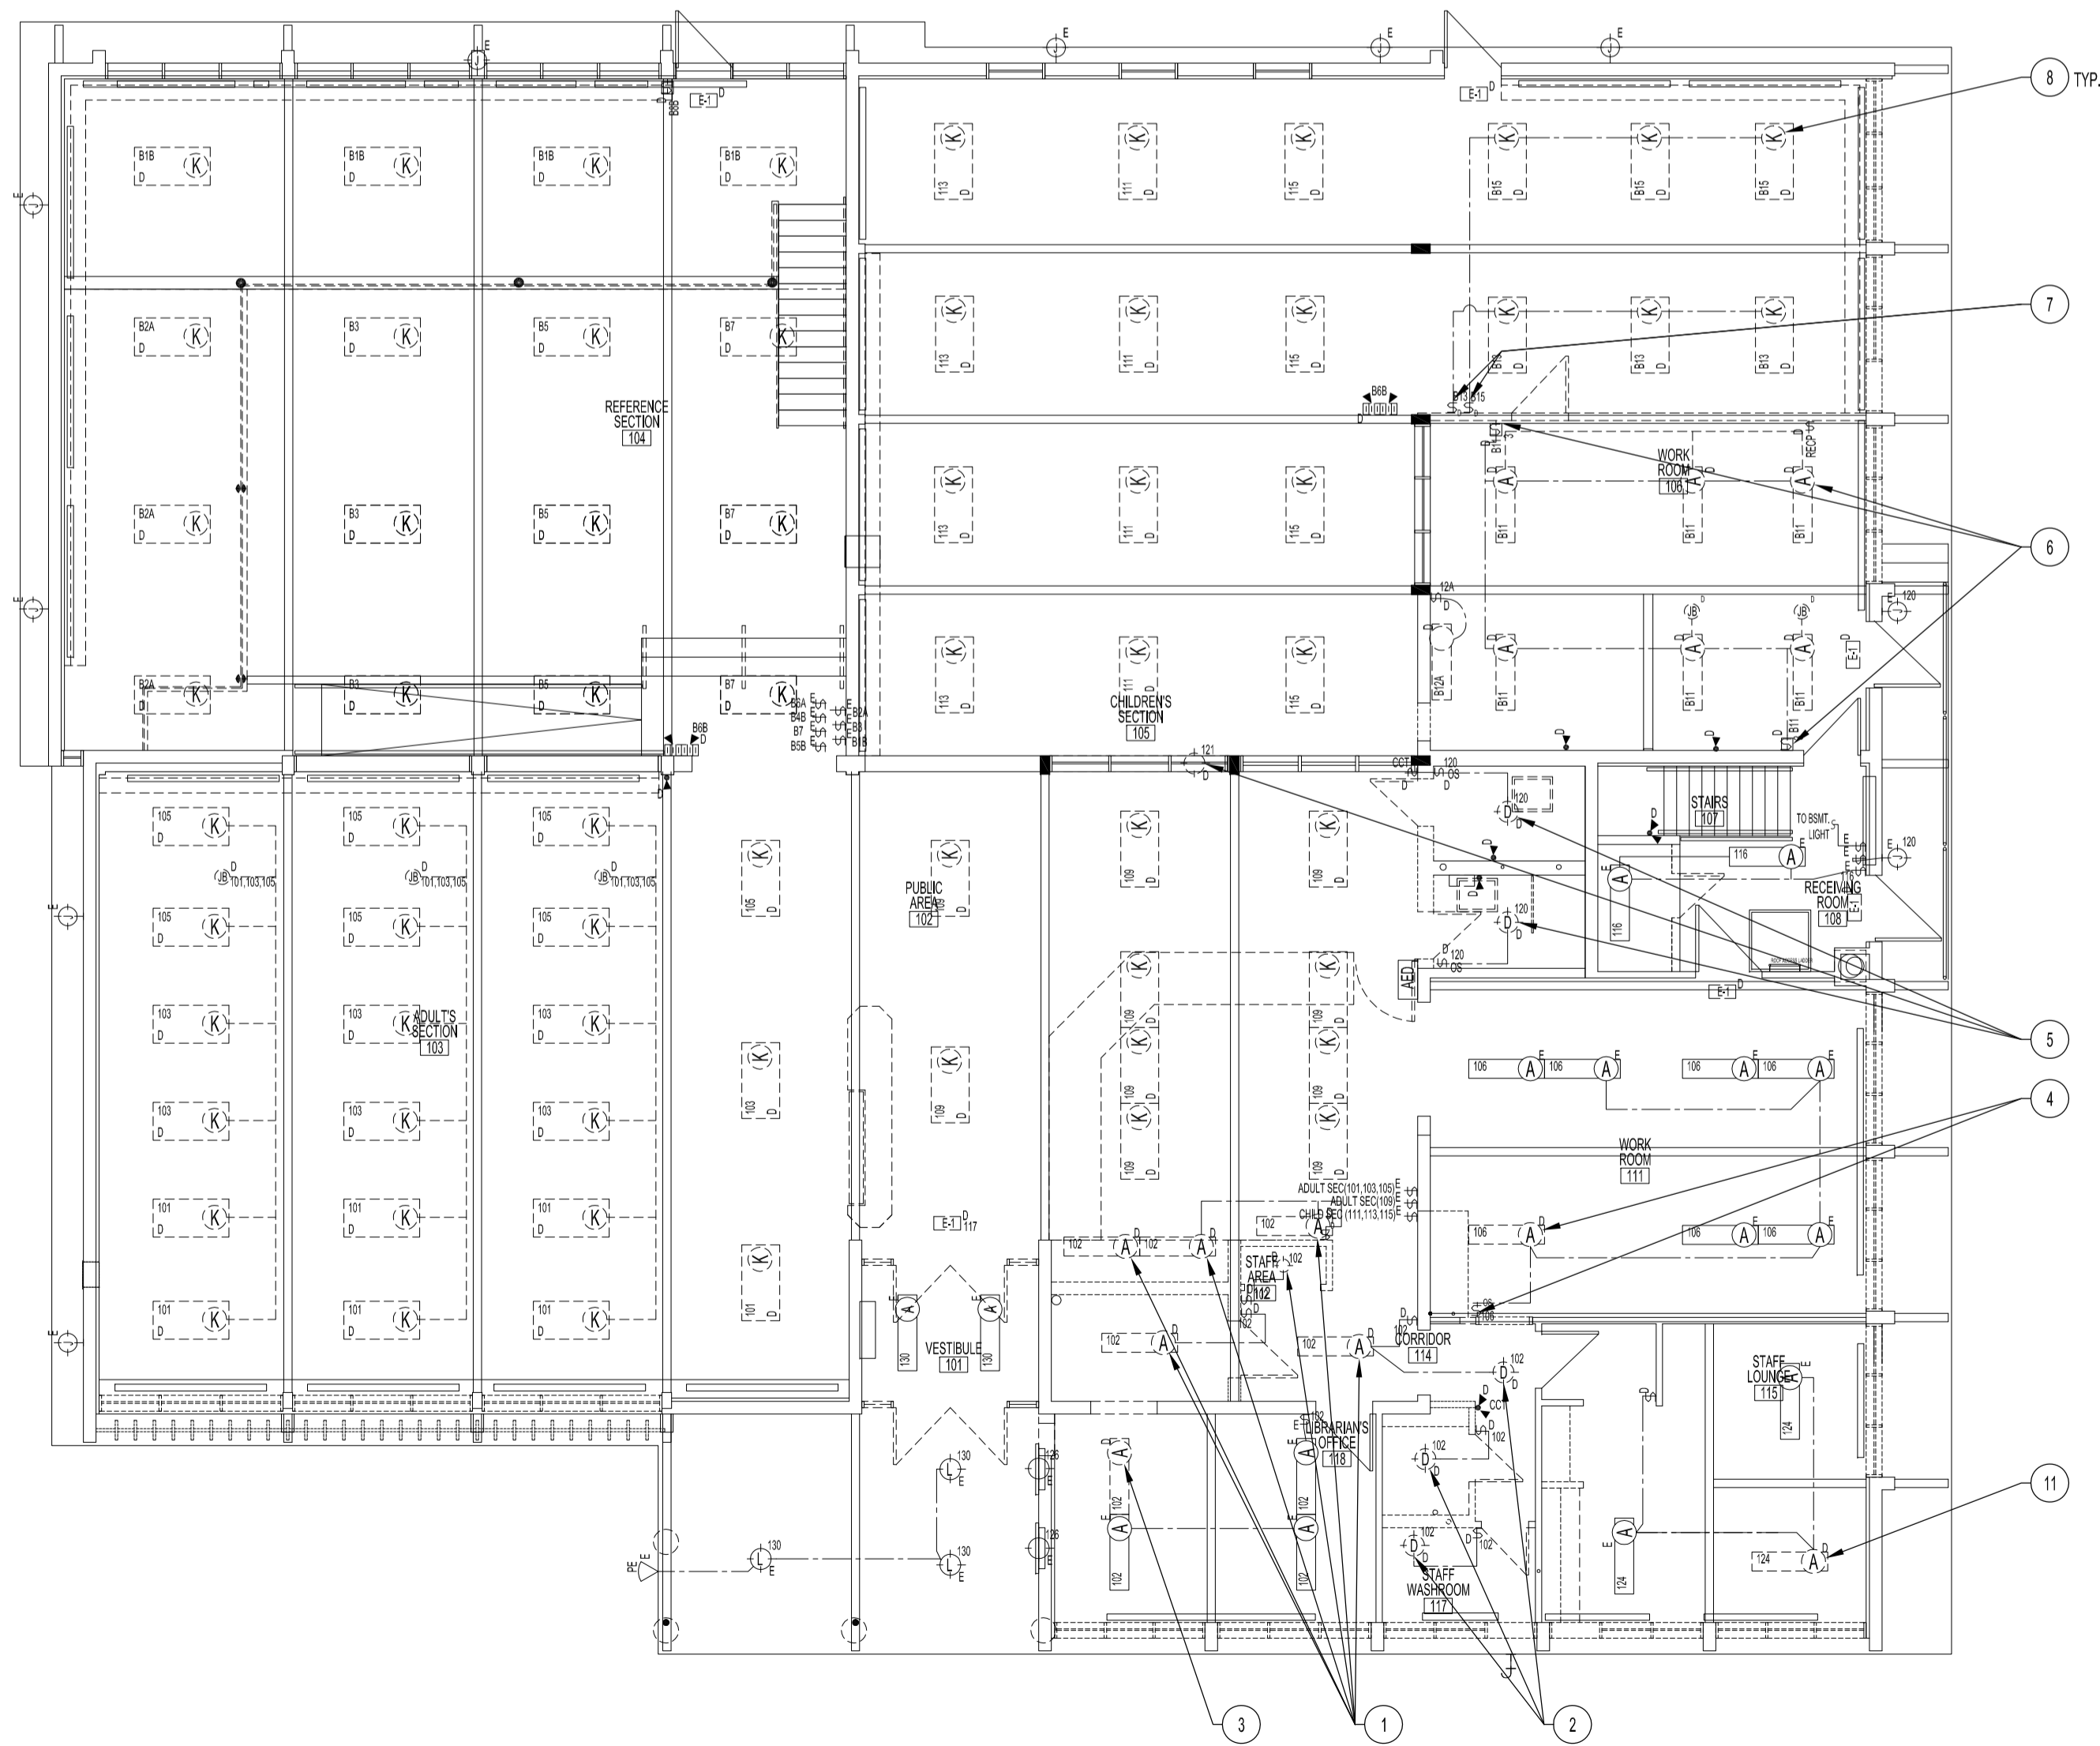

MAIN FLOOR REFLECTED CEILING PLAN - DEMOLITION - ELECTRICAL LIGHTING
SCALE: 1/8"=1'-0"

DEMOLITION NOTES - ELECTRICAL LIGHTING

- TO BE DEMOLISHED
 - EXISTING
1. REMOVE LUMINAIRES, LIGHT SWITCHES & WIRING BACK TO SOURCE.
 2. REMOVE LUMINAIRE FROM WALL & CEILING. LEAVE WIRING IN PLACE TO ACCEPT RELOCATED LUMINAIRES, SEE RENOVATION DRAWING.
 3. RELOCATE LUMINAIRE TO NEW CHUTE ROOM, SEE RENOVATION DRAWING.
 4. RELOCATE LUMINAIRE & LIGHT SWITCH TO NEW JANITOR ROOM. OTHER EXISTING LUMINAIRES IN ROOM TO BE CONNECTED TO NEW OCCUPANCY SENSOR, SEE RENOVATION DRAWING.
 5. EXISTING LUMINAIRE TO BE REPLACED AS SHOWN ON RENOVATION DRAWING. DISCARD EXISTING LUMINAIRE.
 6. REMOVE & RETAIN ALL EXISTING LUMINAIRES IN ROOM. REMOVE WALL SWITCHES.
 7. REMOVE & DISCARD LIGHT SWITCH.
 8. REMOVE & DISCARD TYPE "K" LUMINAIRES. EXISTING WIRING CIRCUITS TO BE REWORKED TO ACCOMMODATE RENOVATION.
 9. REMOVE & DISCARD TYPE "A" LUMINAIRES IN REFERENCE SECTION, INCLUDING WIRING BACK TO SOURCE.
 10. REMOVE & DISCARD TYPE "E" LUMINAIRES IN REFERENCE SECTION WHERE PART OF MEZZANINE IS REMOVED.
 11. ROTATE LUMINAIRE, SEE RENOVATION DRAWING.

No.	REVISION/DESCRIPTION	BY	DATE
SEAL			

DRAWN	CHECKED	DESIGNED	APPROVED
DATE 2012.08.17	USER APPROVAL		

THE CITY OF WINNIPEG
PLANNING, PROPERTY AND
DEVELOPMENT DEPARTMENT
MUNICIPAL ACCOMMODATIONS DIVISION
3-65 GARRY STREET, R3C 4K4

PROJECT
FORT GARRY LIBRARY
INTERIOR & EXTERIOR REFURBISHING

1360 PEMBINA HWY

SHEET TITLE
UNDERSIDE MEZZANINE AND MAIN FLOOR
REFLECTED CEILING PLANS - DEMOLITION
ELECTRICAL LIGHTING

SCALE	PROJECT No:	SHEET No:
AS SHOWN	2011-096-01	E3