



LAST SAVE: 2012/02/17 - 12:52pm
 PATH: M:\112577\0113\4ENG\47ELE\DD - General DWG\1-0102G-E0022-002-00.dwg
 A1 SIZE - 594mm x 841mm

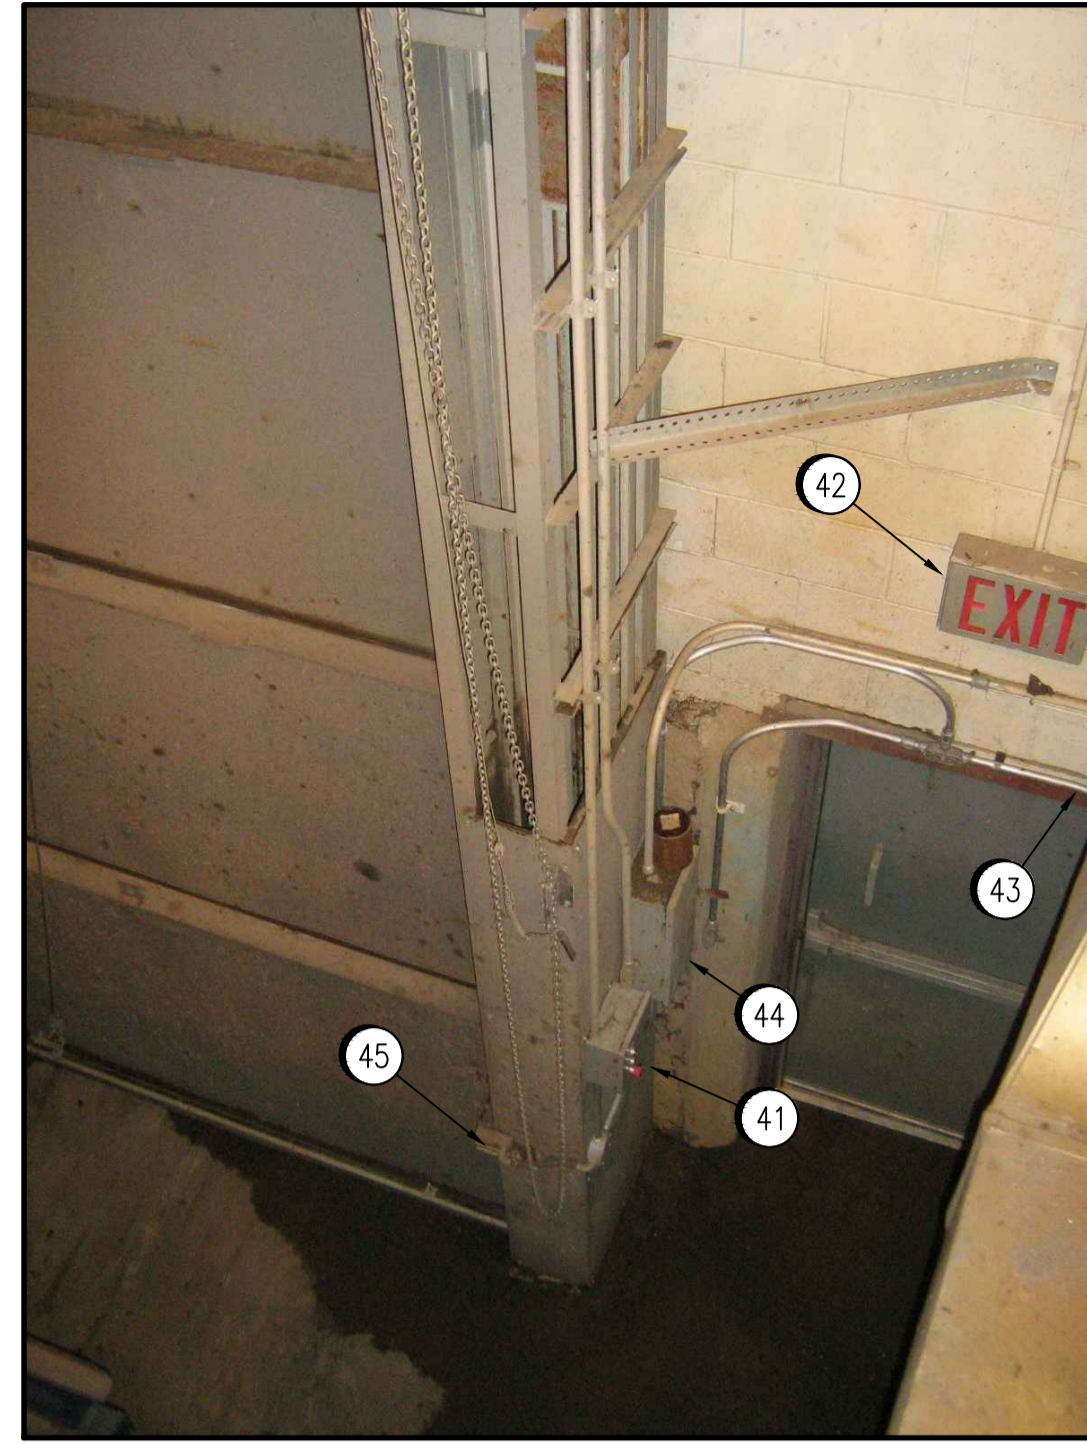


4 DETAIL
SCALE NTS

- 41 REPLACE EXISTING CONTROL STATION, SAFETY EDGE SWITCH AND MISC. FITTINGS.
- 42 REPLACE EXISTING EXIT FIXTURE.
- 43 REPLACE EXISTING DOOR SWITCH (G530-ZSD). SEE DRAWING SEP-2094 FOR WIRING DETAILS. INSTALL EYS SEAL.
- 44 REPLACE EXISTING CIRCUIT BREAKER AND ENCLOSURE. INSTALL EYS SEAL.
- 45 REPLACE EXISTING DOOR SWITCH (G534-ZSD). SEE DRAWING SEP-2094 FOR WIRING DETAILS. INSTALL EYS SEAL.

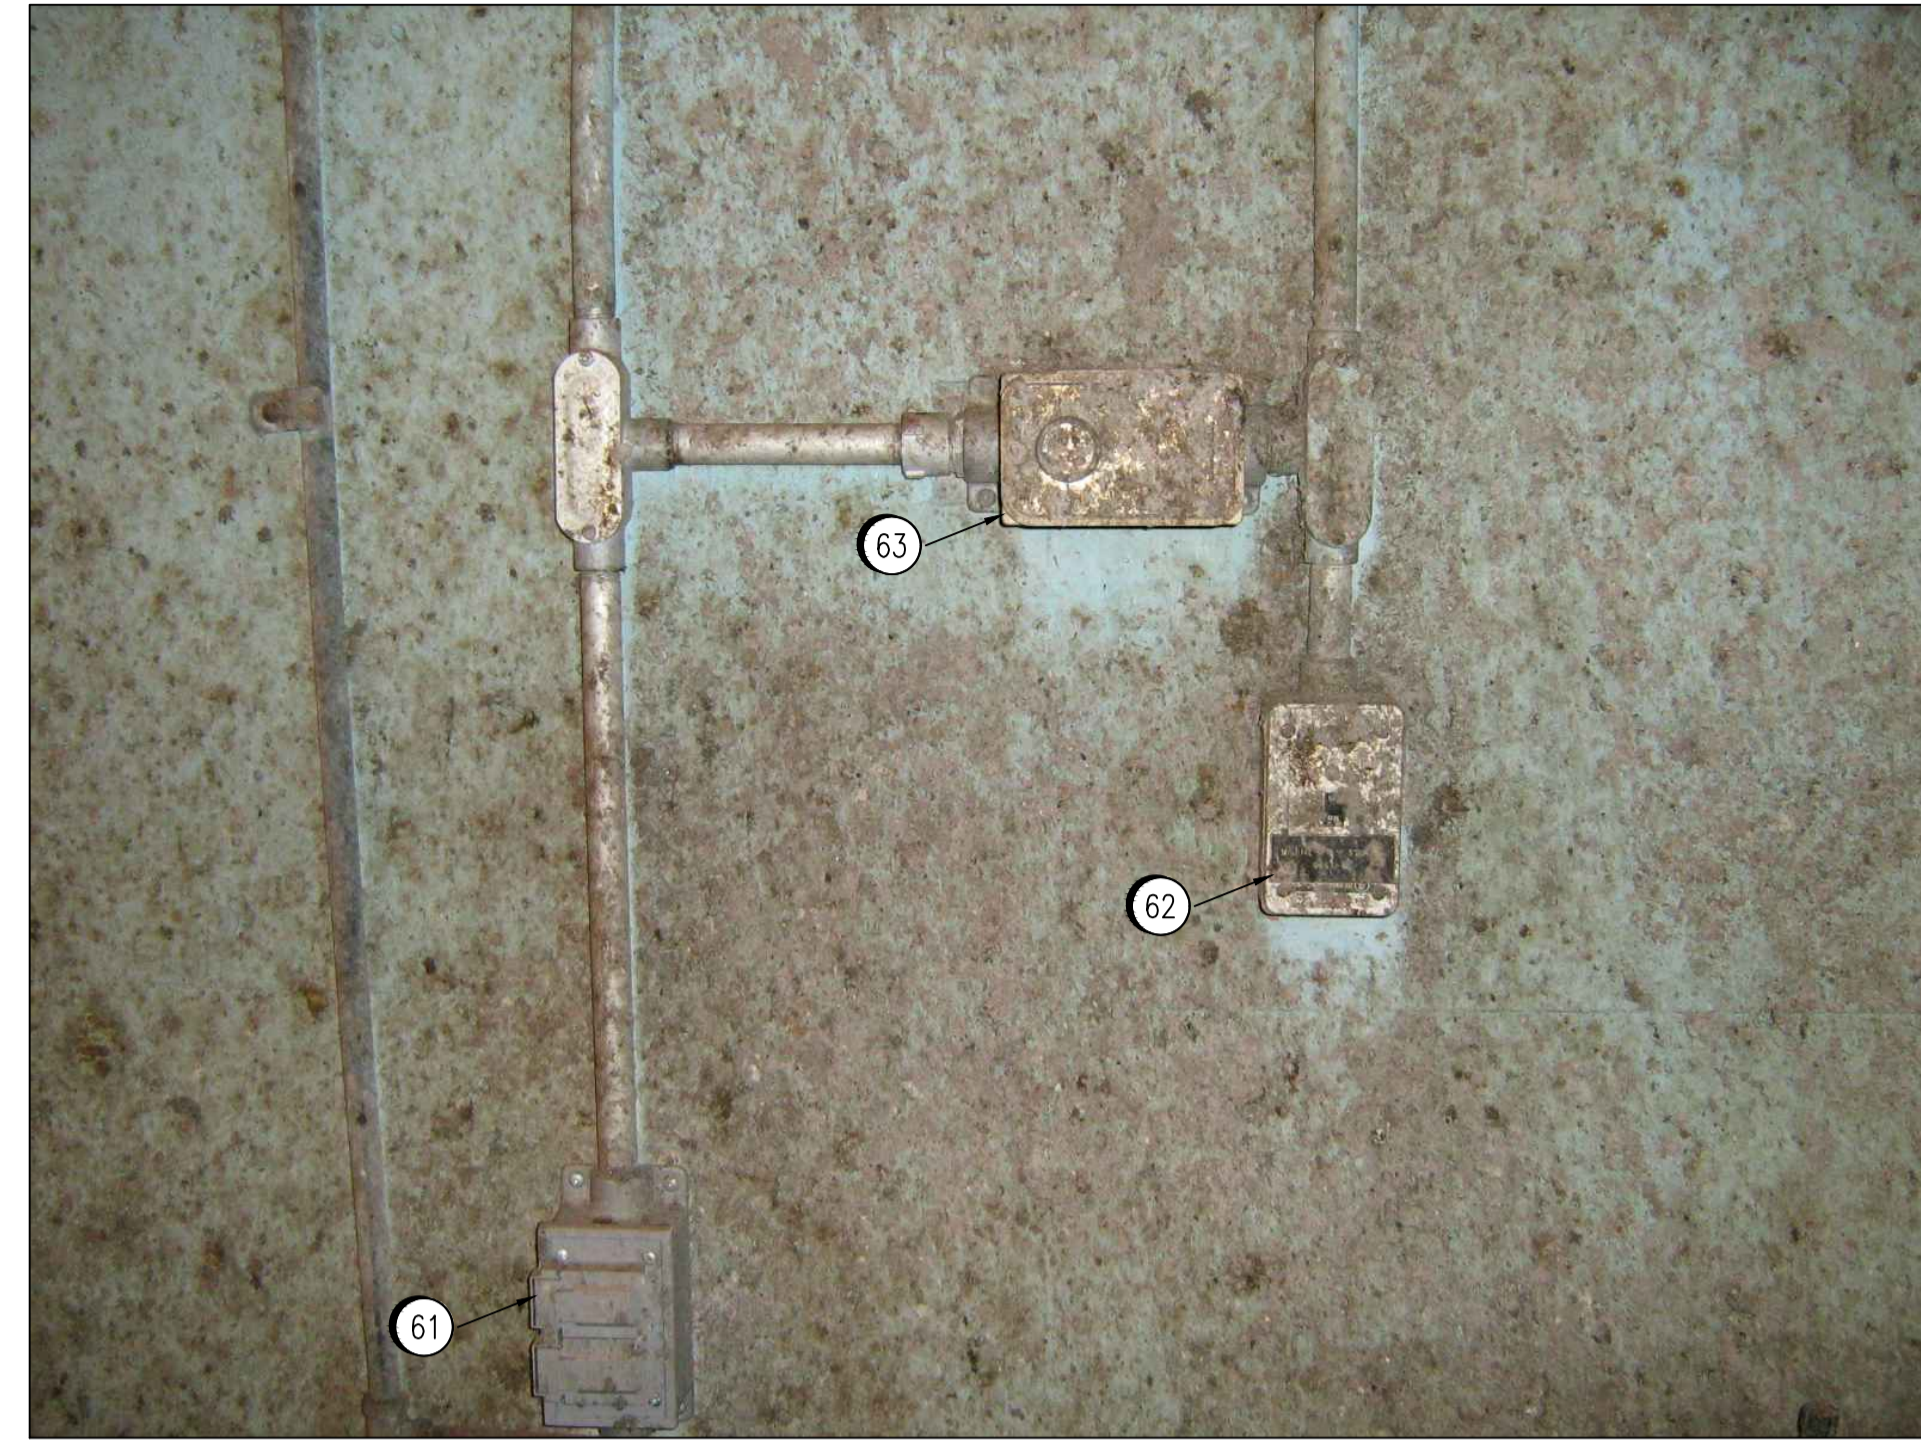


6 DETAIL
SCALE NTS

- 61 REPLACE EXISTING 15A, 120V RECEPTACLE AND BOX. TYPICAL FOR THREE IN TRUCK BAY.
- 62 REPLACE EXISTING MANUAL STARTER.
- 63 REPLACE EXISTING LINE THERMOSTAT. INSTALL EYS SEAL IN EXISTING CONDUIT AND WIRE RUN.

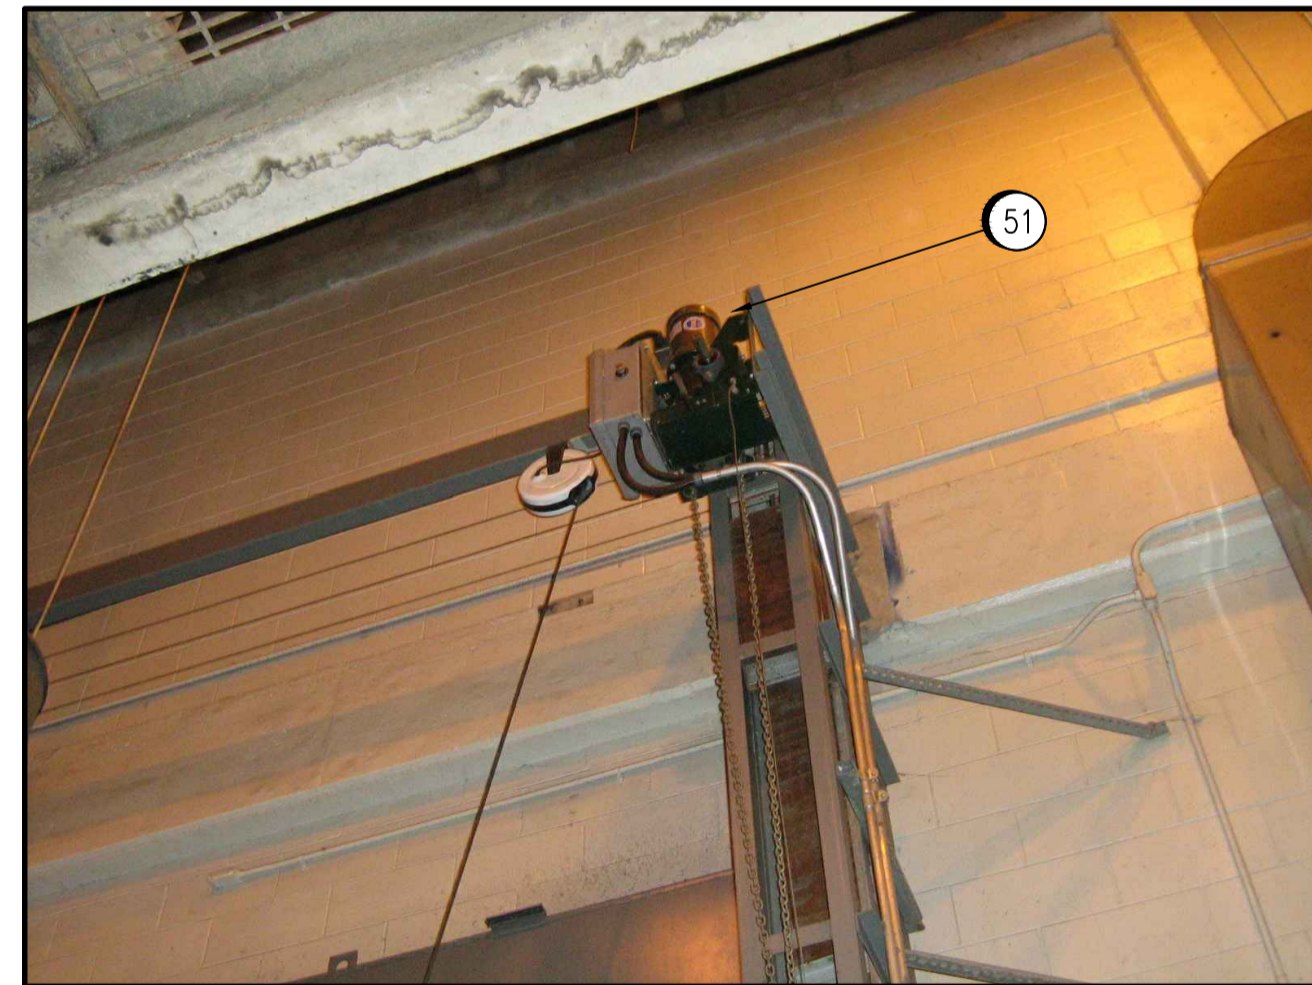

5 DETAIL
SCALE NTS

- 51 REPLACE EXISTING MOTOR, DOOR OPERATOR AND CORD REEL WITH HAZARDOUS RATED UNIT.

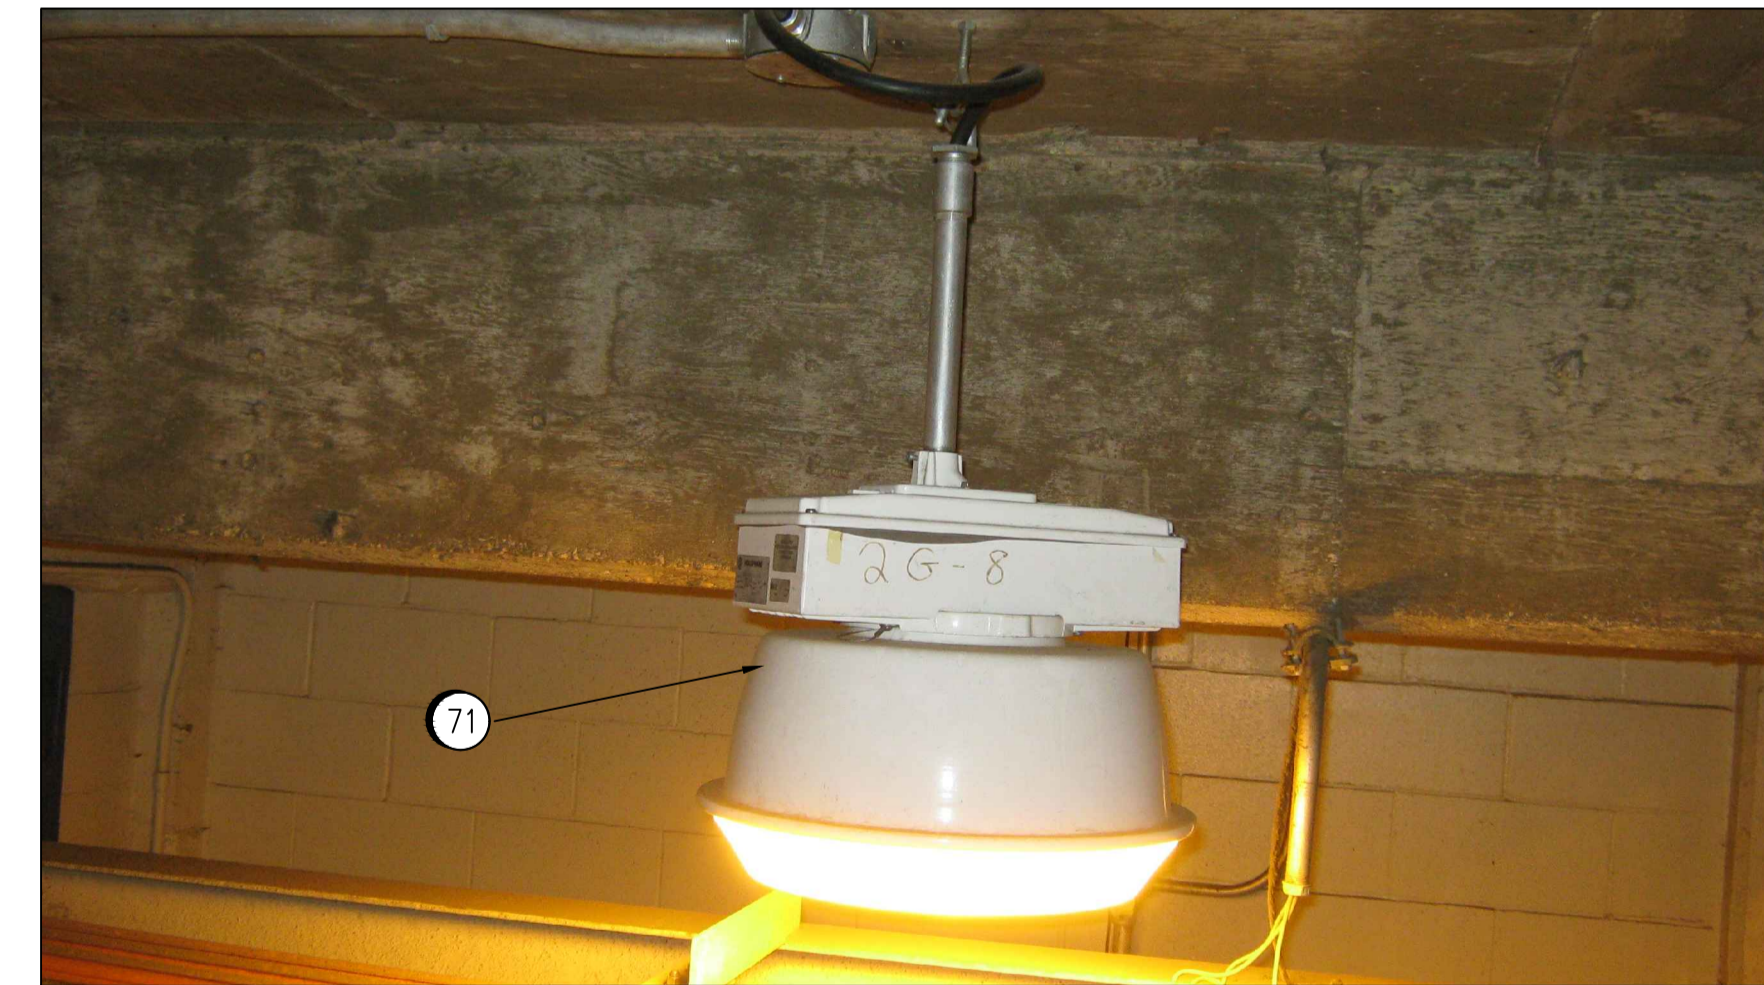


7 DETAIL
SCALE NTS

- 71 REPLACE EXISTING LUMINAIRE WITH TYPE AS INDICATED. SEE INSTALLATION DETAIL ON 1-0102G-E0011.

1-0102A-E0010	TYPICAL INSTALLATION DETAILS.
1-0102A-E0009	DEVICE AND LUMINAIRE SCHEDULE.
1-0102G-E0014	ELECTRICAL CLASSIFICATION PLAN
DRAWING NUMBER	REFERENCE DRAWINGS


 Certificate of Authorization
SNC-Lavalin Inc.
 No. 4489


NO.	REVISIONS	DATE	DESIGN	CHECK
00	ISSUED FOR TENDER, BID OPP. 7-2012	2012/02/08	TMC	CJR


SNC-LAVALIN INC.
 148 Nature Park Way
 Winnipeg, MB, Canada R3P 0X7
 204-786-8080

DESIGNED BY: T. CHURCH	CHECKED BY: C. REIMER
DRAWN BY: S. FUNK	APPROVED BY: C. REIMER
SCALE: NTS	RELEASED FOR CONSTRUCTION BY: N. HARRINGTON
DATE: 2011/07/06	DATE: 2012/02/15
CONSULTANT NO.: 112577-0113-47DD-0205	

ENGINEER'S SEAL

 ORIGINAL DRAWING
 SEALED BY:
 T. M. CHURCH
 SNC-LAVALIN
 MEMBER #32682
 2012/02/15
 REV. 00


THE CITY OF WINNIPEG
 WATER AND WASTE DEPARTMENT

SOUTH END WATER POLLUTION CONTROL CENTRE
 ELECTRICAL CLASSIFICATION UPGRADES
 PLAN LAYOUT
 PUMP & SCREEN BUILDING - TRUCK LOADING BAY G122

CITY DRAWING NUMBER	SHEET	REV.	SIZE
1-0102G-E0022	002	00	A1