





THE CITY OF WINNIPEG WATER AND WASTE DEPARTMENT

WATER TREATMENT PLANT PROTECTED CONNECTIONS BID OPPORTUNITY NO. 708-2012

LIST OF PROJECT DRAWINGS

CITY DRAWING NUMBER	CONSULTANT DRAWING NUMBER	DESCRIPTION
1-0601M-D0004-001	01-G-000	Water Treatment Plant Protected Connections - Cover Sheet
1-0601Y-C0055-001	01-C-101	Water Treatment Plant Protected Connections - Civil - Site Plan
1-0620M-C0008-001	01-C-102	Deacon Culvert Rehabilitation - Civil - Cell 1 Dewatering Pump Station - Grading Plan
1-0601Y-C0056-001	01-C-103	Water Treatment Plant Protected Connections - Civil - Valve Chamber FV-Y304A - Plans & Sections
1-0601Y-C0057-001	01-C-104	Water Treatment Plant Protected Connections - Civil - Valve Chamber HV-Y410C - Plan, Elevations & Sections
1-0601Y-C0058-001	01-C-105	Water Treatment Plant Protected Connections - Civil - Chlorine Contact Chamber - Plan, Elevations & Sections
1-0601Y-S0022-001	01-S-101	Water Treatment Plant Protected Connections - Structural - Chlorine Contact Chamber - Plan, Elevations, Sections & Details
1-0620M-S0001-001	01-S-102	Deacon Culvert Rehabilitation - Structural - Cell 1 Dewatering Pump Station - Sections & Details
1-0620M-E0001-001	01-E-101	Deacon Culvert Rehabilitation - Electrical - Cell 1 Dewatering Pump Station - Details
1-0601Y-E0011-001	01-E-102	Water Treatment Plant Protected Connections - Electrical - Valve Chamber HV-Y304A

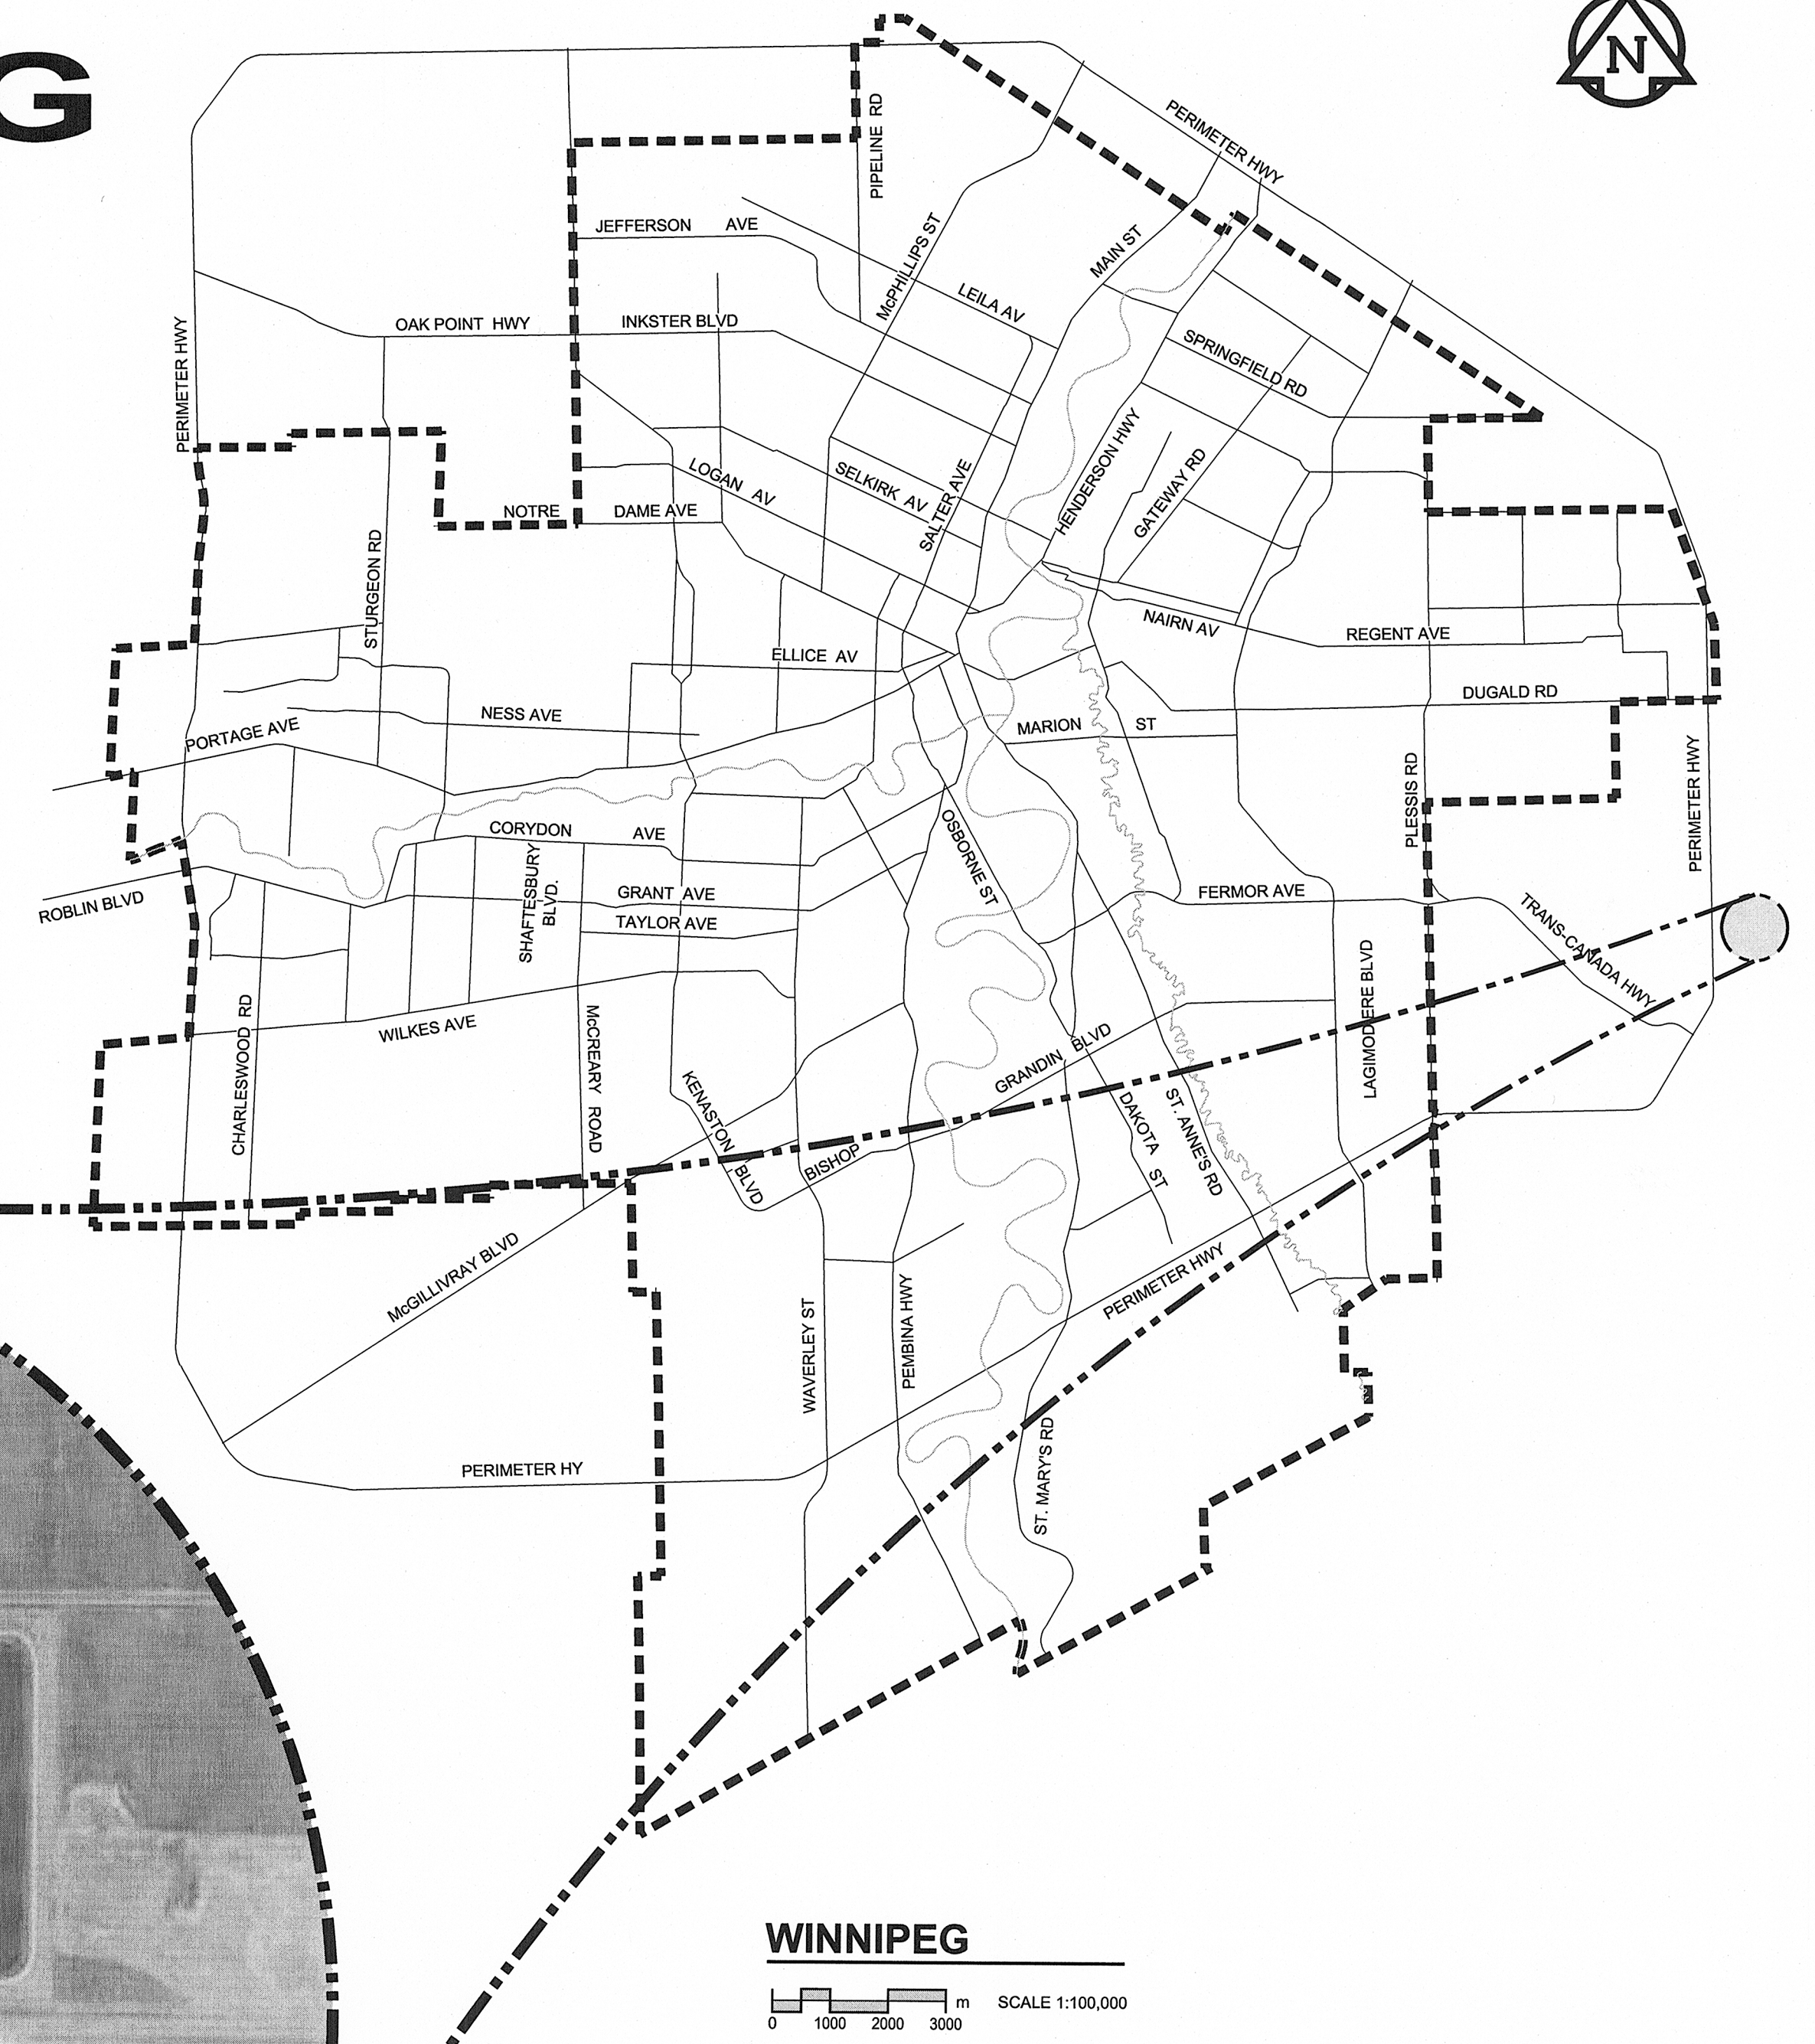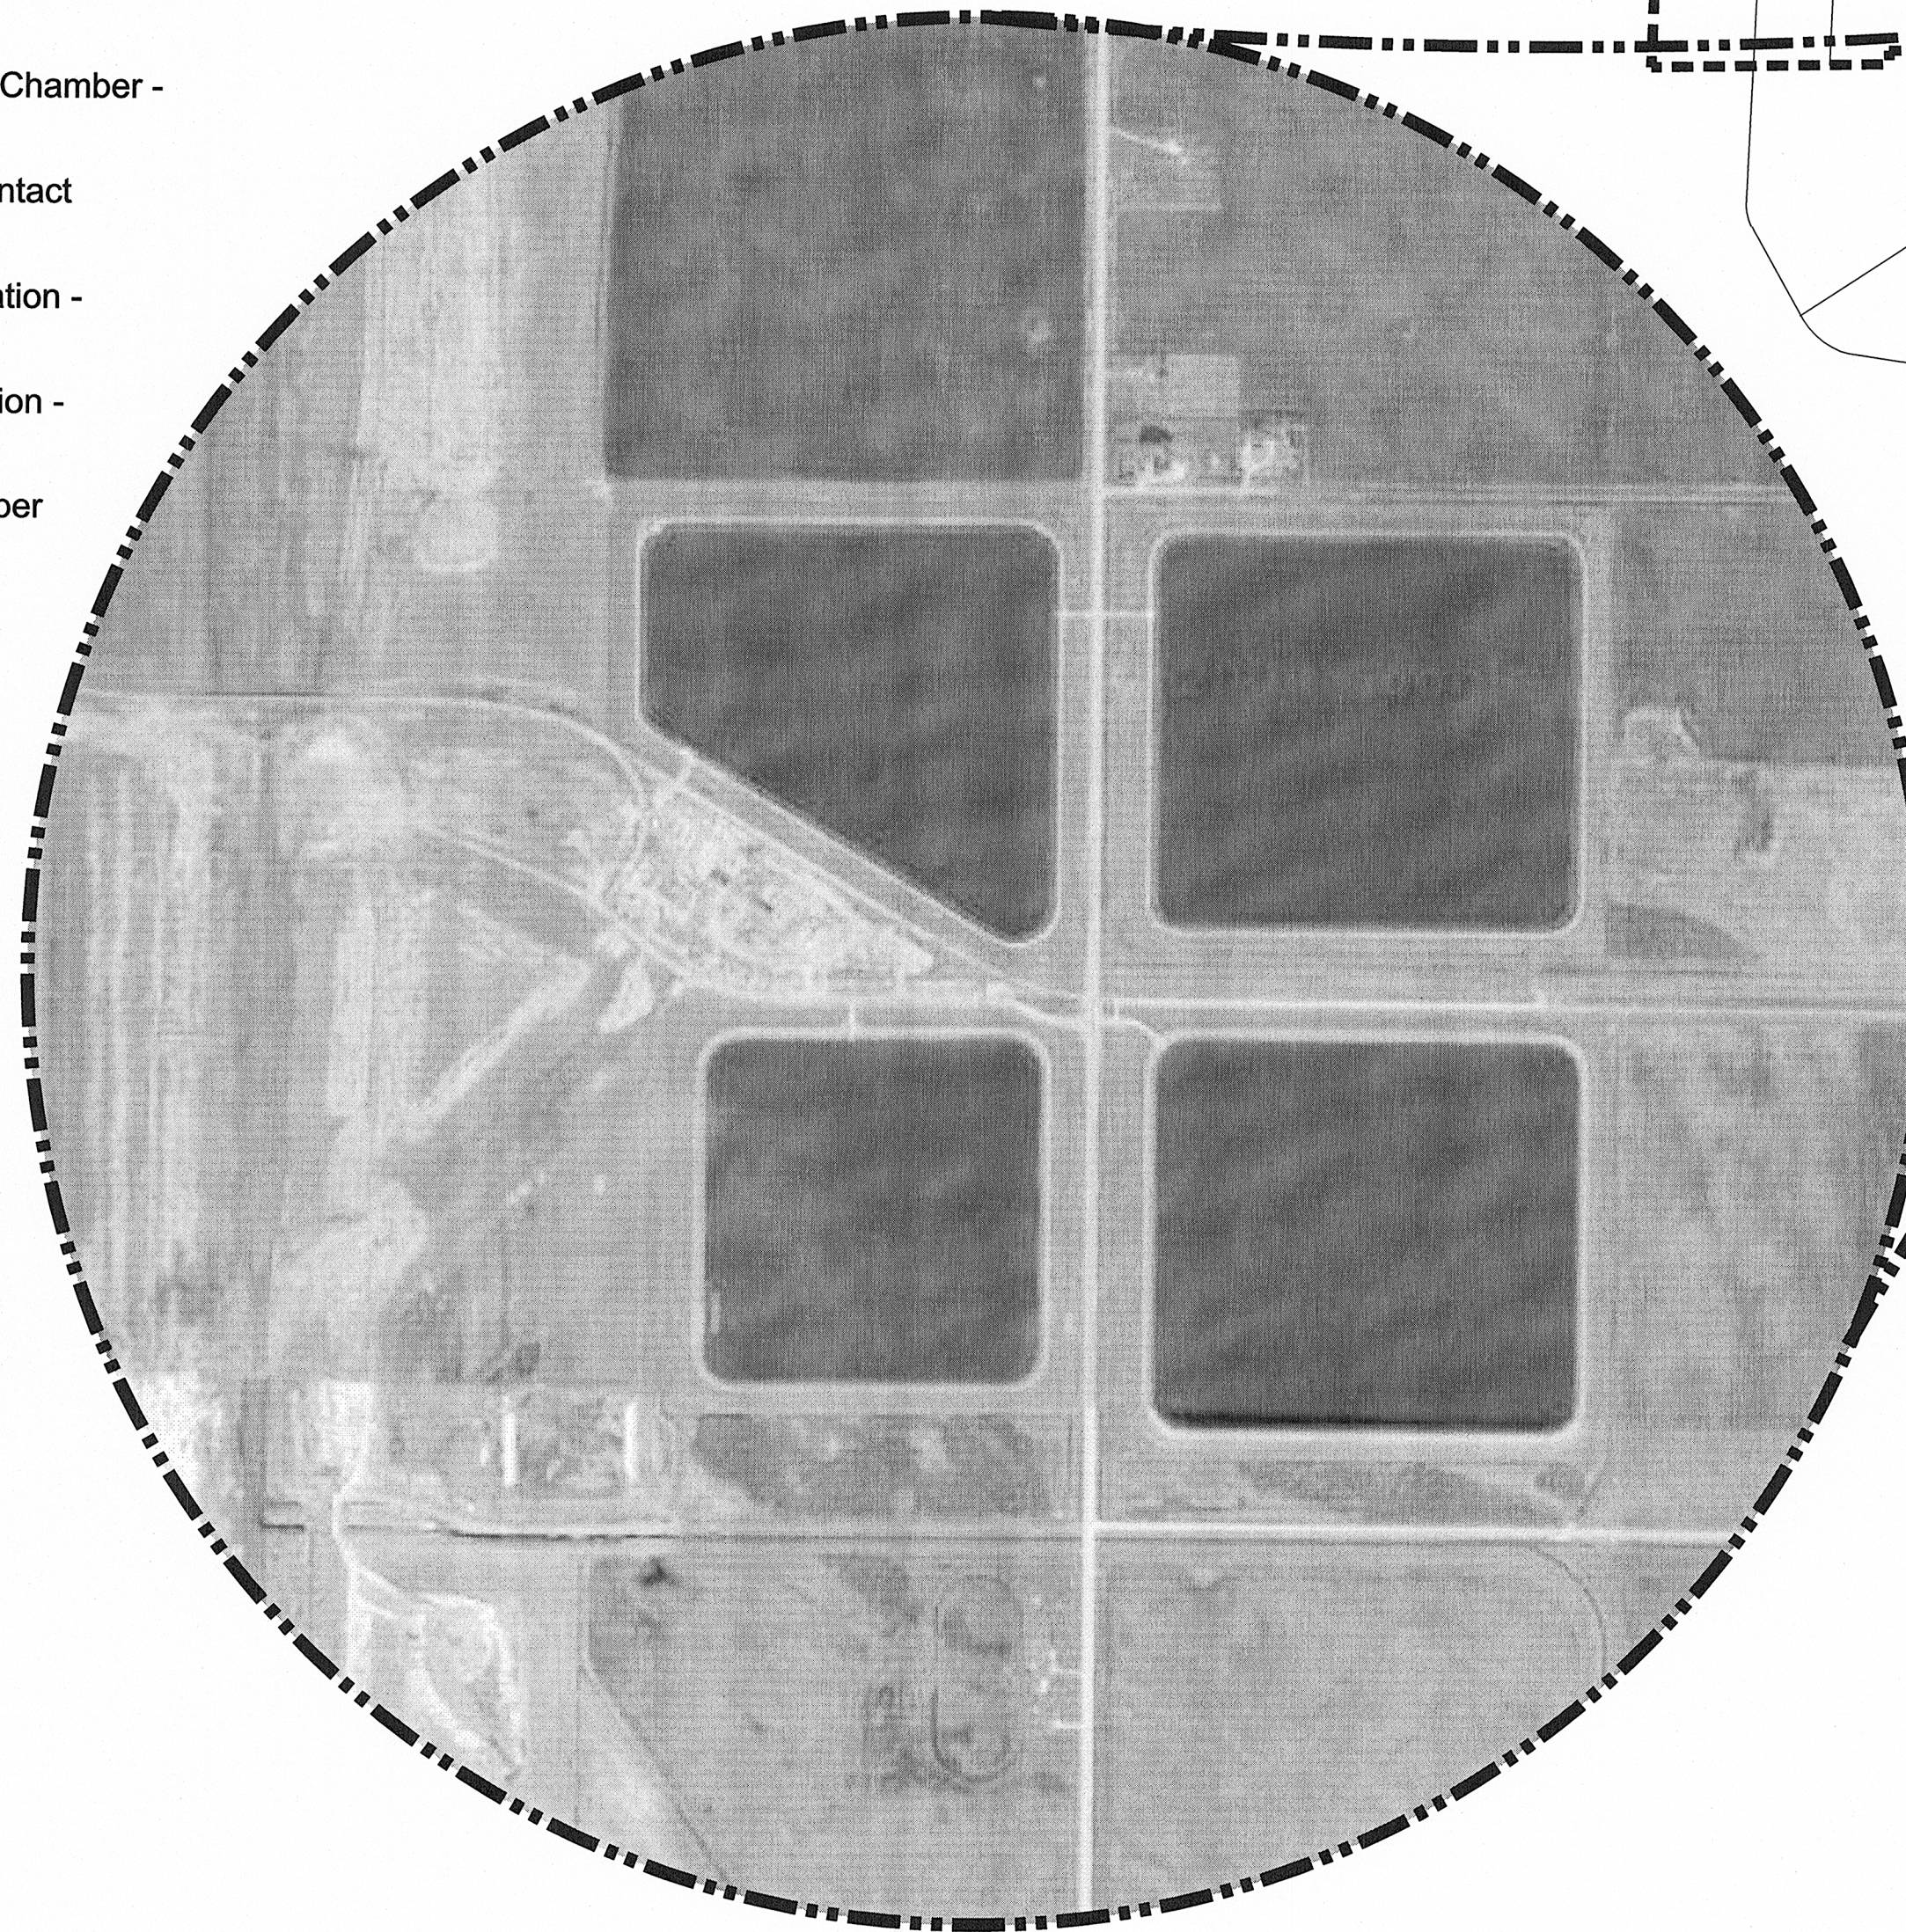

WINNIPEG
SCALE 1:100,000
0 1000 2000 3000 m