
 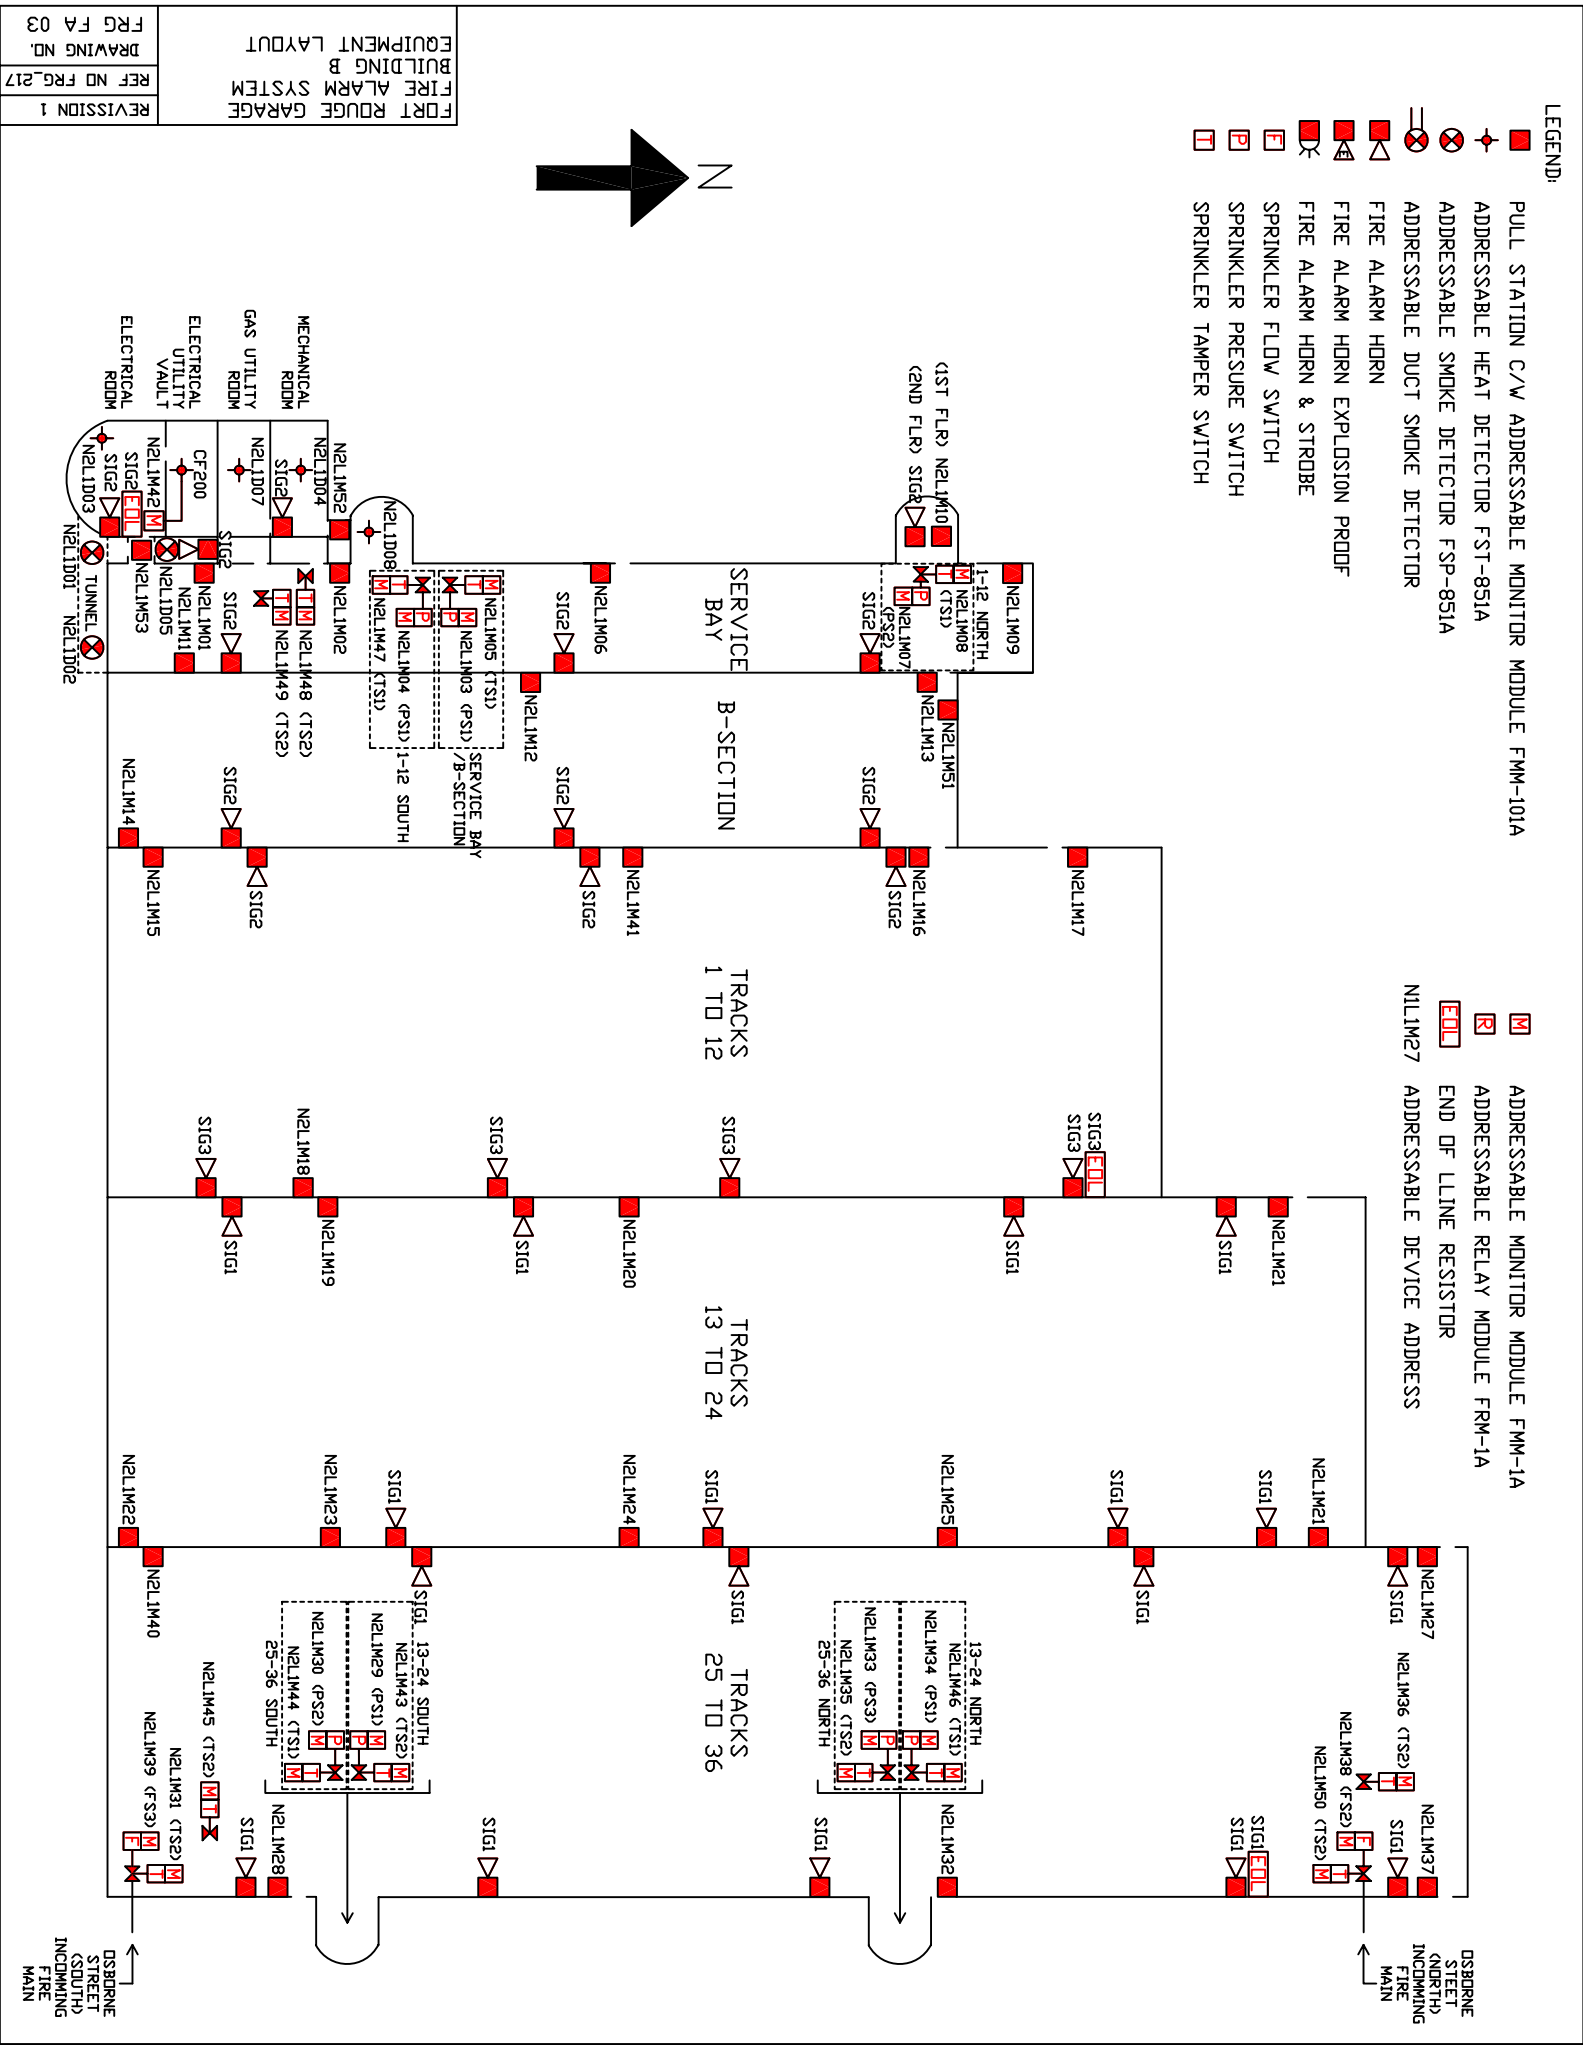


LEGEND:

- PULL STATION C/W ADDRESSABLE MONITOR MODULE FMM-101A
- ADDRESSABLE HEAT DETECTOR FST-851A
- ADDRESSABLE SMOKE DETECTOR FSP-851A
- ADDRESSABLE DUCT SMOKE DETECTOR
- FIRE ALARM HORN
- FIRE ALARM HORN EXPLOSION PROOF
- FIRE ALARM HORN & STROBE
- SPRINKLER FLOW SWITCH
- SPRINKLER PRESURE SWITCH
- SPRINKLER TAMPER SWITCH
- ADDRESSABLE MONITOR MODULE FMM-1A
- ADDRESSABLE RELAY MODULE FRM-1A
- END OF LINE RESISTOR
- ADDRESSABLE DEVICE ADDRESS



REVISION 1
 REF NO FRG_217
 DRAWING NO. FRG FA 03

FORT ROUGE GARAGE
 FIRE ALARM SYSTEM
 BUILDING B
 EQUIPMENT LAYOUT

DSBORNE STREET (SOUTH) INCOMING FIRE MAIN