


SYMBOL QUANT. DESCRIPTION

A_	9	SPRINKLER RISER - GRINNELL 6" MODEL A
B_	3	SPRINKLER RISER - GRINNELL 8" MODEL A
C_	2	SPRINKLER RISER - RELIABLE 6" MODEL E
D_	3	FLOW SWITCH - PADDLE TYPE
E_	3	GLYCAL SRPINKLER SYSTEM
F_	2	FIRE HOSE
G_	10	WATER GONG
H_	4	WALL HYDRANT - McAVITY
J_	3	UNDERGROUND VALVE PIT

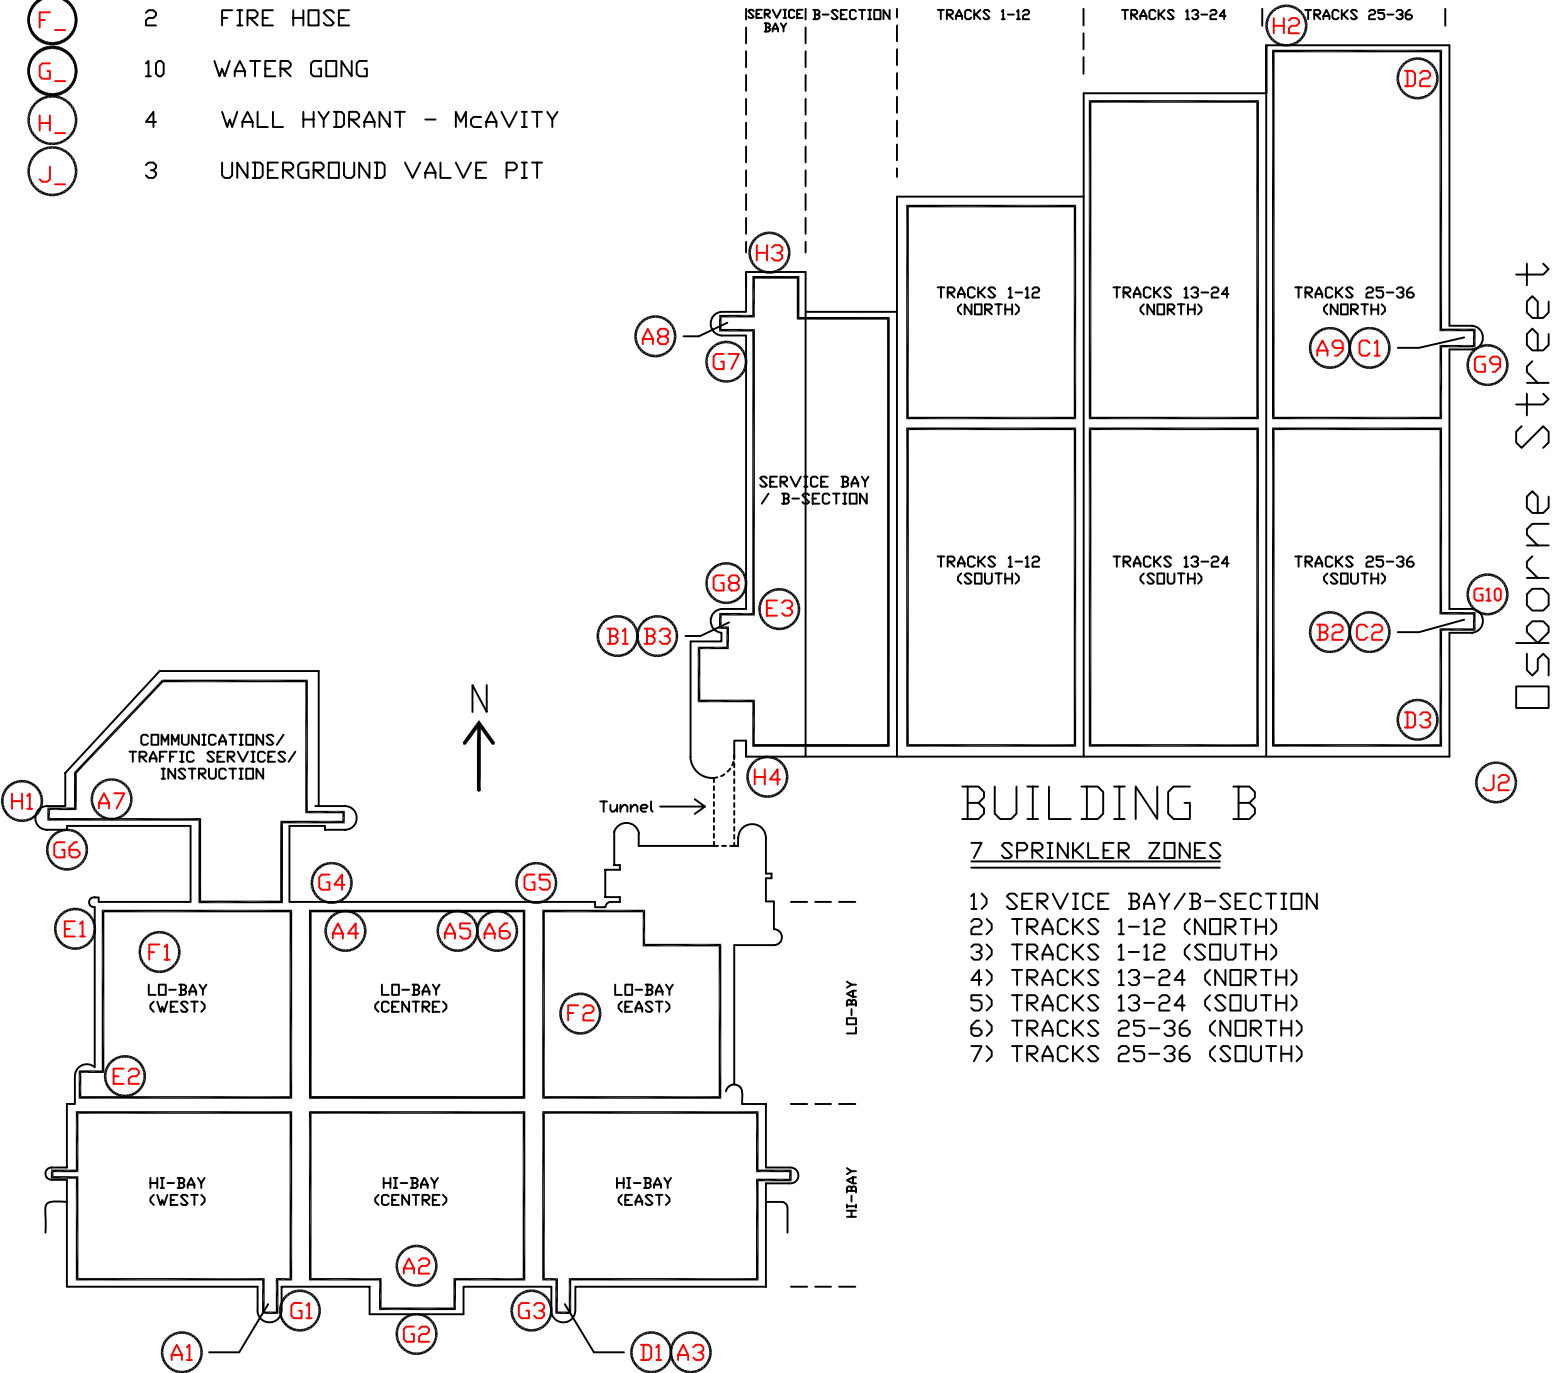

BUILDING B

7 SPRINKLER ZONES

- 1) SERVICE BAY/B-SECTION
- 2) TRACKS 1-12 (NORTH)
- 3) TRACKS 1-12 (SOUTH)
- 4) TRACKS 13-24 (NORTH)
- 5) TRACKS 13-24 (SOUTH)
- 6) TRACKS 25-36 (NORTH)
- 7) TRACKS 25-36 (SOUTH)

BUILDING A

7 SPRINKLER ZONES

- 1) COMMUNICATIONS/TRAFFIC SERVICES/INSTRUCTION
- 2) LO-BAY (WEST)
- 3) LO-BAY (CENTRE)
- 4) LO-BAY (EAST)
- 5) HI-BAY (WEST)
- 6) HI-BAY (CENTRE)
- 7) HI-BAY (EAST)

J3

Brandon Avenue

FORT ROUGE GARAGE SPRINKLER SYSTEM - BUILDINGS A & B - ZONES AND EQUIPMENT LOCATIONS	REVISION 0
	REF NO FRG_209
	DRAWING NO. FRG SPR 01