



ADDRESS: 838 RUE ST. JOSEPH PROJECT No: 2010-031 SHEET TITLE: PARTIAL SITE PLAN - UNDERGROUND SEASONAL WATER SERVICE DATE: 2012.03.09 FILE NAME: 2010031MWD.dwg/C2

SYMBOLS	
ALSO SEE MECHANICAL & PLUMBING DWG.	
SYMBOL	DESCRIPTION
---	CONTRACTOR TO SUPPLY & INSTALL UNLESS OTHERWISE NOTED
---	EXISTING 250MM WATER MAIN
CW	UNDERGROUND WATER SERVICE LINE INTO BUILDING FROM STREET MAIN INTO NEW STORAGE BUILDING
---	PROPERTY LINE
█	APPROXIMATE AREA OF EXCAVATION / PUSH PIPE, BACK-FILLING, COMPACTING & ROUGH GRADING; BY CONTRACTOR. TOP SOIL & SOD; BY OTHERS

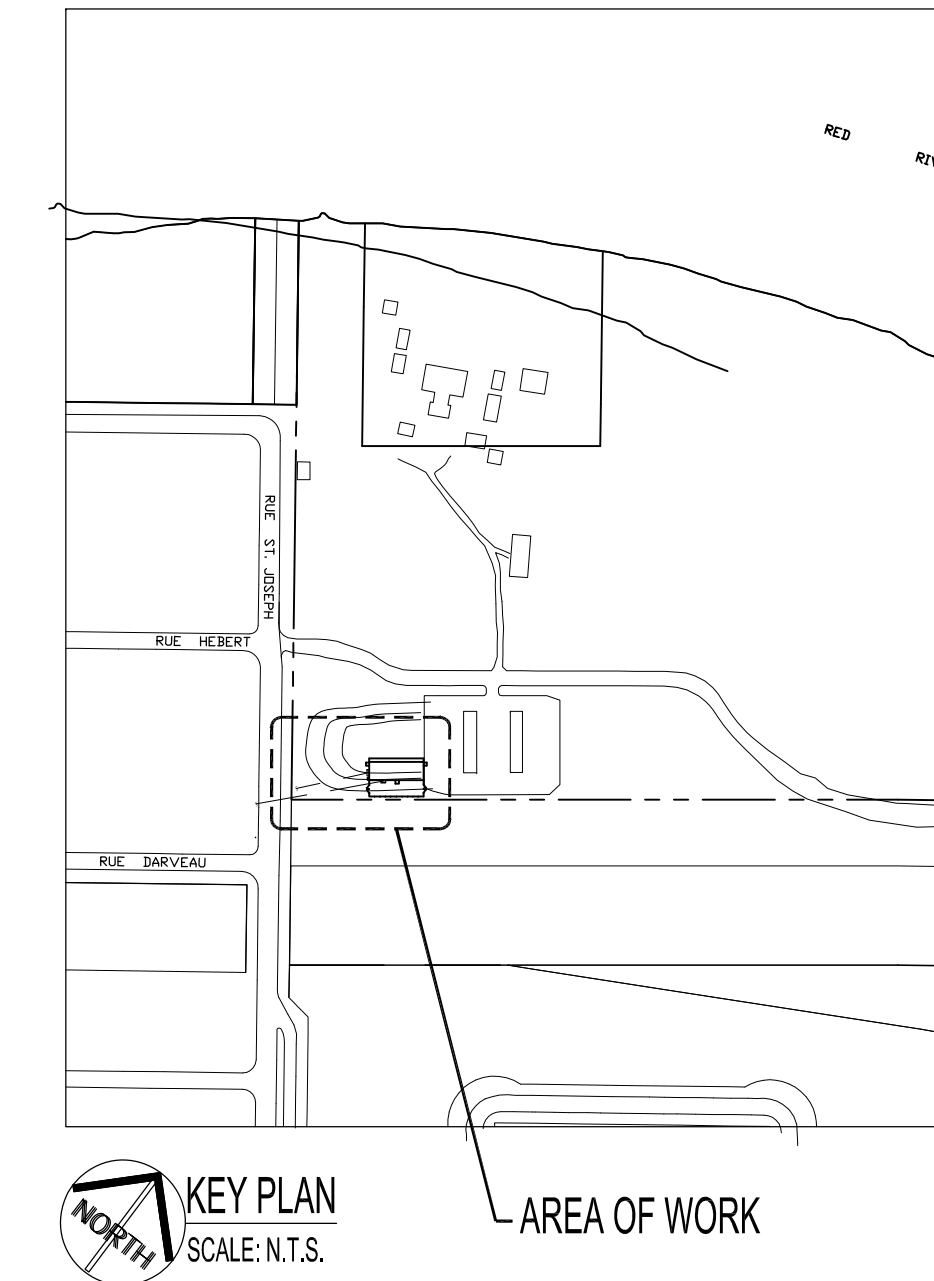

NOTES:
 ALSO SEE ARCHITECTURAL & ELECTRICAL DWGS.
 THESE DRAWINGS SHALL NOT BE SCALED.
 THE CONTRACTOR SHALL VISIT THE SITE AND SATISFY ONESELF ALL DIMENSIONS, DATUM, AND DETAILED INFORMATION SHOWN ARE CORRECT.
 ALL NEW WATER SERVICE PRODUCTS & MATERIALS TO BE CONFORM WITH MANUFACTURERS' SPECIFICATIONS. INSTALL PRODUCTS AS PER CURRENT CITY OF WINNIPEG STANDARD CONSTRUCTION SPECIFICATIONS & NATIONAL PLUMBING CODE OF CANADA.
 ALL SITE WORK TO BE IN ACCORDANCE TO CURRENT CITY OF WINNIPEG CONSTRUCTION SPECIFICATIONS. FINAL TOP SOIL MATERIALS & SODDING BY OTHERS.
 ALL SITE WORK TO BE INSPECTED BY CITY OF WINNIPEG PRIOR TO BACKFILLING, MATERIALS & COMPACTION.
 CONTRACTOR TO OBTAIN ALL REQUIRED PERMITS & VERIFY LOCATION OF EXISTING UNDERGROUND WATER SERVICE FOR TIE-IN POINTS FOR WATER SERVICE TO NEW STORAGE BUILDING. CONTRACTOR TO OBTAIN UTILITY CLEARANCES PRIOR TO EXCAVATING.

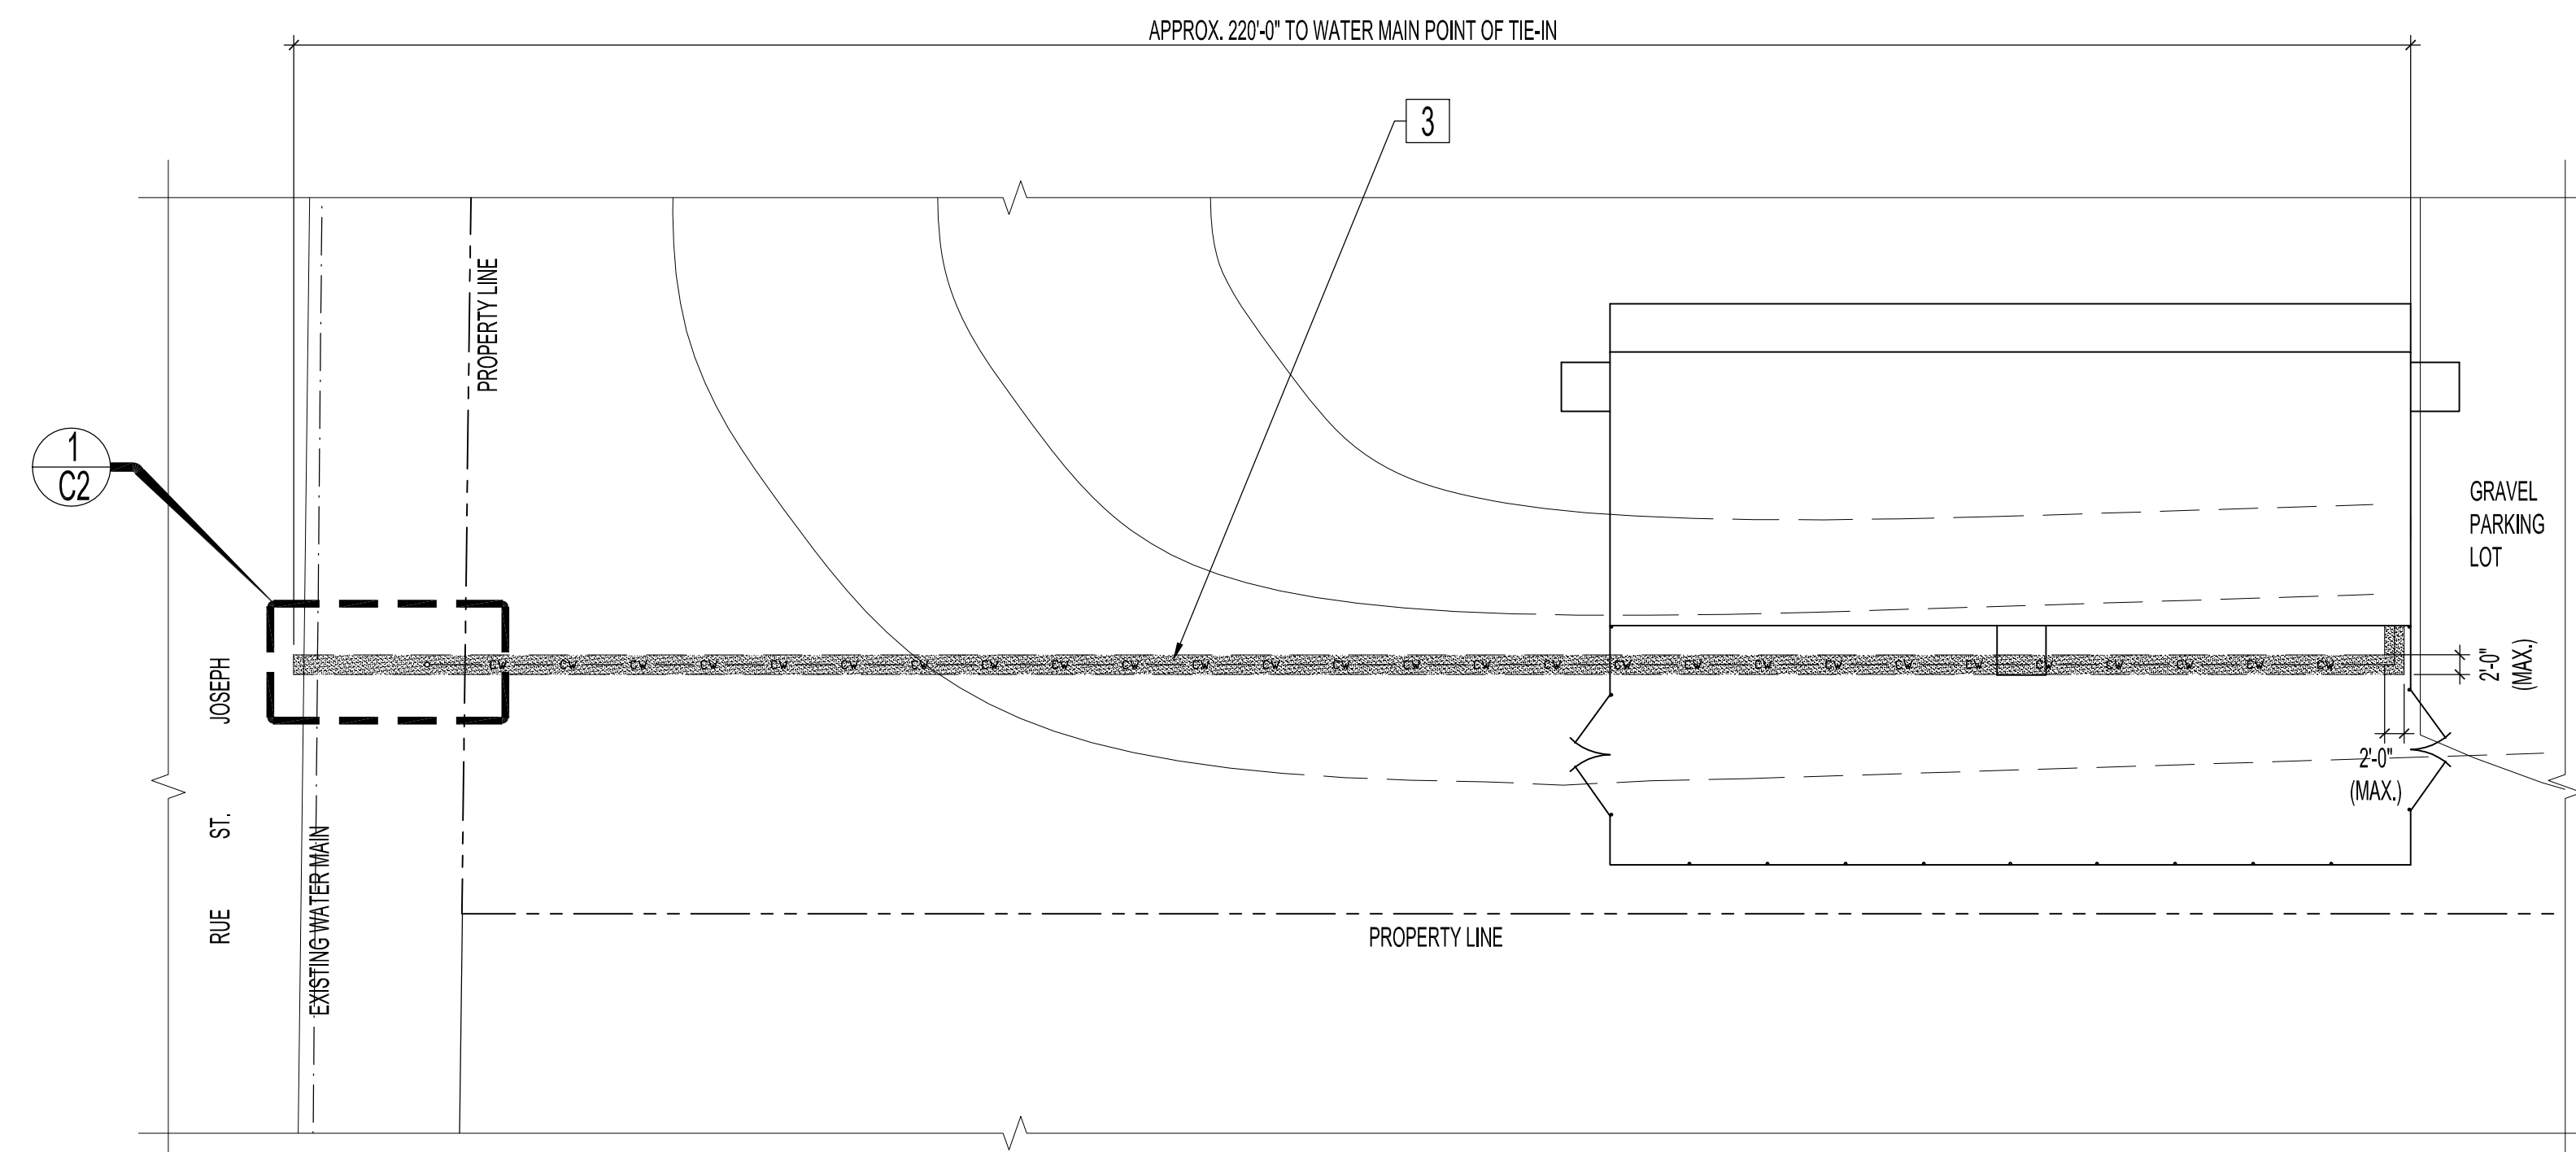


UNDERGROUND SEASONAL WATER SERVICE NOTES:

- REFERENCED CURRENT CITY OF WINNIPEG STANDARD CONSTRUCTION SPECIFICATIONS
- WATERMANS: CW 2110.
 - EXCAVATION, BEDDING AND BACKFILLING: CW 2030.
 - FLUSHING, HYDROSTATIC LEAKAGE TESTING AND DISINFECTION OF WATERMANS AND WATER SERVICES: CW 2125.
- 1 1'0" TYPE K, SEAMLESS COPPER UNDERGROUND WATER SERVICE LINE. CONTINUED ON M1 DWG.
- 2 MINNEAPOLIS STYLE CURB STOP & BOX.
- 3 EXCAVATE / TRENCH TO THE DEPTH OF 6'-0" (MINIMUM) X 2'-0" WIDE (MAXIMUM) OR PUSH PIPE (TRENCHLESS) DOWN TO EXISTING CAST IRON WATER MAIN AND PROVIDE TIE-IN CONNECTION FOR NEW BUILDING WATER SERVICE.


ORIGINAL STAMPED BY: DOUG PALEY
 DATE: 2012.03.09

PARTIAL SITE PLAN - UNDERGROUND SEASONAL WATER SERVICE
 SCALE: 1/16"=1'-0"

No.	REVISION/DESCRIPTION	BY	DATE

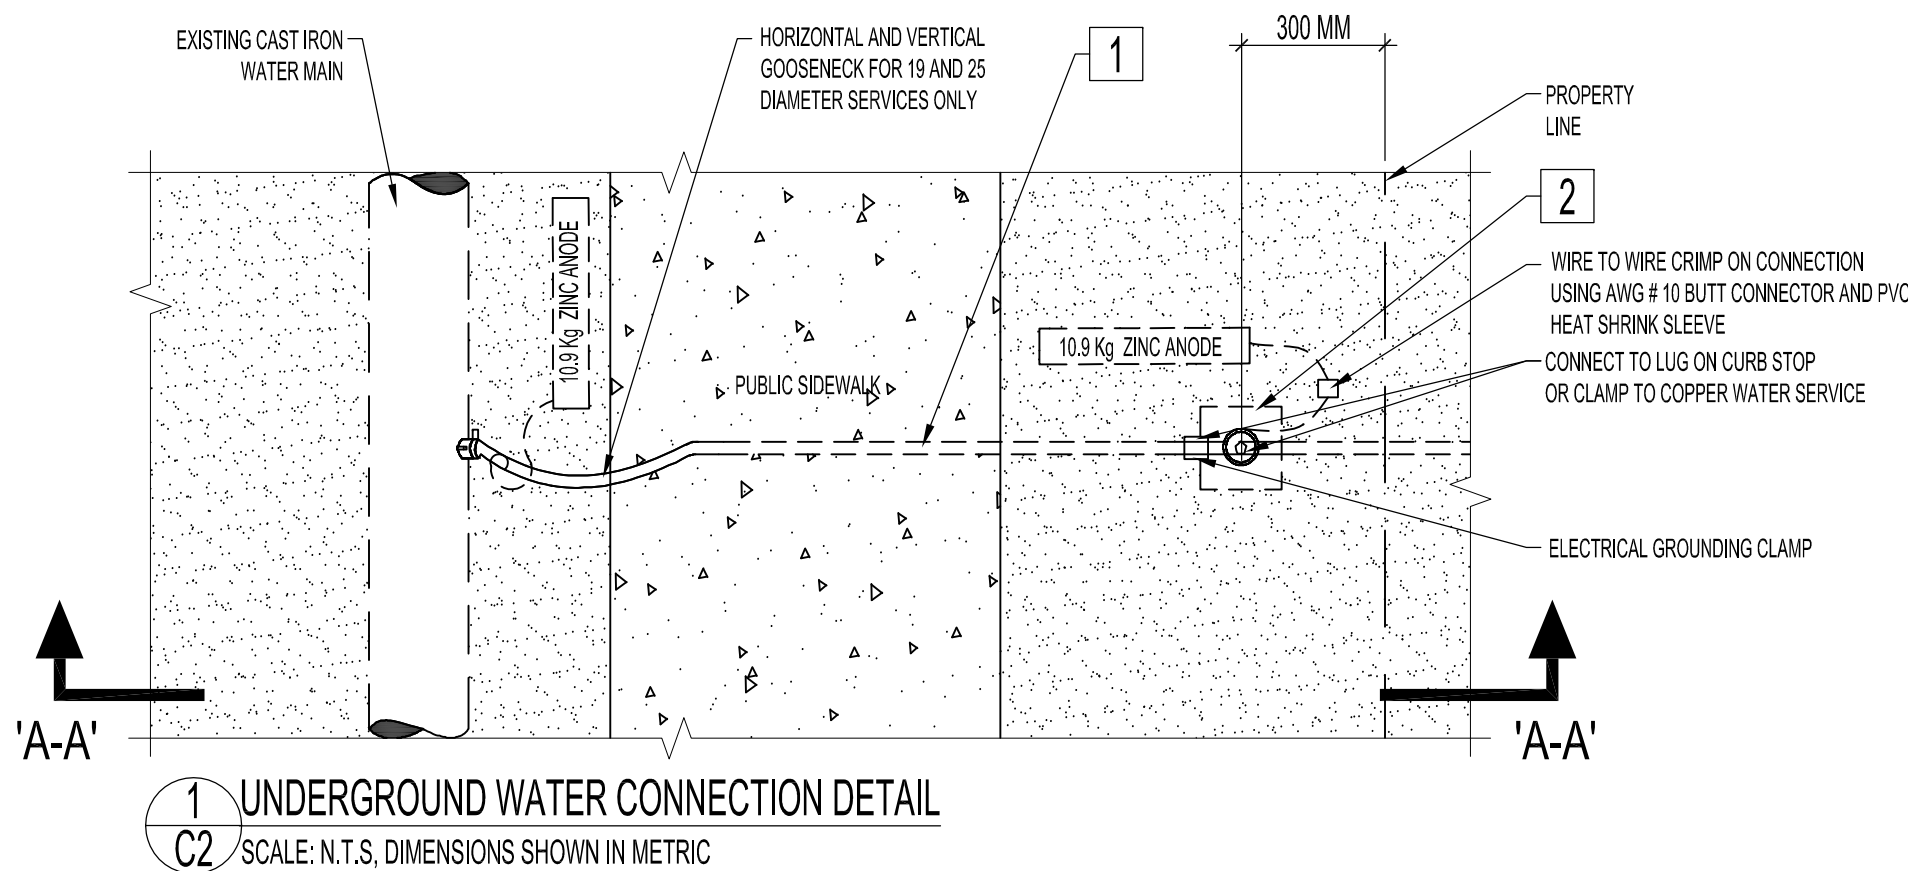

1 UNDERGROUND WATER CONNECTION DETAIL
 SCALE: N.T.S., DIMENSIONS SHOWN IN METRIC

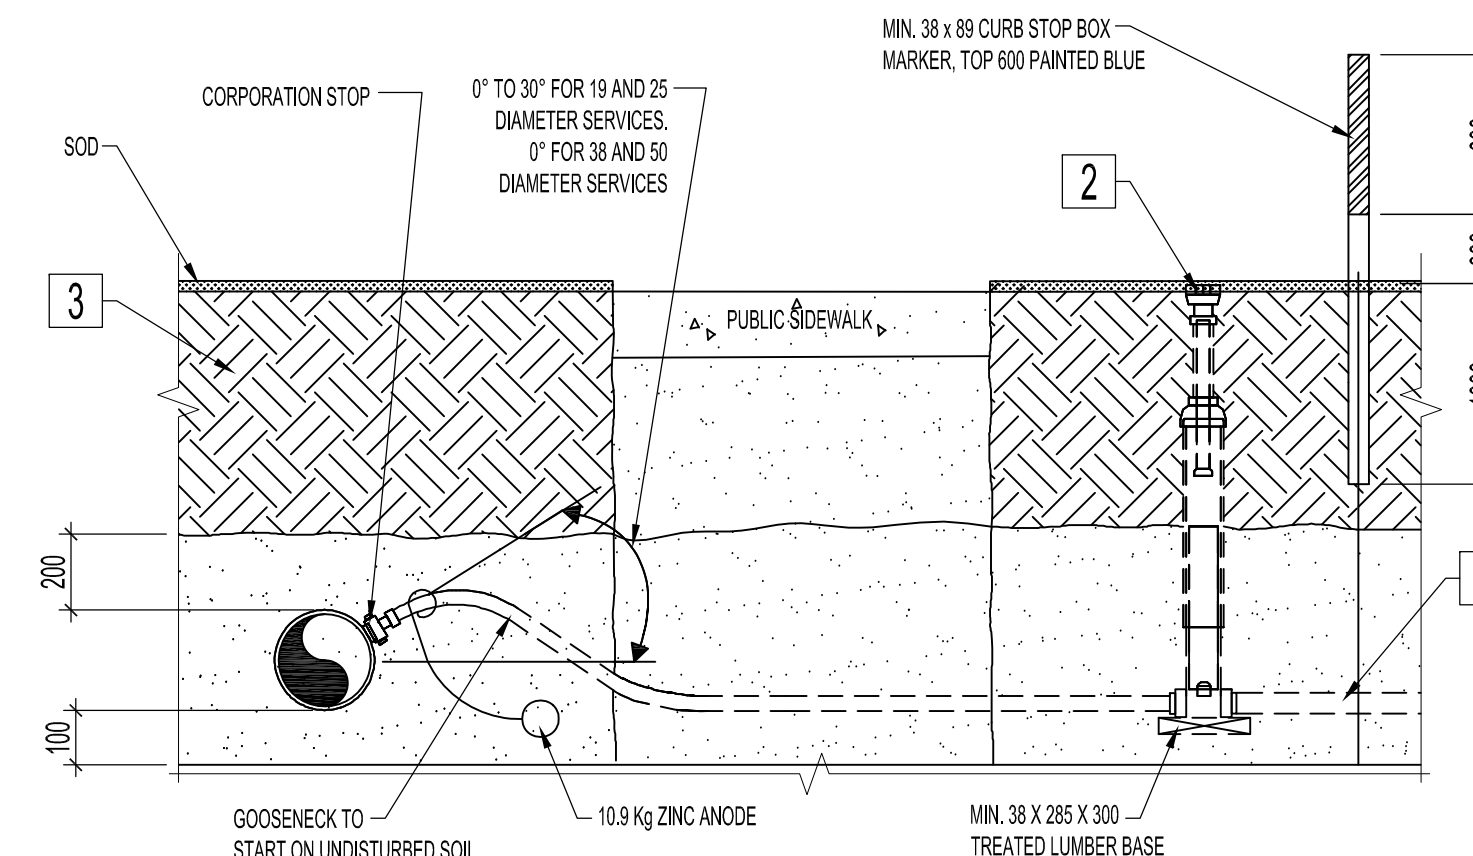

SECTION 'A-A' - UNDERGROUND WATER SERVICE CONNECTION
 SCALE: N.T.S., DIMENSIONS SHOWN IN METRIC

DRAWN	RCP	CHECKED	CAD	DESIGNED	RCP	APPROVED	CAD

THE CITY OF WINNIPEG
 PLANNING, PROPERTY AND DEVELOPMENT DEPARTMENT
 MUNICIPAL ACCOMMODATIONS DIVISION
 3-65 GARRY STREET, R3C 4K4

PROJECT
 WHITTIER PARK
 STORAGE BUILDING

838 RUE ST. JOSEPH

SHEET TITLE
 PARTIAL SITE PLAN
 UNDERGROUND SEASONAL WATER SERVICE

SCALE	PROJECT No:	SHEET No:
AS SHOWN	2010-031	C2

DRAWING SHEET SIZE: A1 (841mm x 594mm) PLOT 1:1