



D.B.M. # 65-002
EL. 32.694

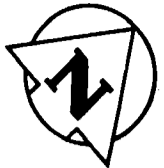

WAVERLEY STREET

WILKES AVE.

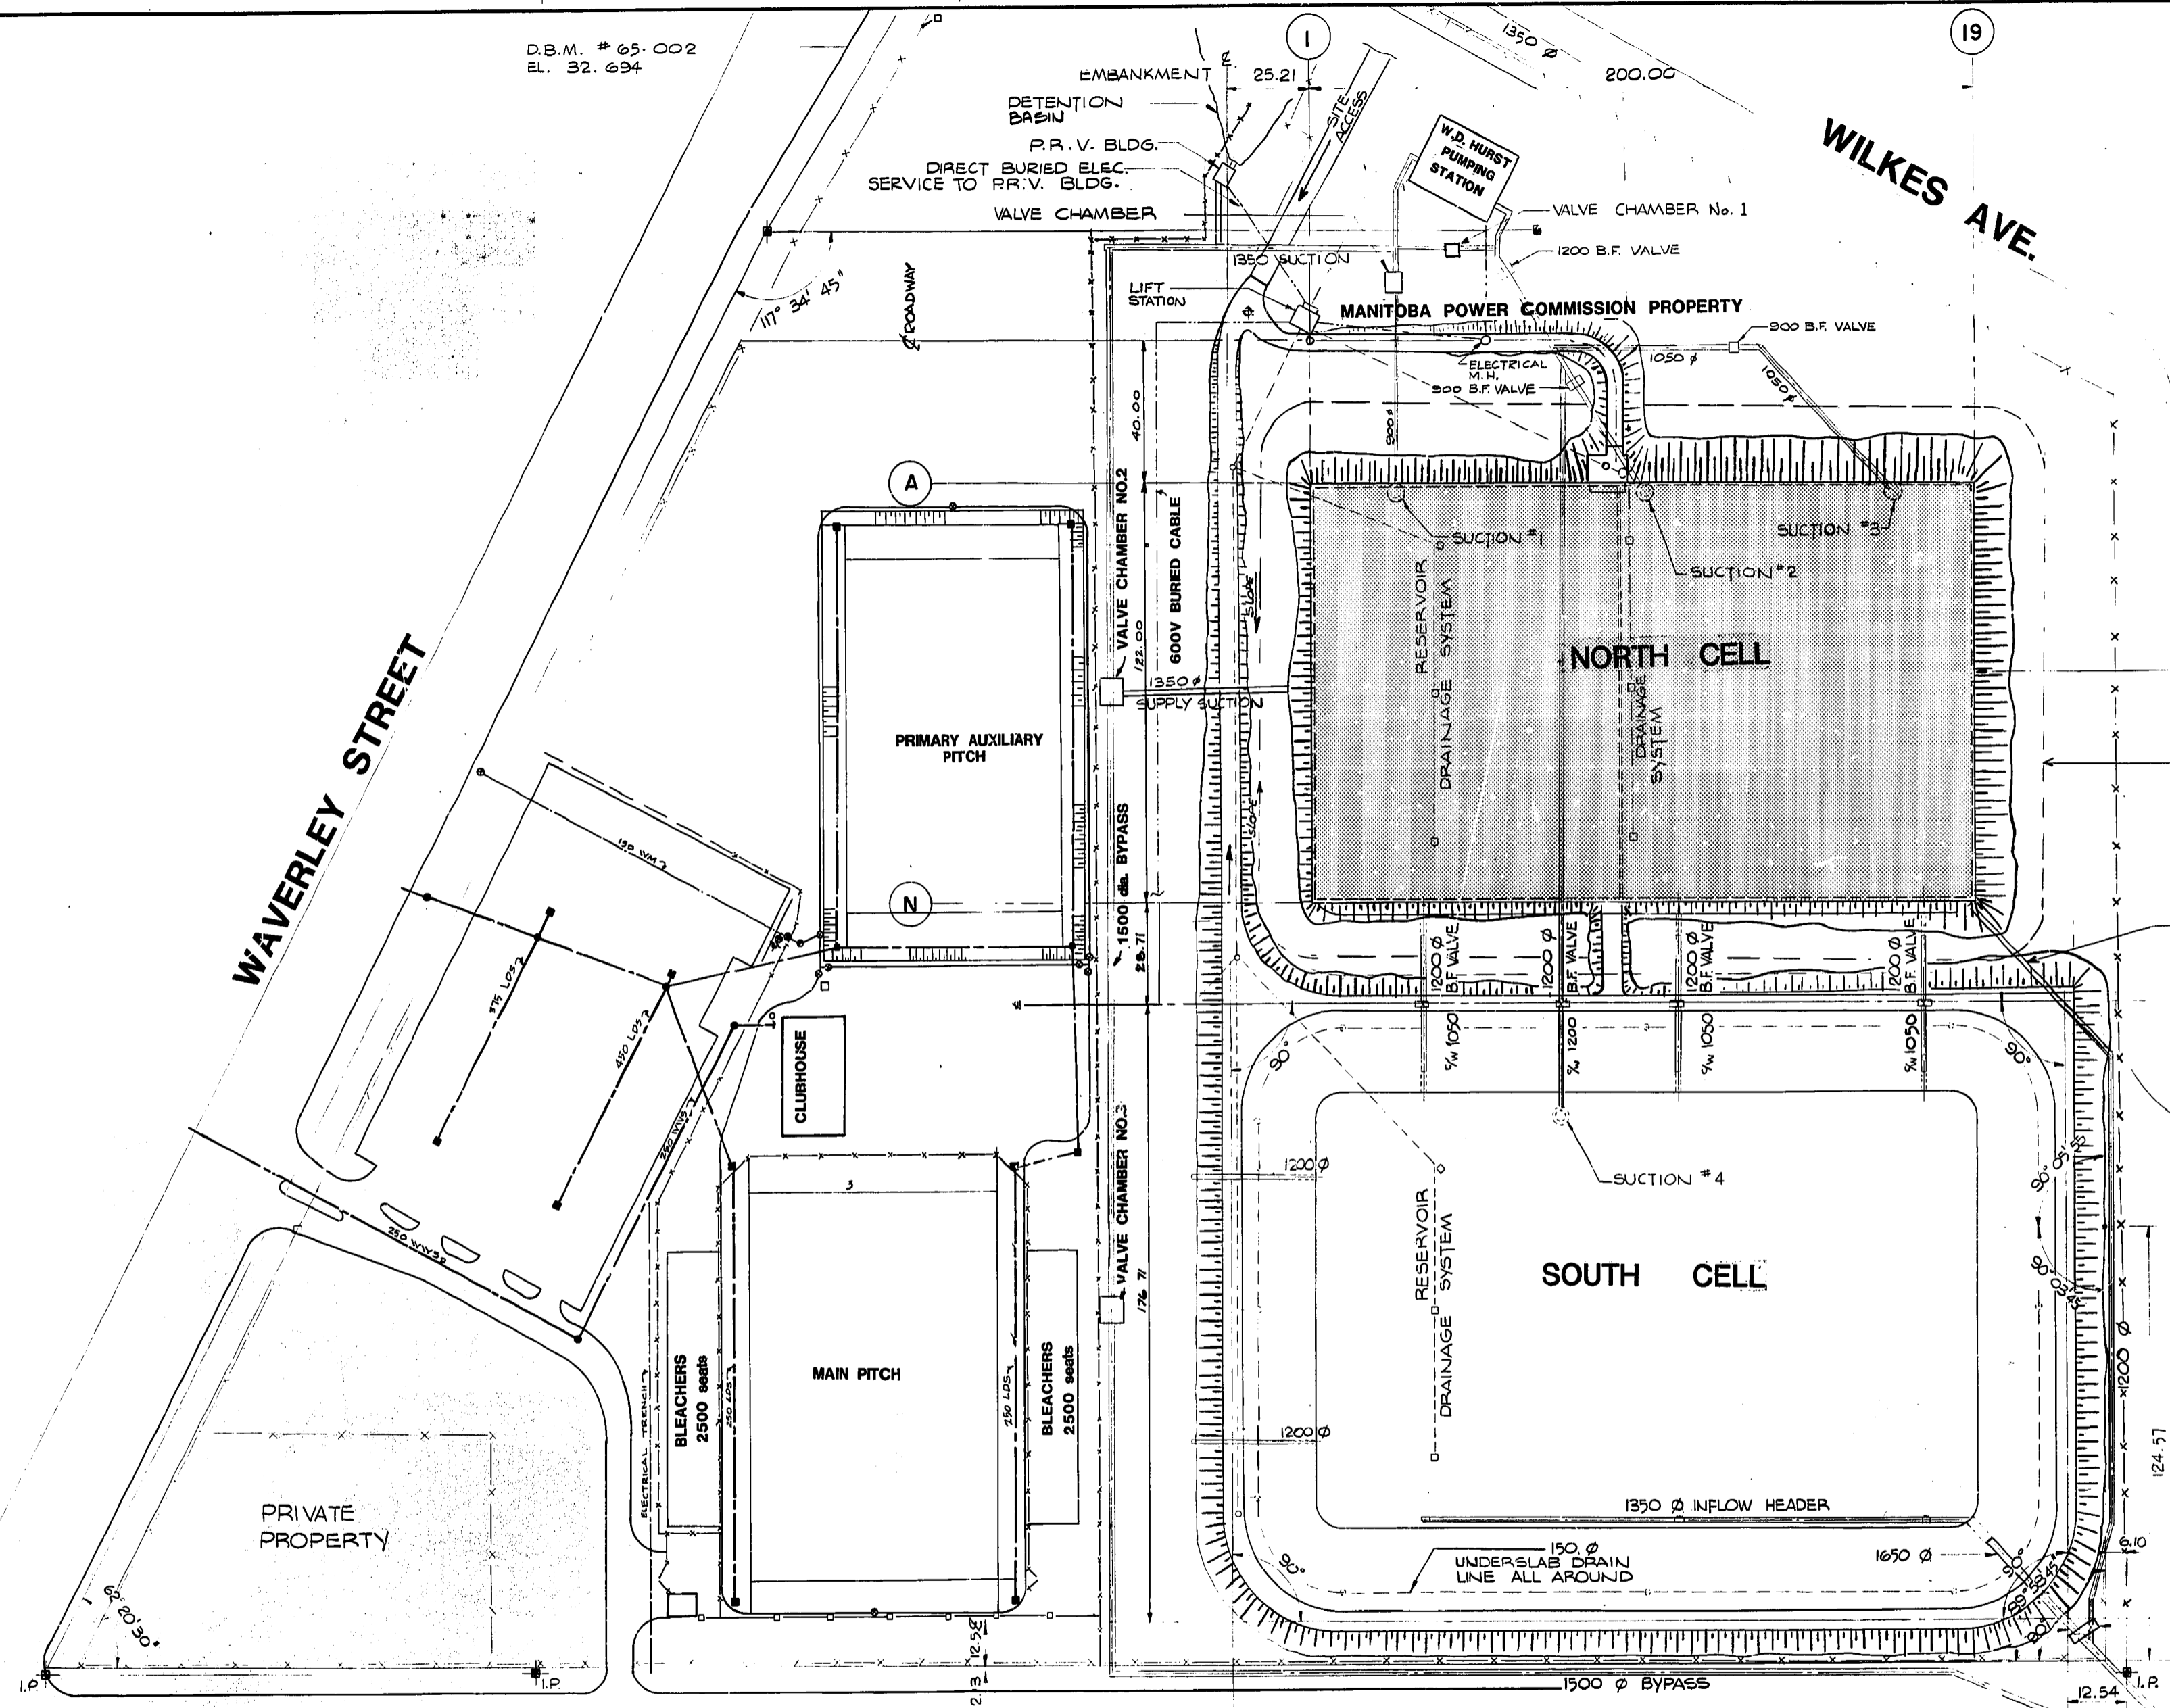

RESERVOIR OUTLINE
150 Ø UNDERSLAB DRAIN LINE ALL AROUND (ABANDONED)

1200 Ø INFLOW

PARKER AVE.

NOTES:
LOCATION OF UNDERGROUND UTILITIES AS SHOWN, ARE BASED ON BEST INFORMATION AVAILABLE, BUT NO GUARANTEE IS GIVEN THAT ALL EXISTING UTILITIES ARE SHOWN.

C.N.R. SPUR TRACK

VALVE CHAMBER

RECORD DRAWING

WILSON PLACE

METRIC NOTES

WHOLE NUMBERS IND. MILLIMETRES
DECIMALIZED EXPRESSIONS IND. METRES

Note:
See Dwg. D-1556 For Aerial of Soccer Complex

NO	REVISIONS	DATE	APP.
3	SOCCER COMPLEX ADDED	FEB 21/80	M.S.
2	RECORD DRAWING	NOV 25/79	E.L.
1	CONSTRUCTION PHASES ADDED		E.L.



Underwood McLellan Ltd.
Consulting Engineers and Planners

DESIGNED BY: R.M.M. DRAWN BY: T.H.
CHECKED BY: DATE: MARCH 20, 1980
APPROVED BY: DATE: 2/3/80

THE CITY OF WINNIPEG
WORKS & OPERATIONS DEPARTMENT
WATERWORKS, WASTE, & DISPOSAL DIVISION

WILKES AVENUE RESERVOIR RECONSTRUCTION
SITE PLAN
RELEASED FOR CONSTRUCTION DATE: 20/03/80
SCALE: 1:1000
DRAWING NO. **WIL-1A**

File # RE10269