 



NO.	CONSTRUCTION NOTES
①	MODIFY GCP-7 AS SHOWN ON OTHER DRAWINGS.
②	PROVIDE UNISTRUT SUPPORTS ATTACHED TO CEILING FOR LCP-G2.
③	PROVIDE NEW INSTRUMENT AIR PIPING FOR G687-XV. TIE INTO EXISTING INSTRUMENT AIR PIPING AT LOCATION SHOWN. PAINT NEW PIPING TO MATCH EXISTING.
④	MOUNT JUNCTION BOXES ON UNISTRUT SUPPORTS.
⑤	INSTALL CONCRETE HOUSEKEEPING PAD UNDER ELECTRICAL EQUIPMENT. SEE 1-0102A-S0001 FOR DETAILS.

REMOVAL NOTES	
Ⓐ	REMOVE OBSOLETE RACEWAYS FOR PNEUMATIC TUBING.

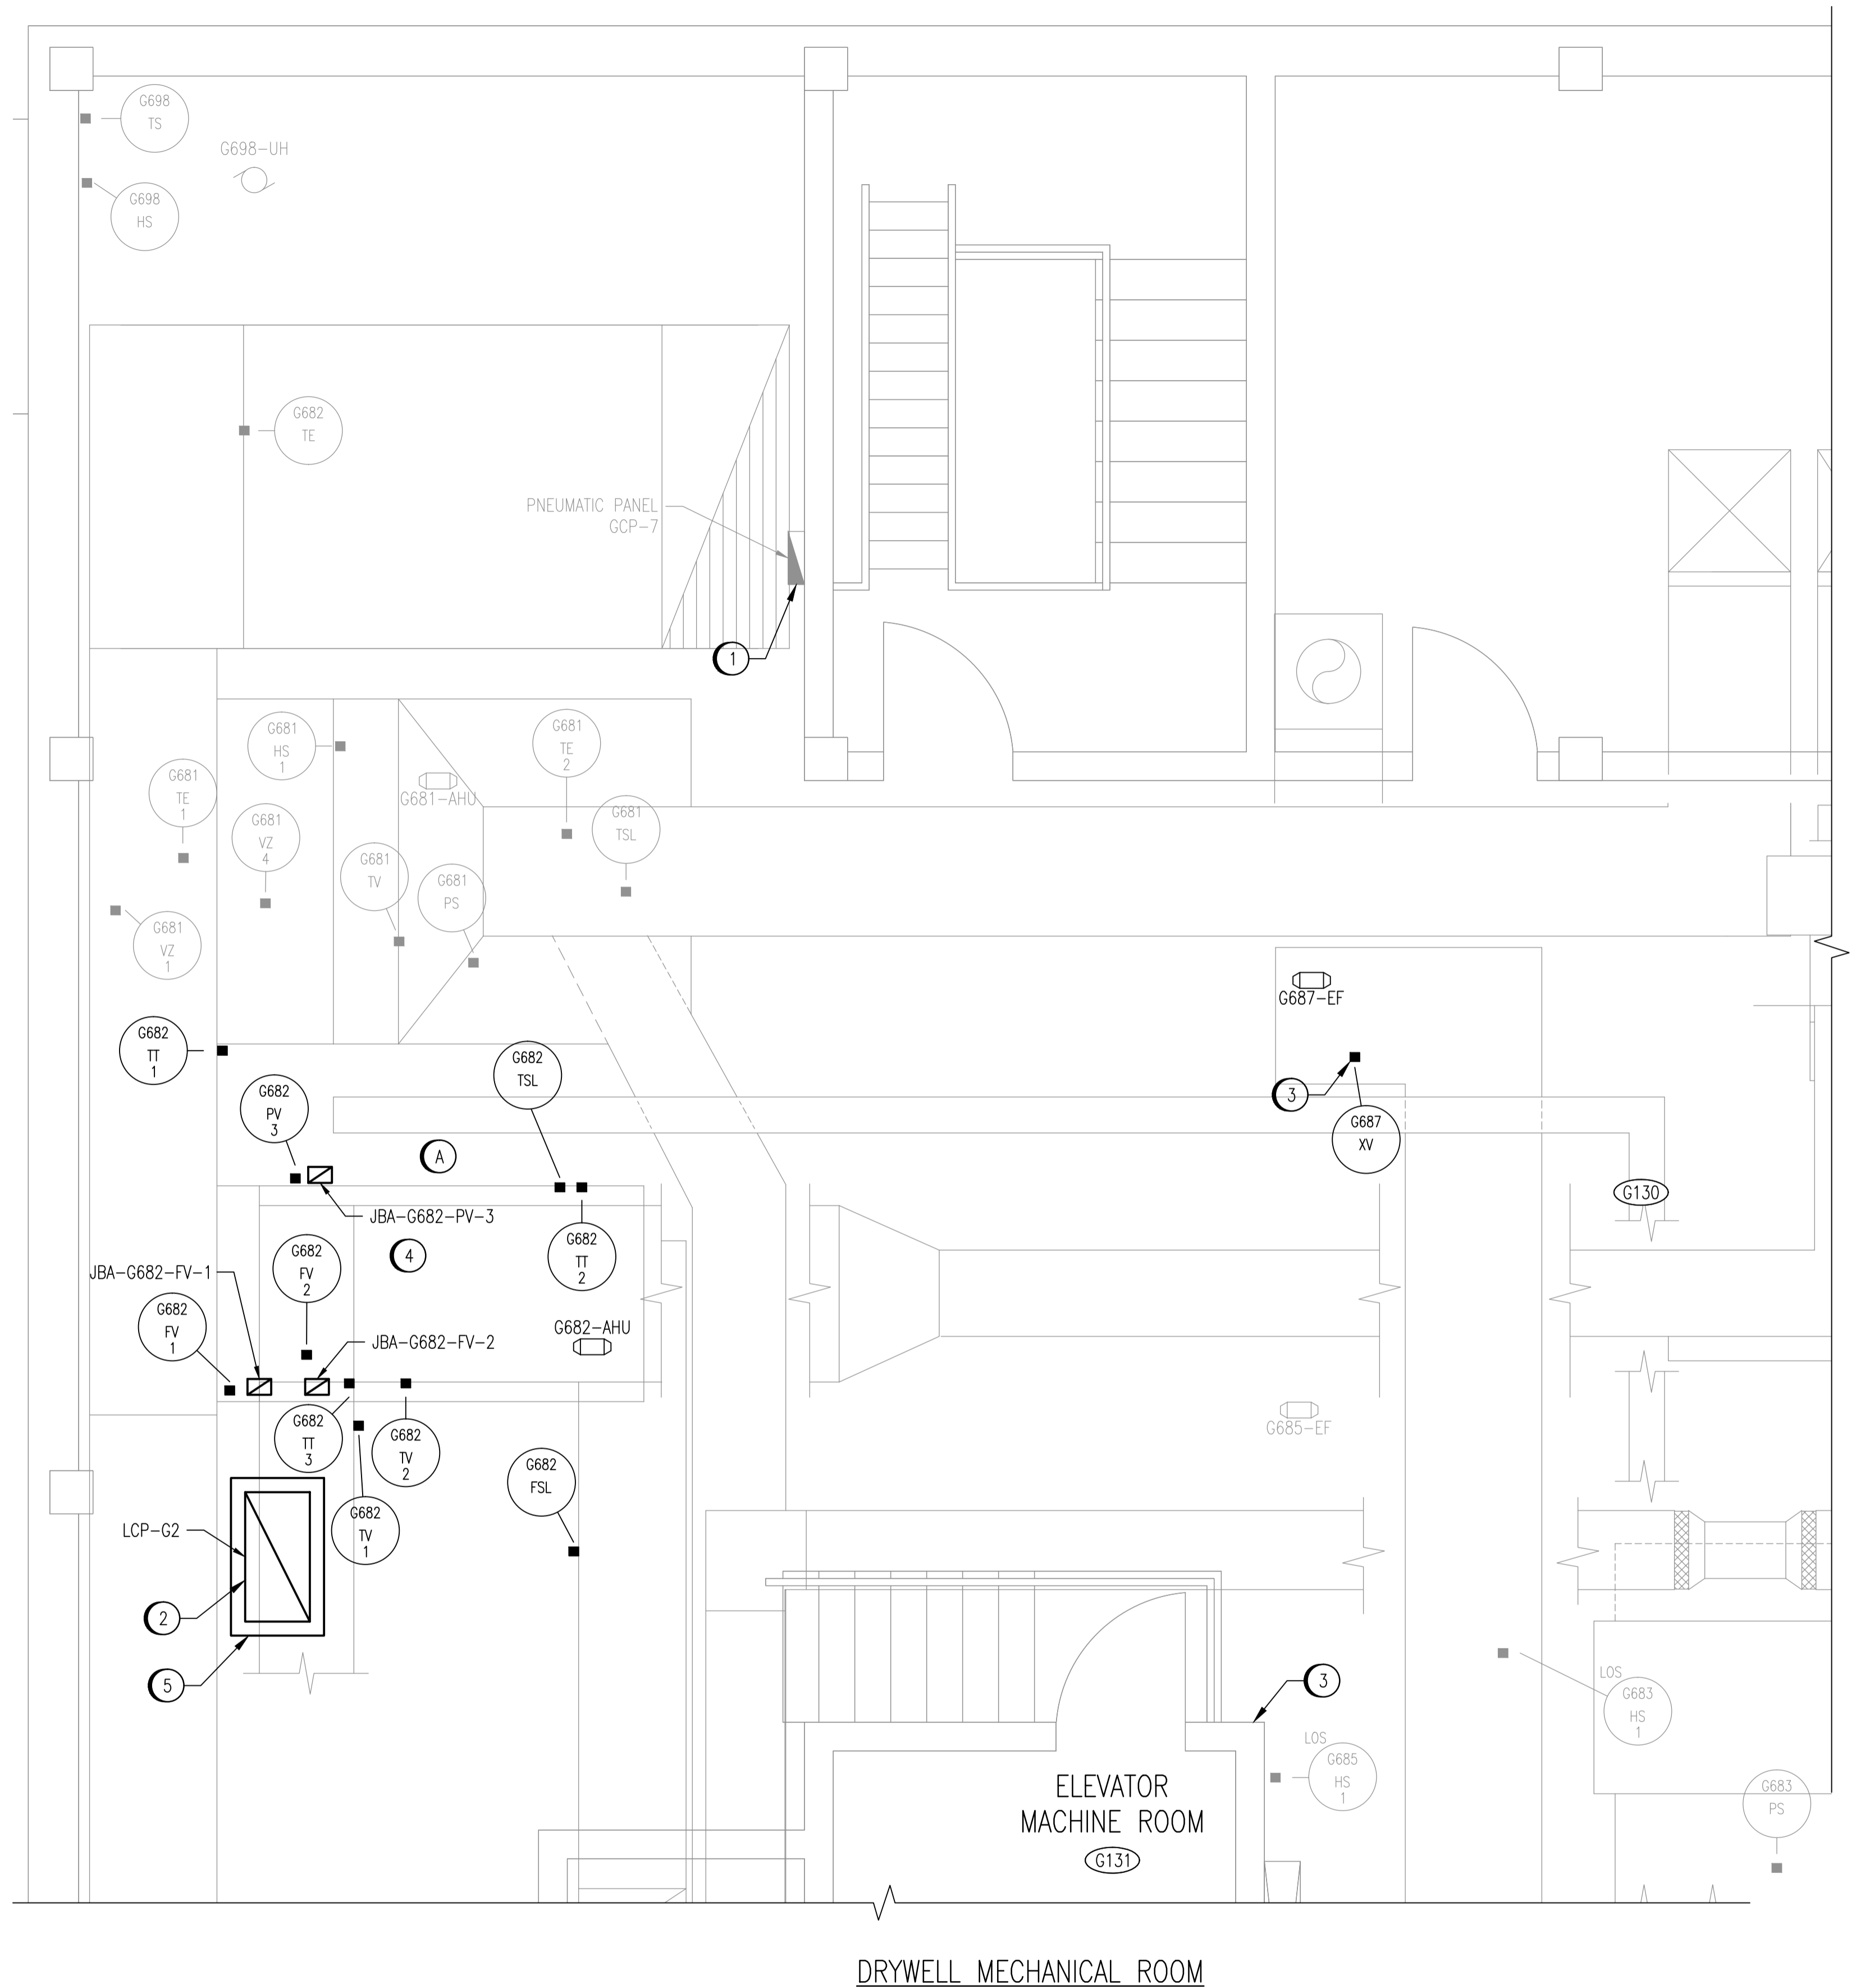

NOTES:

- THIS DRAWING SUPERCEDES PART OF SEP-837.



NO.	REVISIONS	DATE	DESIGN	CHECK
01	ISSUED FOR TENDER, BID OPP. 42-2013	2013/01/15	TMC	CJR
00	ISSUED FOR TENDER, BID OPP. 545-2012	2012/11/21	TMC	CJR

<p>SNC-LAVALIN INC. 148 Nature Park Way Winnipeg, MB, Canada R3P 0X7 204-786-8090</p>		ENGINEER'S SEAL
DESIGNED BY: T. CHURCH	CHECKED BY: C. REIMER	
DRAWN BY: M.J. PERSSON	APPROVED BY: C. REIMER	
SCALE: 1 : 30	RELEASED FOR CONSTRUCTION BY: N. HARRINGTON	
DATE: 2012/01/26	DATE: 2012/10/19	
CONSULTANT NO.: 112577-0116-4800-0001		

THE CITY OF WINNIPEG
WATER AND WASTE DEPARTMENT

SOUTH END WATER POLLUTION CONTROL CENTRE
VENTILATION & MISC UPGRADES
INSTRUMENT LOCATION PLAN
DRYWELL MECHANICAL ROOM - G130
WEST SIDE

CITY DRAWING NUMBER	SHEET	REV.	SIZE
1-0102G-A0099	001	01	A1

1-0102G-A0095	P&ID, WET WELL SUPPLY AND EXHAUST FANS
1-0102G-A0026	P&ID, G682-AHU
DRAWING NUMBER	REFERENCE DRAWINGS