




SECOND FLOOR PLAN OF WEST SERVICE PROJECTION  
OVERHAUL & REPAIR BUILDING  
SCALE 1/4" = 1'-0"

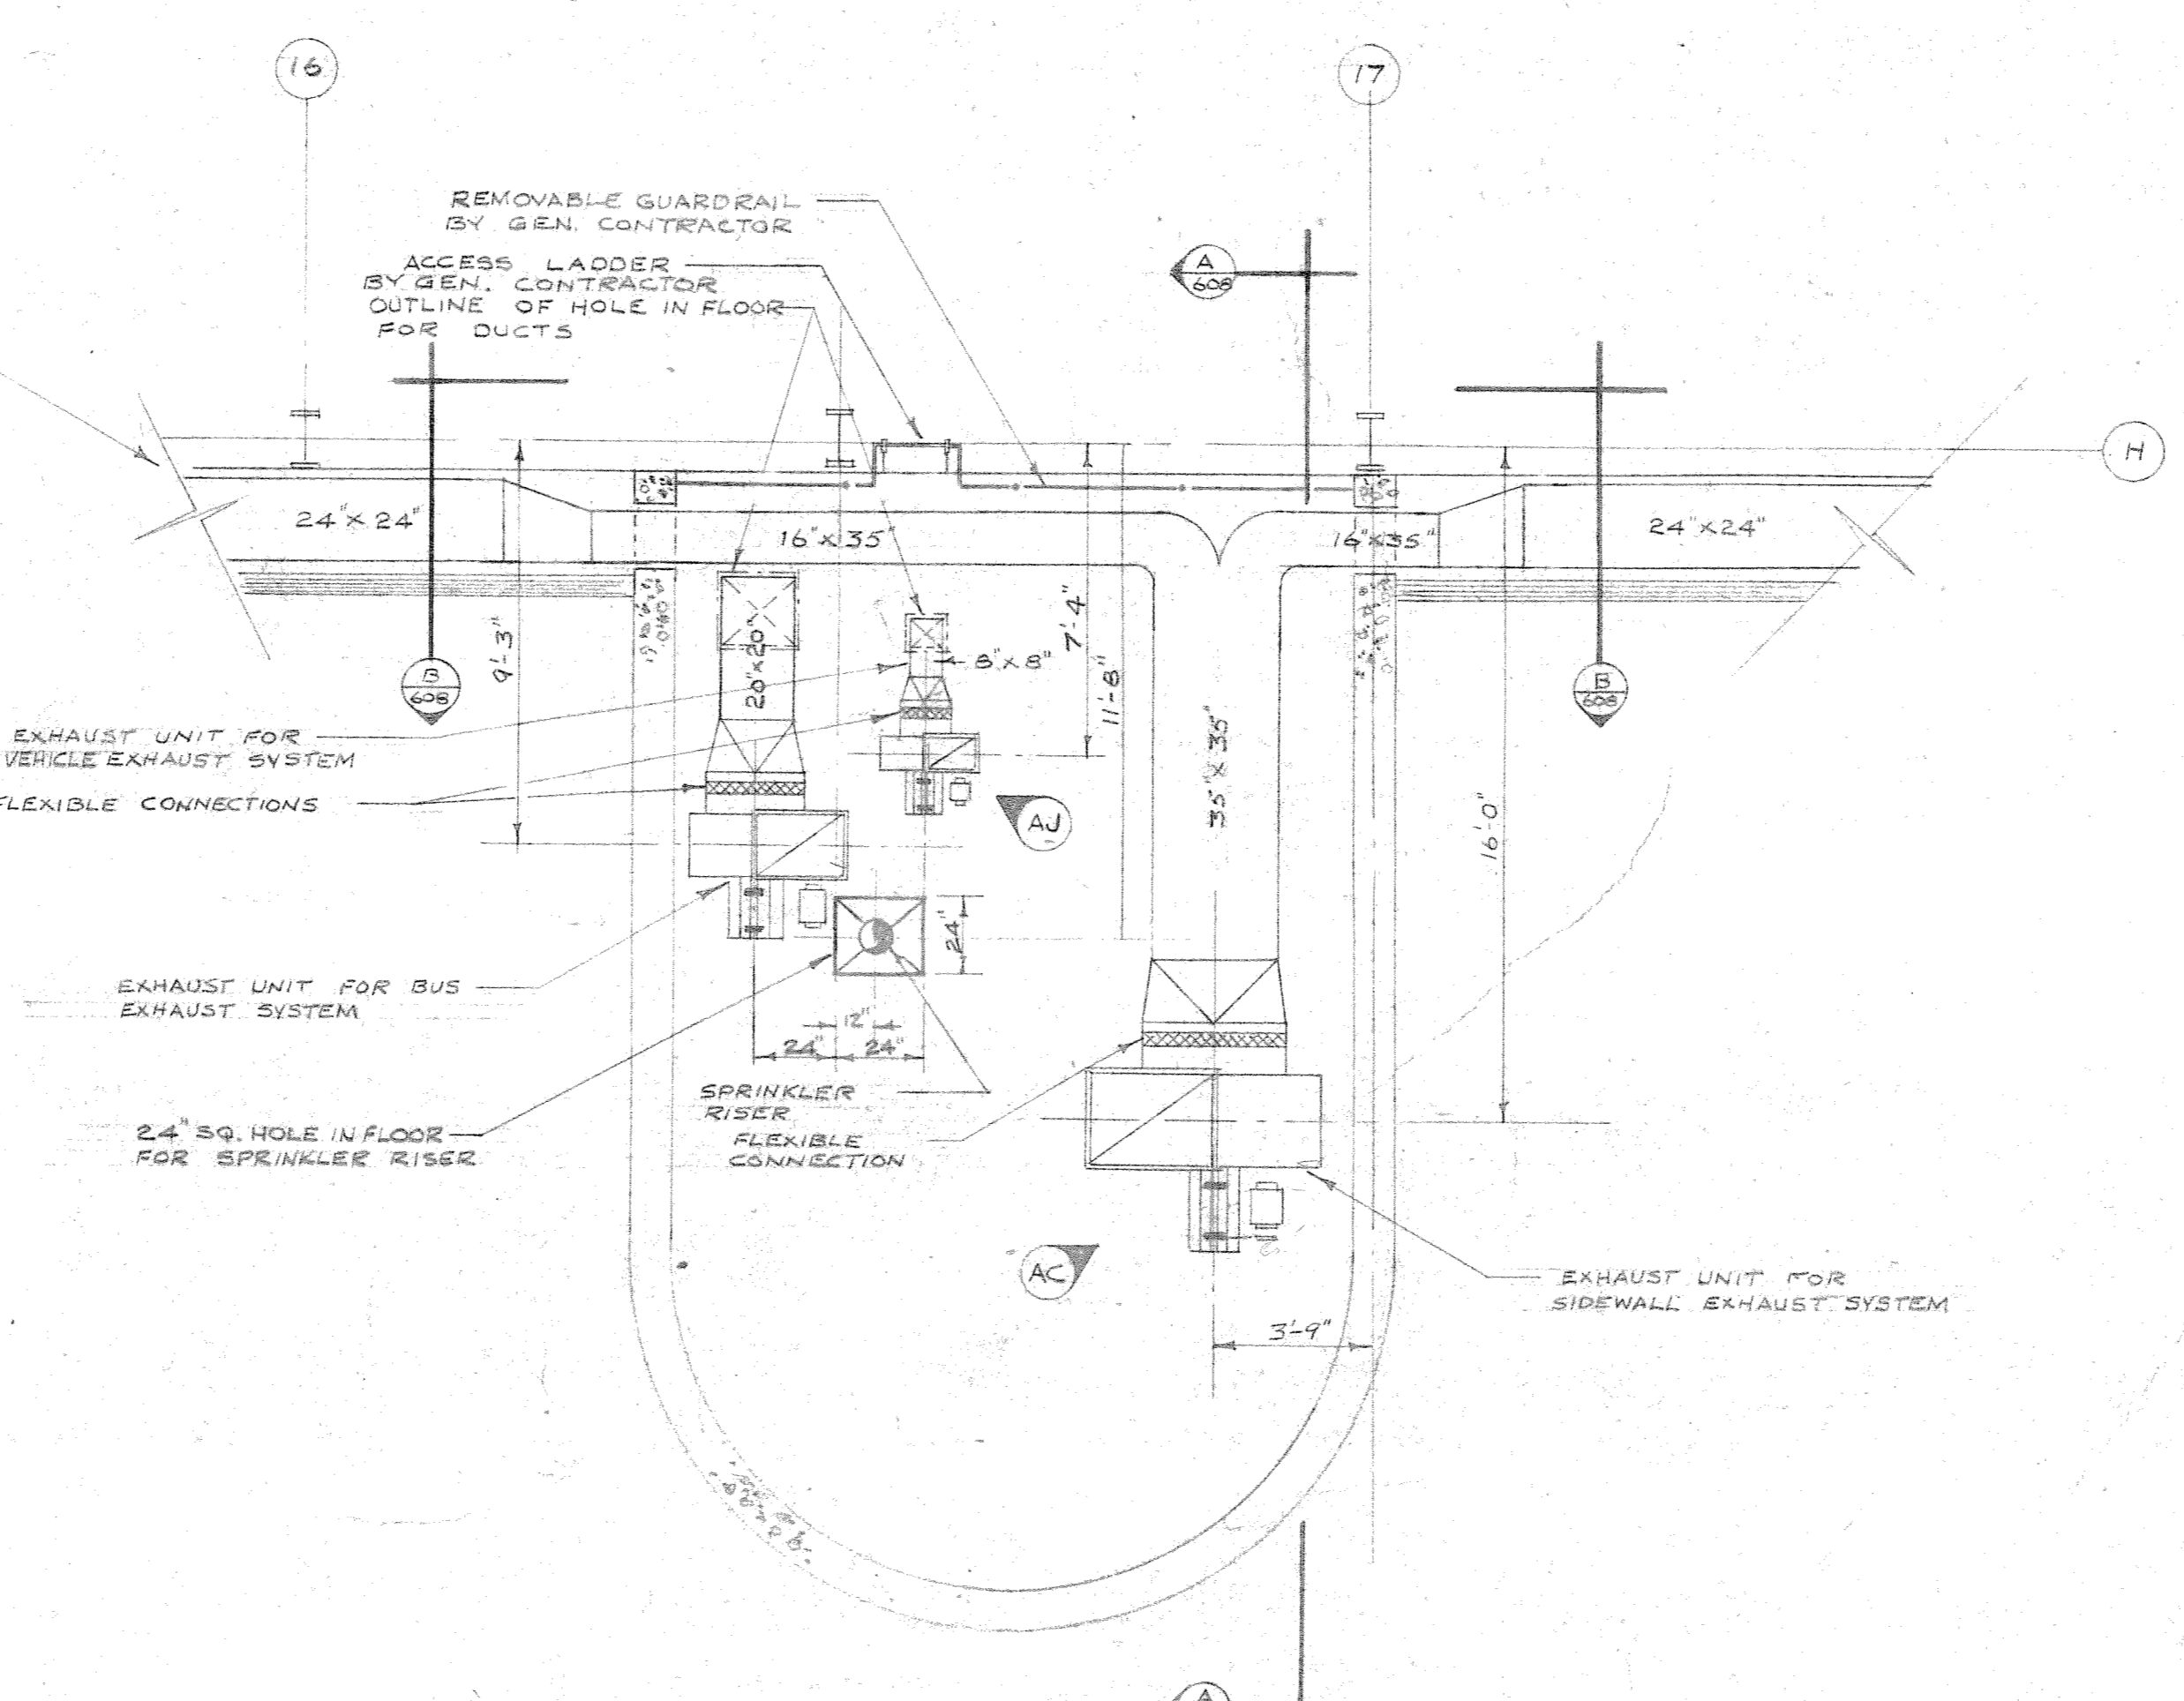


SECOND FLOOR PLAN OF EAST SERVICE PROJECTION  
OVERHAUL & REPAIR BUILDING  
SCALE 1/4" = 1'-0"

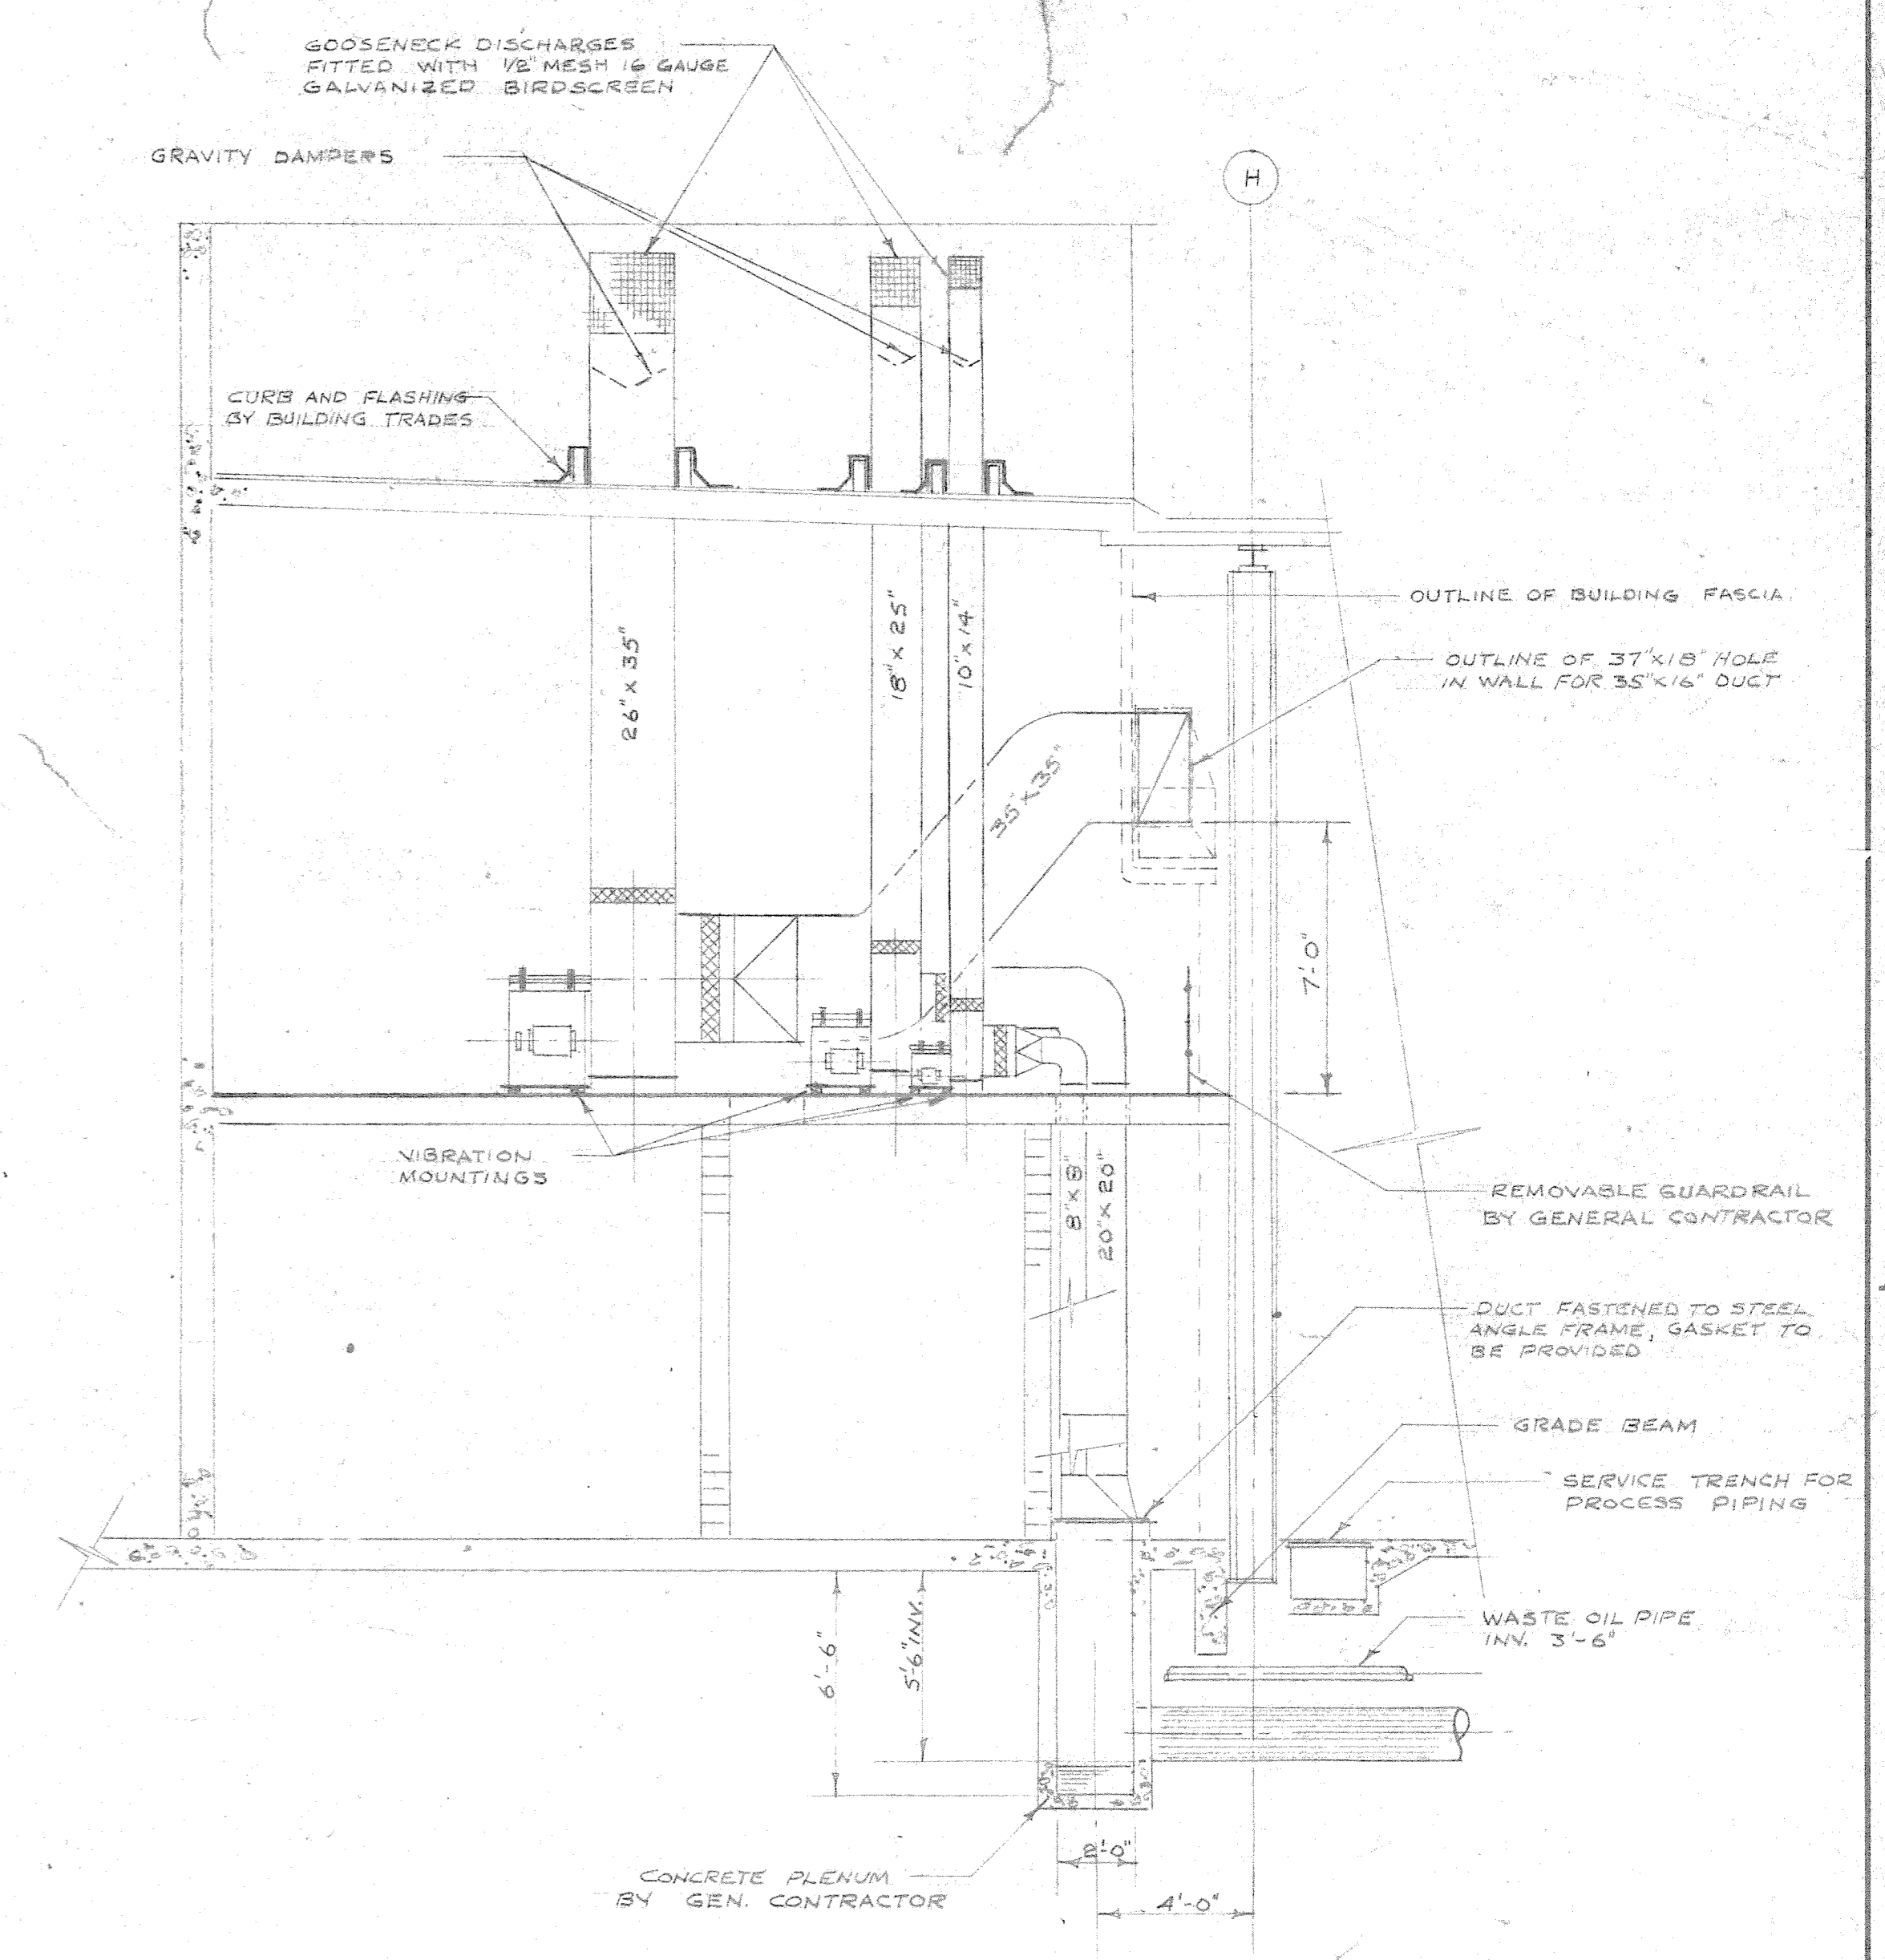


SECTION A-A  
SCALE 1/4" = 1'-0"

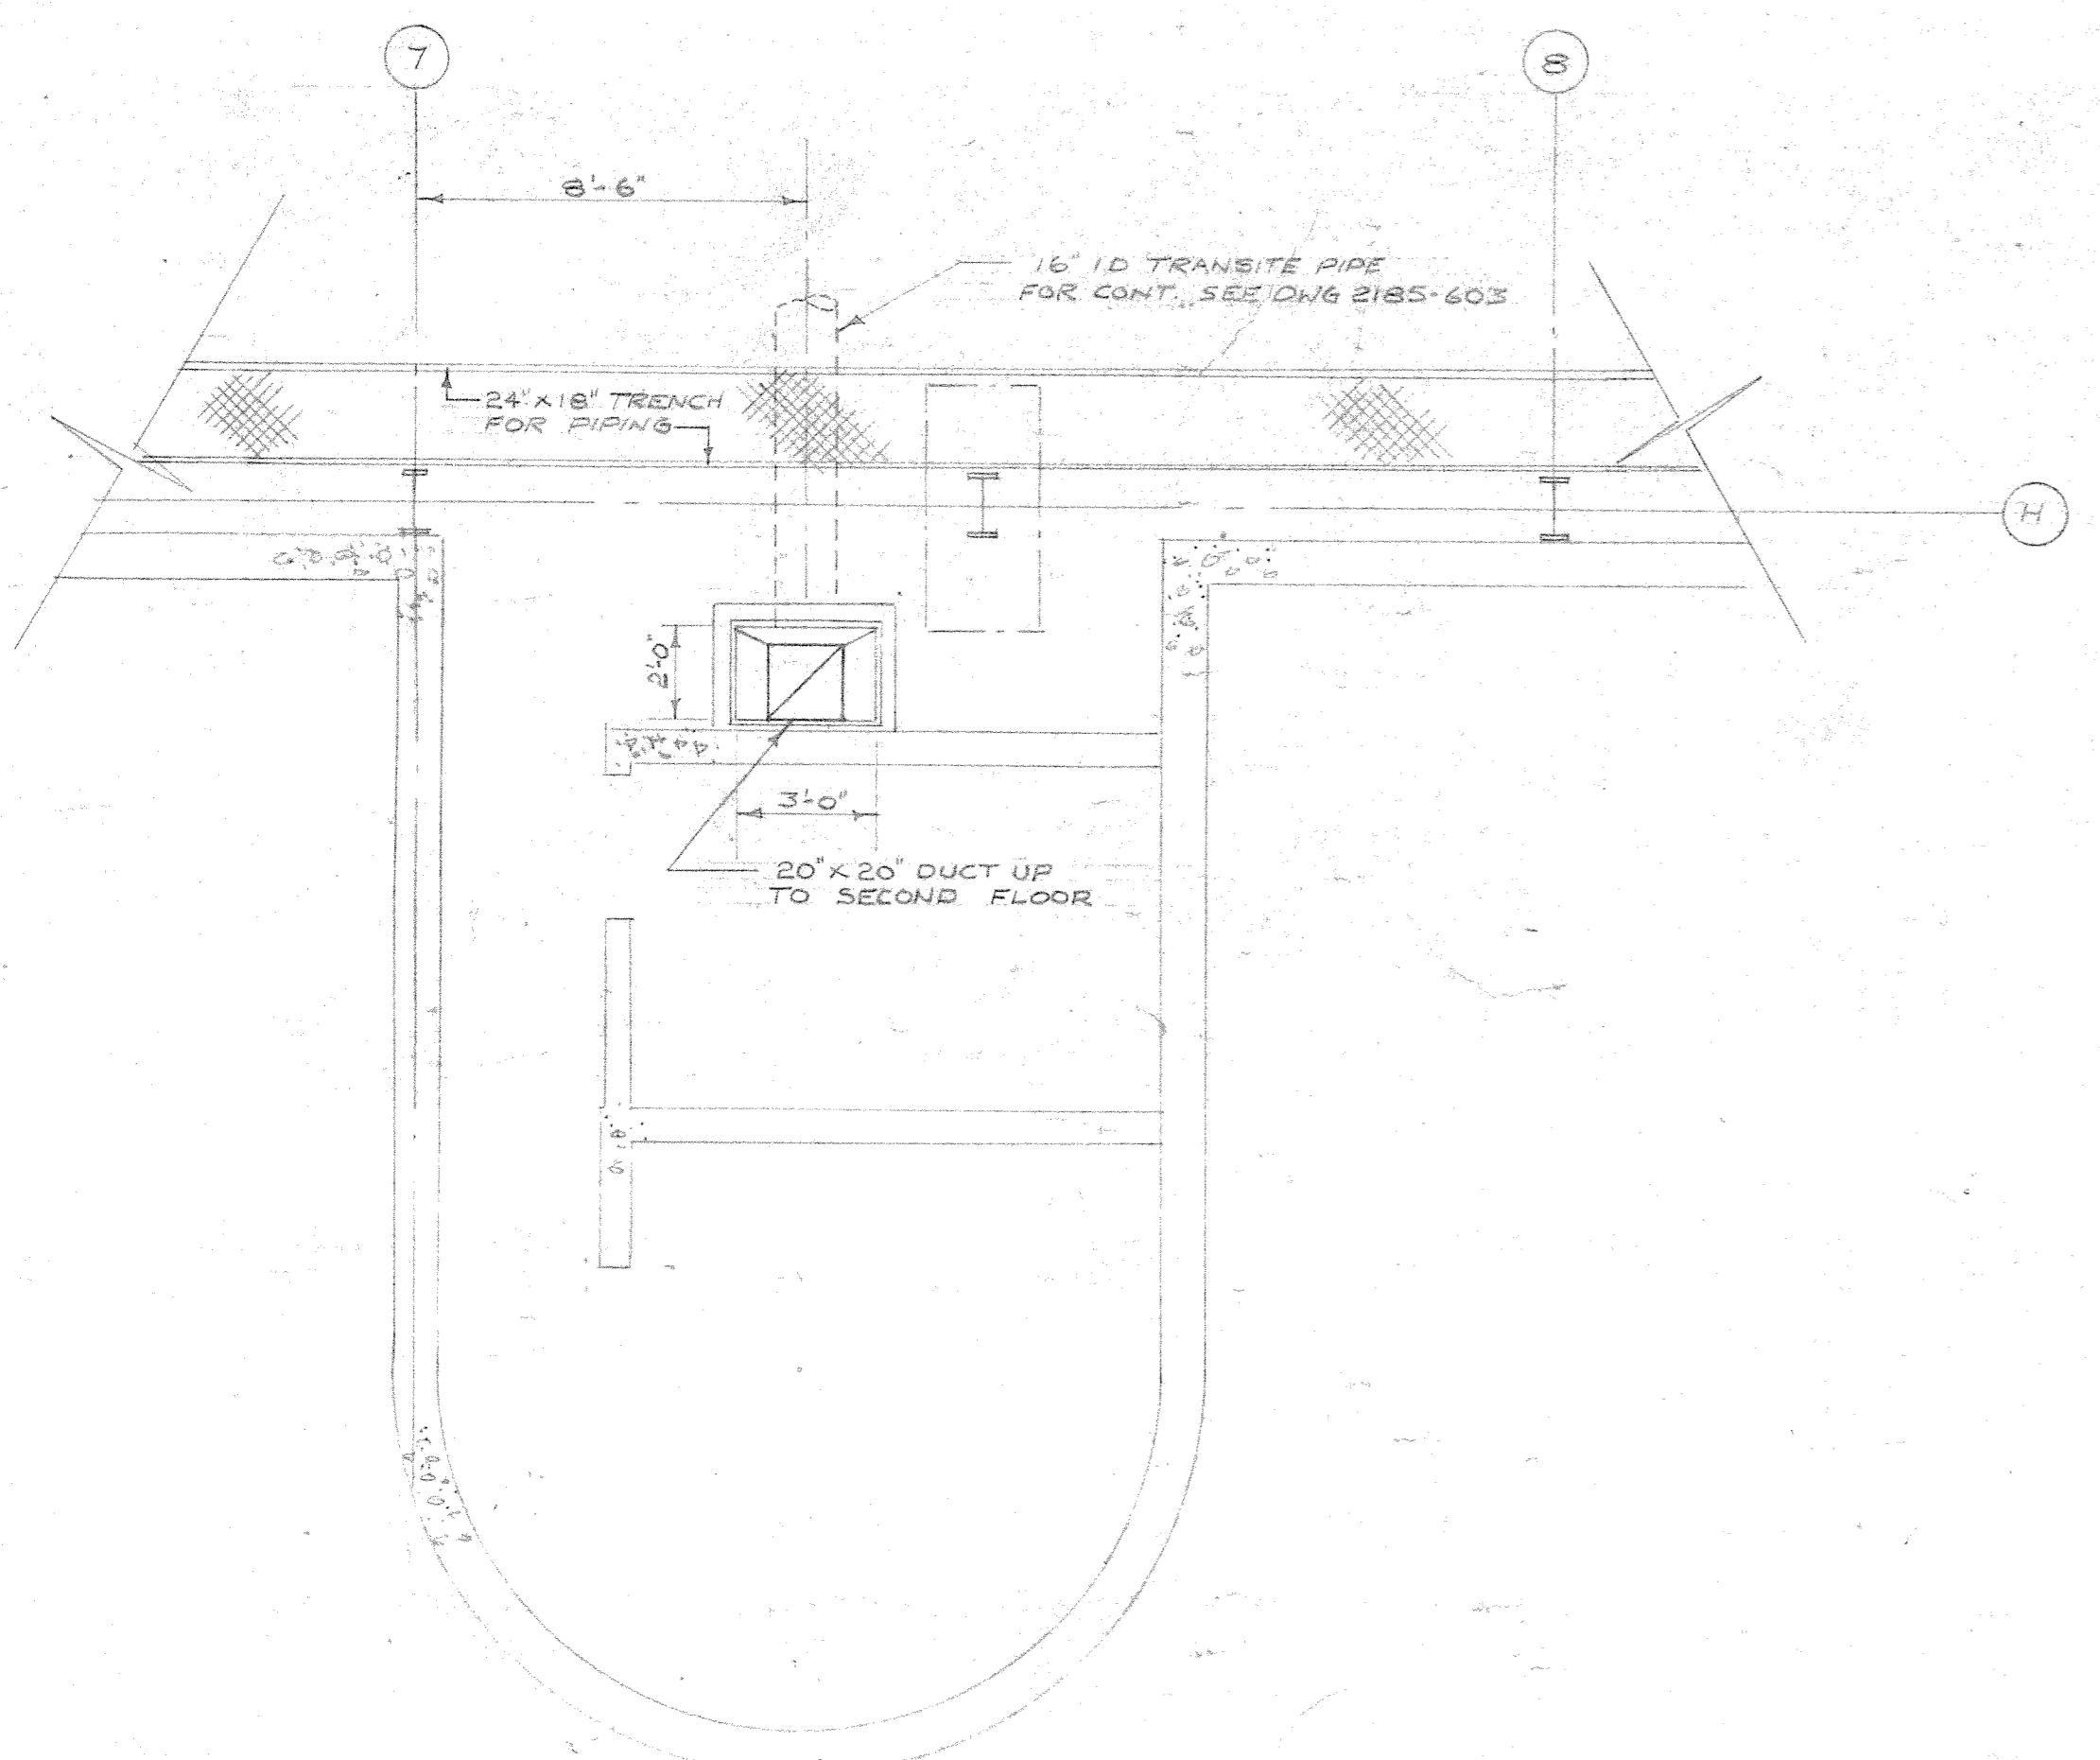


FIRST FLOOR PLAN OF WEST SERVICE PROJECTION  
OVERHAUL & REPAIR BUILDING  
SCALE 1/4" = 1'-0"

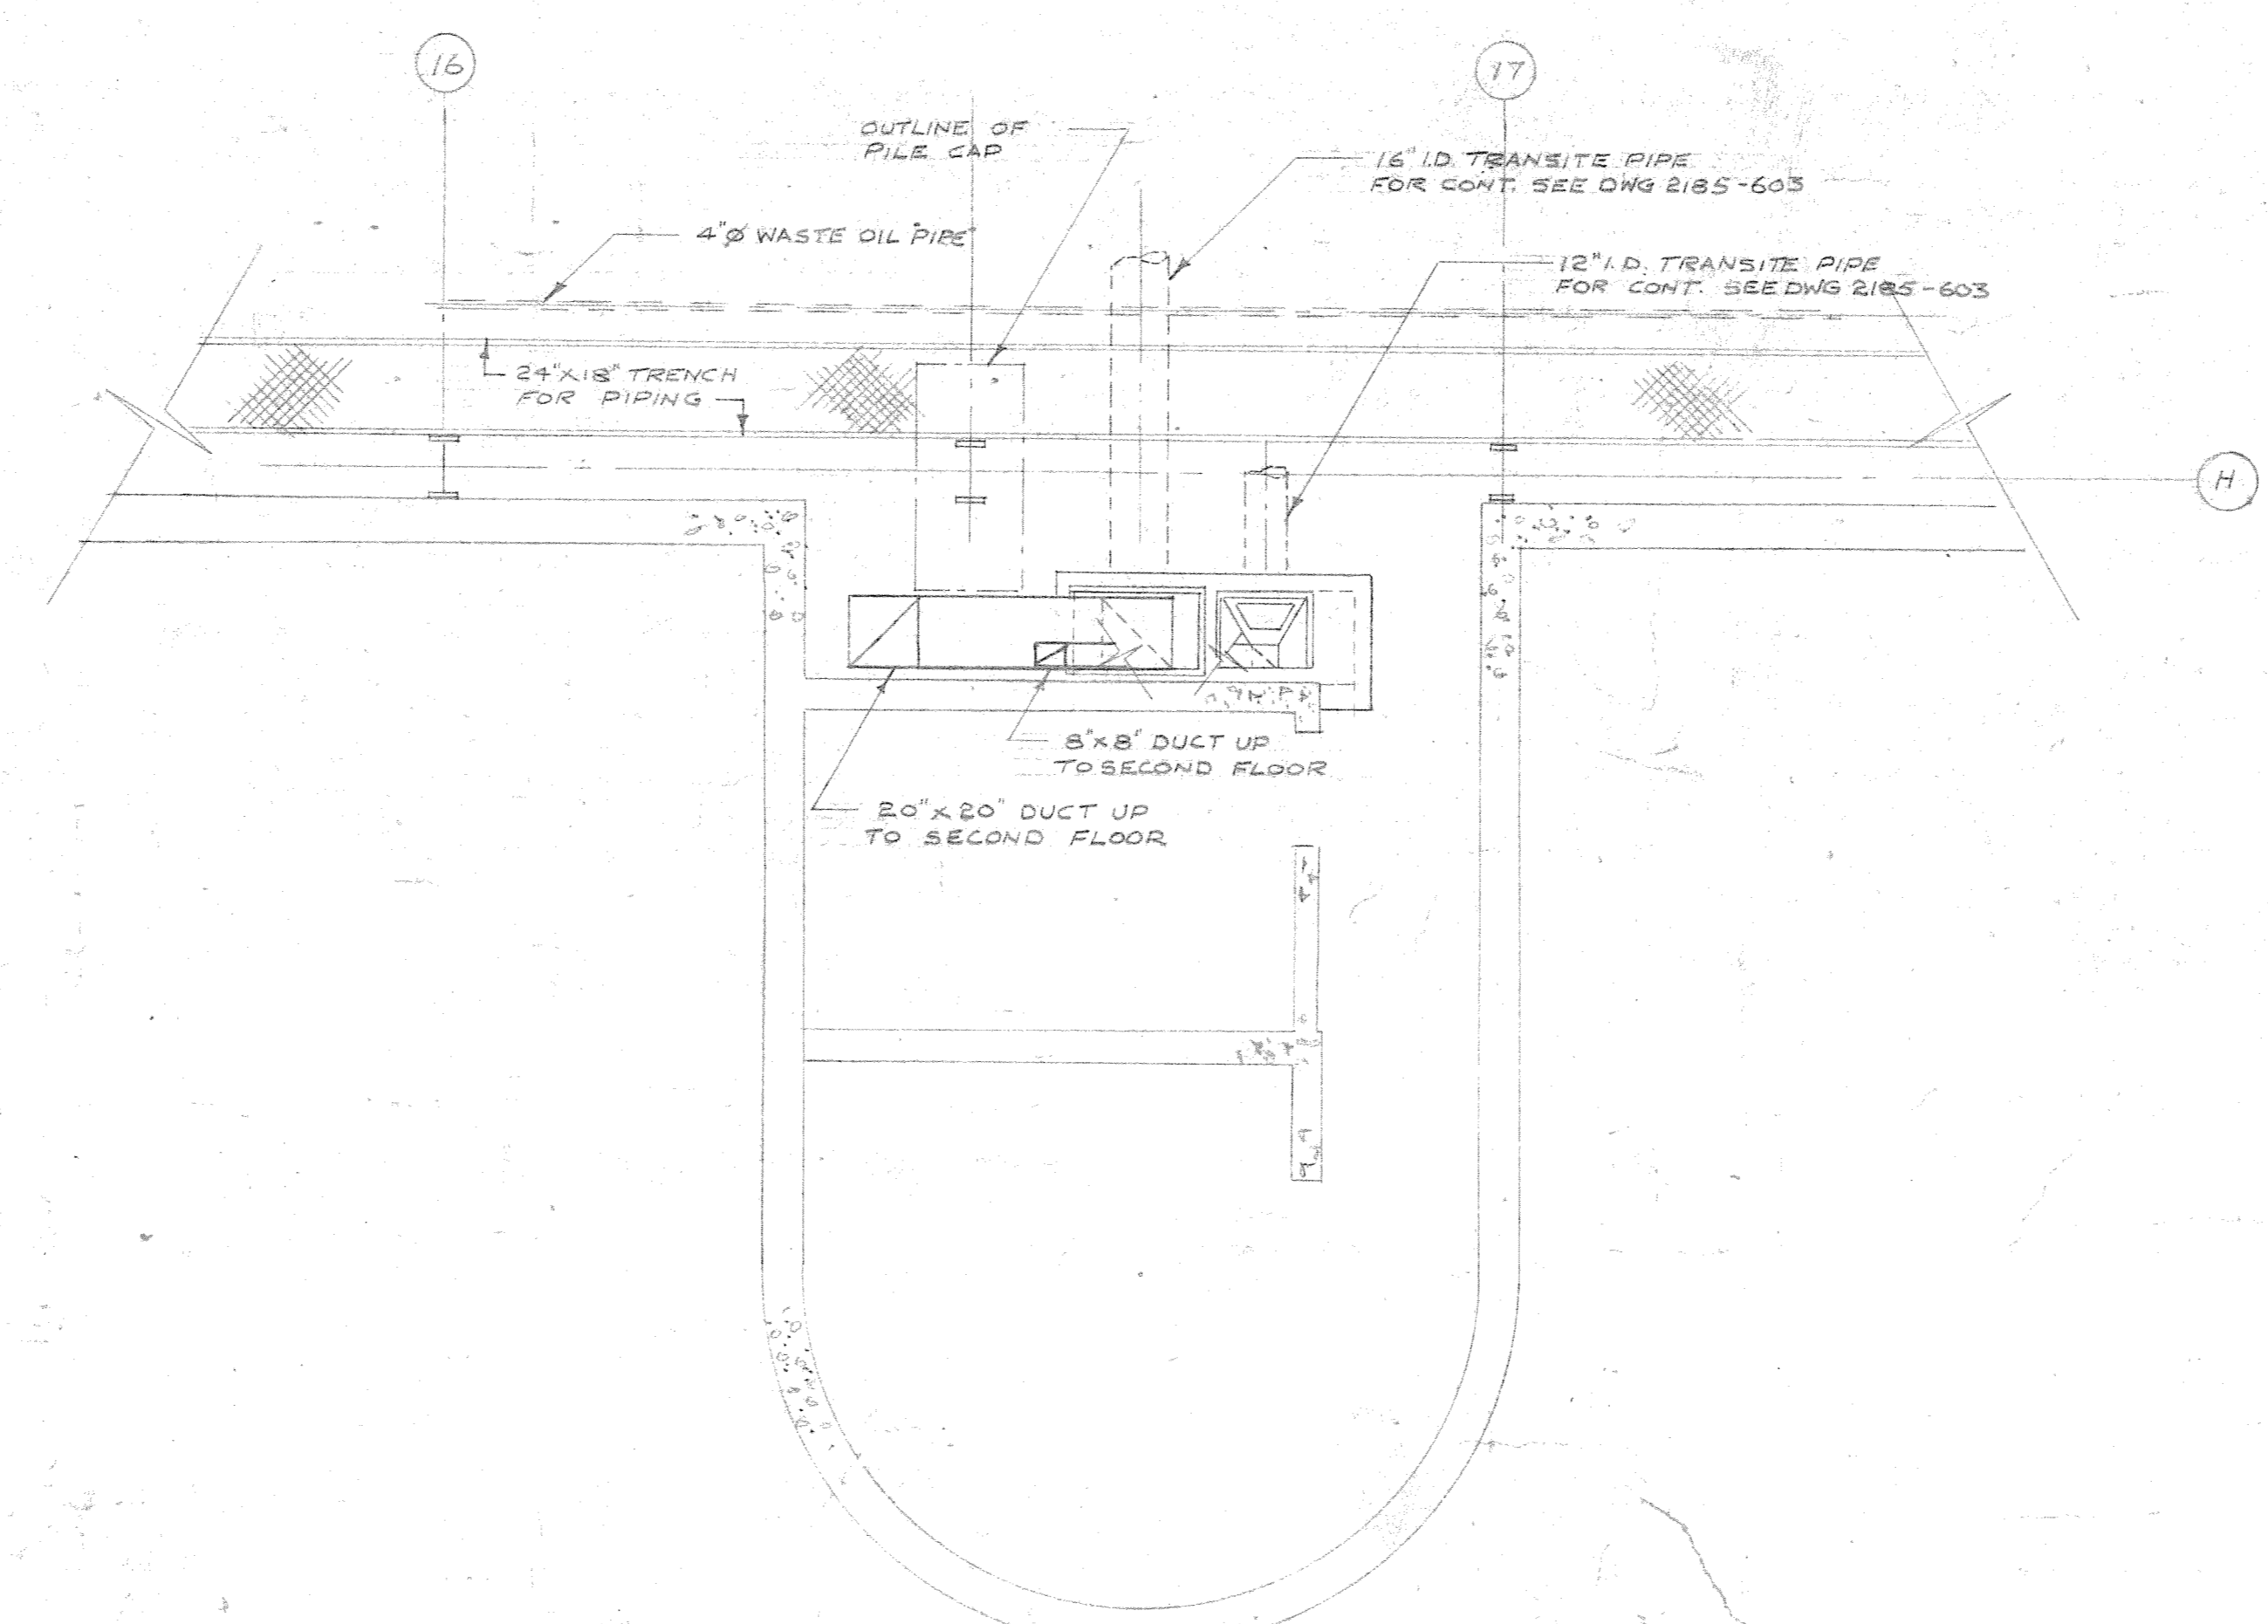


FIRST FLOOR PLAN OF EAST SERVICE PROJECTION  
OVERHAUL & REPAIR BUILDING  
SCALE 1/4" = 1'-0"

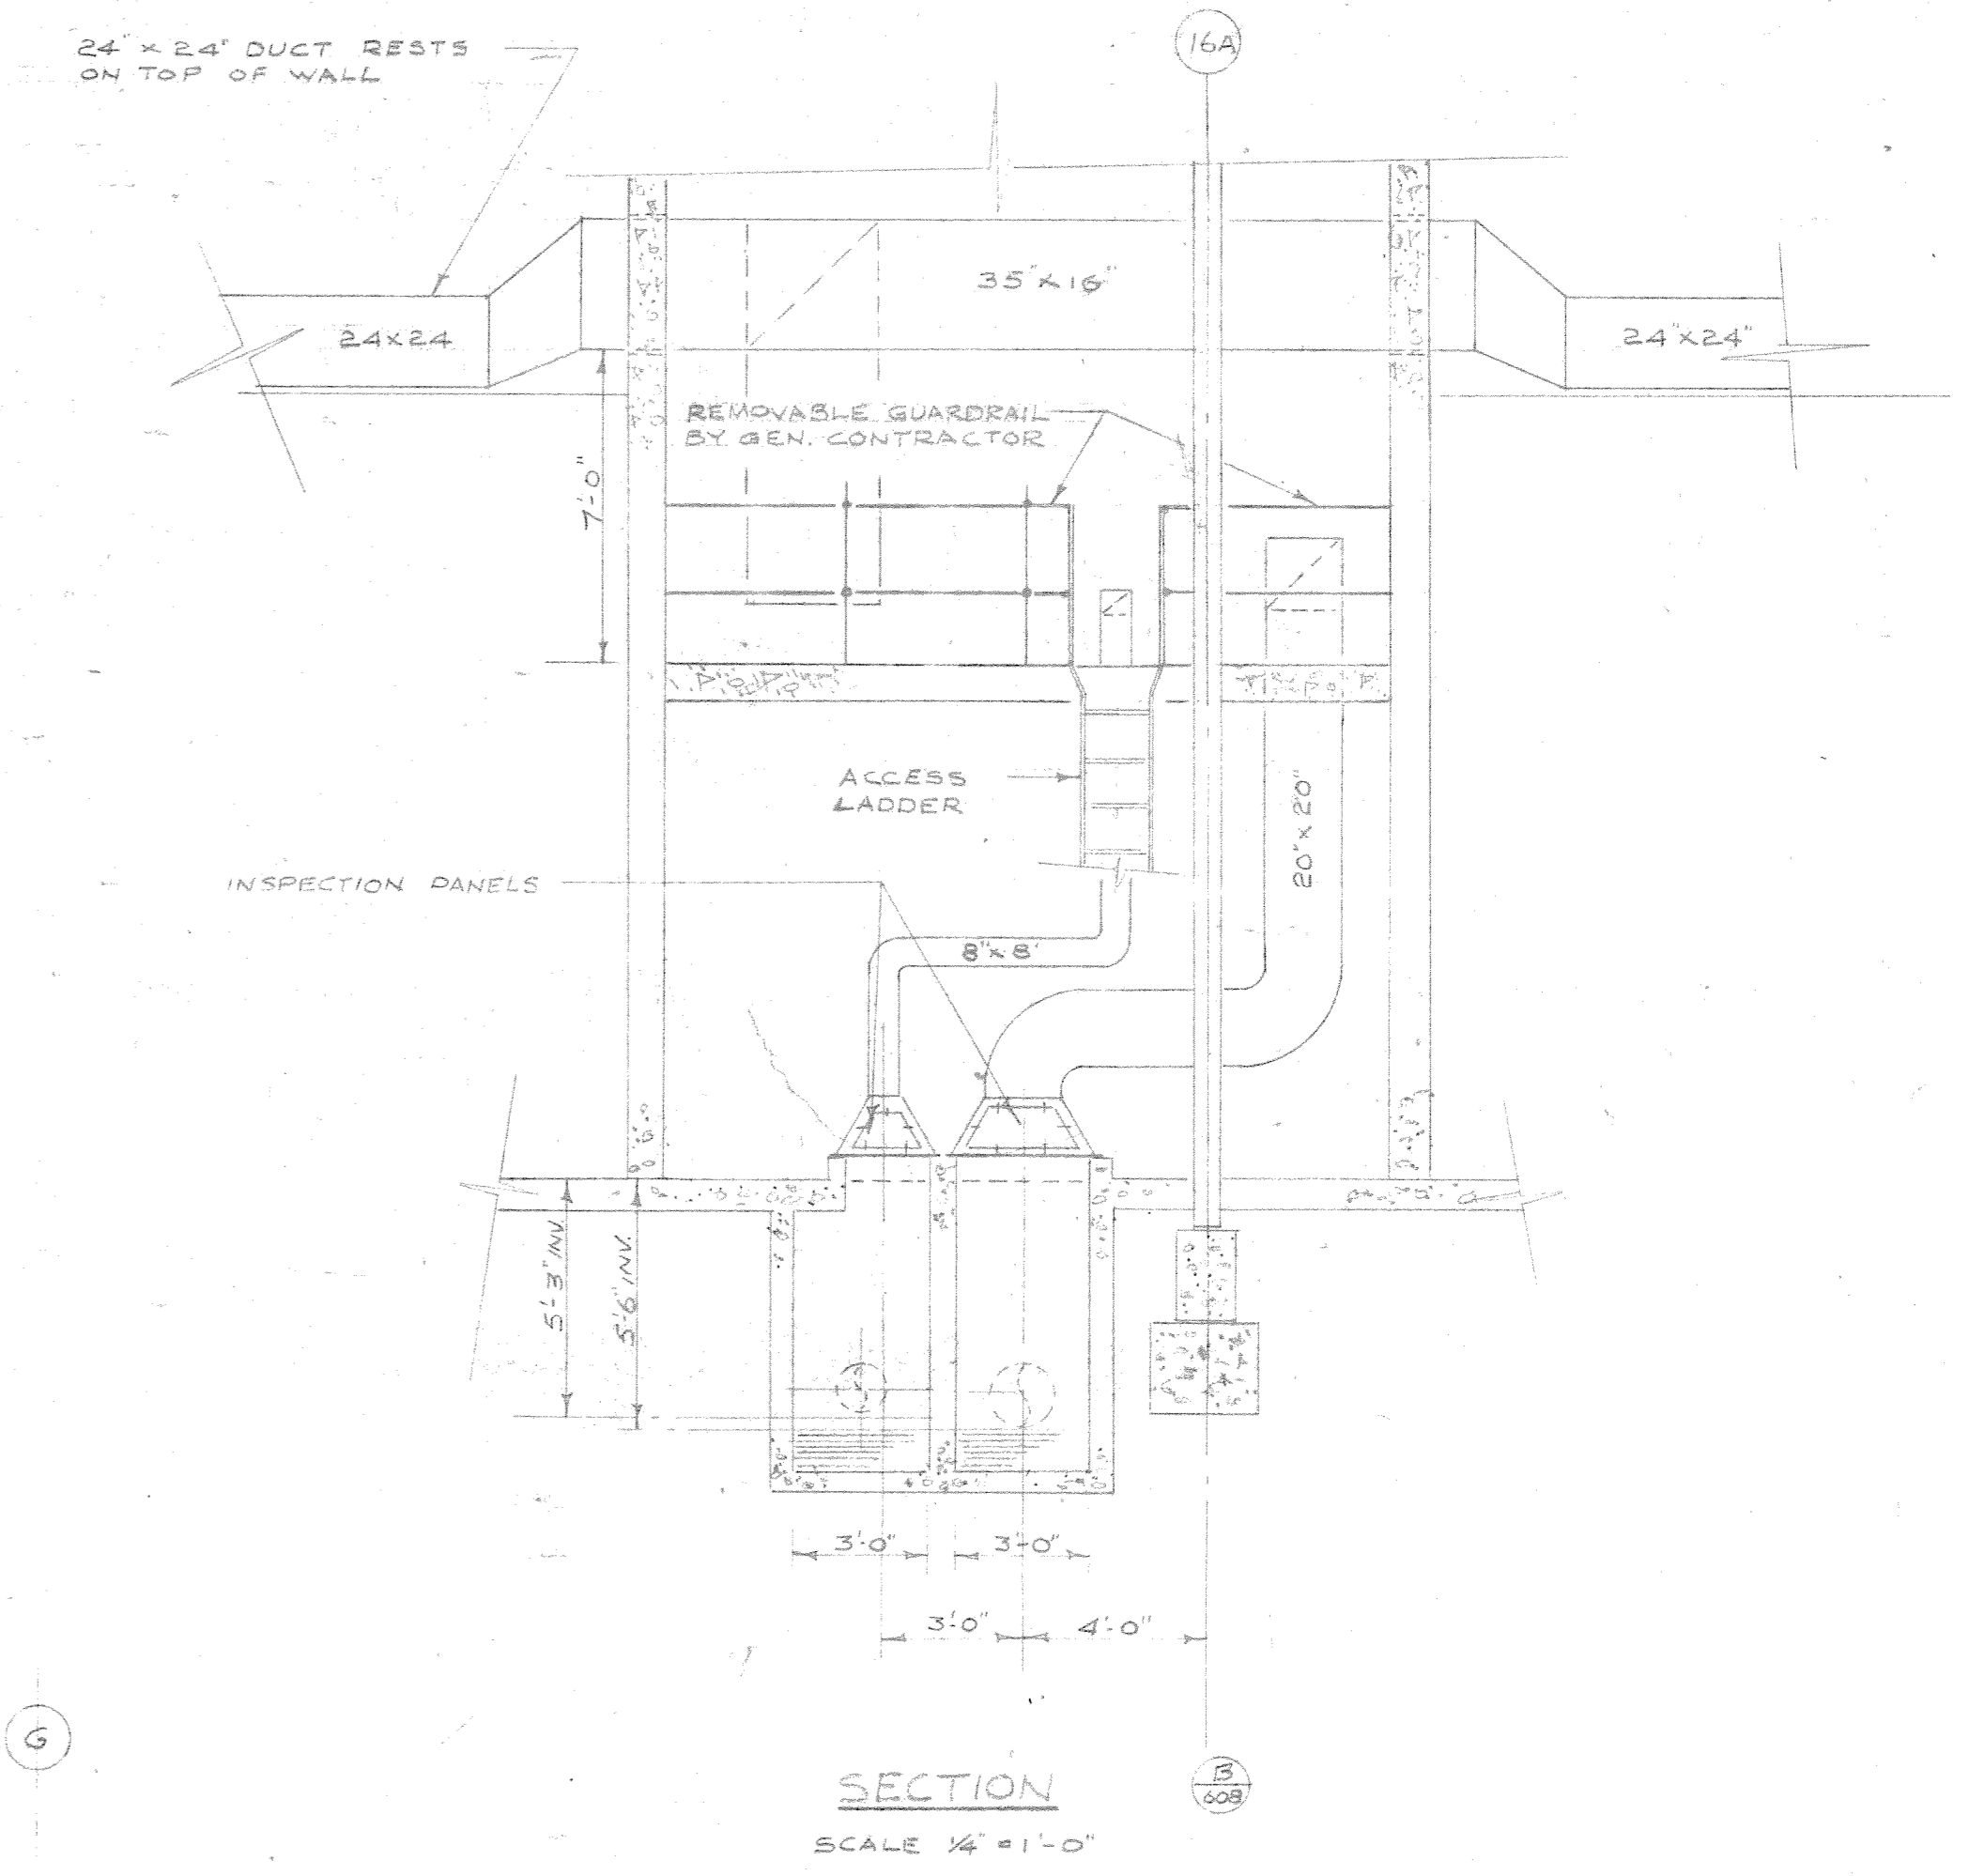


SECTION B-B  
SCALE 1/4" = 1'-0"

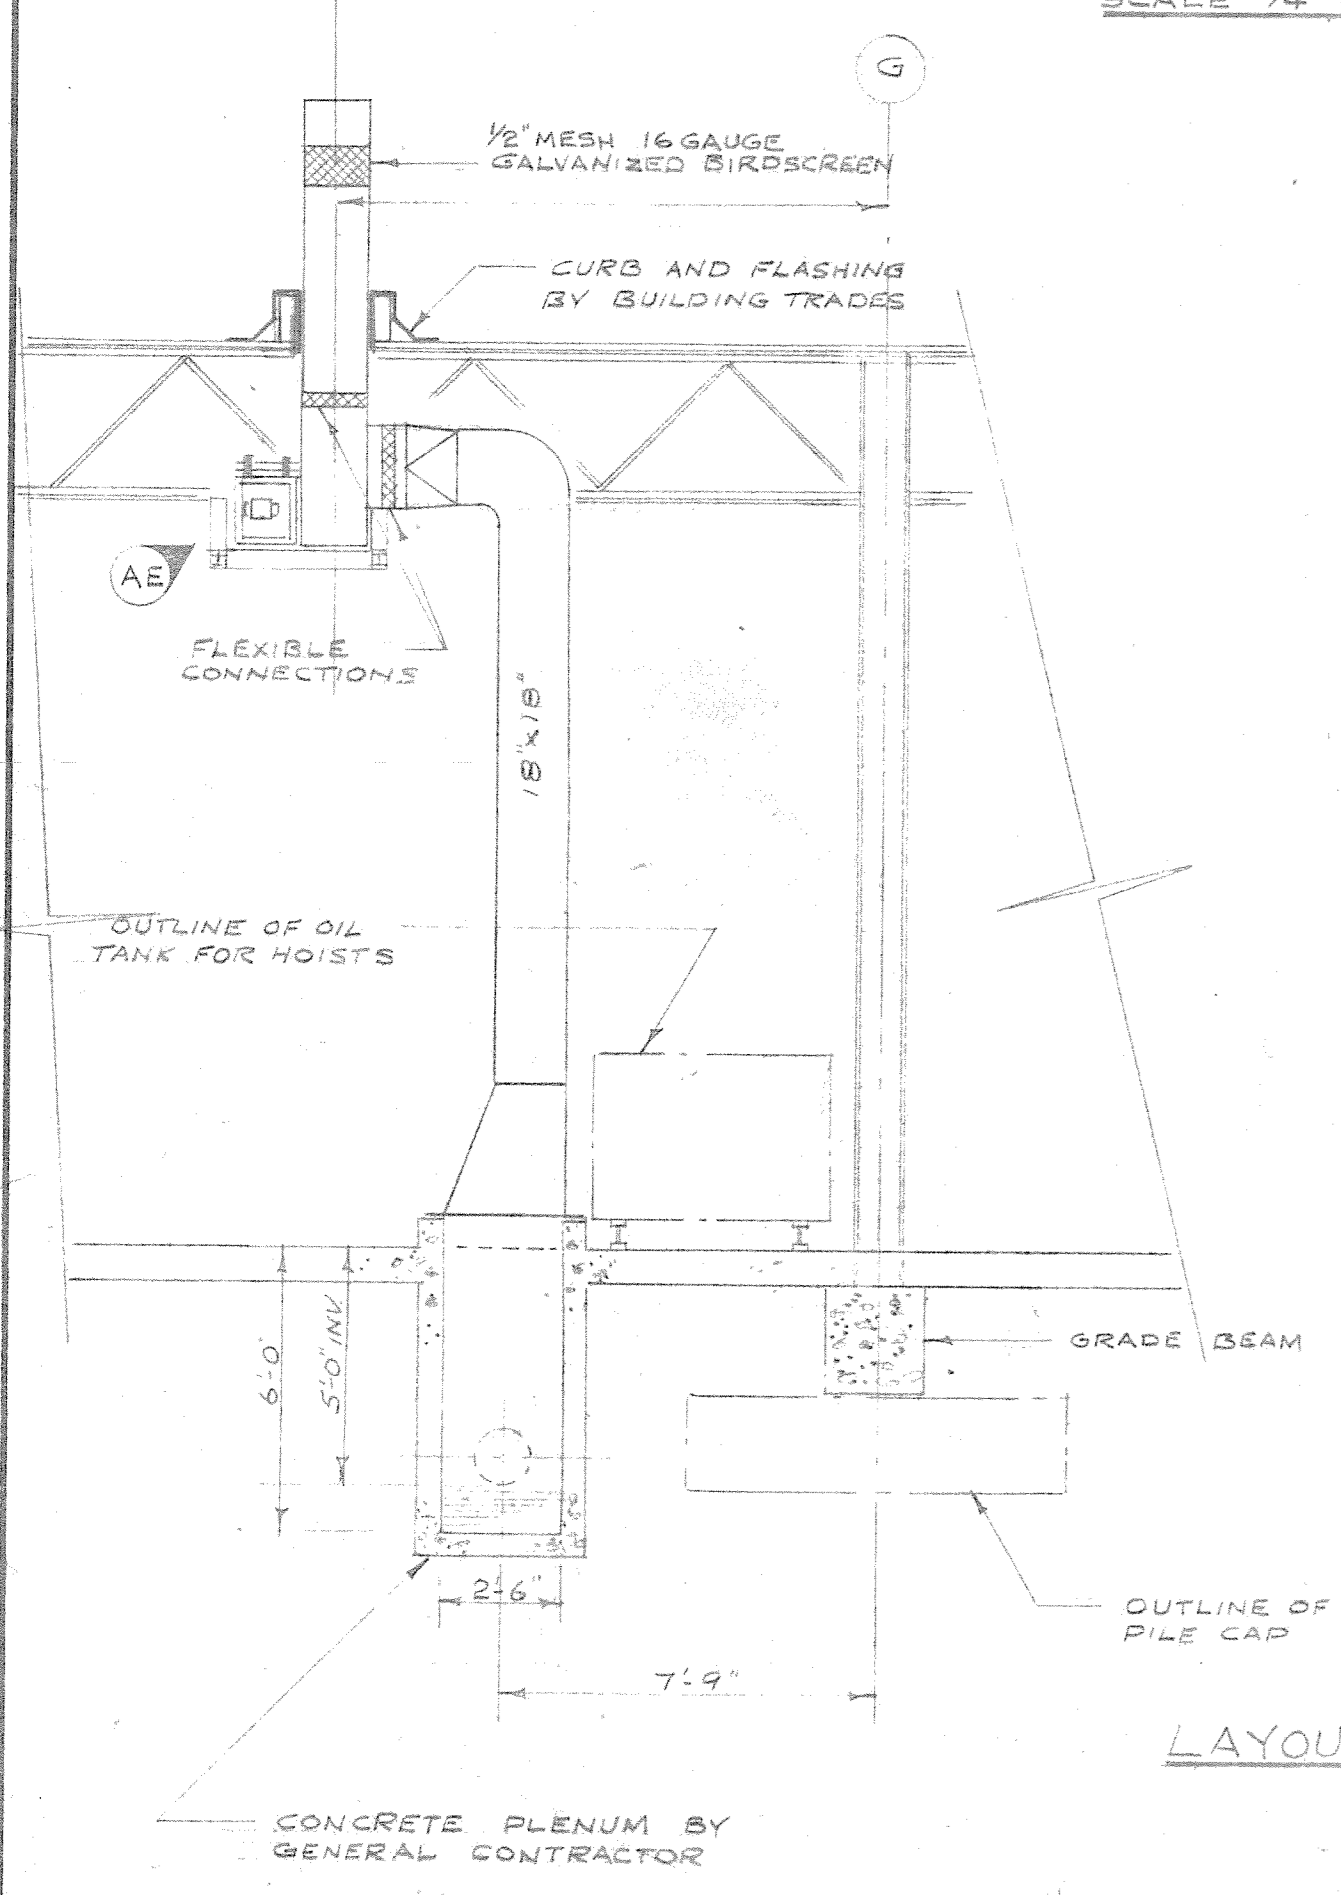

LAYOUT OF WEST SIDE UNIT  
SCALE 1/4" = 1'-0"

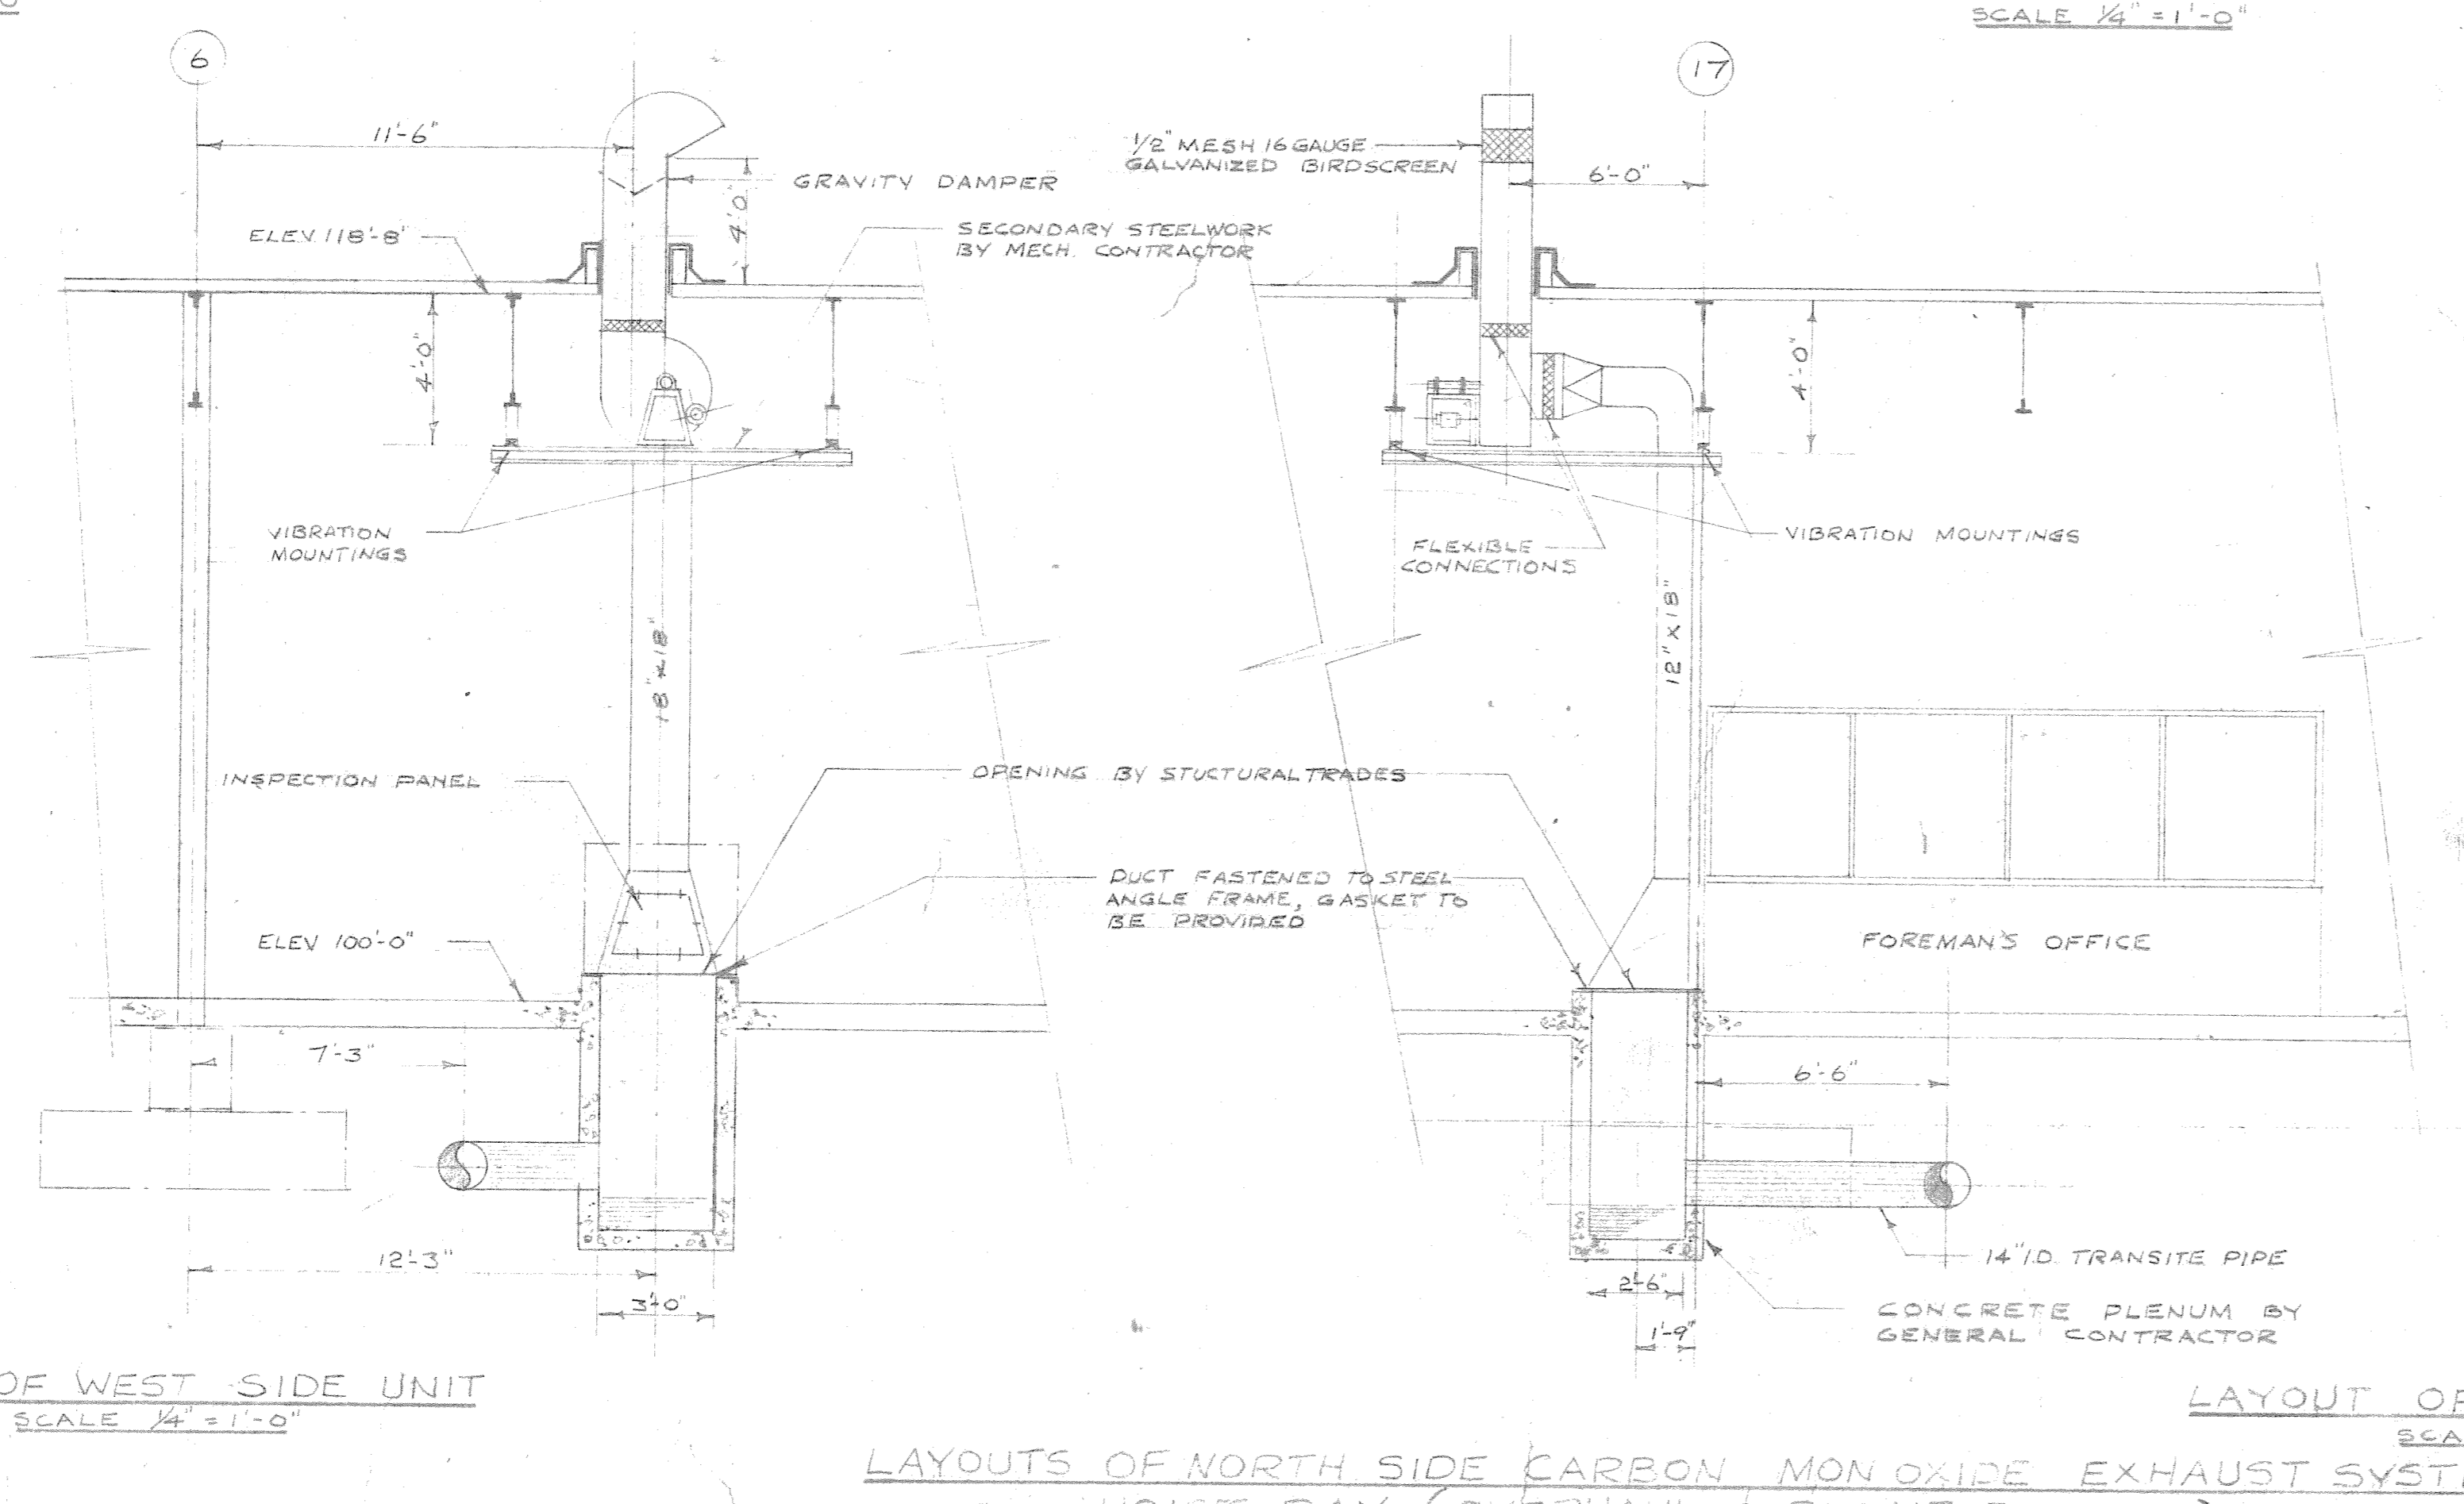

LAYOUTS OF NORTH SIDE CARBON MONOXIDE EXHAUST SYSTEM  
HOIST BAY, (OVERHAUL & REPAIR BUILDING)  
SCALE 1/4" = 1'-0"

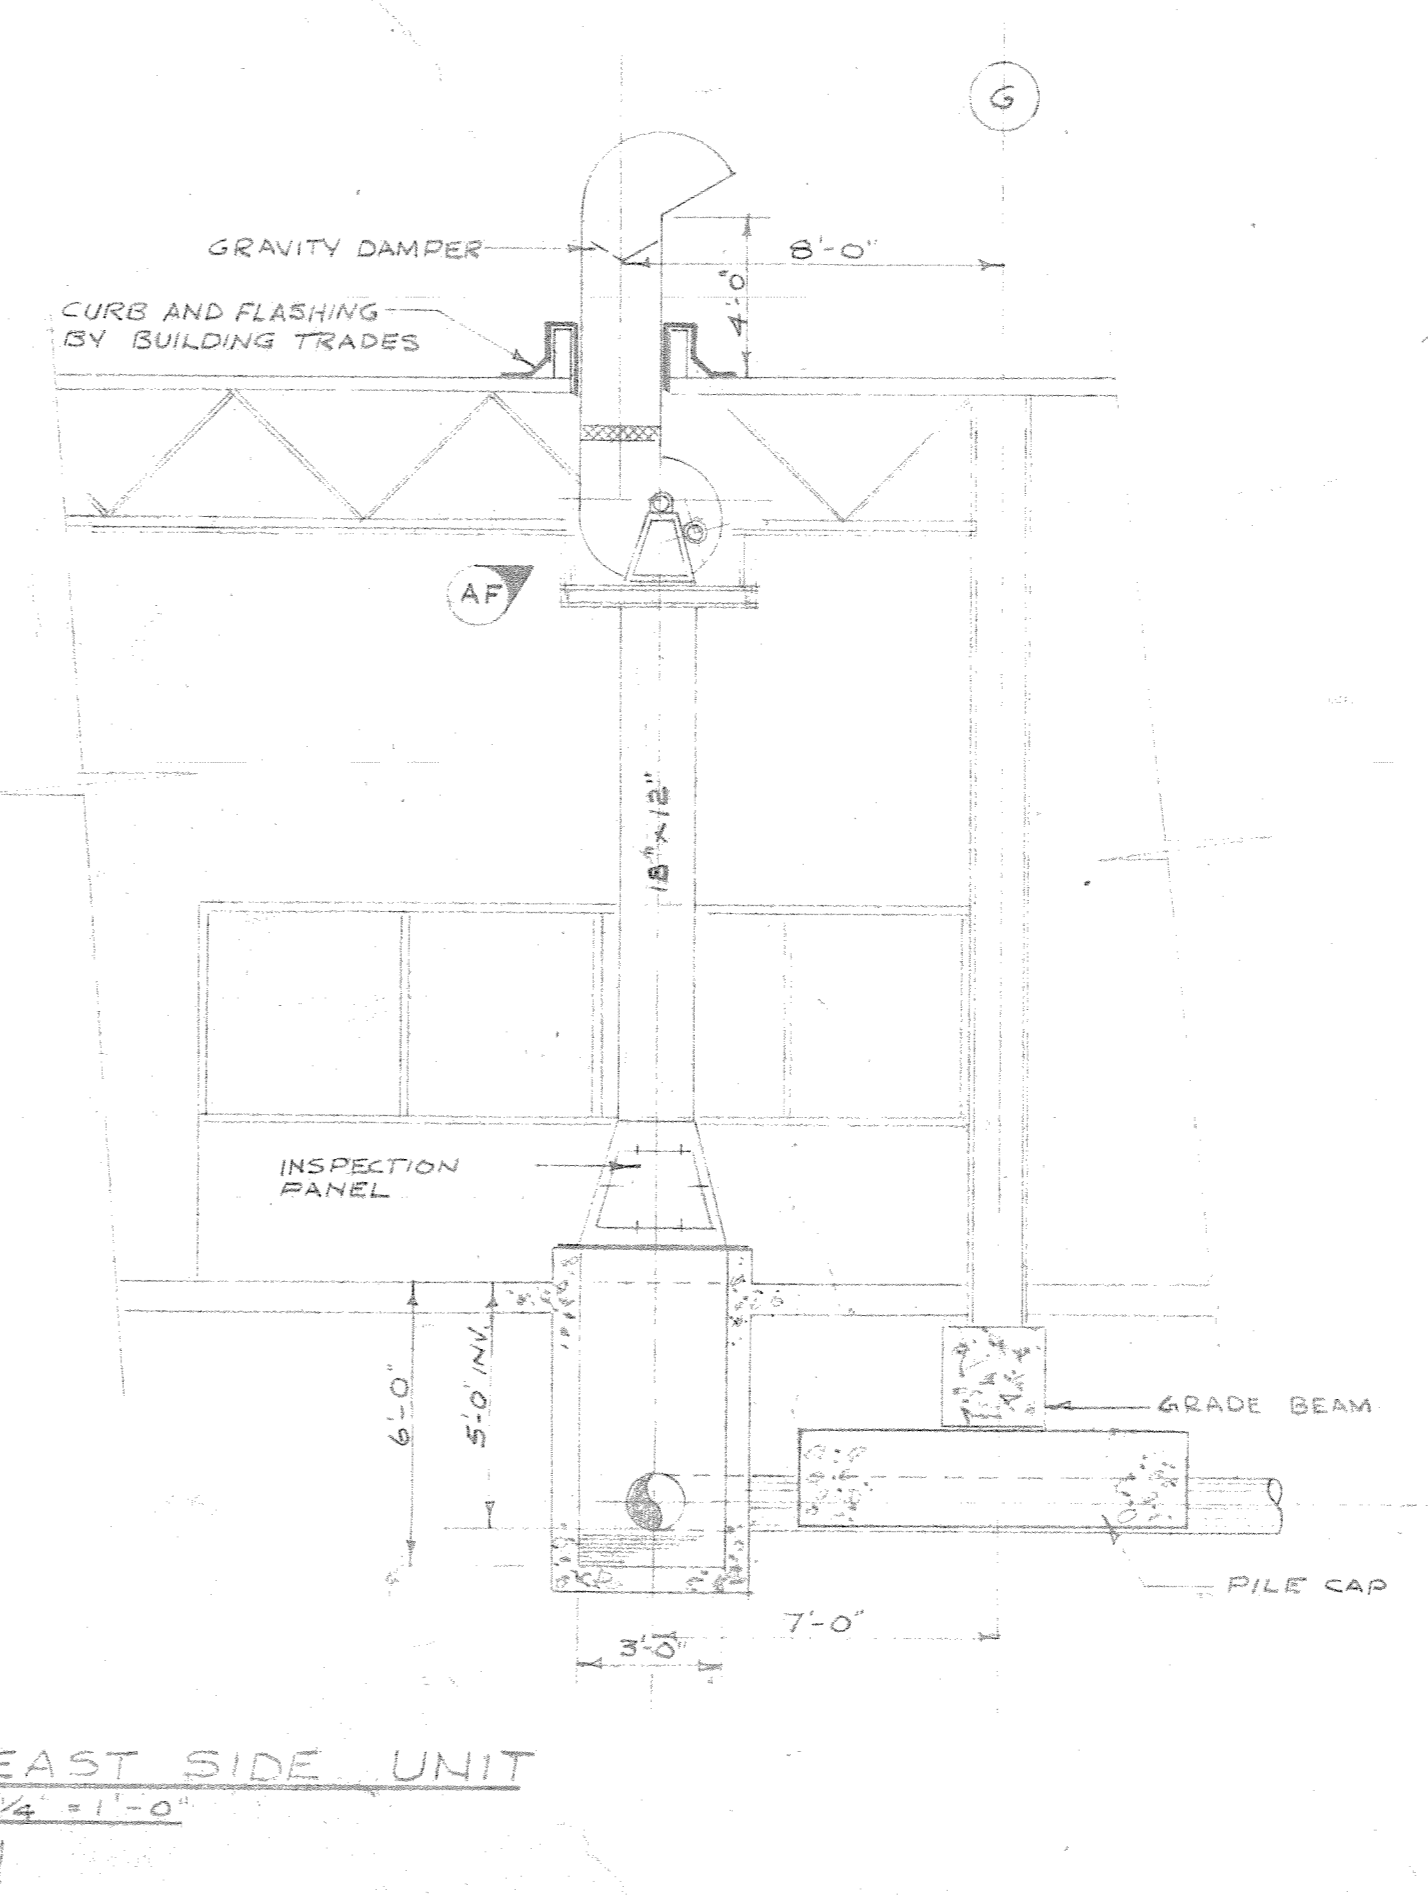

LAYOUT OF EAST SIDE UNIT  
SCALE 1/4" = 1'-0"

NOTE -  
ALL EXHAUST VENTS ARE FITTED WITH BIRDSCREEN AND GRAVITY DAMPER  
ALL EXHAUST FANS TO BE MOUNTED ON VIBRATION ISOLATORS

2185-608

DATE	ISSUE NO.	REV.	DESCRIPTION	DRAWN BY
19/1/68	2	0	FOR TENDER	
26/2/68	1	0	FOR APPROVAL	
ISSUE OR REVISION				
METROPOLITAN CORPORATION OF GREATER WINNIPEG STREETS AND TRANSIT DIVISION				
TRANSIT STORAGE AND SHOP FACILITIES				
HEATING & VENTILATING - DETAILS				
CONSULTING PROFESSIONAL ENGINEERS A. D. MARGISON AND ASSOCIATES LIMITED 1155 LESLIE STREET, DON MILLS, ONTARIO		ARCHITECTS Wickham Ross + Blankstein Coop Gillmor Hanna 10 DONALD STREET, WINNIPEG, MANITOBA		
APPROVED	DATE	DRAWN BY	DATE	
<i>[Signature]</i>	AUGUST '67	<i>[Signature]</i>		
DEPUTY DIRECTOR OF STREETS AND TRANSIT	SCALE	CHECKED	AS SHOWN	
	2185-608	FILE NO.		
	MECHANICAL	SHEET NO.		

LICENSED TO PRACTICE  
IN THE  
PROVINCE OF MANITOBA  
10th Election Expire: 10 Jan. 1968