



PARTIAL MAIN FLOOR PLAN-LIGHTING AND POWER-RENO
 SCALE: 1/8"=1'-0"

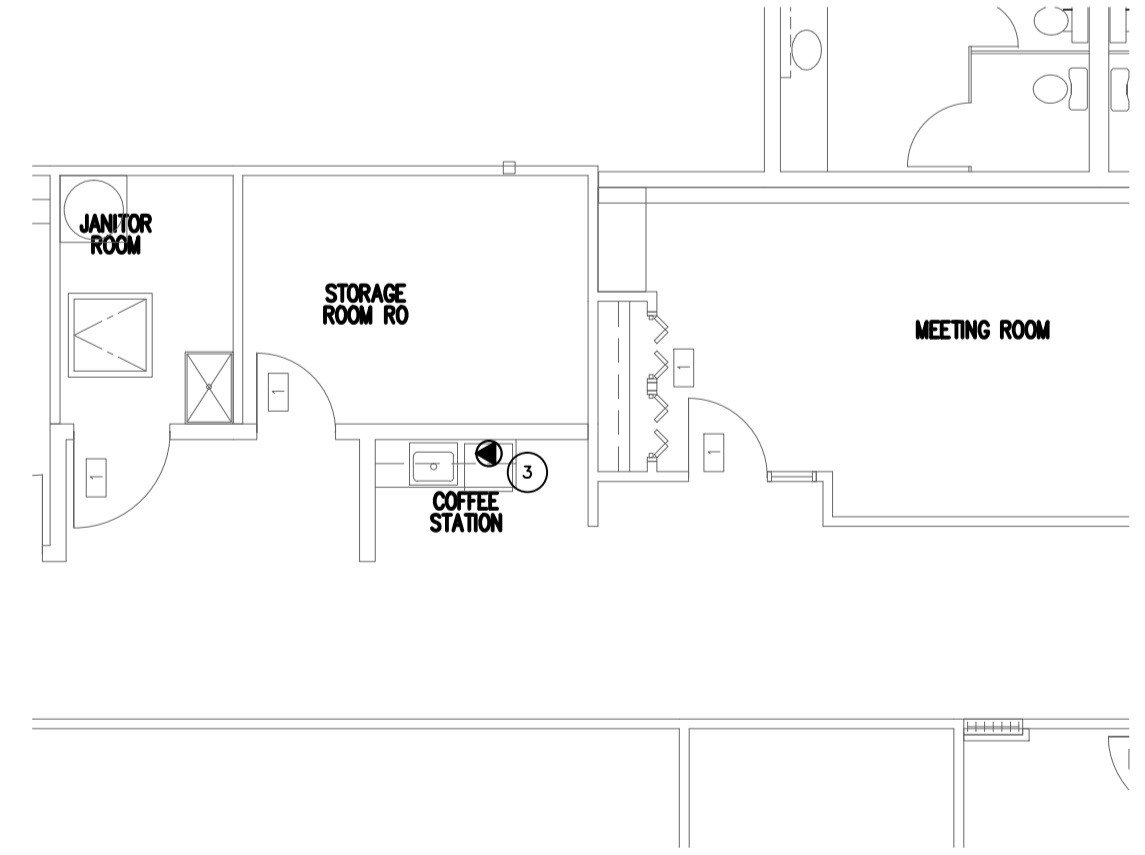


COFFEE STATION-POWER-RENO
 SCALE: 1/8"=1'-0"

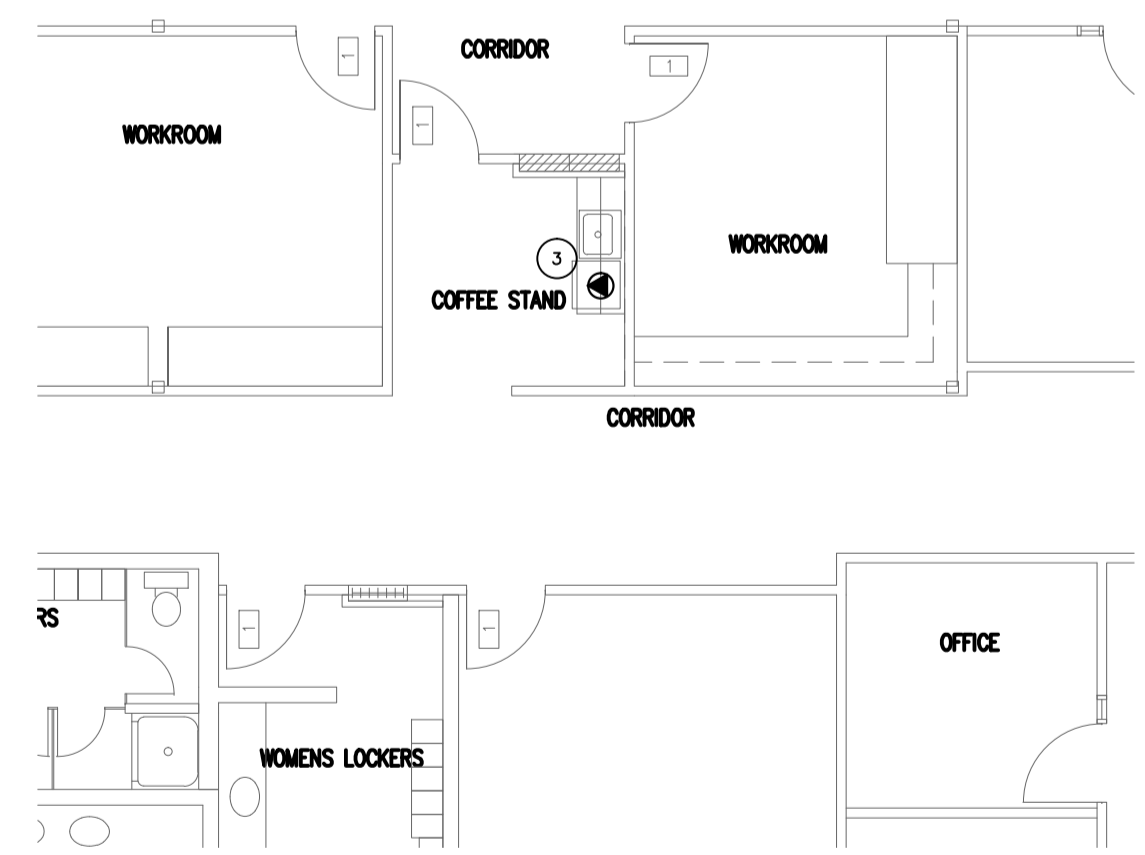

COFFEE STATION-POWER-RENO
 SCALE: 1/8"=1'-0"

KEY NOTES:	
1	PROVIDE A DEDICATED CIRCUIT FOR FRIDGE.
2	PROVIDE A DEDICATED CIRCUIT FOR MICROWAVE.
3	PROVIDE A DEDICATED CIRCUIT FOR DISHWASHER.
4	PROVIDE THESE FIXTURES WITH DIMMING BALLASTS.
5	UTILIZE EXISTING CIRCUITS FROM THIS ROOM. RE-ARRANGE CIRCUITS ON ALL EXISTING OUTLETS TO ALLOW REUSE OF CIRCUITS FOR NEW OUTLETS SHOWN.
6	RECONNECT THESE FIXTURES TO THE EXISTING SWITCHED LIGHTING POWER IN THIS ROOM.
7	NEW LOCATION OF RELOCATED OUTLETS.
8	WIRE AND CONNECT EHC-1 AND VAV-1 TO A 15A - 1P BREAKER. USE THE PANEL THAT SUPPLIES SIMILAR EQUIPMENT IN THE AREA.
9	WIRE AND CONNECT NEW EXHAUST FAN TO A 15A-1P BREAKER TO THE CLOSEST PANEL WITH CAPACITY. CONNECT TO A WALL MOUNTED SWITCH.
10	NEW SWITCHES TO BE OCCUPANCY SENSOR TYPE TO MATCH EXISTING.
11	NEW LOCATION FOR COPIER. UTILIZE SAME CIRCUIT FROM PREVIOUS LOCATION ALONG HALF WALL.
12	PROVIDE CEILING MOUNTED OUTLETS FOR PROJECTOR. INCLUDE A 25mm C FROM THE CEILING MOUNTED JUNCTION BOX TO THE WALL MOUNTED JUNCTION BOX.
13	NEW LOCATION OF RELOCATED FIRE ALARM HORN.
14	WIRE AND CONNECT POWER TO A REDUNDANT CIRCUIT FROM THE DEMOLISHED HALF WALL. PROVIDE NEW VOICE/DATA HOME RUNS BACK TO PATCH PANEL. CAT6 CABLE TO BE USED.

NOTES:

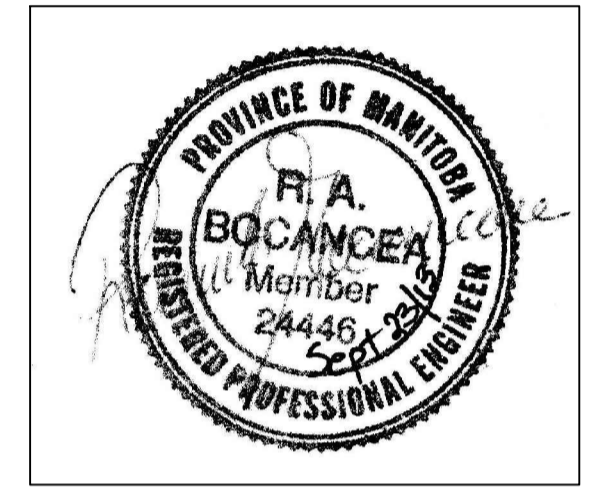

1	ISSUED FOR CONSTRUCTION	KO	23/09/13
No.	REVISION/DESCRIPTION	BY	DATE

DRAWN	KOLO	CHECKED	DESIGNED	KO	APPROVED
DATE	2013.09.23	USER	APPROVAL		

Winnipeg THE CITY OF WINNIPEG
 PLANNING, PROPERTY AND
 DEVELOPMENT DEPARTMENT
 MUNICIPAL ACCOMMODATIONS DIVISION
 3-65 GARRY STREET, R3C 4K4

PROJECT
 WASTE WATER SERVICES
 ALTERATIONS TO WASTE WATER
 OFFICE AREAS
 1199 PACIFIC AVENUE

SHEET TITLE
 RENOVATION
 LIGHTING AND POWER

SCALE	PROJECT No:	SHEET No:
AS SHOWN	2013-101	E.2.1