



DILLON CONSULTING LIMITED 485 RICHMOND STREET, LONDON, ONTARIO, CANADA N6A 5A9, PHONE (519) 438-6192, FAX (519) 672-8209

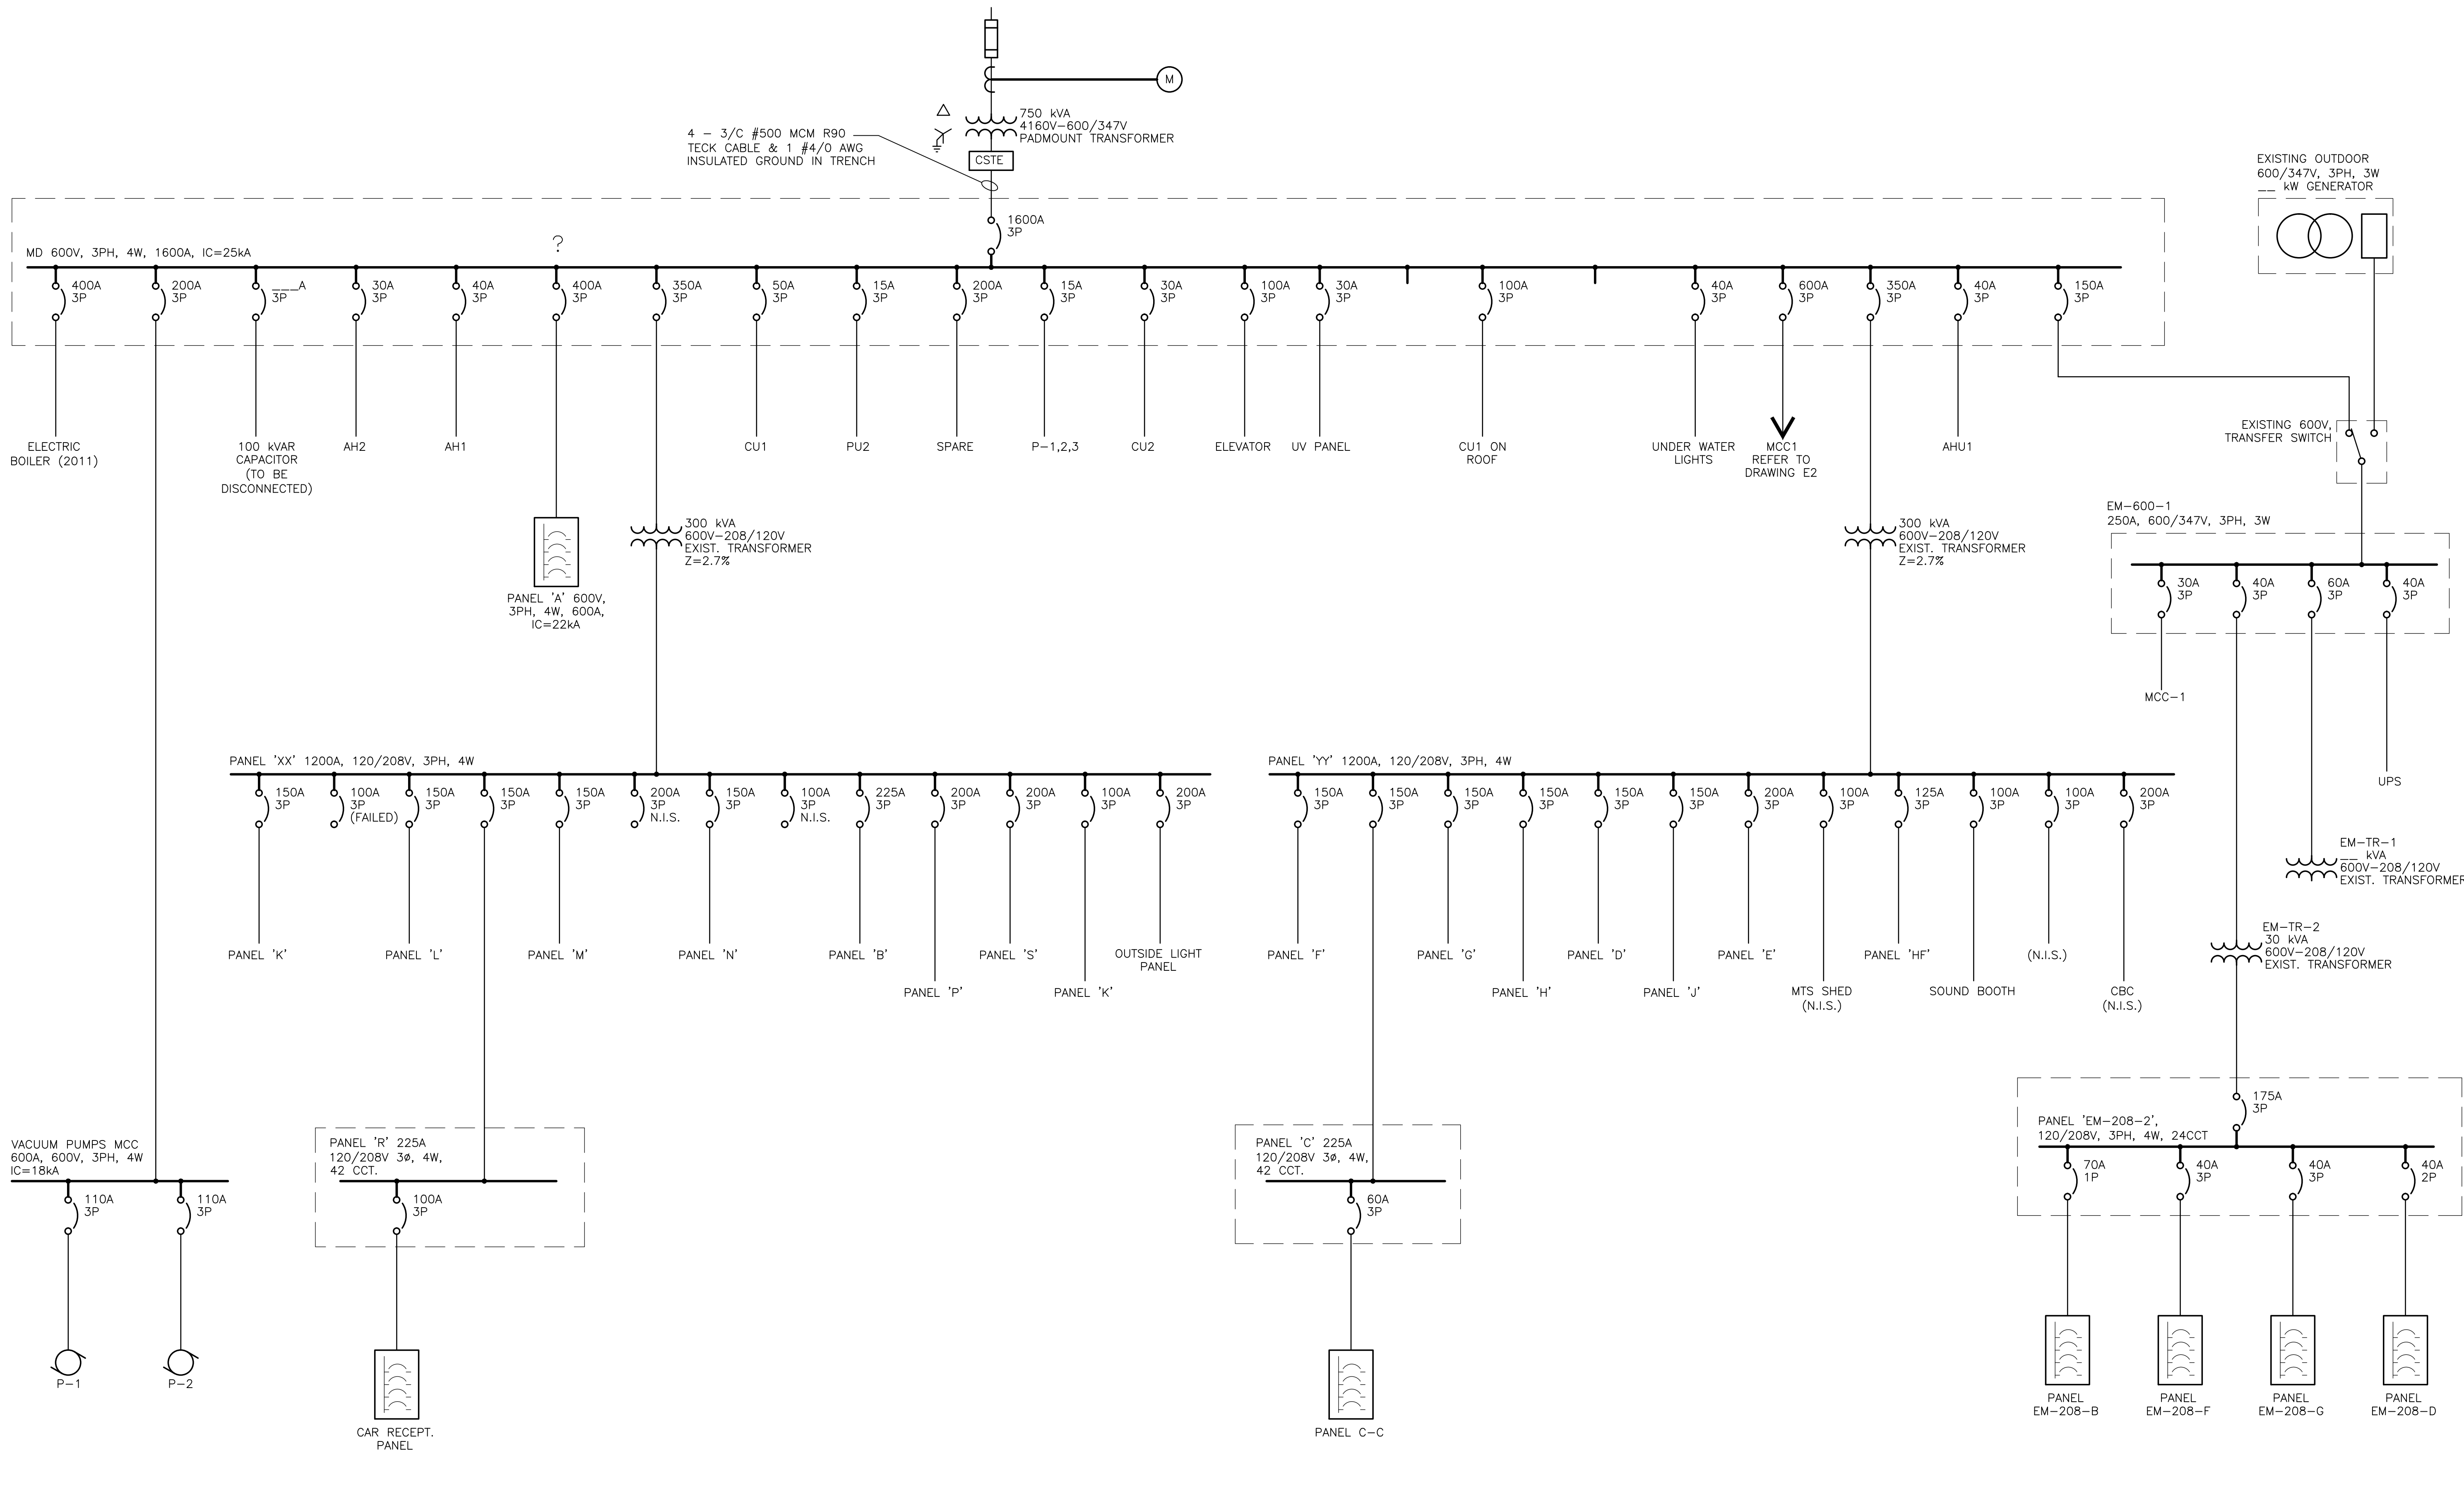

Conditions of Use
 Verify elevations and/or dimensions on drawing prior to use. Report any discrepancies to Dillon Consulting Limited.
 Do not scale dimensions from drawing.
 Do not modify drawing, re-use it, or use it for purposes other than those intended at the time of its preparation without prior written permission from Dillon Consulting Limited.

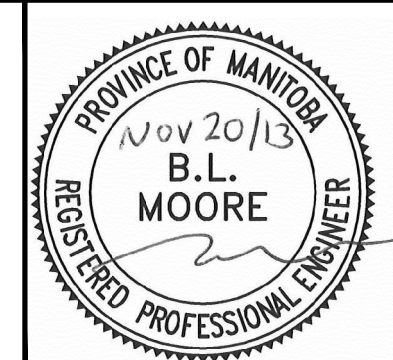

DESIGN	REVIEWED BY
DRAWN	CHECKED BY
DATE	FEB. 12, 2013
SCALE	N.T.S.
0	ISSUED FOR BID OPPORTUNITY NUMBER 850-2013
No.	ISSUED FOR
	DATE
	BY

PAN AM POOL ELECTRICAL UPGRADE		PROJECT NO. 137300
ELECTRICAL - DEMOLITION SINGLE LINE DIAGRAM 1 OF 2		SHEET NO. E401

File Name: g:\cad\137300\contract\form\electrical\el401.dwg