

1 ROOF PLAN - SANITARY AND STORM WATER PIPING  
1 : 75

**DRAWING NOTES:**

- ① PIPE UP TO CONTROL ROOF DRAIN.
- ② SANITARY VENT THROUGH ROOF. PROVIDE FLASHING, COORDINATE WITH ROOFING SYSTEM AND ROOFING CONTRACTOR.
- ③ APPROX. LOCATION OF EXISTING RAIN WATER LEADER. COORDINATE TIE-IN ELEVATION, SIZE AND LOCATION ON SITE.
- ④ STORM WATER PIPING AT HIGH LEVEL. COORDINATE EXACT ROUTE ON SITE (TYPICAL).
- ⑤ PROVIDE HEAT TRACE FOR THE FIRST 3.0m OF PIPING; SELF-REGULATING TYPE C/W CONTROL AS REQUIRED.


 
**LEGEND:**

- ↑ PIPE RISER DOWN
- COIL— CLEAN OUT

REFERENCE DRAWINGS	
NO.	DESCRIPTION

**NOTES:**

- 1. REFER TO DWG 1329720500-DWG-M0007 FOR MECHANICAL SCHEDULES.
- 2. REFER TO DWG 1329720500-DWG-S0003 FOR MAIN FLOOR STRUCTURAL DETAILS.
- 3. REFER TO DWG 1329720500-DWG-B0002 FOR MAIN FLOOR BUILDING DETAILS.
- 4. REFER TO DWG 1329720500-DWG-M0001 FOR PLUMBING LEGEND.

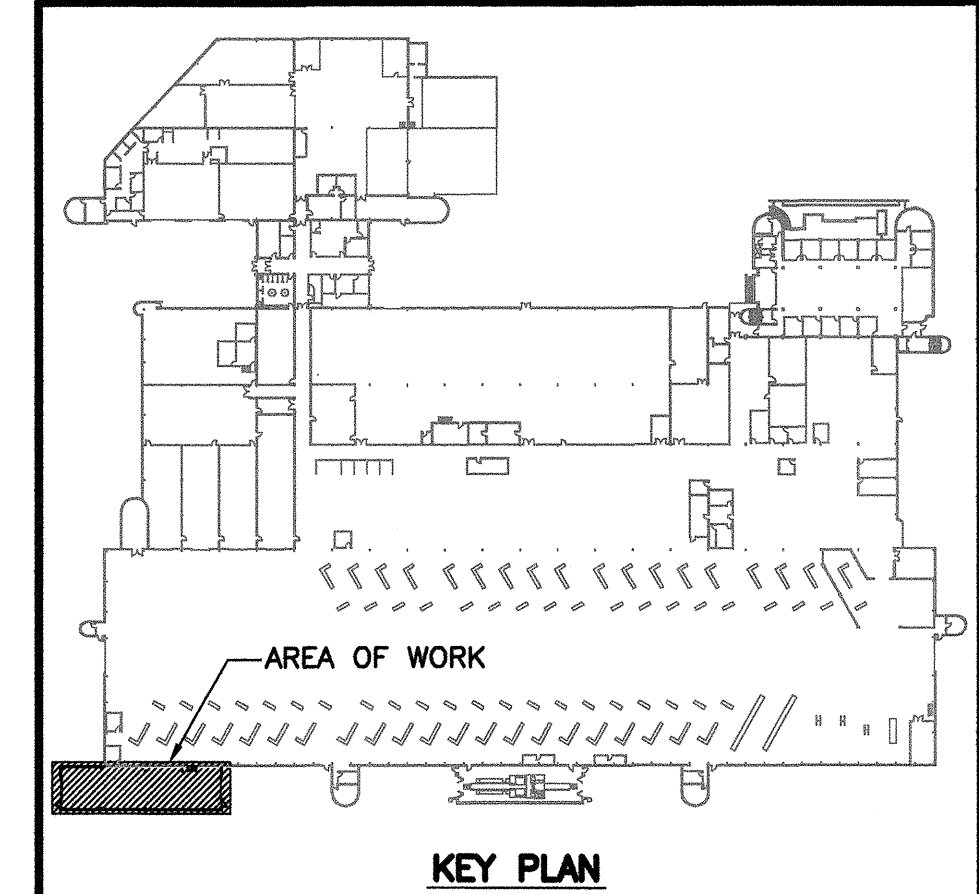

NO.	DATE	DESCRIPTION	PREPARED	REVIEW	DESIGN	AUTHORIZED
01	14.01.17	ISSUED FOR CONSTRUCTION	DD	JS	TS	TS

REGISTERED PROFESSIONAL ENGINEER

DESIGNED BY: TS	PREPARED BY: EV	REVIEWED BY: JS
AUTHORIZED BY: [Signature]	DATE: 13.11.20	SCALE: AS NOTED

THE CONTENT OF THIS DOCUMENT IS NOT INTENDED FOR THE USE OF, NOR IS IT INTENDED TO BE RELIED UPON BY ANY PERSON, FIRM OR CORPORATION OTHER THAN THE CLIENT AND TETRA TECH WEI INC. (Tetra Tech). TETRA TECH WEI INC. (Tetra Tech) DENIES ANY LIABILITY WHATSOEVER TO OTHER PARTIES FOR DAMAGES OR INJURY SUFFERED BY SUCH THIRD PARTY ARISING FROM THE USE OF THIS DOCUMENT BY THEM, WITHOUT THE EXPRESSED WRITTEN AUTHORITY OF TETRA TECH WEI INC. (Tetra Tech) AND OUR CLIENT. THIS DOCUMENT IS SUBJECT TO FURTHER RESTRICTIONS IMPOSED BY THE CONTRACT BETWEEN THE CLIENT AND TETRA TECH WEI INC. (Tetra Tech) AND THESE PARTIES' PERMISSION MUST BE SOUGHT REGARDING THIS DOCUMENT IN ALL OTHER CIRCUMSTANCES.

SUB-CONSULTANTS:

CLIENT: CITY OF WINNIPEG  
TRANSIT DEPARTMENT

**TETRA TECH**

PROJECT NAME:  
CITY OF WINNIPEG TRANSIT - FORT ROUGE GARAGE  
BUS MAINTENANCE ADDITION

DRAWING DESCRIPTION:  
**ROOF PLAN -  
SANITARY AND STORM WATER  
PIPING**

DRAWING NO: 1329720500-DWG-M0003  
REV: 00