




# THE CITY OF WINNIPEG

## PUBLIC WORKS DEPARTMENT ENGINEERING DIVISION

### 2014 LOCAL STREETS PACKAGE

### DUNROBIN AVENUE, HARBISON AVENUE WEST AND VARIOUS OTHER LOCATIONS

### BID OPPORTUNITY No. 622-2014

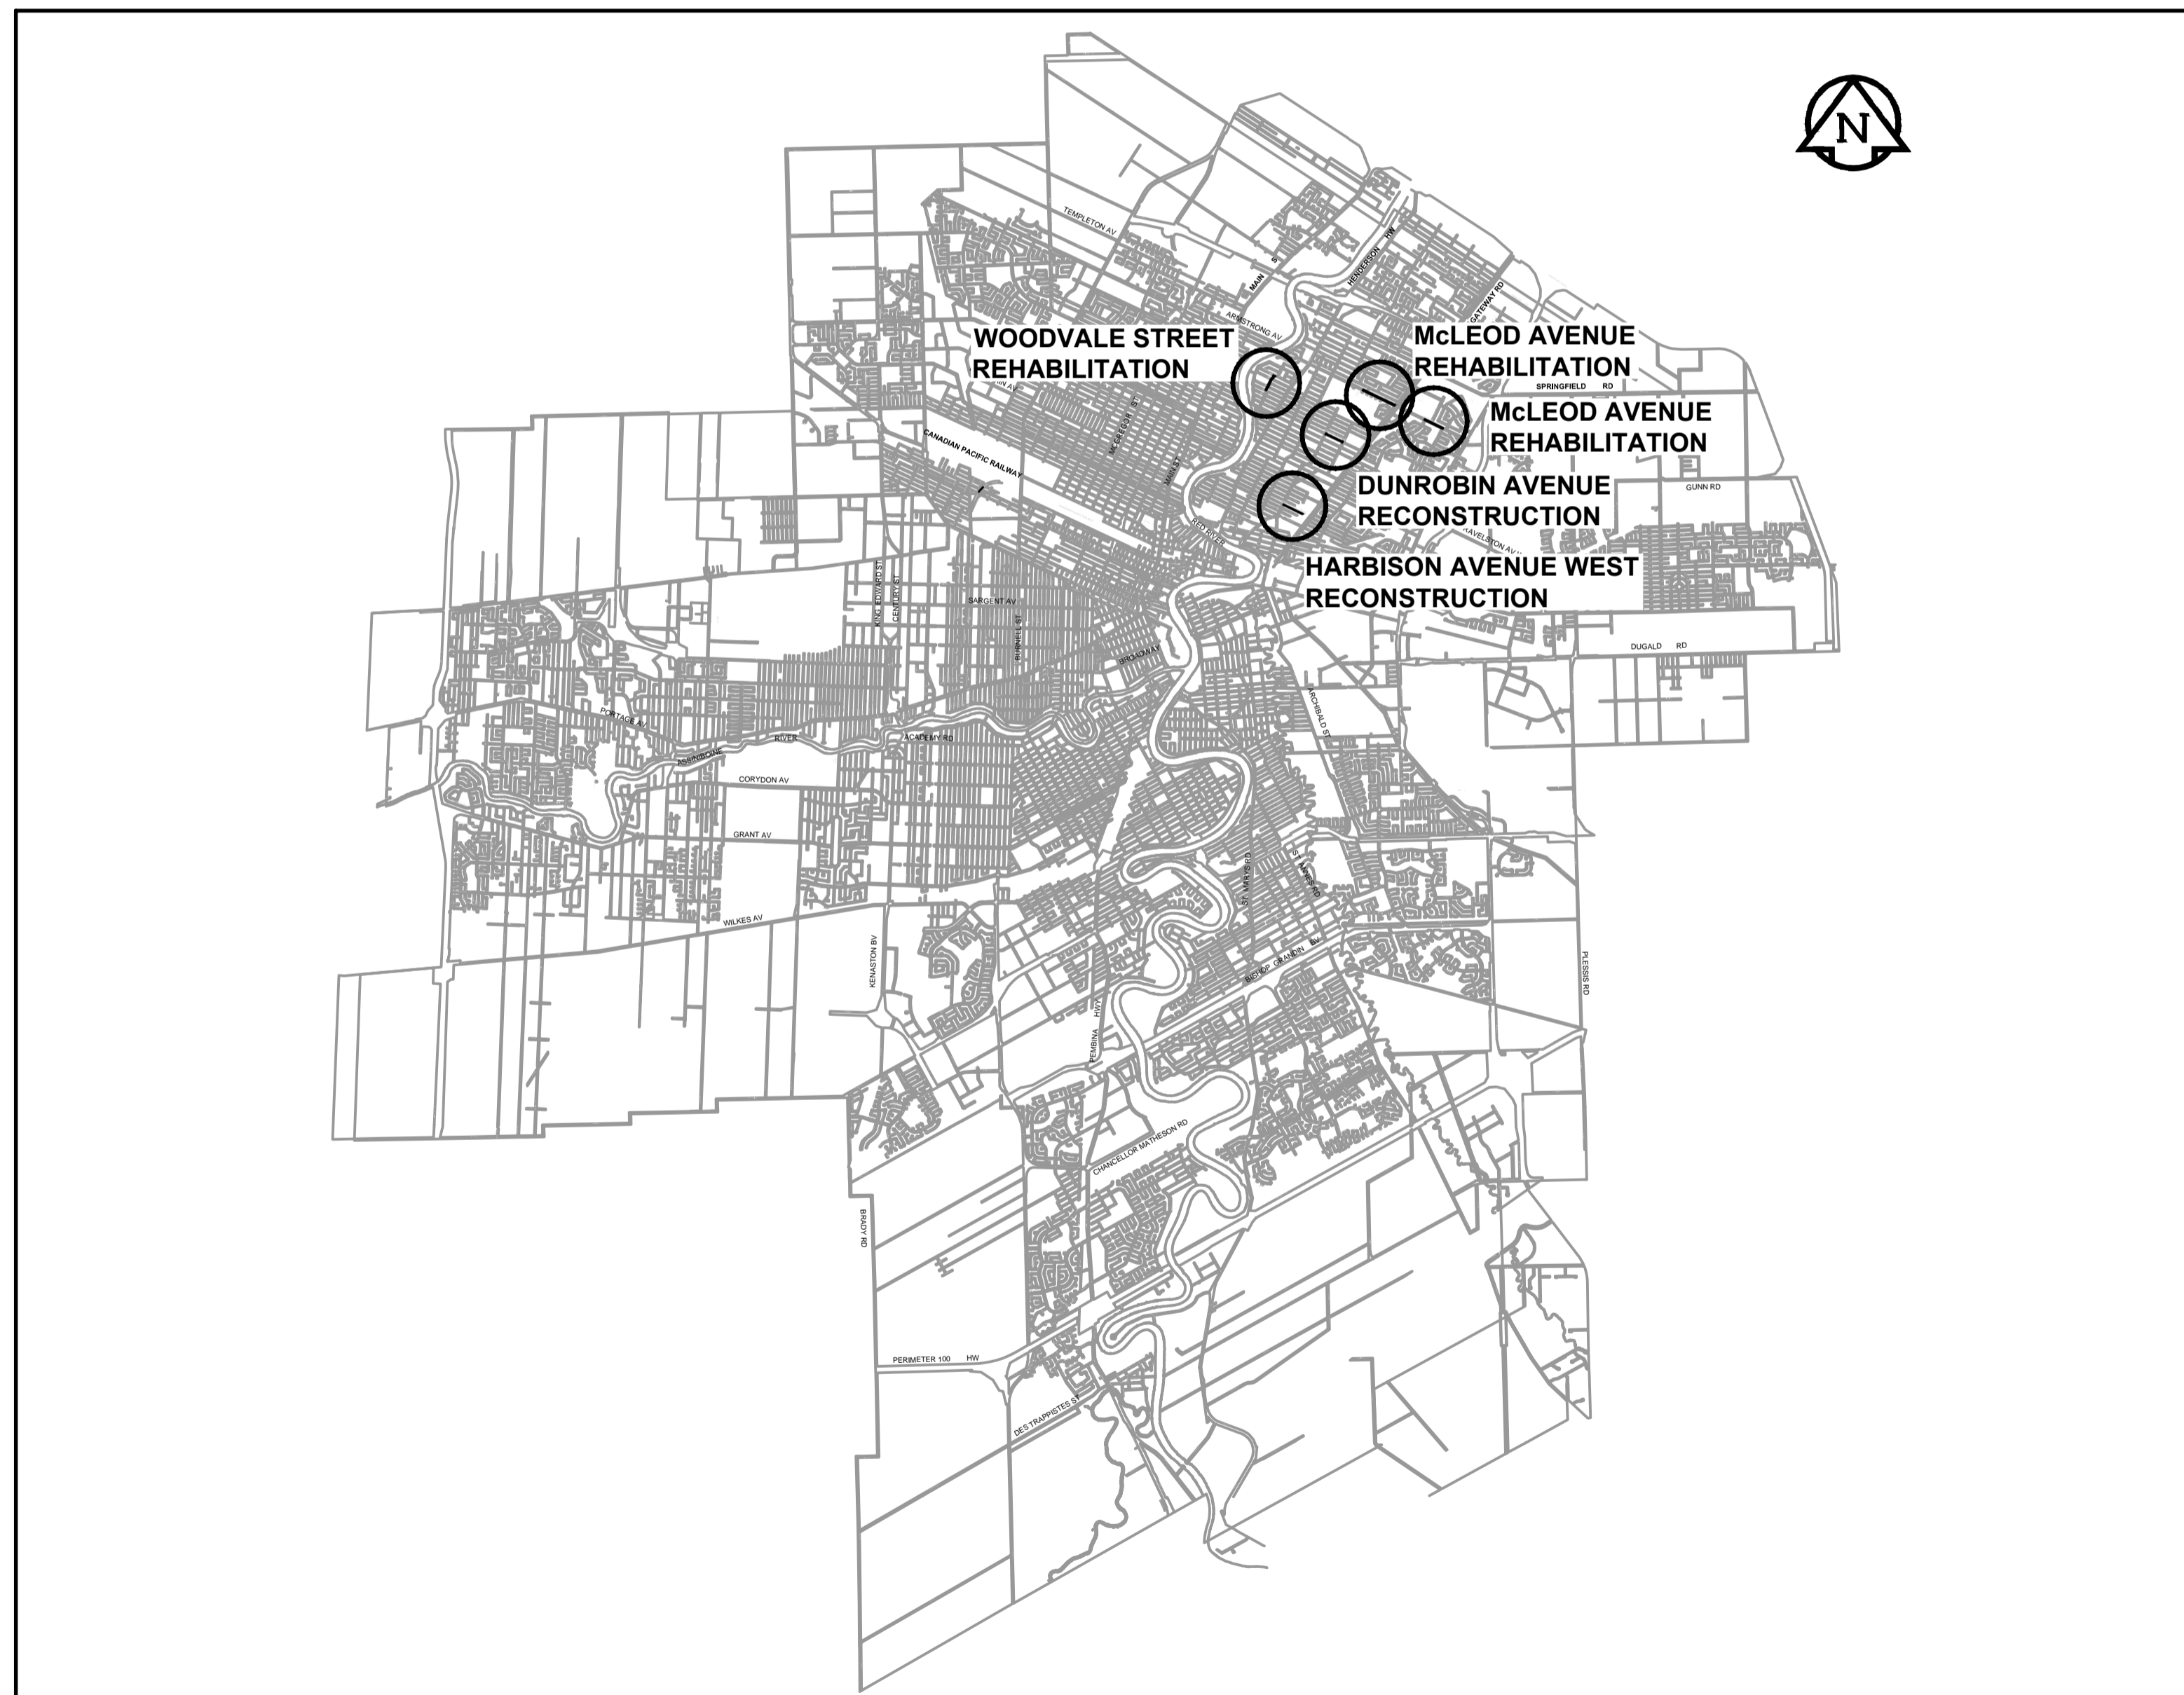

**LOCATION PLAN**

SCALE: 1:100,000  
0 2500 5000m

**DRAWING LIST**

DRAWING NUMBER	DESCRIPTION
0	COVER SHEET AND LOCATION PLAN
<b>DUNROBIN AVENUE - WATT STREET TO GOLSPIE STREET</b>	
1	STA 0+070 TO STA 0+210
2	STA 0+210 TO STA 0+350
3	STA 0+350 TO STA 0+490
<b>HARBISON AVENUE WEST - WATT STREET TO EAST END</b>	
4	STA 0+040 TO STA 0+160
5	STA 0+160 TO STA 0+280
6	STA 0+280 TO STA 0+400
7	STA 0+400 TO STA 0+520
<b>McLEOD AVENUE - LONDON STREET TO LOUELDA STREET</b>	
8	STA 0+050 TO STA 0+170
9	STA 0+170 TO STA 0+290
10	STA 0+290 TO STA 0+410
11	STA 0+410 TO STA 0+520
<b>WOODVALE STREET - LINDEN AVENUE TO MOSSDALE AVENUE</b>	
12	STA 0+080 TO STA 0+210
13	STA 0+210 TO STA 0+330
14	STA 0+330 TO STA 0+460
<b>McLEOD AVENUE - DURNESSE BAY TO RALEIGH STREET</b>	
15	STA 0+060 TO STA 0+210
16	STA 0+210 TO STA 0+330
17	STA 0+330 TO STA 0+450
18	STA 0+450 TO STA 0+580
19	STA 0+580 TO STA 0+700
20	STA 0+700 TO STA 0+820
<b>DUNROBIN AVENUE - SEWER REPAIR</b>	
10804	300 CO CS POINT REPAIRS - 2nd MH W OF GOLSPIE ST TO MH AT WATT ST
<b>HARBISON AVENUE - SEWER REPAIR</b>	
10805	375 VC CS POINT REPAIR - 1st MH E OF WATT ST TO MH AT WATT ST
10806	300 CO CS POINT REPAIR - 3rd MH E OF WATT ST TO 2nd MH E OF WATT ST
10807	300 CO CS POINT REPAIR - 4th MH E OF WATT ST TO 3rd MH E OF WATT ST
<b>STREET LIGHTING PROJECT</b>	
1-04707-DD-50000-0202	DUNROBIN AVENUE - WATT STREET TO GOLSPIE STREET -CONTRACTOR TO REPLACE EXISTING UNDERGROUND STREET LIGHTING PLANT
1-04707-DD-50000-0203	HARBISON AVENUE WEST - WATT STREET TO EAST END -CONTRACTOR TO REPLACE EXISTING UNDERGROUND STREET LIGHTING PLANT



RELEASED FOR CONSTRUCTION BY:  
*John Schuster*  
STREETS PROJECT COORDINATOR

June 26/14  
DATE



COVER SHEET AND LOCATION PLAN

CITY DRAWING No.	REV
N/A	0
CONSULTANT NO.	
W140002-T-000_RX.dwg	