



THE CITY OF WINNIPEG


PLANNING, PROPERTY AND DEVELOPMENT
DEPARTMENT

BROOKSIDE CEMETERY WATER SERVICE RENEWALS

BID OPPORTUNITY: 829-2014

DRAWING LIST

<u>SHT. NO.</u>	<u>TITLE</u>	<u>CITY OF WINNIPEG DRAWING NO.</u>
1 OF 4	BROOKSIDE CEMETERY WATER SERVICE RENEWALS PLAN OVERVIEW	D-13669
2 OF 4	BROOKSIDE CEMETERY WATER SERVICE RENEWALS PLAN AND PROFILE	D-13670
3 OF 4	BROOKSIDE CEMETERY WATER SERVICE RENEWALS PLAN AND PROFILE	D-13671
4 OF 4	BROOKSIDE CEMETERY WATER SERVICE RENEWALS DETAILS	D-13672

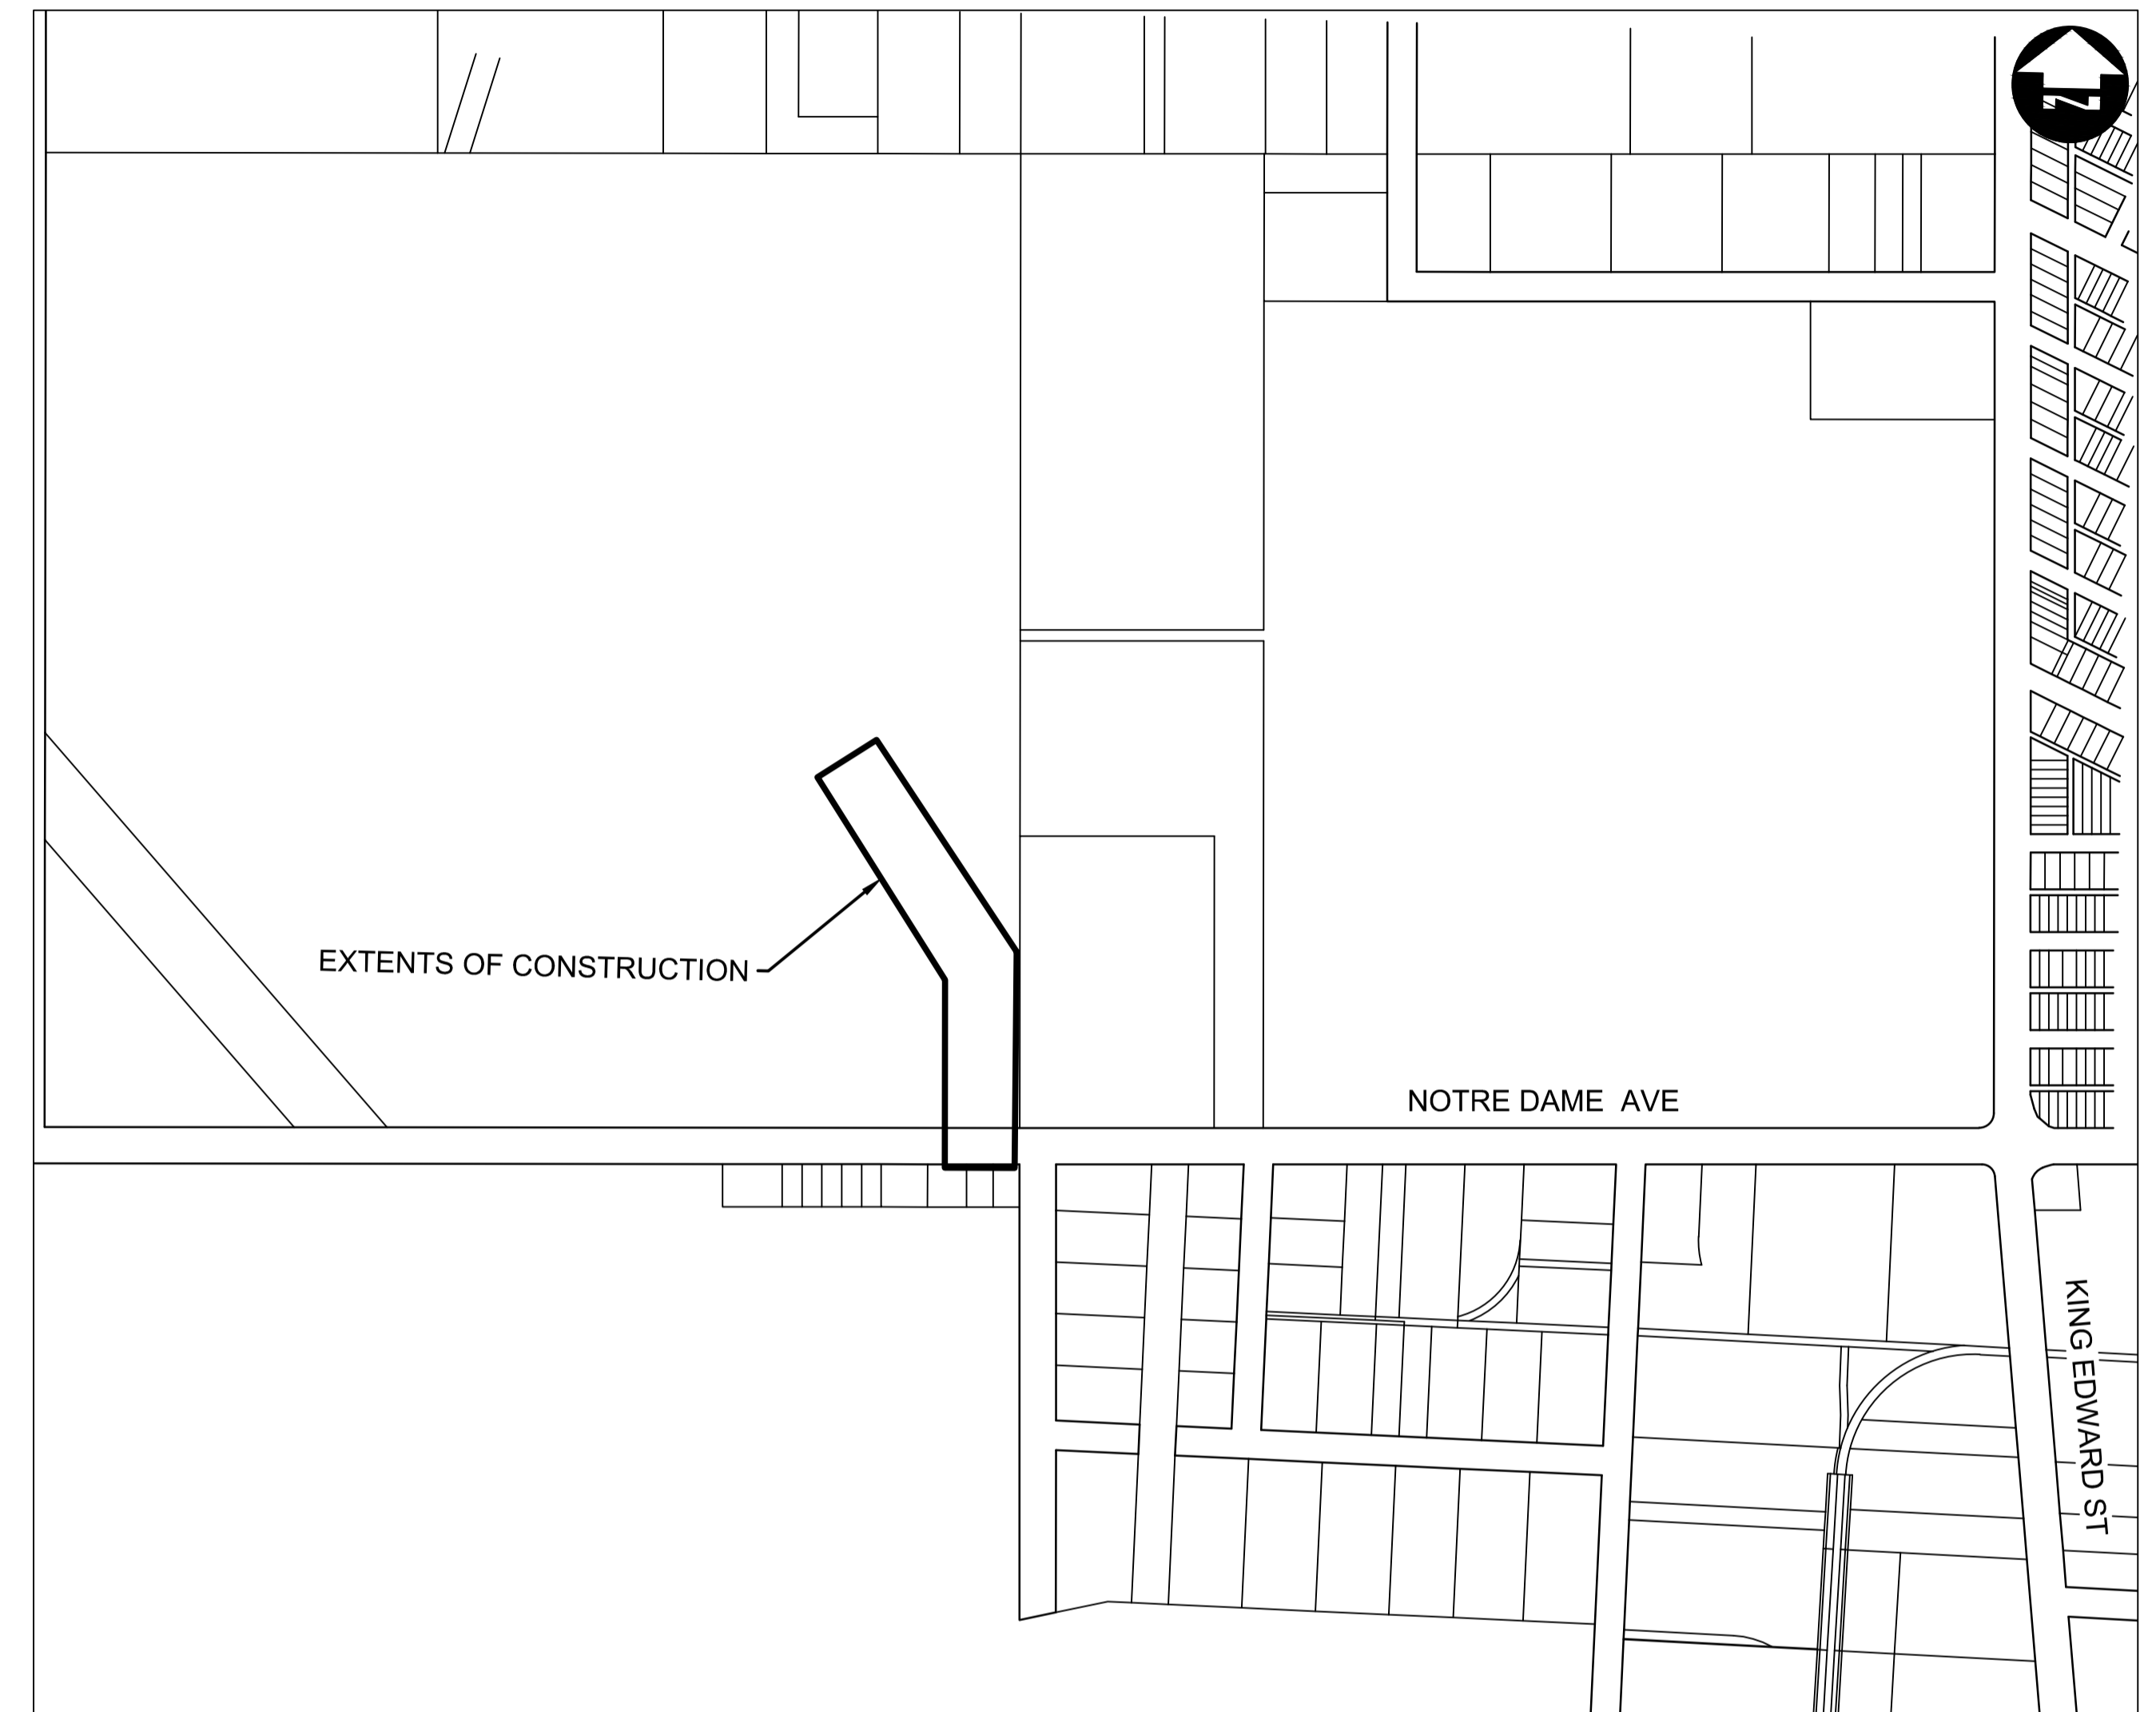

LOCATION PLAN

