





PUBLIC VEHICLE AREA
 OPERATING VEHICLE AREA

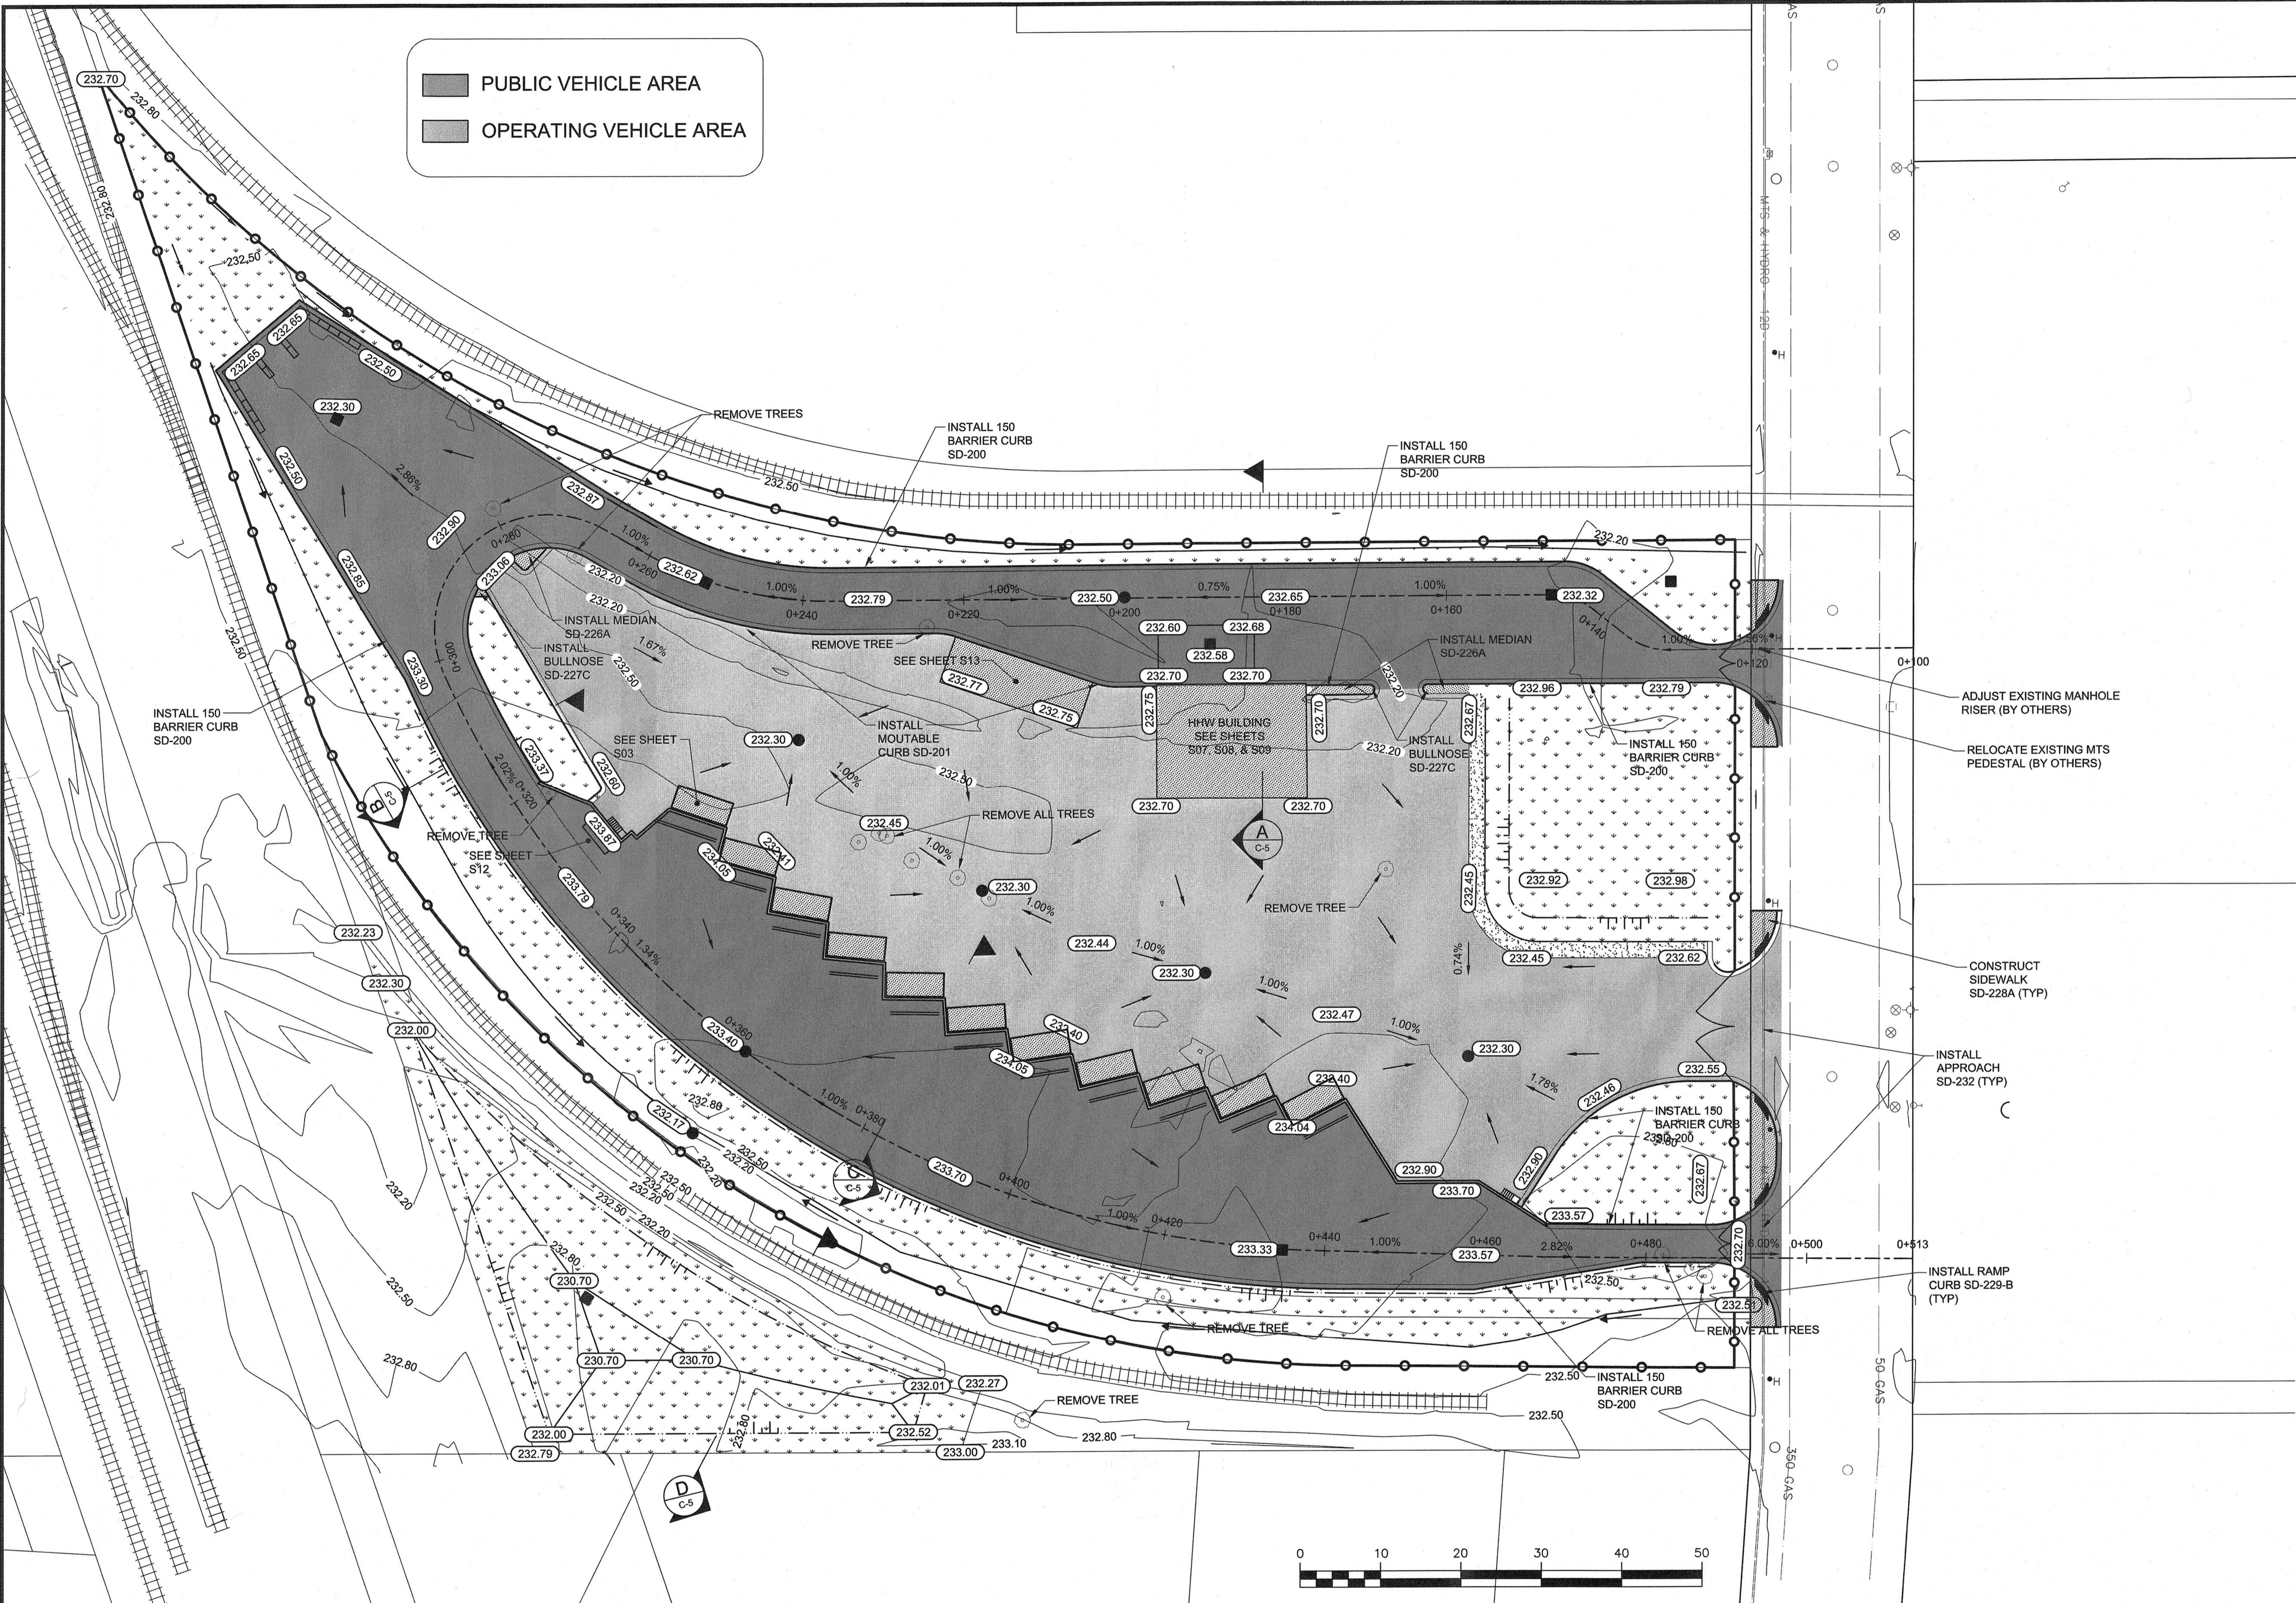

ADJUST EXISTING MANHOLE RISER (BY OTHERS)
 RELOCATE EXISTING MTS PEDESTAL (BY OTHERS)
 CONSTRUCT SIDEWALK SD-228A (TYP)
 INSTALL APPROACH SD-232 (TYP)
 INSTALL RAMP CURB SD-229-B (TYP)

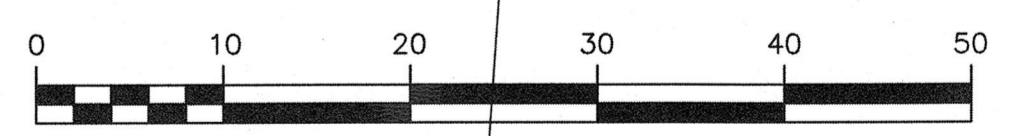

APEGM
 Certificate of Authorization
 Dillon Consulting Limited (MB)
 No. 1789 Date: MAR. 4, 2016

METRIC
 WHOLE NUMBERS INDICATE MILLIMETRES
 DECIMALIZED NUMBERS INDICATE METRES

150 WM	WATERMAIN	150 WM	MTS	M.T.S.	MTS	150 mm W.M.	WATERMAIN	150 mm W.M.
Hydrant	HYDRANT	Valve	VALVE	CONCRETE	CONCRETE	Hydrant	HYDRANT	Hydrant
300 LDS	LAND DRAINAGE SEWER	300 LDS	ASPHALT	ASPHALT	300 mm L.D.S.	Valve	VALVE	Valve
250 WWS	WASTE WATER SEWER	250 WWS	PLANING	PLANING	250 mm W.W.S.	Land Drainage Sewer	LAND DRAINAGE SEWER	Land Drainage Sewer
Manhole	MANHOLE	Test Holes	TEST HOLES	SIDEWALK	SIDEWALK	Waste Water Sewer	WASTE WATER SEWER	Waste Water Sewer
Catch Basin	CATCH BASIN	Junctions	JUNCTIONS	PAVING STONES	PAVING STONES	Profile	PROFILE	Profile
Gas	GAS	Culvert	CULVERT	PROPERTY LINE	PROPERTY LINE	PVMT Flow Direction	PVMT FLOW DIRECTION	PVMT Flow Direction
Existing	LEGEND-PLAN	Proposed	PROPOSED	Survey Bar	SURVEY BAR			
				Curb Ramp	CURB RAMP			
				Ditch	DITCH			
				Swale	SWALE			
				Legend-Profile	LEGEND-PROFILE			
				Proposed	PROPOSED			

UNDERGROUND STRUCTURES
 SUPV. U/G STRUCTURES COMMITTEE DATE
 NOTE:
 LOCATION OF UNDERGROUND STRUCTURES AS SHOWN ARE BASED ON THE BEST INFORMATION AVAILABLE. BUT NO GUARANTEE IS GIVEN THAT ALL EXISTING UTILITIES ARE SHOWN OR THAT THE GIVEN LOCATIONS ARE EXACT. CONFIRMATION OF EXISTENCE AND EXACT LOCATION OF ALL SERVICES MUST BE OBTAINED FROM THE INDIVIDUAL UTILITIES BEFORE PROCEEDING WITH CONSTRUCTION.

B.M. ELEV.					
DESIGNED BY	WPN				
DRAWN BY	GLG				
CHECKED BY					
APPROVED BY	ARR				
HOR. SCALE	1:400				
VERTICAL					
ISSUED FOR TENDER	16/03/04	ARR			
NO. REVISIONS		DATE	BY	DATE	

DILLON CONSULTING
 RELEASED FOR CONSTRUCTION
 DATE

ENGINEER
W.P. NAIRN
 Member 34277
 March 2, 2016
 CONSULTANT PROJECT NUMBER
13-8224

THE CITY OF WINNIPEG
 WATER AND WASTE DEPARTMENT
 4R WINNIPEG DEPOT
 PACIFIC AVENUE
GRADING PLAN
 CITY DRAWING NUMBER
 1-0851A-C0002-001
 SHEET 3 OF 43
 CONSULTANT DRAWING NUMBER
C2

C:\projects\win\working_directory\active\csgp\0245766A\138224-02-PLR-COM.dwg