


1 MAIN FLOOR LIGHTING PLAN
SCALE: 1/4" = 1' - 0"

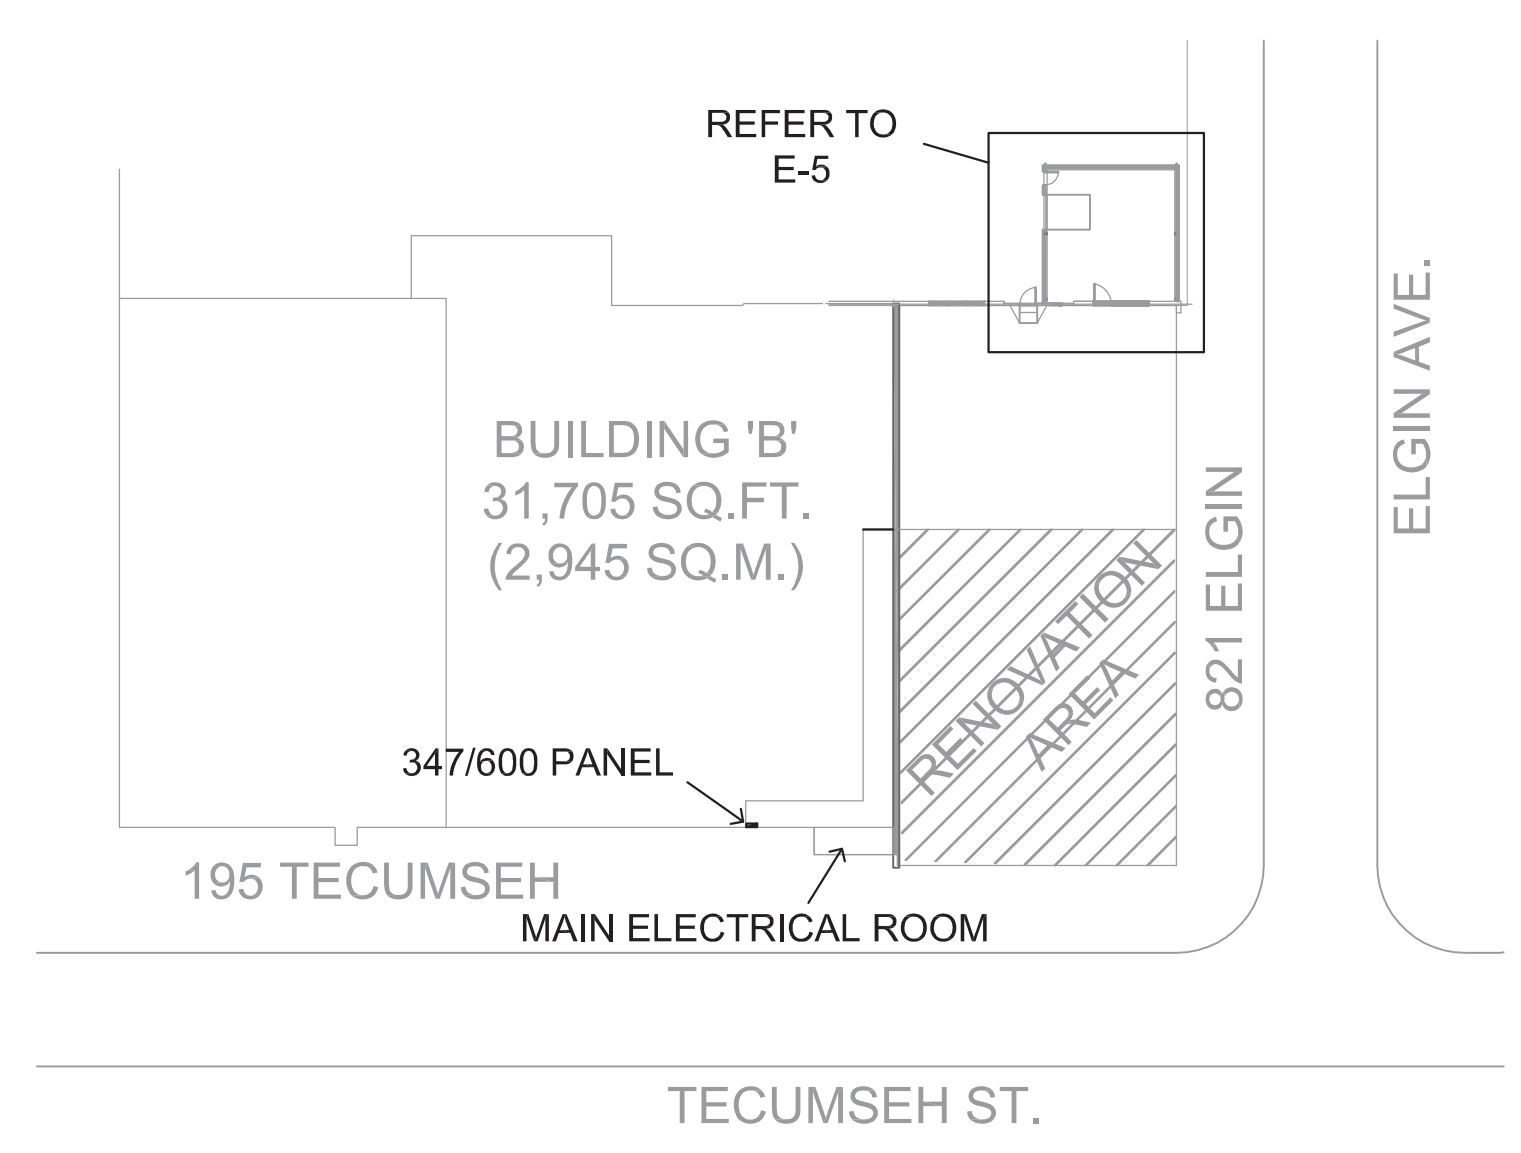

3 SITE PLAN
E-1 NOT TO SCALE

- DRAWING NOTES:**
- ALL BOARD ROOM LIGHTS TO BE CONNECTED TO DIMMERS. ENSURE DIMMERS ARE RATED FOR THEIR INTENDED LOAD.
 - ENSURE BATTERY UNIT IS ON STAIRWAY AND VESTIBULE LIGHTING CIRCUIT.
 - ENSURE THAT HALLWAY LEADING TO EXIT HAS ADEQUATE EXIT SIGNAGE.
 - RELOCATE SWITCH TO BESIDE NEW DOOR.
- GENERAL NOTES:**
- ENSURE THAT EXISTING WIRING EXPOSED OR AFFECTED DURING CONSTRUCTION IS REDONE OR REROUTED IN A PROPER MANNER. RE-USE CIRCUITS AND WIRING WHERE POSSIBLE. WHERE WIRING IS NOT RE-USED, STRIP BACK TO CLOSEST DISCONNECT OR PANEL.
 - EXISTING LIGHTING AND SWITCHING DENOTED WITH AN "E" TO REMAIN.
 - ENSURE THAT ALL REMAINING FLUORESCENT LIGHTS IN CONSTRUCTION AREA ARE UPGRADED TO T-8'S. PROVIDE NECESSARY STICKERS SHOWING REQUIRED INFORMATION. REPAIR ANY DAMAGED SOCKETS AND LENSES.
 - REMOVE AND PROPERLY DISPOSE OF ALL LIGHTS WHICH WILL NO LONGER BE USED.
 - EXIT SIGNS THROUGHOUT BUILDING MUST BE CONSISTENT. CHANGE EXISTING SIGNS TO GREEN PICTOGRAM TO MATCH NEW SIGNS IN OFFICE AREA. ALTERNATIVELY, IN CONSULTATION WITH CITY OF WINNIPEG, NEW SIGNS IN OFFICE AREA MAY BE RED LETTER TO MATCH EXISTING SIGNS.
 - ENSURE THAT EMERGENCY AND EXIT LIGHTS ARE ON LOCAL NIGHT LIGHT CIRCUIT.

LIGHTING SCHEDULE

TYPE	DESCRIPTION	LAMPS	NOTES
A	CREE AR24-40L-40K-S	40W LED	DIMMABLE
B	LITHONIA 2GT8-2-32-120-GE10IS-CSA	2 32W T8	
C	LITHONIA WRT-G-2-32-MVOLT-GE10IS-CSA	2 32W T8	
D	LITHONIA Z-2-32-MVOLT-GE10IS-CSA-ZBASR	2 32W T8	
F	JUNO TC-1	8W LED	A - BASE LAMP
G	PHILIPS LIGHTOLIER S7R830K10	14.2W LED	ROUGH IN WITH 2-1/8" DEEP OCTAGON BOX
H	LEVITON 001-8863-OCC	13W CFL	
K	LITHONIA SB-2-32-MVOLT-GE10IS-CSA	2 32W T8	
L	RC LIGHTING WPLED26RCL	26W LED	MOUNT ABOVE DOOR. CONTROL WITH PHOTOCELL ON LIGHT.
M	LITHONIA AVL4-18L-MDR-EZ1 LP835	21W LED	

EMERGENCY LIGHTING SCHEDULE

BU #1.2	EMERGENCY BATTERY UNIT LUMACELL RG125-100-2-LD9
BU #3.4	EMERGENCY BATTERY UNIT LUMACELL RG125-36-2-LD9
	EMERGENCY REMOTE HEADS LUMACELL MOM-2-LD9
	EMERGENCY EXIT SIGN (SINGLE FACE) LUMACELL LS-1-W-U
	EMERGENCY EXIT SIGN (DOUBLE FACE) LUMACELL LS-2-W-U



APECM
Certificate of Authorization
Jorey Electric Ltd.
No. 4600 Date: 14 July 2015

JOREYELECTRIC!
Engineering Consultants
6-1375 Nisakwa Road E
Winnipeg MB R2J 3T3
p. 204-255-4842
e. info@joreyelectric.com

NO	REVISION	DATE	BY
3	ISSUED FOR ADDENDUM #1	14 JUN 2015	JJD
2	RE-ISSUED FOR TENDER	22 JUN 2015	JJD
1	ISSUED FOR TENDER	12 JUN 2015	JJD
0	ISSUED FOR CONSTRUCTION	1 JUN 2015	JJD

Project: TRANSPORTATION MANAGEMENT CENTRE RENOVATIONS
821 ELGIN AVE., WINNIPEG, MANITOBA

Sheet Title: MAIN FLOOR LIGHTING PLAN
SITE PLAN
LIGHTING & EMERGENCY LIGHTING SCHEDULES

Date: 1 JUN 2015
By: TD
Project No: 14-131
Sheet No: E-1/R-3