

1 MAIN FLOOR PLAN - HVAC
M2.0 SCALE: 1/4"=1'-0"


GRILLE/DIFFUSER SCHEDULE			
SYMBOL	MANUFACTURER	MODEL	REMARKS
A	EH PRICE	SQUARE CONE DIFFUSERS SCDA/3/C/B-12	
B	EH PRICE	LINEAR SLOT PLENUM PDDR	
C	EH PRICE	RETURN 520D	
D	EXISTING	DOOR TRANSFER GRILL ATGH/3/B/15	
E	EH PRICE	RETURN 520D	
F	EH PRICE	EGG CRATE GRILL 80/F/A/B12	
G	EH PRICE	PERFORATED RETURNS PDDR/3/B12	
H	EH PRICE	LOUVERED FACE SUPPLY 520D/F/L/A/B12	

CONTRACTOR IS RESPONSIBLE TO ORDER FRAME SELECTION AS PER ARCHITECTURAL REFLECTED CEILING PLAN

HEATING AND COOLING LEGEND	
(Symbol)	THERMOSTAT ROOM SENSOR
EQUIPMENT TAG (SEE SCHEDULE)	
VENTILATION LEGEND	
(Symbol)	TRANSFER SLEEVE
(Symbol)	VOLUME BALANCING DAMPER
(Symbol)	FIRE DAMPER
(Symbol)	FIRE FLAP
(Symbol)	MOTORIZED DAMPER
(Symbol)	BACKDRAFT DAMPER

- DRAWING NOTES: #
- CONNECT TO EXHAUST DUCT AT UNDERSIDE OF CEILING SEE SHEET M2.1 FOR CONTINUATION
 - CONNECT TO SUPPLY DUCT AT UNDERSIDE OF ROOF DECK SEE SHEET M2.1

THIS DRAWING MUST NOT BE SCALED.
THE GENERAL CONTRACTOR SHALL VERIFY ALL DIMENSIONS, DATINGS AND LEVELS PRIOR TO COMMENCEMENT OF WORK AND IS HELD RESPONSIBLE FOR REPORTING ANY DISCREPANCY OR OMISSION TO CAN-TEC SERVICES LTD. IMMEDIATELY.
THIS DRAWING IS THE EXCLUSIVE PROPERTY OF CAN-TEC SERVICES LTD. AND CAN BE REPRODUCED ONLY WITH THE PERMISSION OF CAN-TEC SERVICES LTD. IN WHICH CASE THE REPRODUCTION MUST BEAR THEIR NAME AS THE ENGINEERING/DRAFTING FIRM.
http://www.can-tec.com

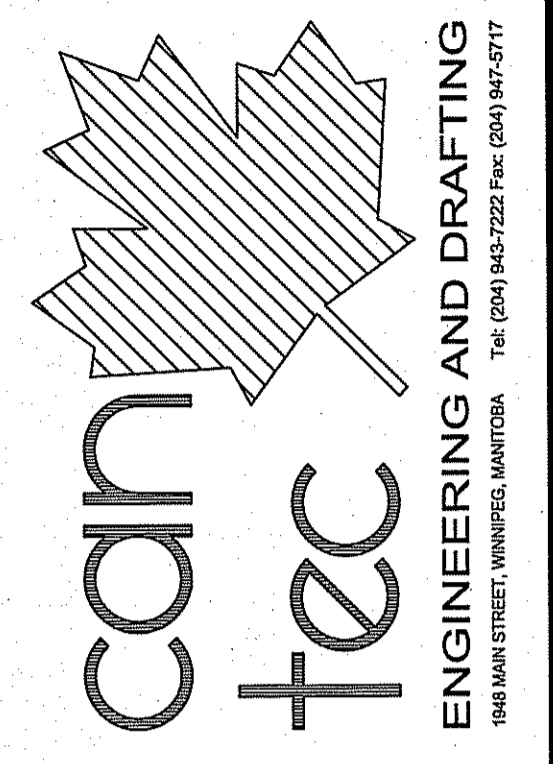

REV #	REVISION	DATE	BY
02	ISSUED FOR CONSTRUCTION	15 06 15	JLS
01	ISSUED FOR TENDER	15 06 12	JLS
00	ISSUED FOR CONSTRUCTION	15 06 01	JLS
00	ISSUED FOR REVIEW	15 05 15	JLS
00	ISSUED FOR REVIEW	15 05 14	JLS

SEALED BY:

PROJECT TITLE
TRAFFIC MANAGEMENT CENTER - RENOVATIONS

SHEET TITLE
HVAC MAIN FLOOR PLAN

DATE
14 11 20

SCALE
AS NOTED

LOCATION
821 ELGIN AVENUE, WINNIPEG, MANITOBA

CONSTRUCTION

REVISION #:
14-112-14-30

CHECKED BY
JLS

DRAWN BY
RS

NO. 4189 Date: June 19, 2015

CONSTRUCTION
M2.0
REVISION #:
14-112-14-30

