



PLAN
SCALE: 1 : 20

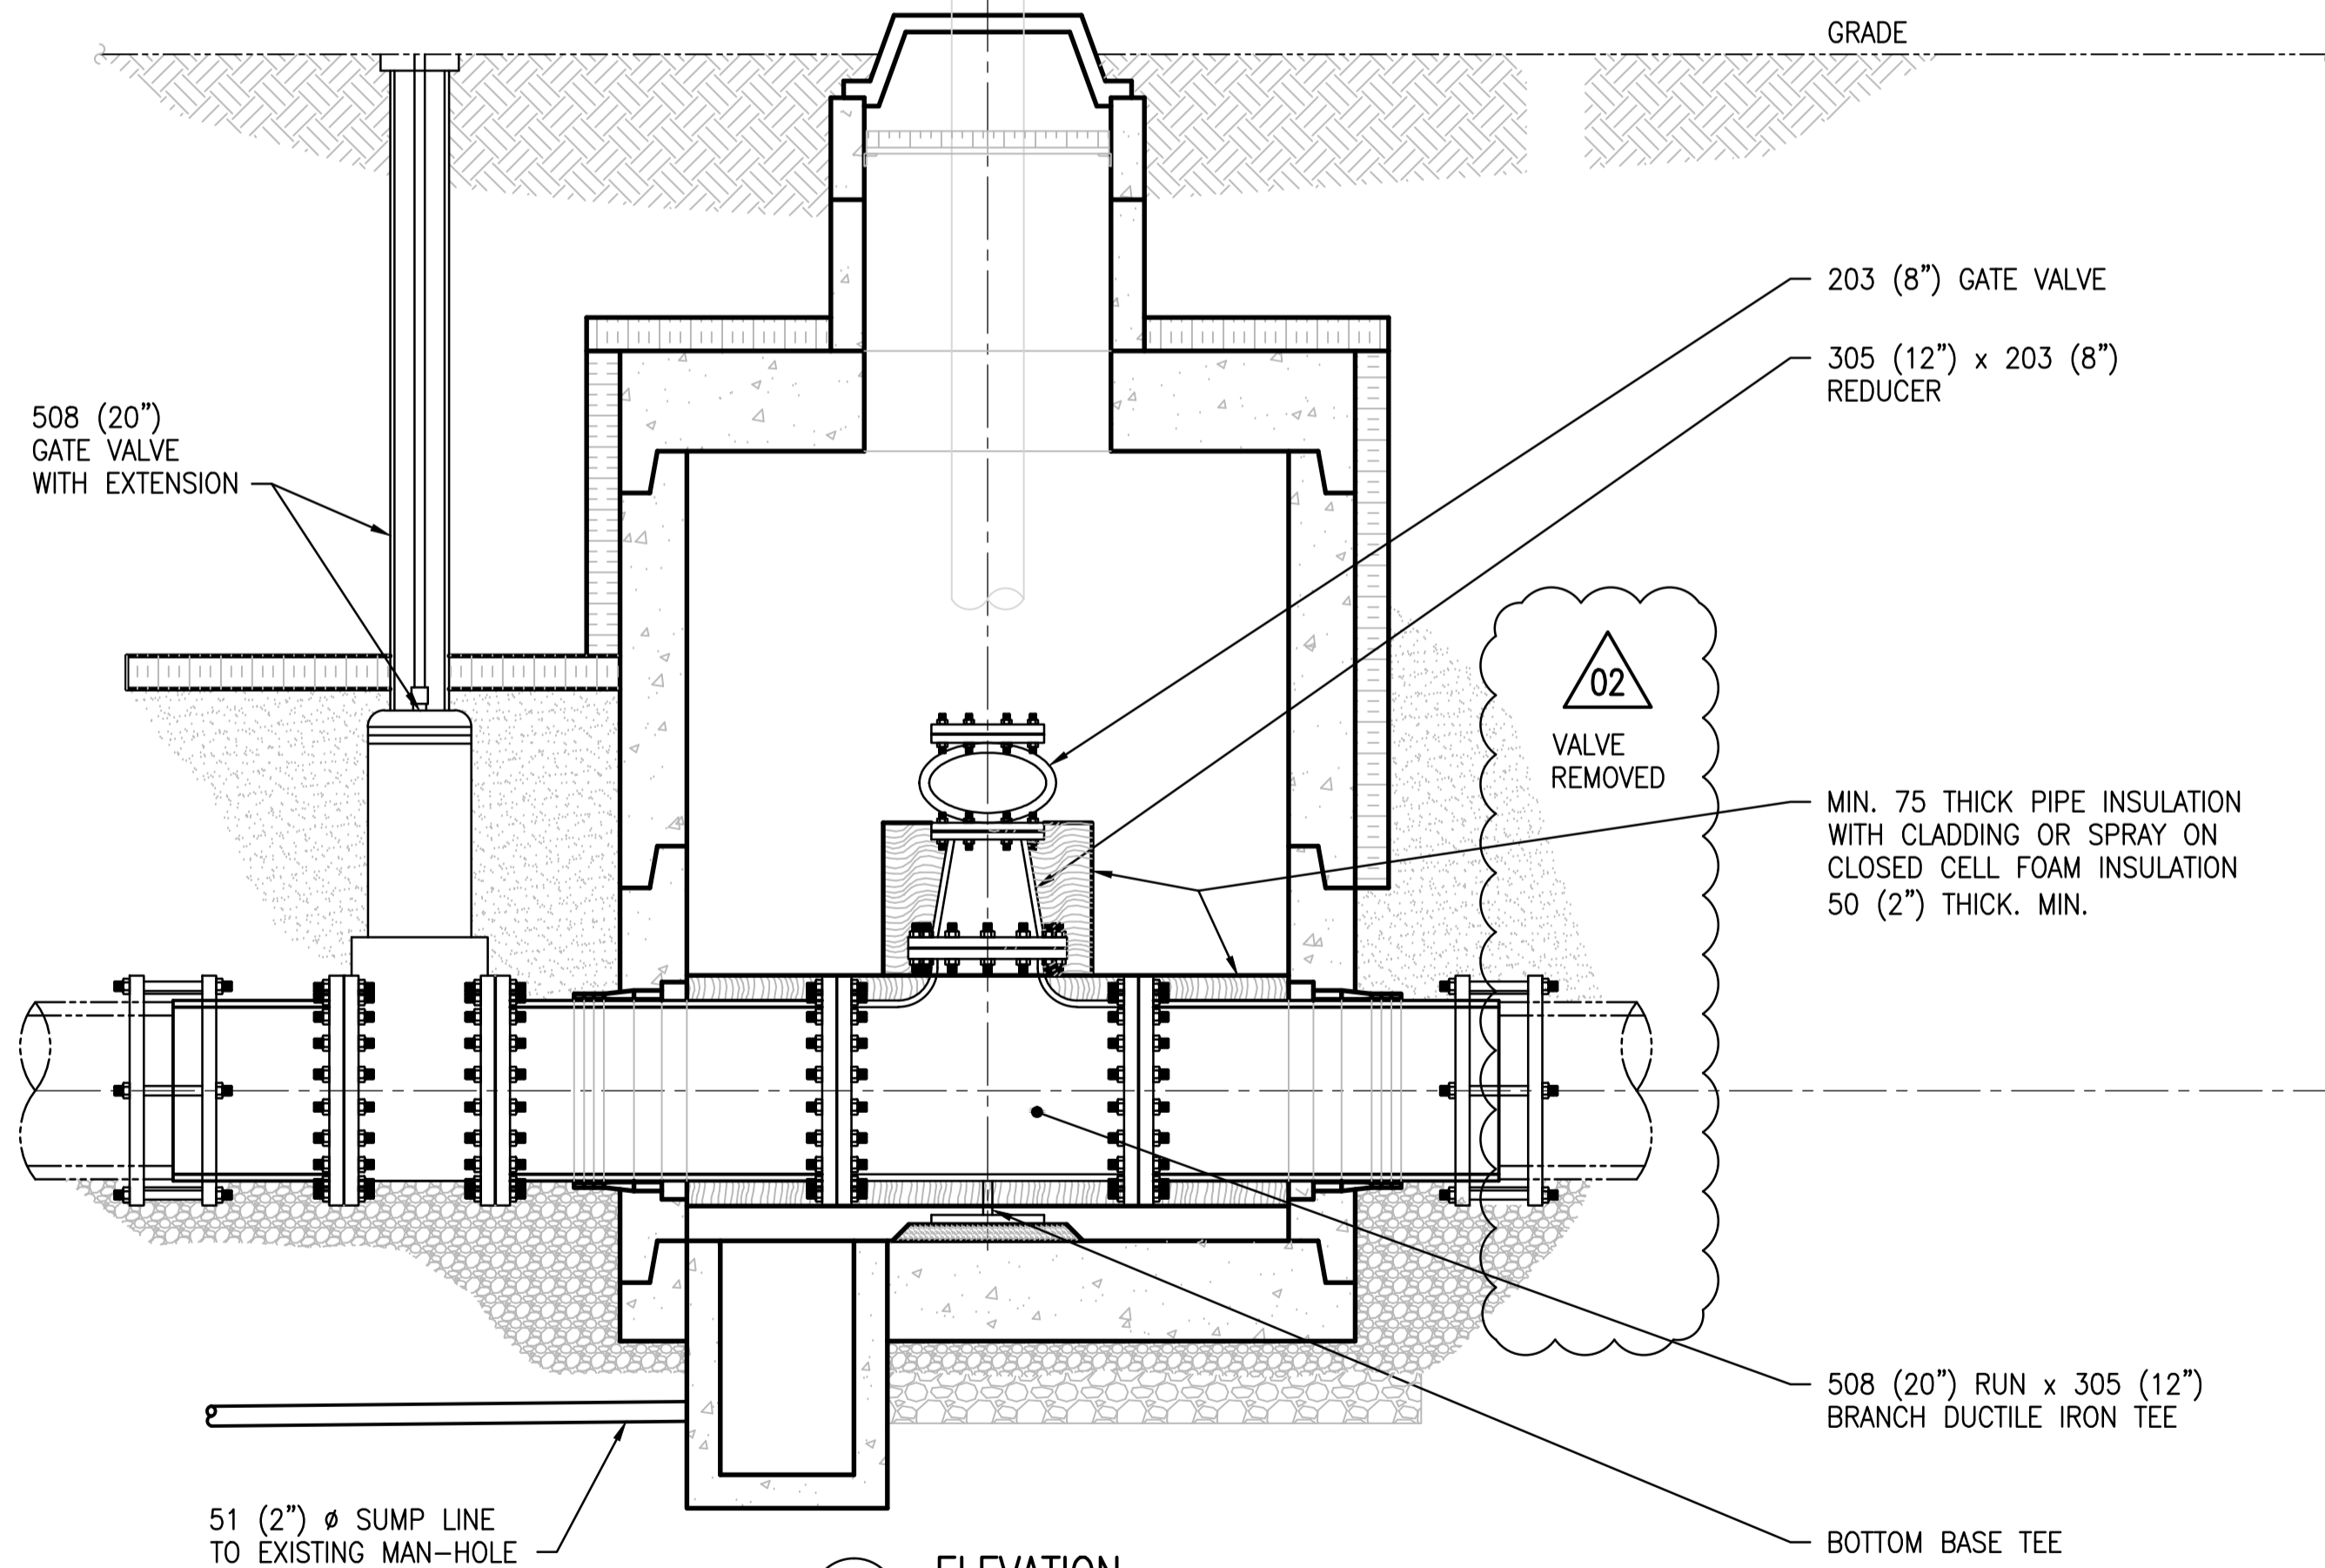


A ELEVATION
SCALE: 1 : 20

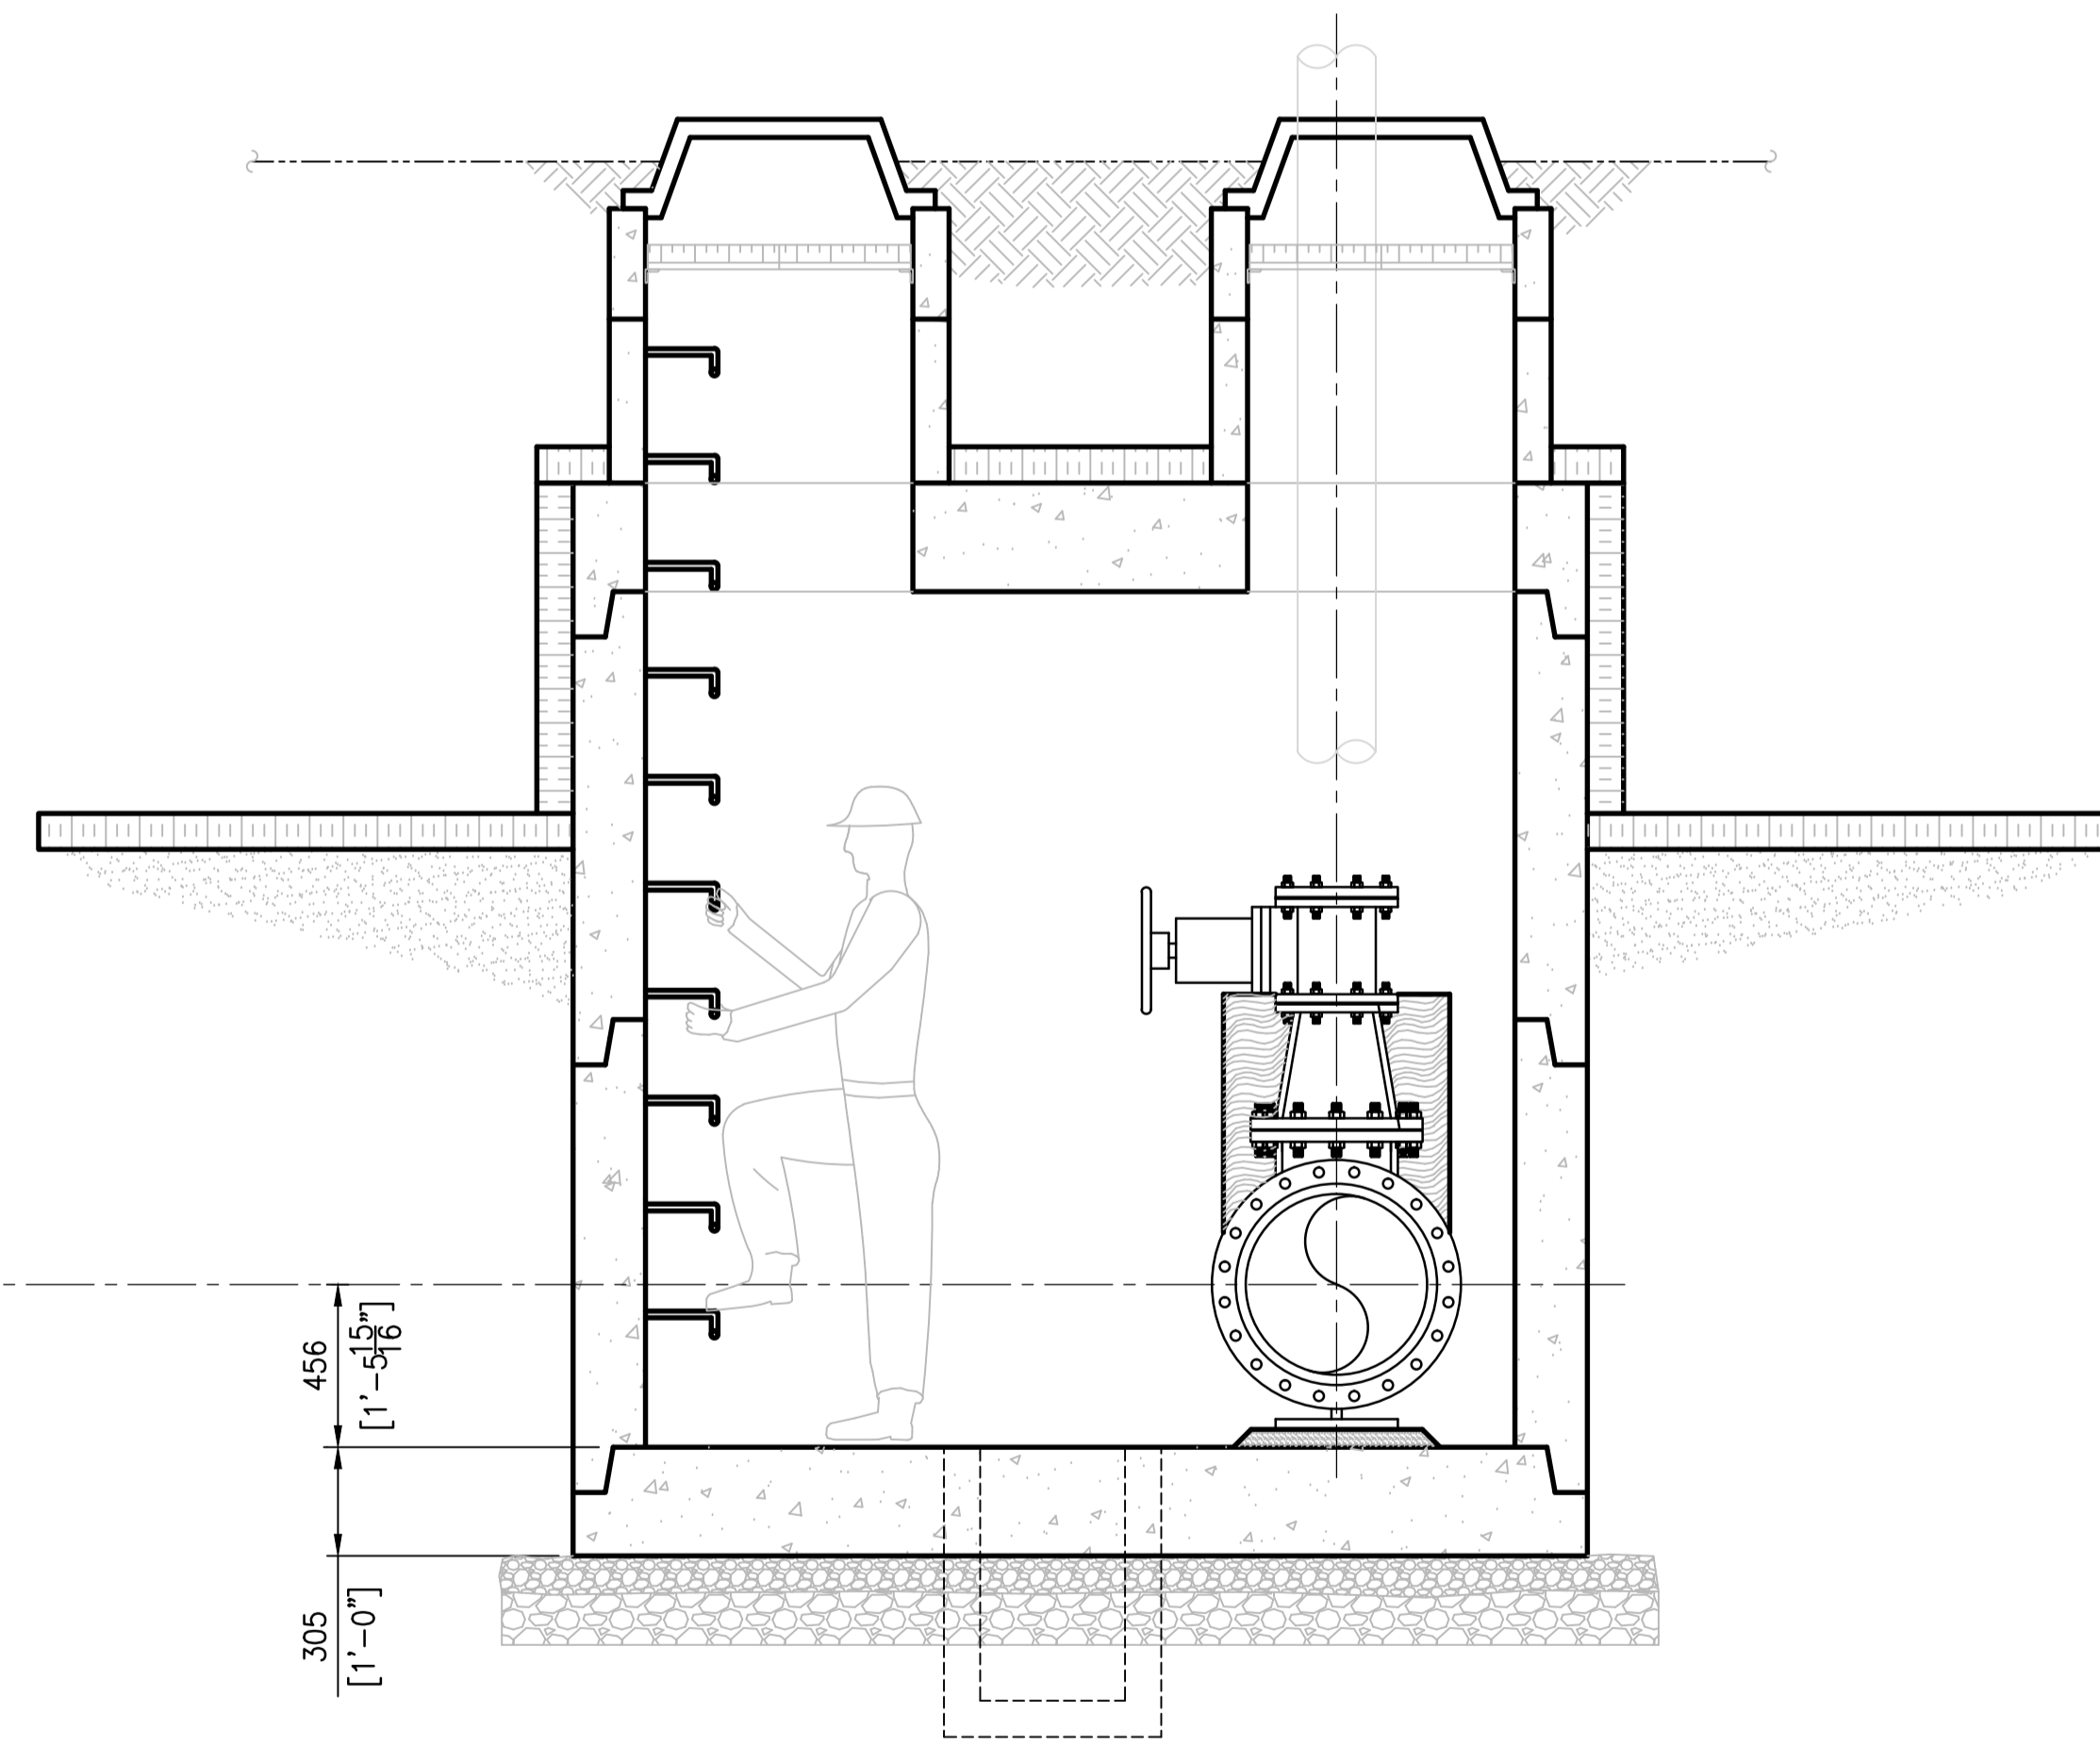

B ELEVATION
SCALE: 1 : 20

S-265	AINSLIE COMM. & PUMPING STATION - SITE PLAN
403-B	AINSLIE COMM. & PUMPING STATION - SUPERSTRUCTURE & DETAILS
403-A	AINSLIE COMM. & PUMPING STATION - REINFORCING DETAILS
403	AINSLIE COMM. & PUMPING STATION
DRAWING NUMBER	REFERENCE DRAWINGS

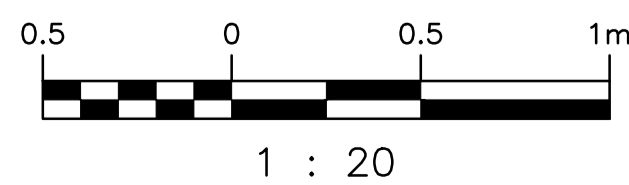

02	VALVE REMOVED	2015/10/09	IP
01	REVISED INSULATION/CONNECTOR NOTE	2015/10/08	IP
00	ISSUED FOR ADDENDUM - MANHOLE DETAILS	2015/09/28	IP
NO.	REVISIONS	DATE	DESIGN/CHECK

		SNC-LAVALIN INC. 148 Nature Park Way Winnipeg, MB, Canada R3P 0X7 204-786-8080	
DESIGNED BY:	I. PARKINSON	CHECKED BY:	J. ALO
DRAWN BY:	B. DICKSON	APPROVED BY:	
SCALE:	1:20	ISSUED FOR CONSTRUCTION	
DATE:	2015/09/28	BY:	
CONSULTANT NO.:		DATE:	

ENGINEER'S SEAL

**PRELIMINARY
NOT TO BE
USED FOR
CONSTRUCTION**

		THE CITY OF WINNIPEG WATER AND WASTE DEPARTMENT	
OLIVE WASTEWATER LIFT STATION 2015 UPGRADES PLAN AND ELEVATION MANHOLE STRUCTURE			
CITY DRAWING NUMBER	1-0169L-M0005	SHEET	001
REV.	02	SIZE	A1