



1 MAIN FLOOR PLAN - DEMOLITION - PLUMBING
SCALE: 1/16" = 1'-0"

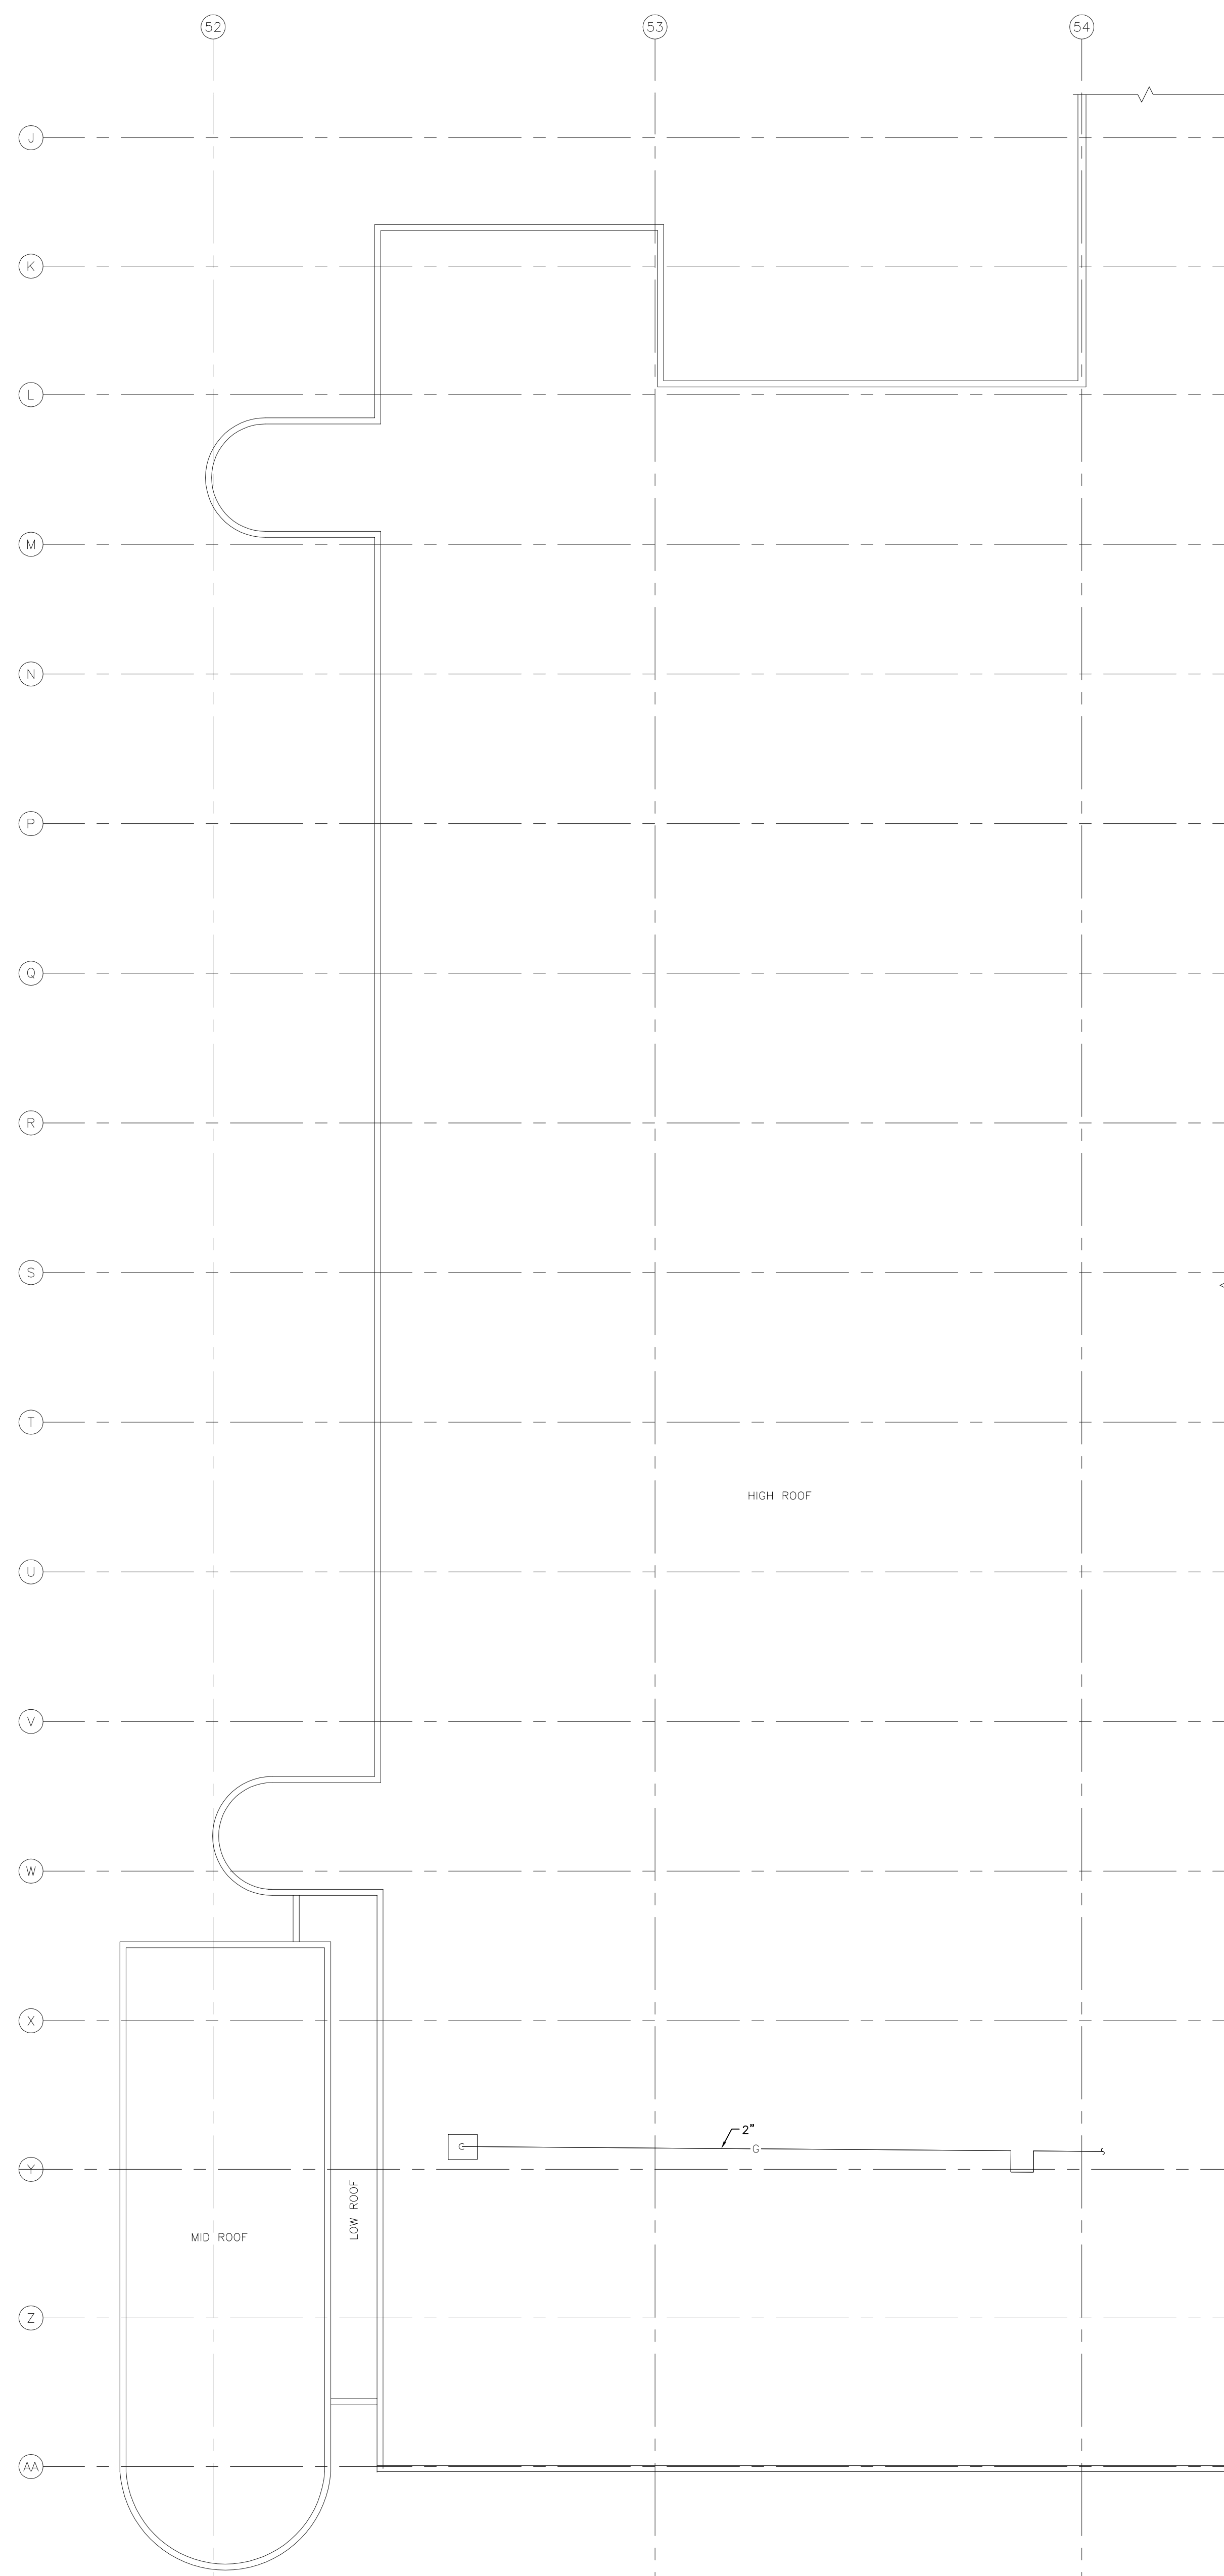

2 ROOF PLAN - DEMOLITION - PLUMBING
SCALE: 1/16" = 1'-0"

GENERAL NOTES

- A. REFER TO SCOPE OF WORK DESCRIPTION IN FRONT END SPECIFICATIONS FOR SEQUENCING.
- B. ALL ABANDONED EQUIPMENT AND SERVICES WITHIN AREA OF WORK SHALL BE REMOVED.
- C. THIS BUILDING MAY CONTAIN ASBESTOS. REFER TO FRONT END SPECIFICATIONS FOR FURTHER INFORMATION.

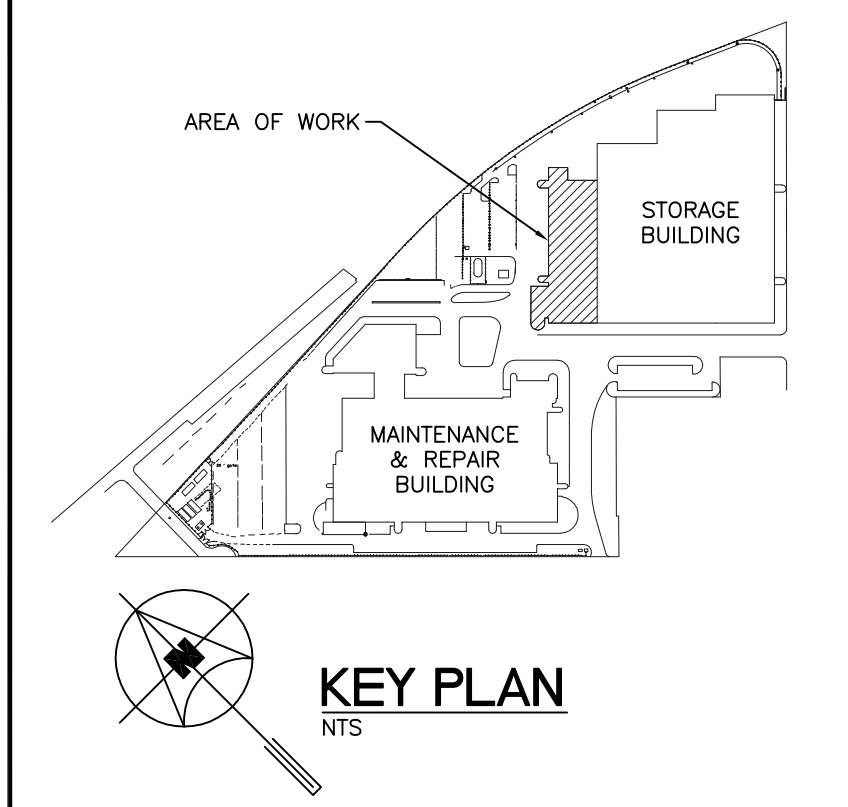

DEMOLITION KEYNOTES

- 1. DEMOLISH AND REMOVE ABANDONED UNIT HEATERS.
- 2. DEMOLISH AND REMOVE NATURAL GAS PIPING BACK TO VALVE/MAIN/PRV AS SHOWN. REPAIR AND SEAL PRV VENT ROOF OPENING (REFER TO STRUCTURAL).
- 3. EXISTING NATURAL GAS METER TO REMAIN.

5		
4		
3		
2		
1	ISSUED FOR ADDENDUM 2	JH 20/11/15
0	ISSUED FOR CONSTRUCTION	JH 27/10/15
NO.	Description	BY DD/MM/YY

APEGM
Certificate of Authorization
SMB Engineering Ltd.
No. 166 Expiry: April 30, 2016

ORIGINAL CONTRACT DRAWING
BONDED AND SEALED BY
J. T. HORROCKS, P. ENG
OCTOBER 27, 2015

770 Bradford Street
Winnipeg, Canada
T 204 775-0291
SMSeng.com

SMS ENGINEERING

Winnipeg Transit

Project Title
**CITY OF WINNIPEG FORT ROUGE
TRANSIT BASE - SERVICE BAY AND
B-SECTION VENTILATION UPGRADE**

WINNIPEG MANITOBA

Drawing Title
**MAIN FLOOR AND ROOF PLAN -
DEMOLITION - PLUMBING**

Drawn By	GB/IE	Checked By	JH	Approved By	JH
Scale	AS SHOWN	Date	JULY 2014	Project No	14-194-01
Revision Number	1	Drawing Number	M1.1	Sheet Order	1 OF 11

14194_M1.1_P01_L1000 - NOVEMBER 20, 2013 - 2:37PM CST - CBAL