



1 MAIN FLOOR PLAN - DEMOLITION - PLUMBING  
SCALE: 1/16" = 1'-0"

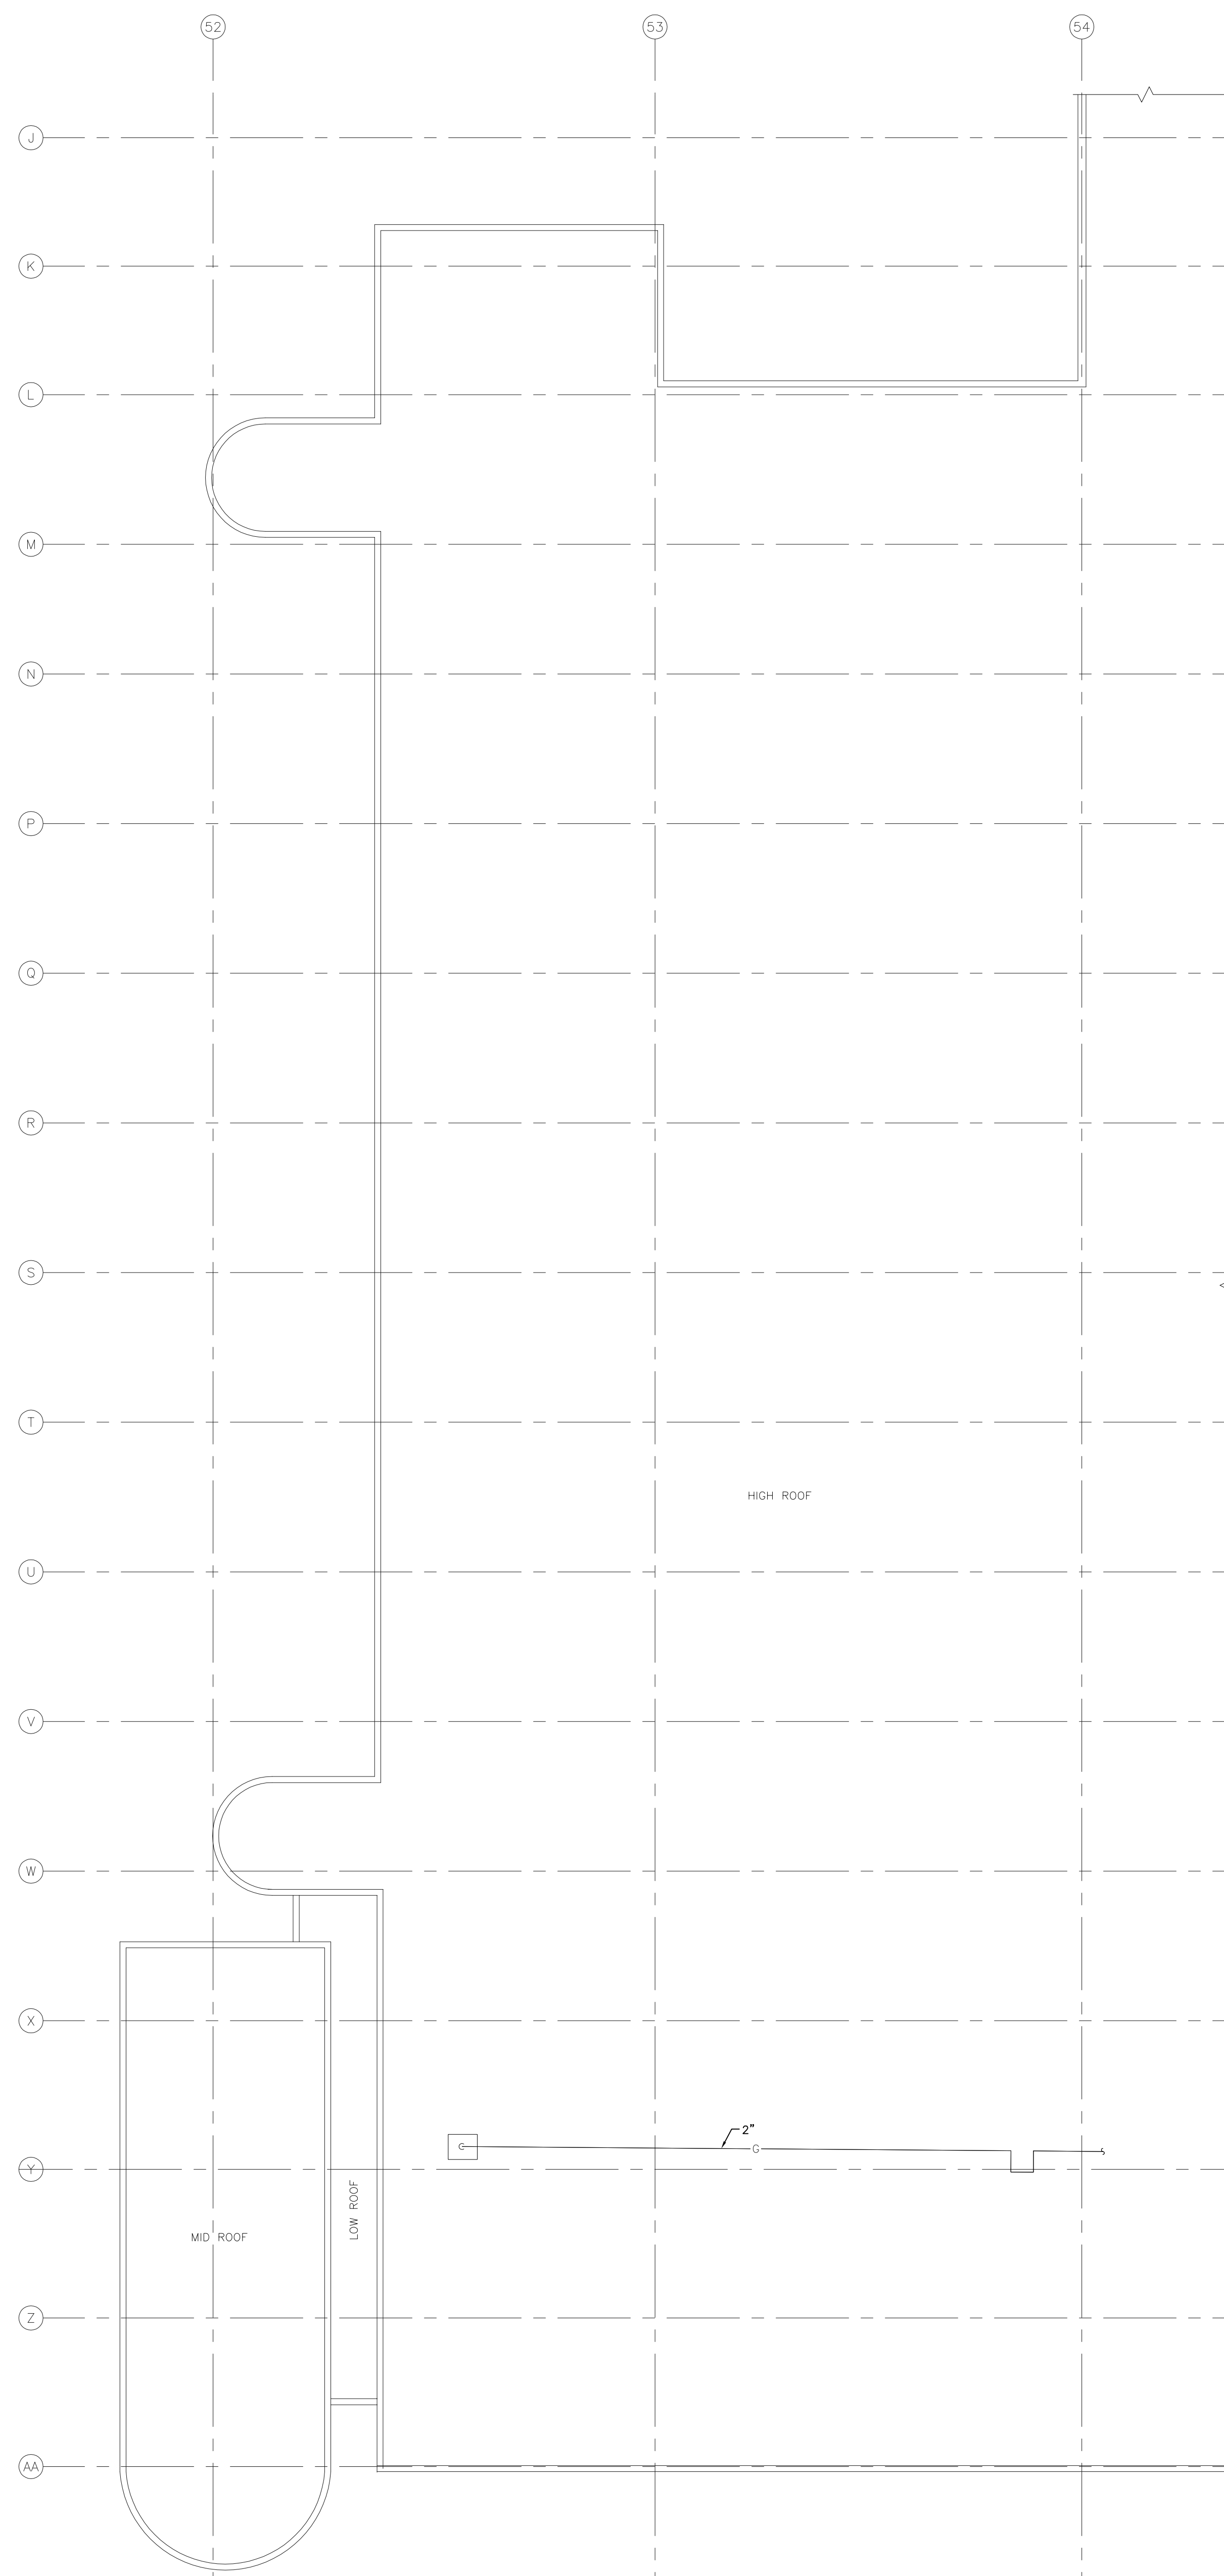

2 ROOF PLAN - DEMOLITION - PLUMBING  
SCALE: 1/16" = 1'-0"

**GENERAL NOTES**

- A. REFER TO SCOPE OF WORK DESCRIPTION IN FRONT END SPECIFICATIONS FOR SEQUENCING.
- B. ALL ABANDONED EQUIPMENT AND SERVICES WITHIN AREA OF WORK SHALL BE REMOVED.
- C. THIS BUILDING MAY CONTAIN ASBESTOS. REFER TO FRONT END SPECIFICATIONS FOR FURTHER INFORMATION.

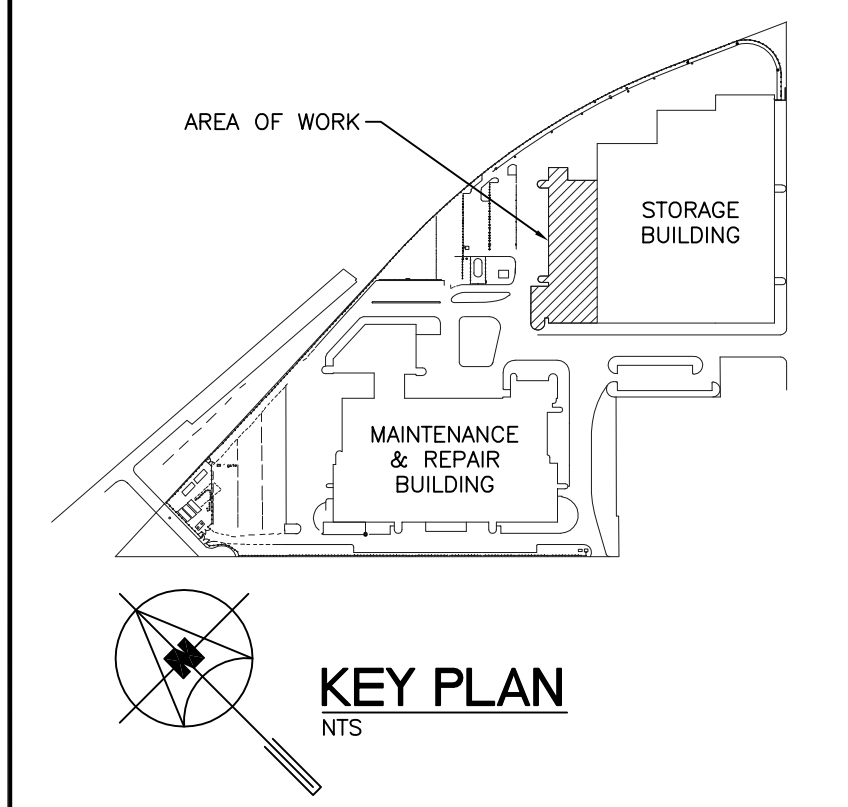

**DEMOLITION KEYNOTES**

- 1. DEMOLISH AND REMOVE ABANDONED UNIT HEATERS.
- 2. DEMOLISH AND REMOVE NATURAL GAS PIPING BACK TO VALVE/MAN/PRV AS SHOWN. REPAIR AND SEAL PRV VENT ROOF OPENING (REFER TO STRUCTURAL).
- 3. EXISTING NATURAL GAS METER TO REMAIN.

6			
5			
4			
3			
2			
1			
0	ISSUED FOR CONSTRUCTION	JH	27/10/15
NO.	Description	BY	DD/MM/YY

**APEGM**  
Certificate of Authorization  
SMB Engineering Ltd.  
No. 166 Expiry: April 30, 2016

**HORROCKS**  
Member  
24767  
2/10/15  
REGISTERED PROFESSIONAL ENGINEER

770 Bradford Street  
Winnipeg, Canada  
T 204 775 0291  
SMSeng.com

**SMS ENGINEERING**

**Winnipeg Transit**

Project Title  
**CITY OF WINNIPEG FORT ROUGE  
TRANSIT BASE - SERVICE BAY AND  
B-SECTION VENTILATION UPGRADE**

WINNIPEG MANITOBA

Drawing Title  
**MAIN FLOOR AND ROOF PLAN -  
DEMOLITION - PLUMBING**

Drawn By	GB/IE	Checked By	JH	Approved By	JH
Scale	AS SHOWN	Date	JULY 2014	Project No	14-194-01
Revision Number	0	Drawing Number	M1.1	Sheet Order	1 OF 11