


GENERAL NOTES

- A. WHERE TOGGLE SWITCHES, OR DIMMER CONTROLS ARE ADJACENT EACH OTHER, PROVIDE GANGED SWITCHING TO ACCOMMODATE TOTAL NUMBER OF SWITCHES, UNLESS NOTED OTHERWISE.
- B. ALL RECESSED LIGHTING FIXTURES IN LAY-IN CEILINGS SHALL BE INSTALLED WITH 6" LONG FLEXIBLE METAL CONDUIT.
- C. ALL MOUNTING HEIGHTS FOR LUMINAIRES ARE TO THE BOTTOM OF THE LUMINAIRE UNLESS NOTED OTHERWISE. REFER TO ARCHITECTURAL DETAILS.
- D. REFER TO ARCHITECTURAL ELEVATIONS FOR MOUNTING HEIGHTS OF EXTERIOR OR INTERIOR LUMINAIRES.
- E. EMERGENCY LIGHTING REMOTE HEADS AND EXIT SIGNS SHALL BE CEILING MOUNTED WITHIN THE MAIN LIBRARY AREA UNLESS NOTED OTHERWISE. REFER TO ARCHITECTURAL FLOOR PLANS AND REFLECTED CEILING PLANS FOR MOUNTING HEIGHTS AND LOCATIONS.

KEY NOTES

- 1. MAIN FLOOR EMERGENCY LIGHTING BATTERY UNIT. PROVIDE ZONE SENSING TO PICK UP LIGHTING CIRCUITS FOR BATTERY UNIT SUPPLYING EMERGENCY LIGHTING THIS AREA.
- 2. NETWORK WALL PDD DIMMING CONTROLLER. REFER TO MULTI-PURPOSE LIGHTING CONTROL SCHEMATIC.
- 3. CONDUIT SUPPLYING LIGHTING AND LIGHTING CONTROLS WITHIN MAIN LIBRARY AREA SHALL BE RUN PARALLEL TO CEILING FLUTES AND WITHIN CEILING FLUTES WHEREVER POSSIBLE. REFER TO ARCHITECTURAL DETAILS.
- 4. NETWORK WALL PDD ON/OFF CONTROL. REFER TO MAIN LIBRARY LIGHTING CONTROL SCHEMATIC.

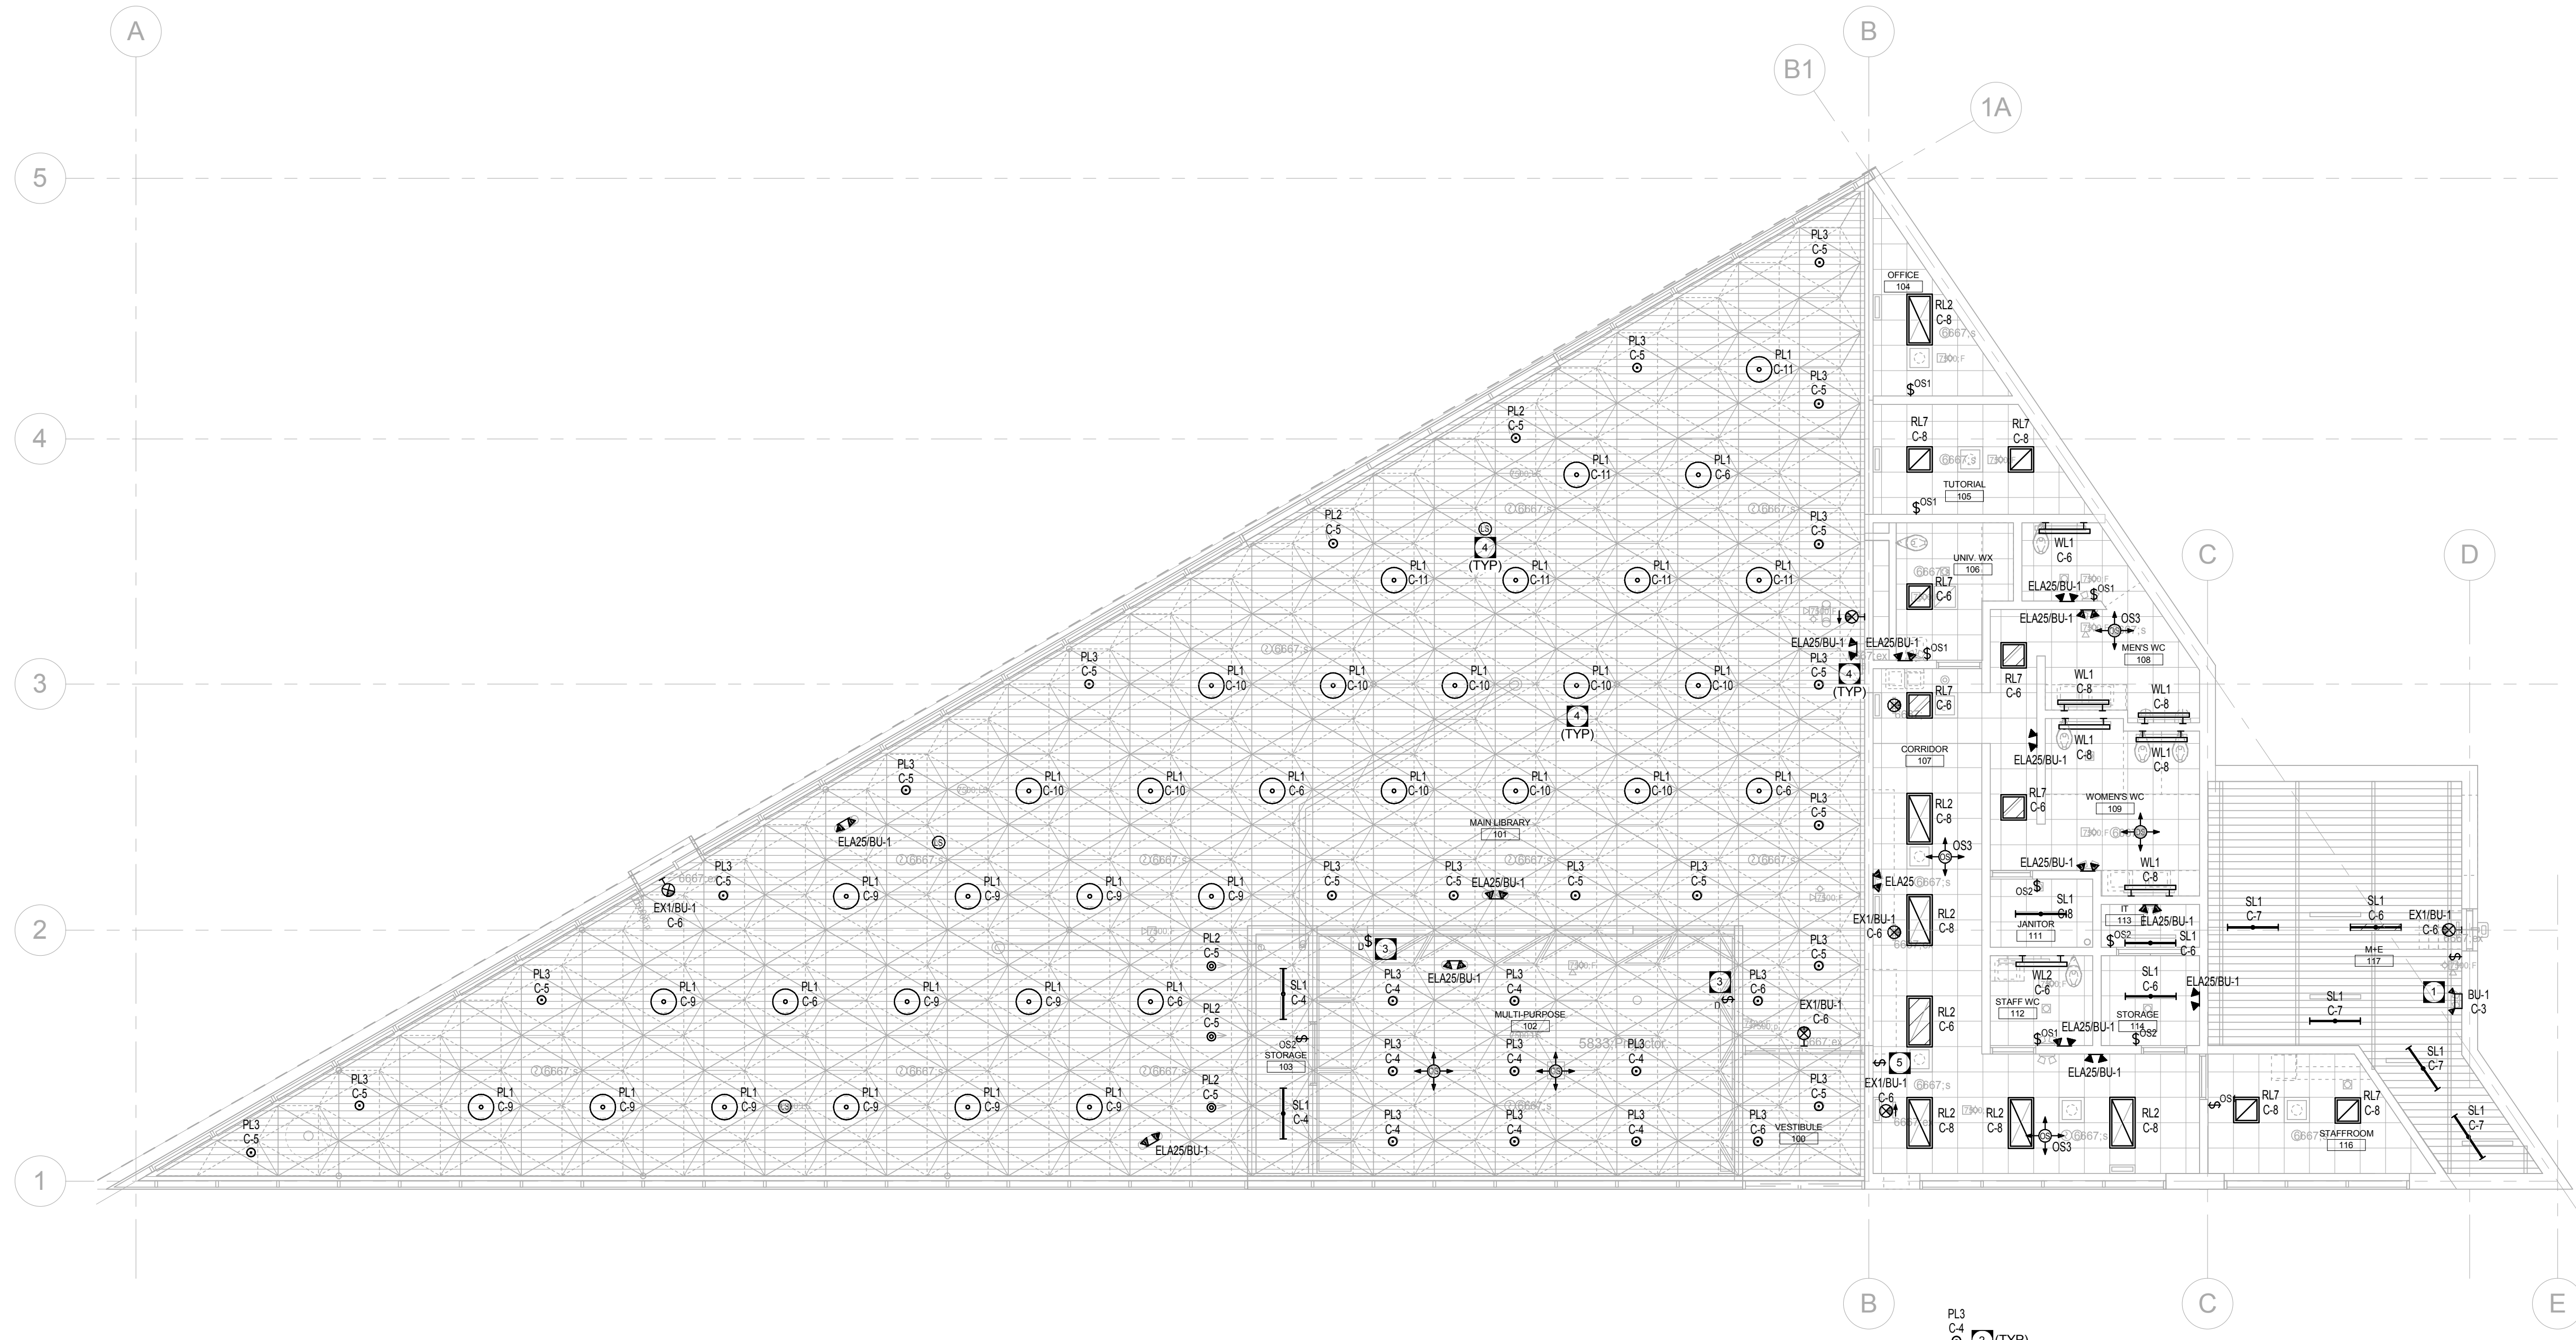

1 MAIN FLOOR PLAN - LIGHTING
 EL2.1 SCALE: 1/8" = 1'-0"

epp siepman engineering inc.
 mechanical & electrical engineers
 303-100 Osborne St. South
 Winnipeg, MB R3L 1Y5
 p 204.453.1080
 ese@eppsiepman.com

O 16-03-31 Issued for Construction
 revision

THIS DRAWING IS THE EXCLUSIVE PROPERTY OF H5 ARCHITECTURE AND DAVID PENNER ARCHITECT AND MAY NOT BE REPRODUCED AND/OR USED IN ANY MANNER WITHOUT THEIR EXPRESSED WRITTEN PERMISSION. THE GENERAL CONTRACTOR AND MATERIALS SUPPLIERS SHALL CHECK ALL DIMENSIONS AND INFORMATION ON THIS DRAWING AND REPORT ANY DISCREPANCIES PRIOR TO COMMENCEMENT OF WORK. DO NOT SCALE THIS DRAWING.

OWNER

 CITY OF WINNIPEG - PLANNING, PROPERTY & DEVELOPMENT DEPARTMENT
 MUNICIPAL ACCOMMODATIONS DIVISION
 3rd FLOOR - 65 GARRY ST., WPG, R3C 4K4

david penner
 ARCHITECT
 +
h5a
 h5 architecture

David Penner, 204.475.8978
 Hello Rodrigues, 204.774.0012
 120 Yale Avenue, Winnipeg, MB, R3M 0L7

PROJECT
 Windsor Park Library
ADDRESS
 1201 Archibald Street
DATE
 February 28, 2016
SCALE
 As indicated

main floor -
 lighting
EL2.1