



THE CITY OF WINNIPEG

PUBLIC WORKS DEPARTMENT


ENGINEERING DIVISION

2016 LOCAL STREETS PACKAGE


SONY PLACE, TROTTIER BAY AND

VARIOUS OTHER LOCATIONS

BID OPPORTUNITY No. 181-2016

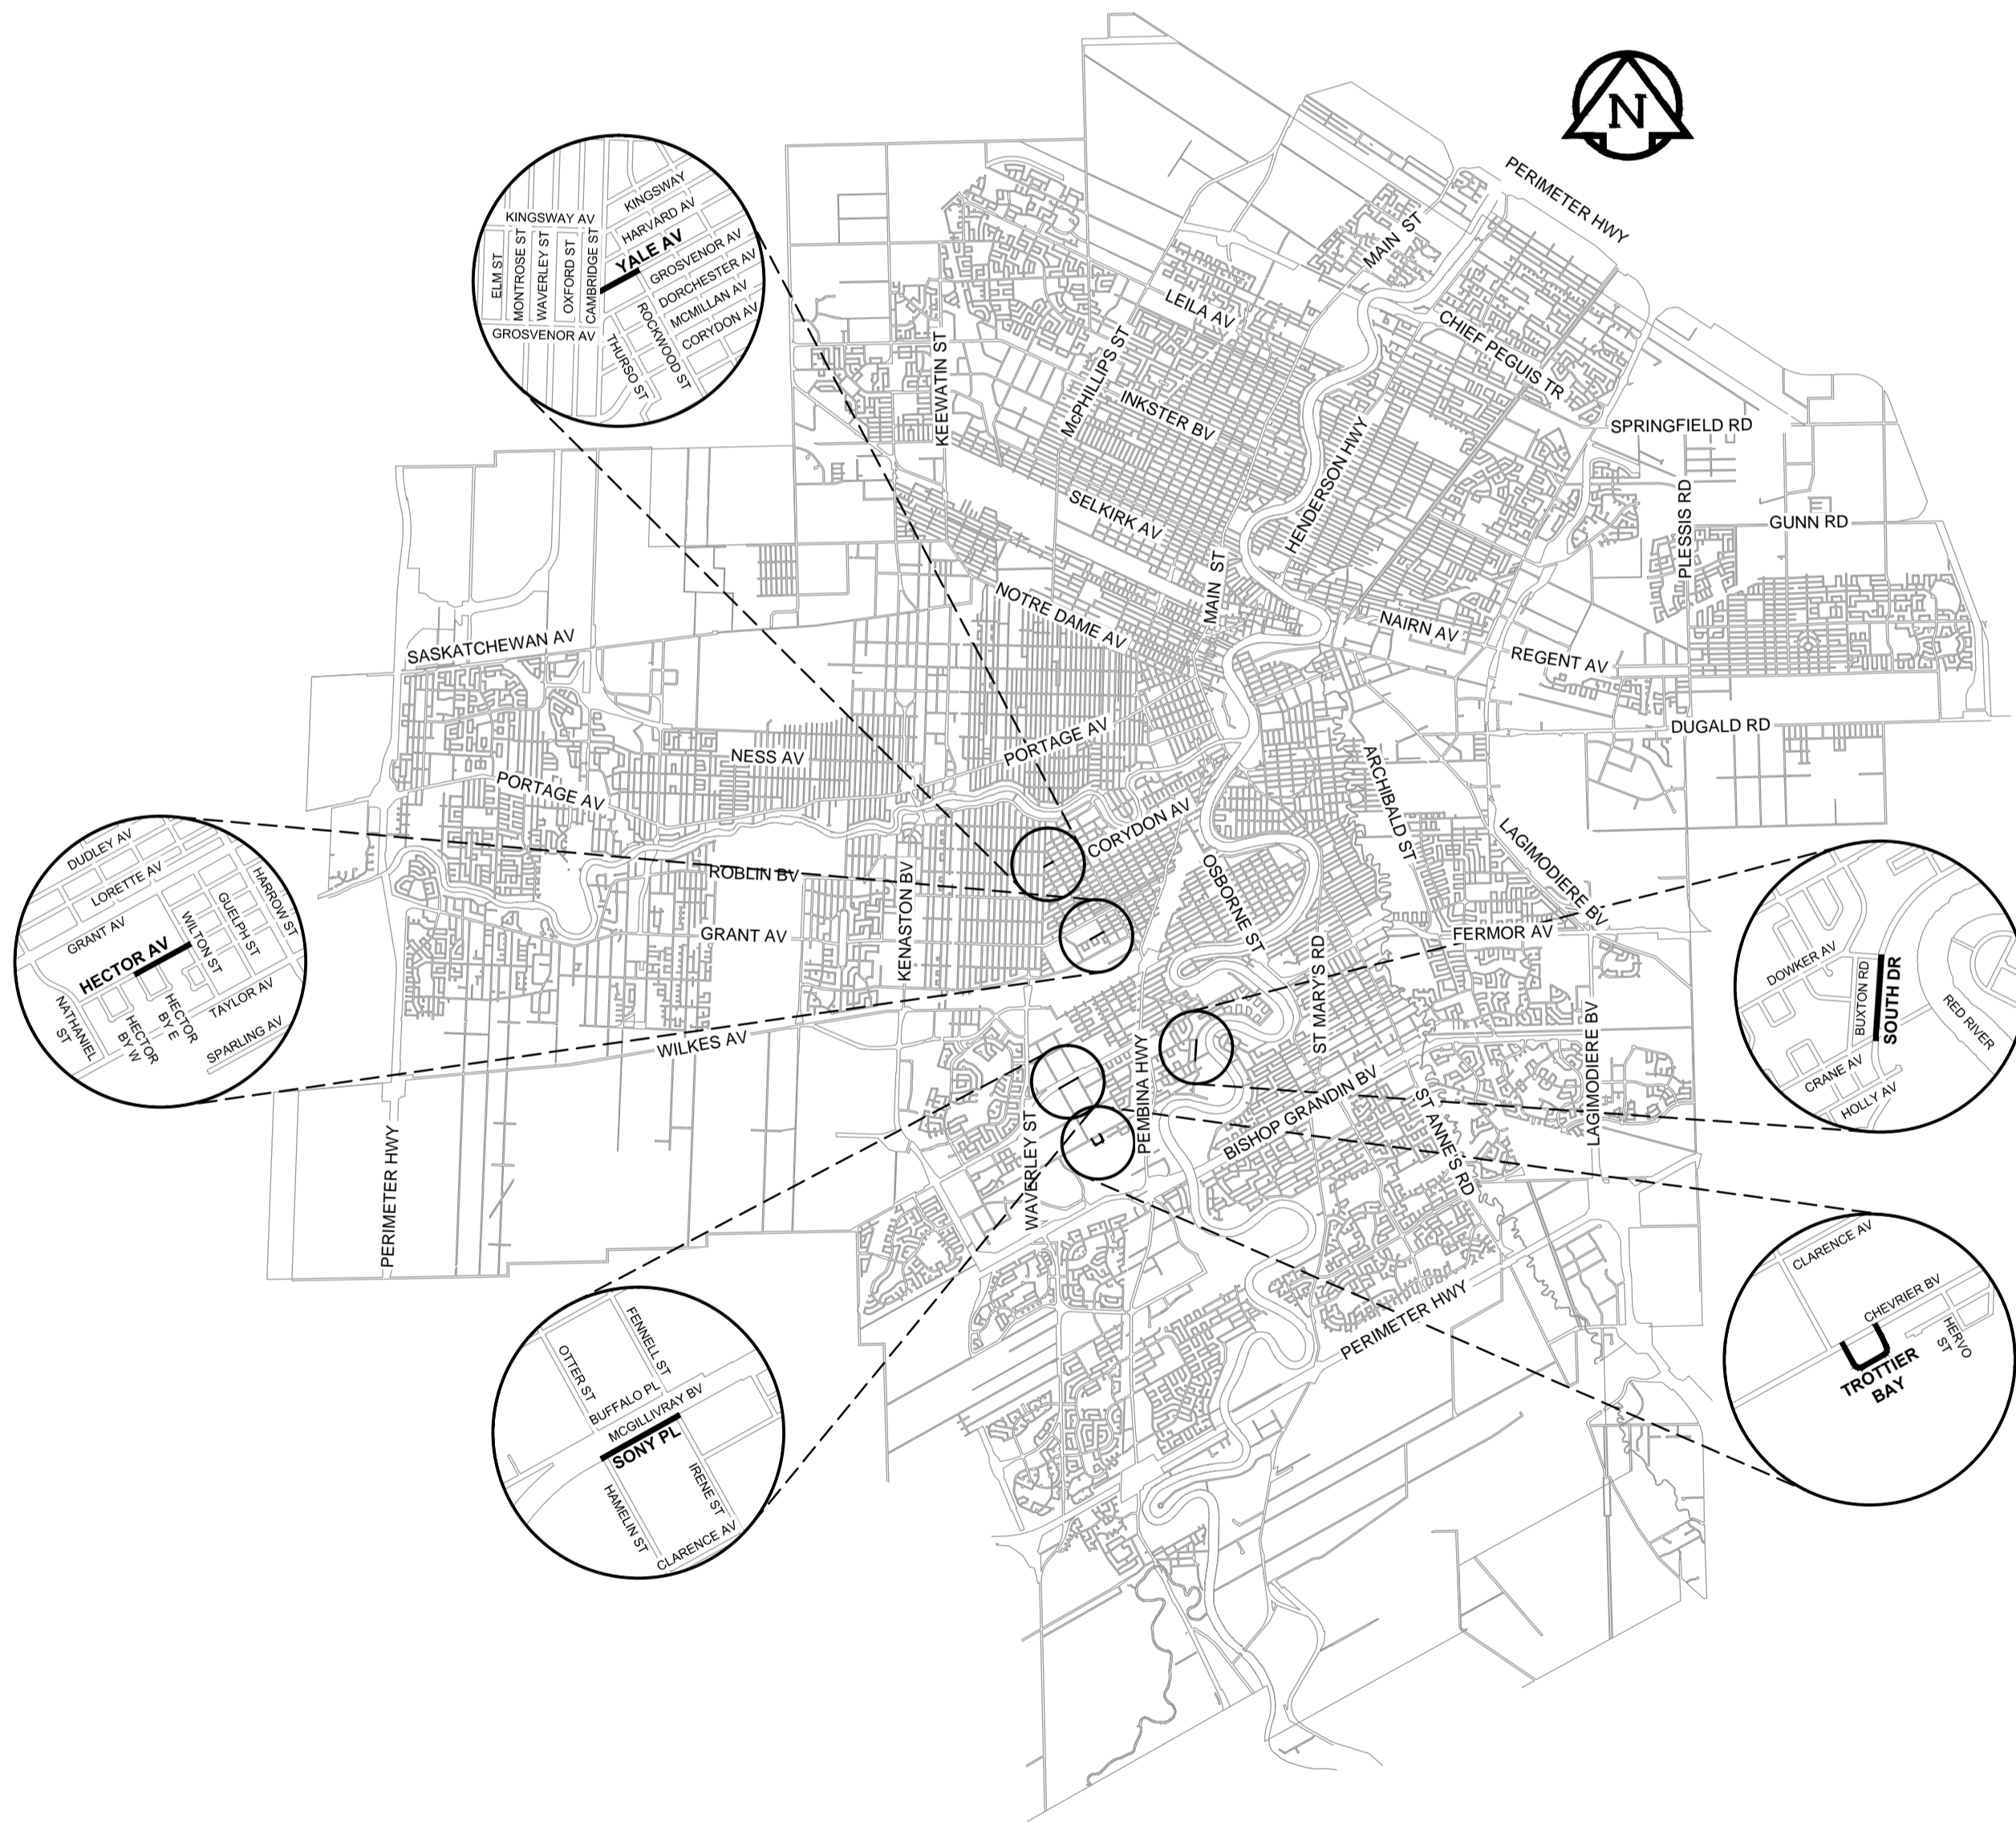

LOCATION PLAN

 

DRAWING LIST

DRAWING NUMBER DESCRIPTION

0 COVER SHEET AND LOCATION PLAN

**YALE AVENUE - CAMBRIDGE ST TO ROCKWOOD ST
CONCRETE RECONSTRUCTION**

HORIZONTAL AND VERTICAL ALIGNMENT
1 CAMBRIDGE ST TO STA 0+190
2 STA 0+190 TO ROCKWOOD ST

**HECTOR AVENUE - HECTOR BAY E (W LEG) TO WILTON ST
CONCRETE RECONSTRUCTION**

HORIZONTAL AND VERTICAL ALIGNMENT
3 HECTOR BAY E (W LEG) TO STA 0+450
4 STA 0+450 TO STA 0+550
5 STA 0+550 TO WILTON ST

**SONY PLACE - HAMELIN ST TO IRENE ST
CONCRETE RECONSTRUCTION**

HORIZONTAL AND VERTICAL ALIGNMENT
6 HAMELIN ST TO STA 0+220
7 STA 0+220 TO STA 0+350
8 STA 0+350 TO IRENE ST

**TROTTIER BAY - CHEVRIER BV TO CHEVRIER BV
CONCRETE RECONSTRUCTION**

HORIZONTAL AND VERTICAL ALIGNMENT
9 CHEVRIER BV TO STA 0+220
10 STA 0+220 TO STA 0+360
11 STA 0+360 TO CHEVRIER BV

**SOUTH DRIVE - CRANE AV TO DOWKER AV
CONCRETE RECONSTRUCTION**

HORIZONTAL AND VERTICAL ALIGNMENT
12 CRANE AV TO STA 0+210
13 STA 0+210 TO STA 0+340
14 STA 0+340 TO DOWKER AV

STREET LIGHTING PROJECT

- 1-04707-DE-50000-0282 0001 YALE AVENUE - CAMBRIDGE ST TO ROCKWOOD ST
(CONTRACTOR TO REPLACE EXISTING UNDERGROUND STREET LIGHTING PLANT)
- 1-04707-DE-50000-0284 0001 HECTOR AVENUE - HECTOR BAY E (W LEG) TO WILTON ST
(CONTRACTOR TO REPLACE EXISTING UNDERGROUND STREET LIGHTING PLANT)
- 1-04707-DE-50000-0285 0001 SONY PLACE - HAMELIN ST TO IRENE ST
(CONTRACTOR TO REPLACE EXISTING UNDERGROUND STREET LIGHTING PLANT)

HECTOR AVENUE - SEWER REPAIRS

- 11298 300 CONC CS POINT REPAIR
MH AT HECTOR BAY E (W LEG) TO MH AT HECTOR BAY E (E LEG)
- 11299 375 CONC CS POINT REPAIR
MH AT WILTON ST TO 1st MH W OF WILTON ST

IRENE STREET - SEWER REPAIRS

- LD-7841 300 CONC LDS POINT REPAIR
1st MH S OF SONY PL TO MH AT SONY PL

SOUTH DRIVE - SEWER REPAIRS

- LD-7842 300 CONC LDS POINT REPAIR
1st MH S OF DOWKER AV TO MH AT DOWKER AV



RELEASED FOR CONSTRUCTION BY:

STREETS PROJECT ENGINEER

DATE



COVER SHEET AND LOCATION PLAN

CITY DRAWING No. N/A REV C

CONSULTANT NO. W160015-Cover Sheet 2B.dwg