




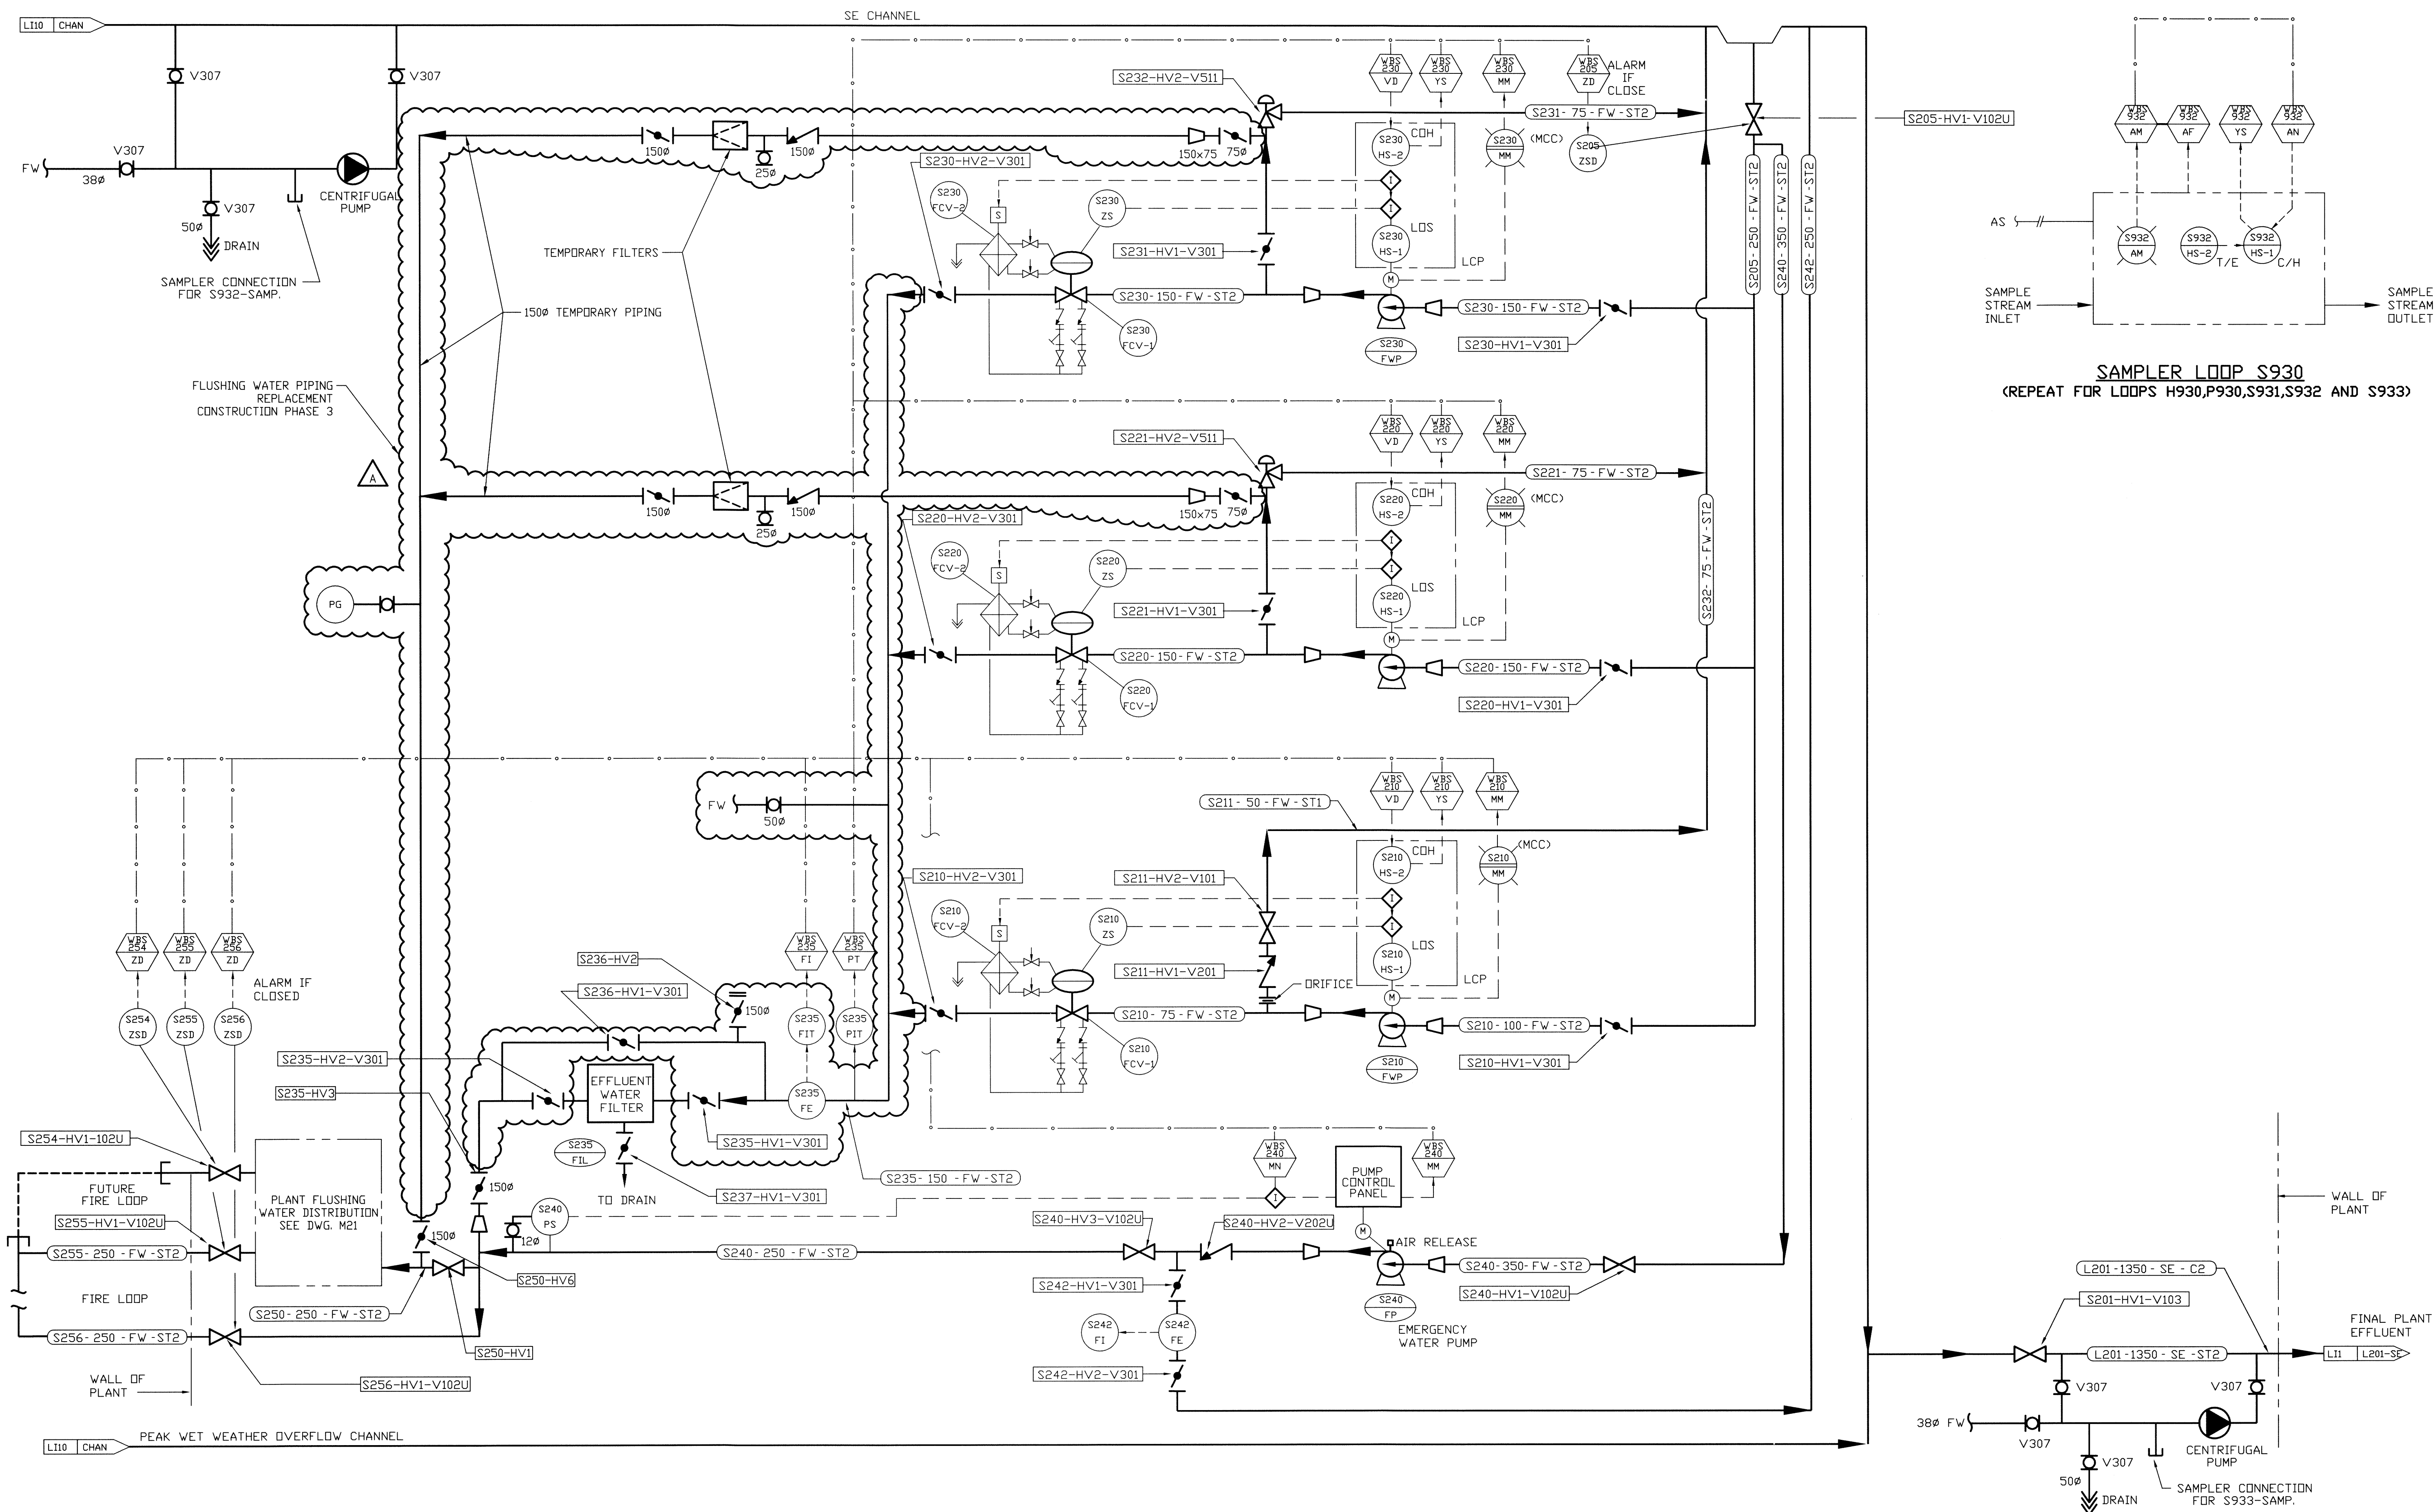

THIS DRAWING IS BASED ON EXISTING SYSTEM P&ID,
DRAWING NO. WEP-93 REV. 2

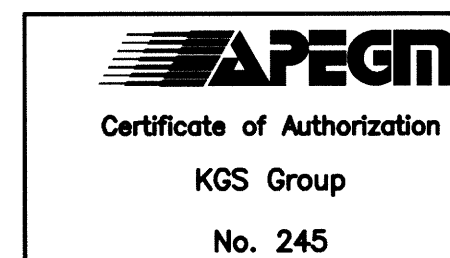

		FIELD BOOK #:		KGS GROUP CONSULTING ENGINEERS		
POSTED TO LBIS						
				DESIGNED BY JS	CHECKED BY <i>MSK</i>	
				DRAWN BY JFS	APPROVED BY <i>JS</i>	
				HOR. SCALE AS NOTED	RELEASED FOR CONSTRUCTION	
0	ISSUED FOR CONSTRUCTION	16/05/09	<i>JS</i>	VERT. SCALE AS NOTED		
NL	REVISIONS	DATE		DATE	2016-05-09	

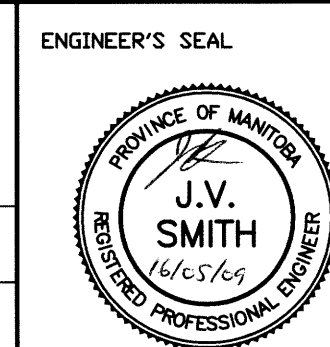

P1.3



THE CITY OF WINNIPEG
WATER AND WASTE DEPARTMENT

WEWPCC FW PIPE REPLACEMENT
MECHANICAL
FLUSHING WATER PIPE REPLACEMENT
CONSTRUCTION PHASE 3
PIPING AND INSTRUMENTATION DIAGRAM

SHEET 1	OF 1
CITY DRAWING NUMBER	
1-0103S-P0025-001	