



NOTE:  
 NOT ALL SHELTERS REQUIRE ELECTRICAL SUPPLY  
 SEE SPECIFICATION FOR LOCATIONS  
 ELECTRICAL WIRES TO EXTEND 1.0 m ABOVE CONCRETE PAD  
 ELECTRICAL SUPPLY IS 120 VOLT 2.8 AMP, 60 CYCLE (BY OTHERS)

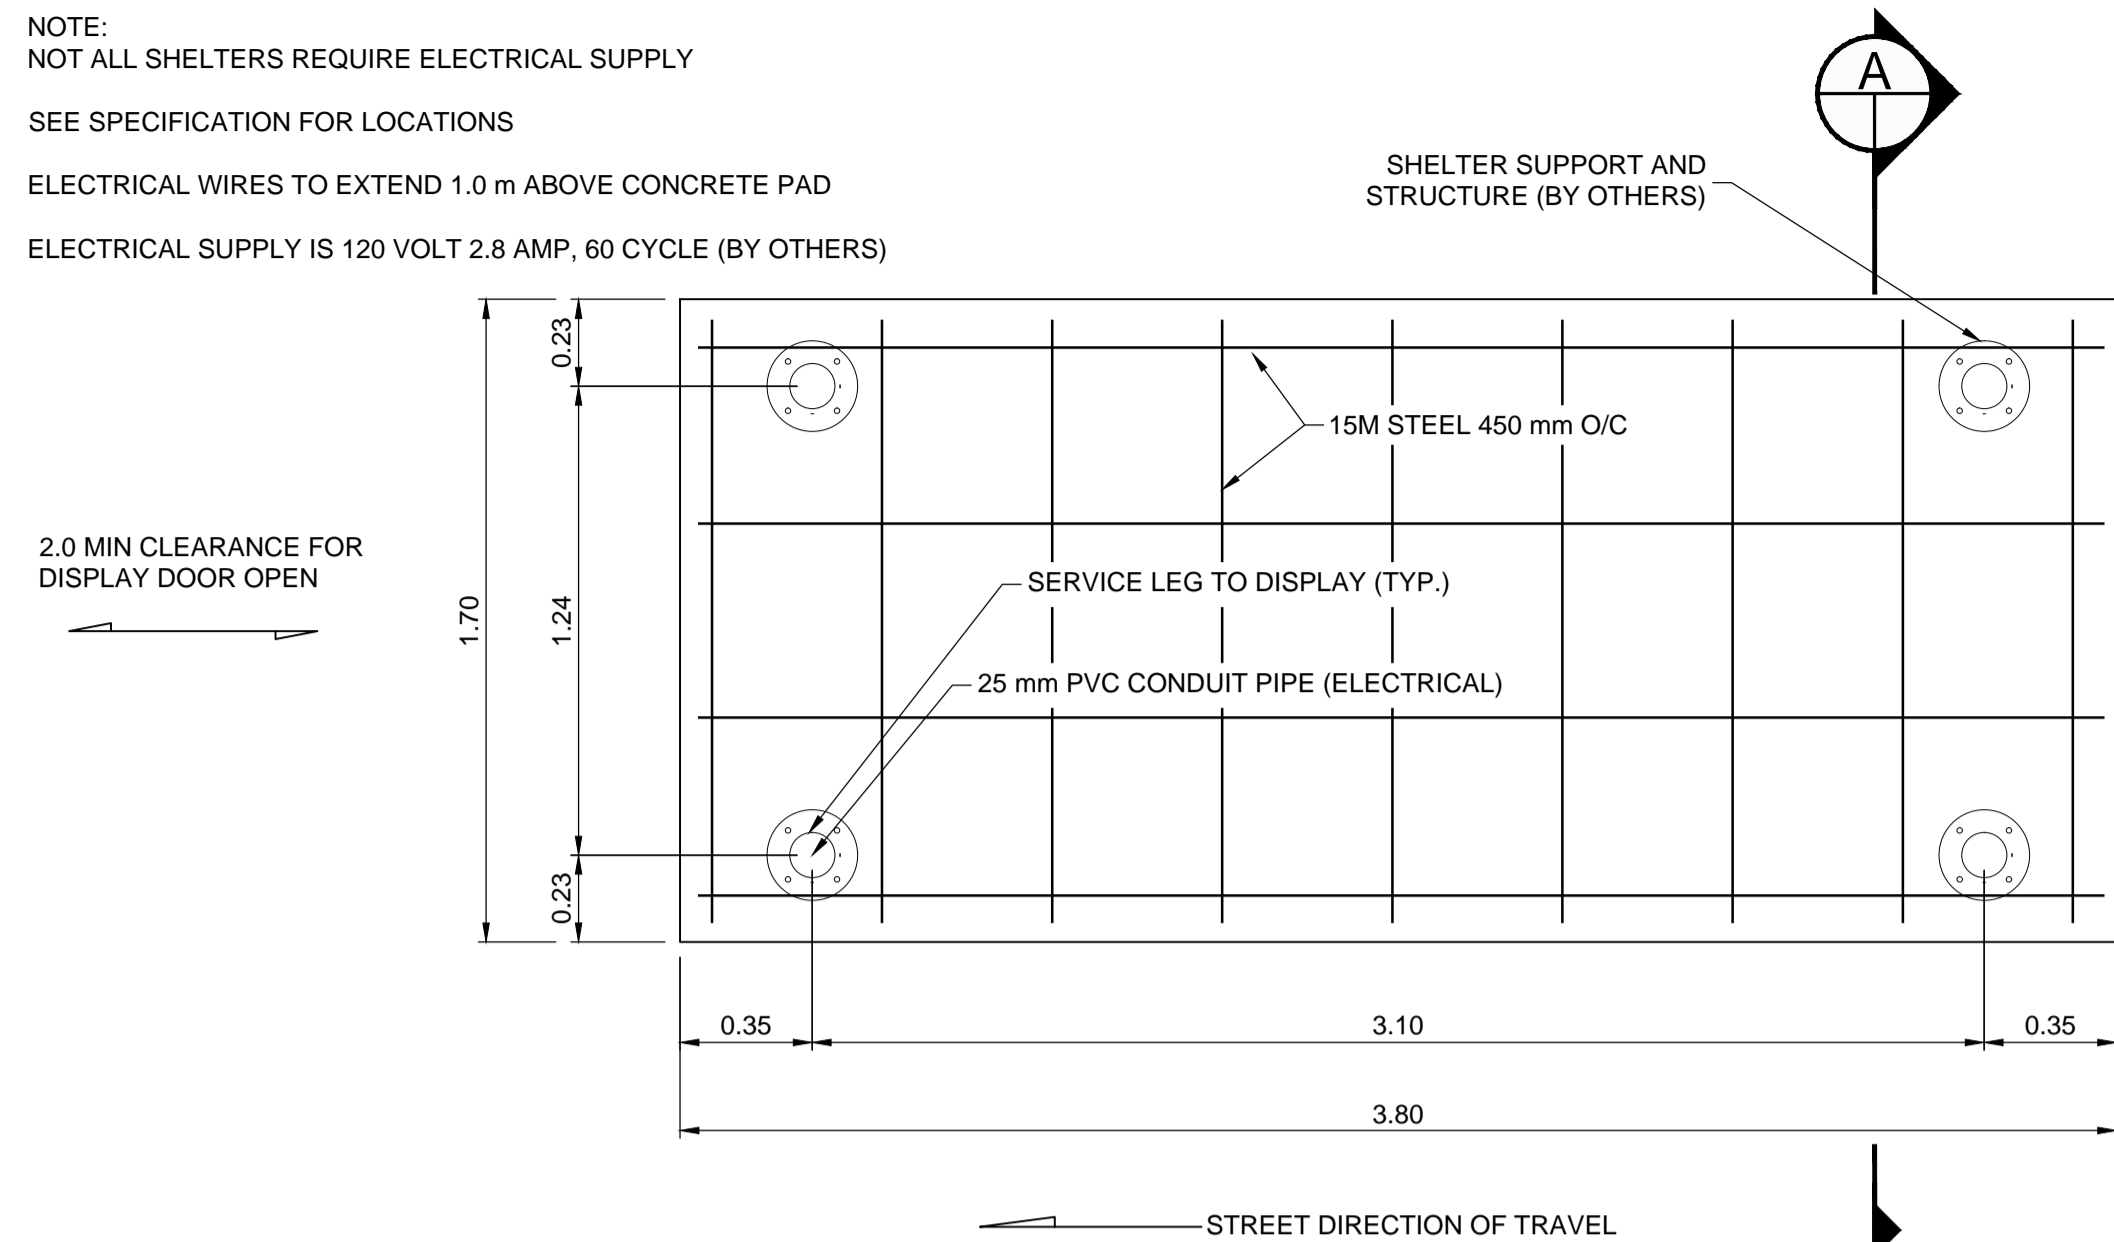


**18** TRANSIT SHELTER FOUNDATION PLAN  
 SCALE: 1:20

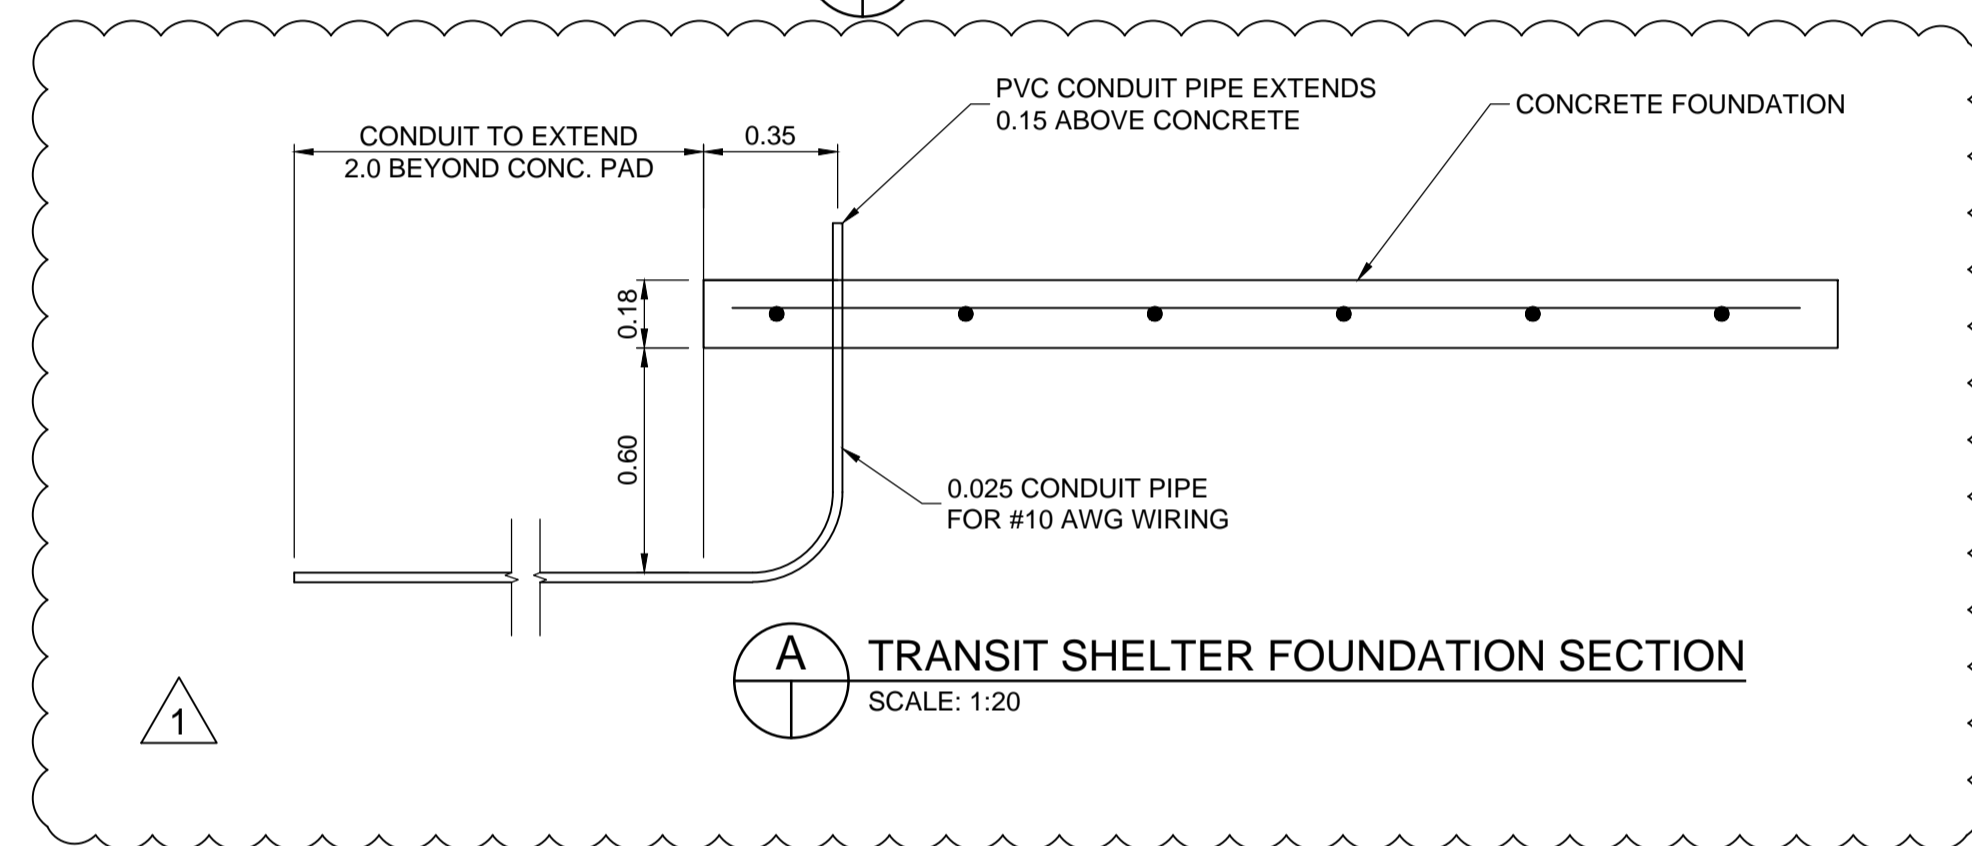


**A** TRANSIT SHELTER FOUNDATION SECTION  
 SCALE: 1:20

4

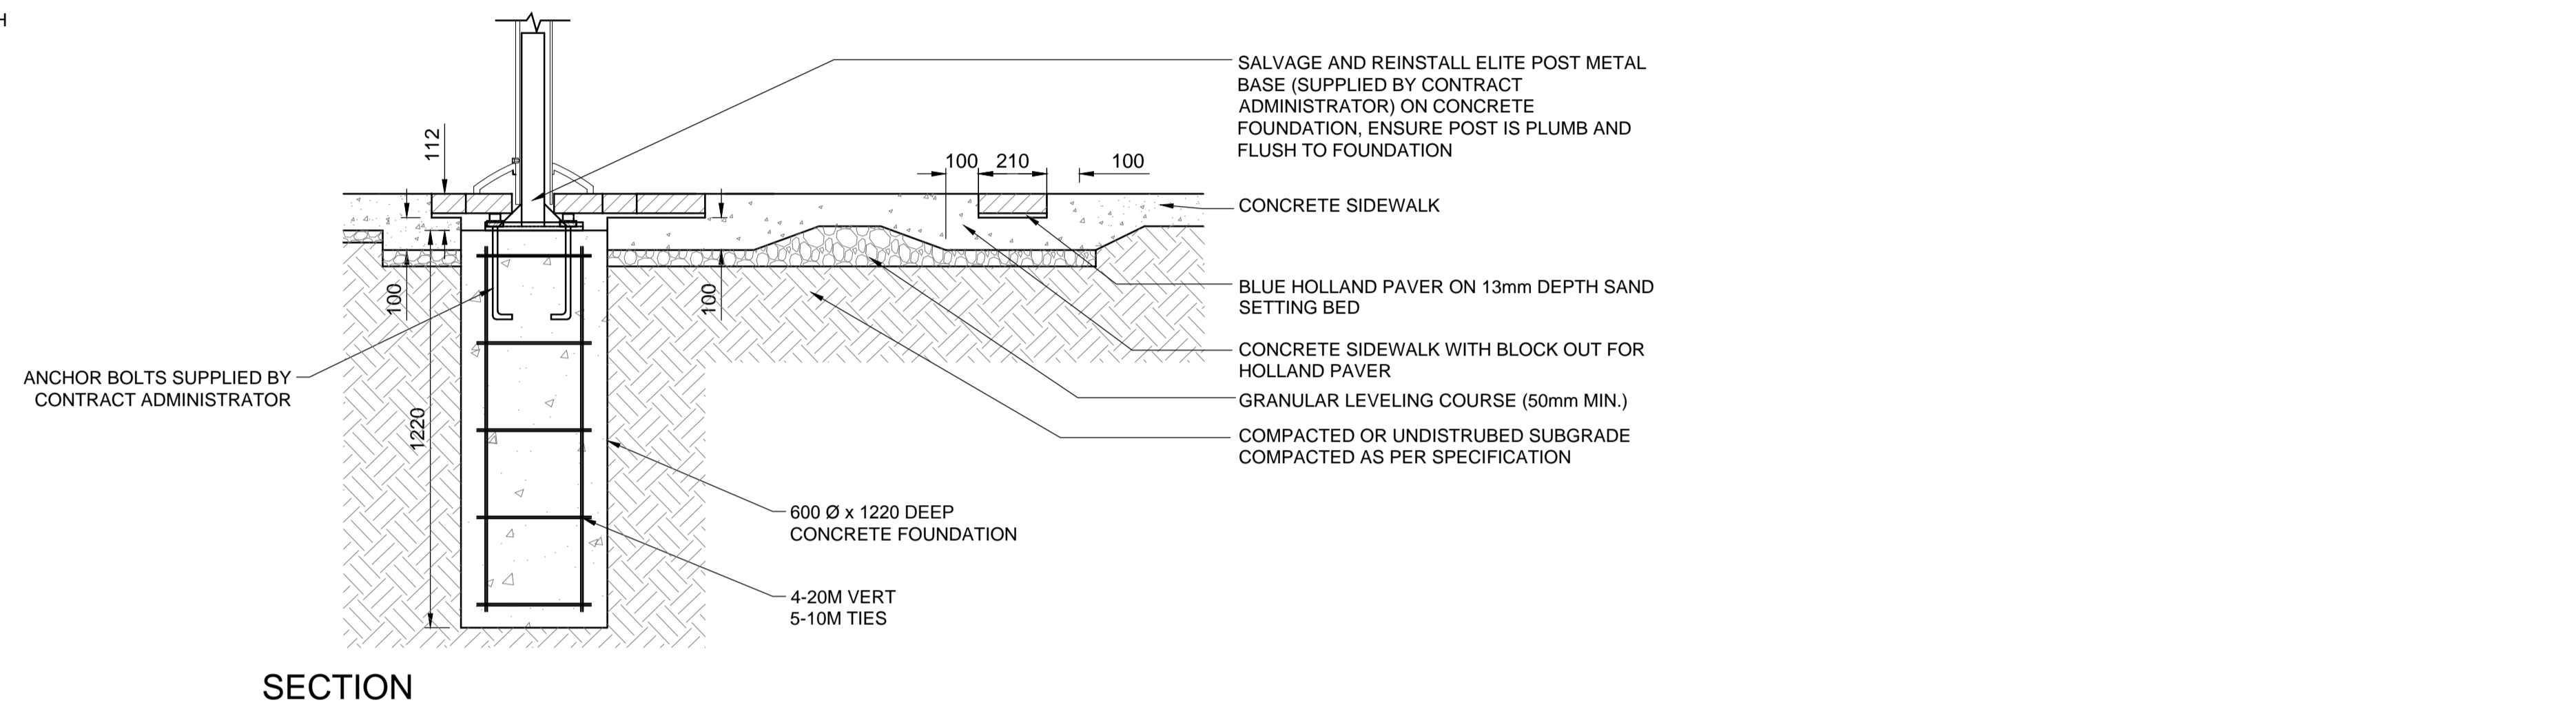

SECTION

**20** TRANSIT BUS STOP FLAG FOUNDATION AND STOP INDICATOR PAVERS  
 SCALE: NTS

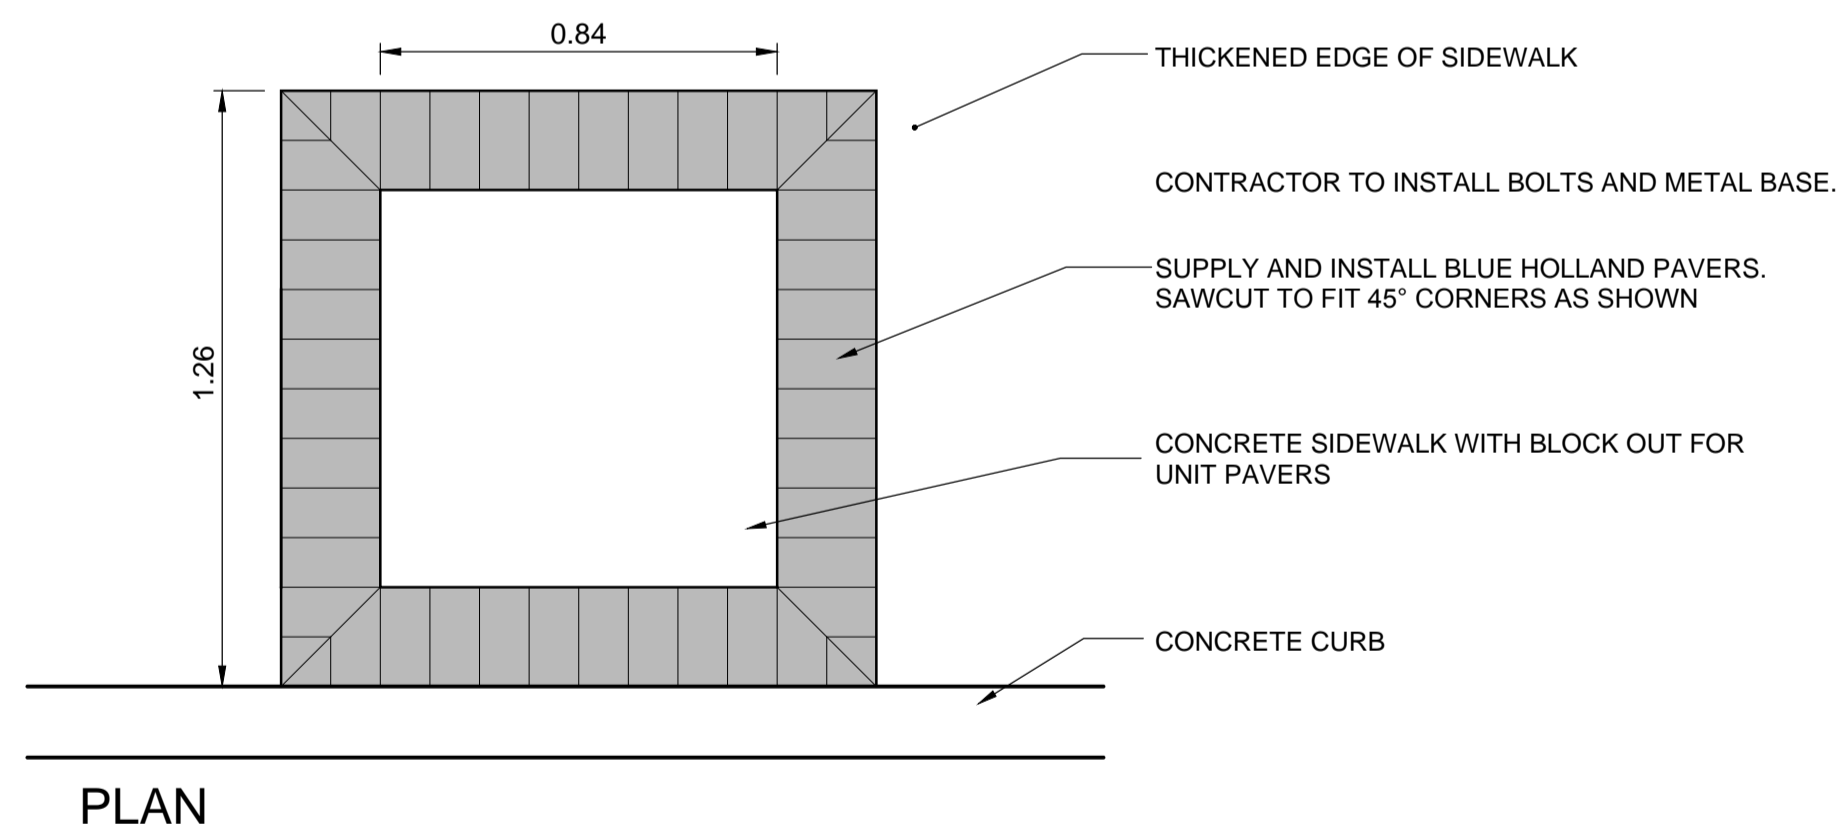

PLAN

**21** STOP INDICATOR PAVERS  
 SCALE: NTS



UNDERGROUND STRUCTURES  SUPV. U/G STRUCTURES DATE	B.M. ELEV.	SEE SHEET C2-CT-007 FOR CONTROL POINT INFORMATION		ENGINEER'S SEAL	<b>THE CITY OF WINNIPEG</b> PUBLIC WORKS DEPARTMENT	CITY DRAWING NUMBER
				DESIGNED BY RTP CHECKED BY DBW DRAWN BY RD APPROVED BY DBW		
LOCATION OF UNDERGROUND STRUCTURES AS SHOWN ARE BASED ON THE BEST INFORMATION AVAILABLE. BUT NO GUARANTEE IS GIVEN THAT ALL EXISTING UTILITIES ARE SHOWN OR THAT THE GIVEN LOCATIONS ARE EXACT. CONFIRMATION OF EXISTENCE AND EXACT LOCATION OF ALL SERVICES MUST BE OBTAINED FROM THE INDIVIDUAL UTILITIES BEFORE PROCEEDING WITH CONSTRUCTION.	1 ADDENDUM #7 17/03/20 DBW 0 ISSUED FOR TENDER 17/01/09 DBW	NO. REVISIONS DATE BY	HOR. SCALE AS NOTED VERTICAL AS NOTED	RELEASED FOR CONSTRUCTION DATE	CONSULTANT PROJECT NUMBER 16-3353	CONSULTANT DRAWING NUMBER C2-CT-077

G:\CAD\163353\Technical Workspace\Engineering\Drawings and Figures\Roadworks\Contract\163353-C2-CON-CT-DETAILS.dwg