


1 MAIN LEVEL - LIGHTING PLAN

BE-004 SCALE: 1 : 50

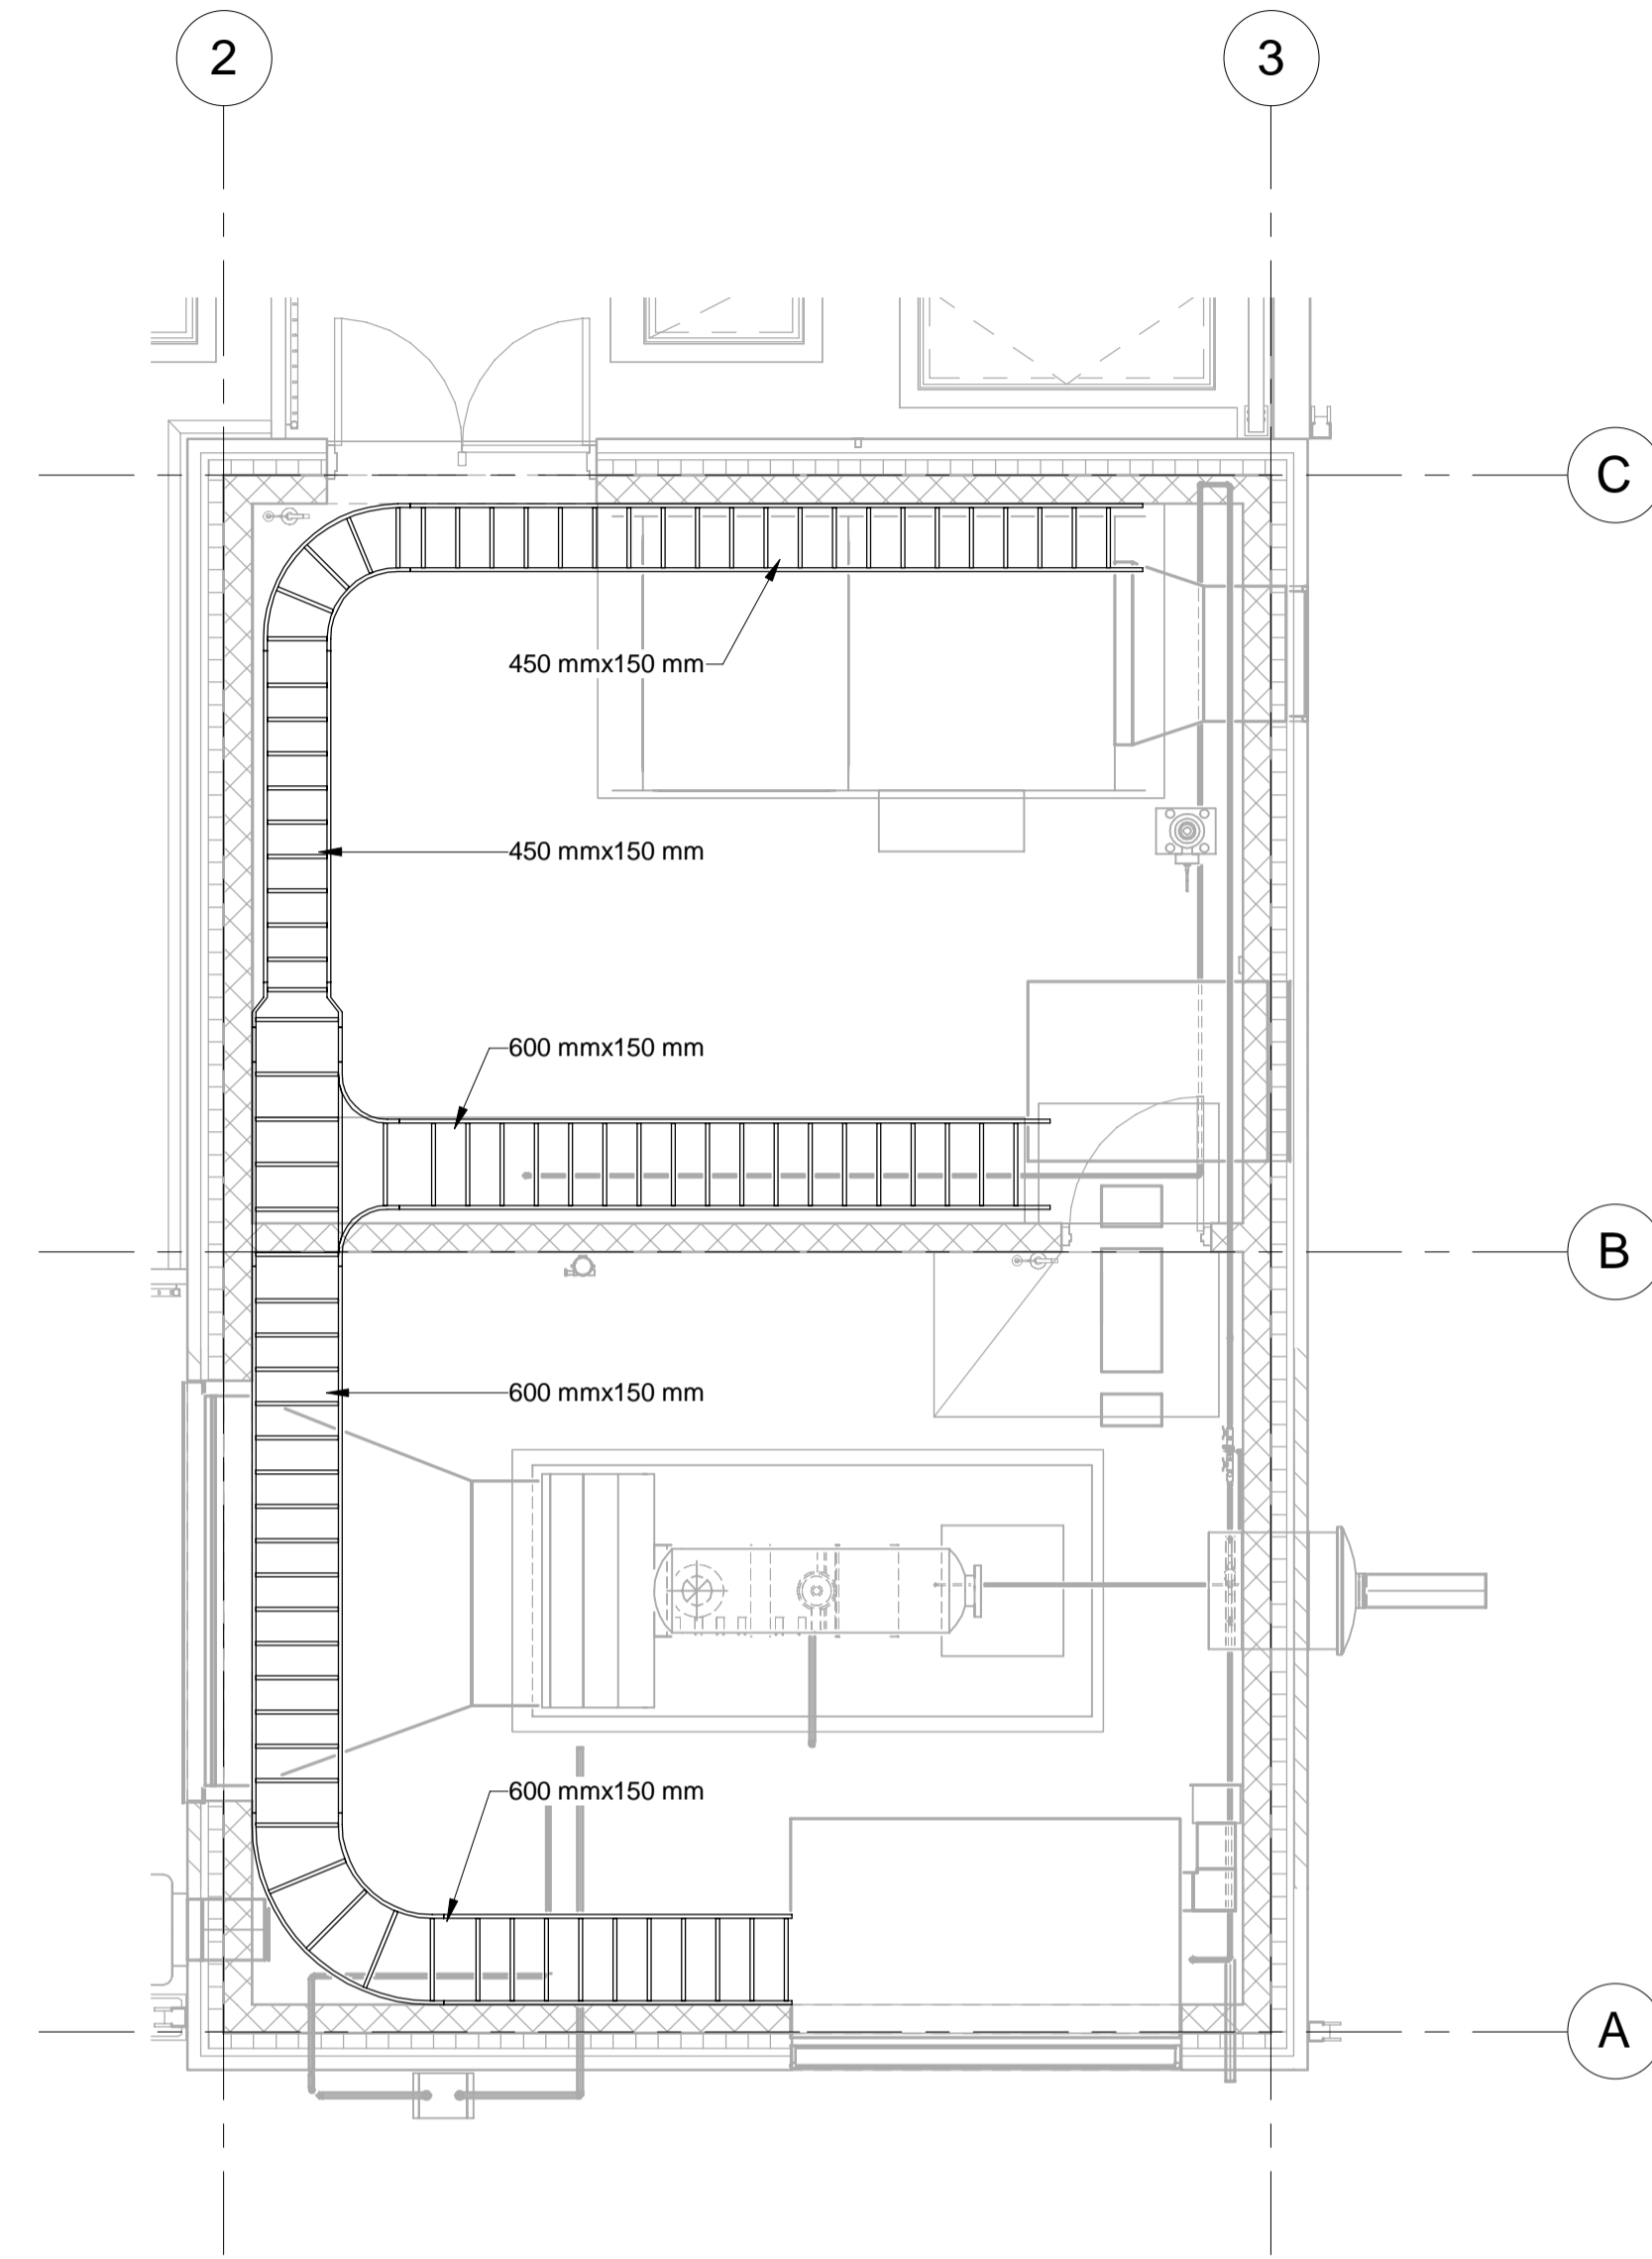

2 MAIN LEVEL - CABLE TRAY

BE-004 REF: BE-003 SCALE: 1 : 50

P:\60321148\900-Work\910-CAD\99-SUPPORT\PROJECT_TITLE_BLOCKS\163383-XTB-C1-CU.dwg



METRIC
WHOLE NUMBERS INDICATE MILLIMETRES
DECIMALIZED NUMBERS INDICATE METRES

UNDERGROUND STRUCTURES SUPV. U/G STRUCTURES DATE		B.M. ELEV.							CITY DRAWING NUMBER U-239-2016-C2-BE-004		
<small>LOCATION OF UNDERGROUND STRUCTURES AS SHOWN ARE BASED ON THE BEST INFORMATION AVAILABLE. BUT NO GUARANTEE IS GIVEN THAT ALL EXISTING UTILITIES ARE SHOWN OR THAT THE GIVEN LOCATIONS ARE EXACT. CONFIRMATION OF EXISTENCE AND EXACT LOCATION OF ALL SERVICES MUST BE OBTAINED FROM THE INDIVIDUAL UTILITIES BEFORE PROCEEDING WITH CONSTRUCTION.</small>		O ISSUED FOR TENDER 17/01/09 RC					DESIGNED BY RB CHECKED BY LCS DRAWN BY RC APPROVED BY SS		CONSULTANT PROJECT NUMBER 60321148		SHEET 4 OF 8
NO. REVISIONS DATE BY		O ISSUED FOR TENDER 17/01/09 RC		HOR. SCALE AS SHOWN RELEASED FOR CONSTRUCTION VERTICAL		CONSULTANT PROJECT NUMBER 60321148		PUMPING STATION LIGHTING & CABLE TRAY MAIN LEVEL		CONSULTANT DRAWING NUMBER C2-BE-004	