


- NOTES:**
1. WINTER WATER MAIN BREAKS MAY RESULT IN OVER TOPPING WEIR AND ENTIRE OUTFALL.
 2. CONTRACTOR TO PROVIDE PROPER WARNING SIGNS ALONG PEDESTRIAN PATH CONCERNING WORK SITE.
 3. ALL EXCAVATED MATERIAL WITHIN 107.0 OF THE REGULATED SUMMER RIVER LEVEL (RSRL) MUST BE REMOVED FROM SITE (NO STOCKPILING).

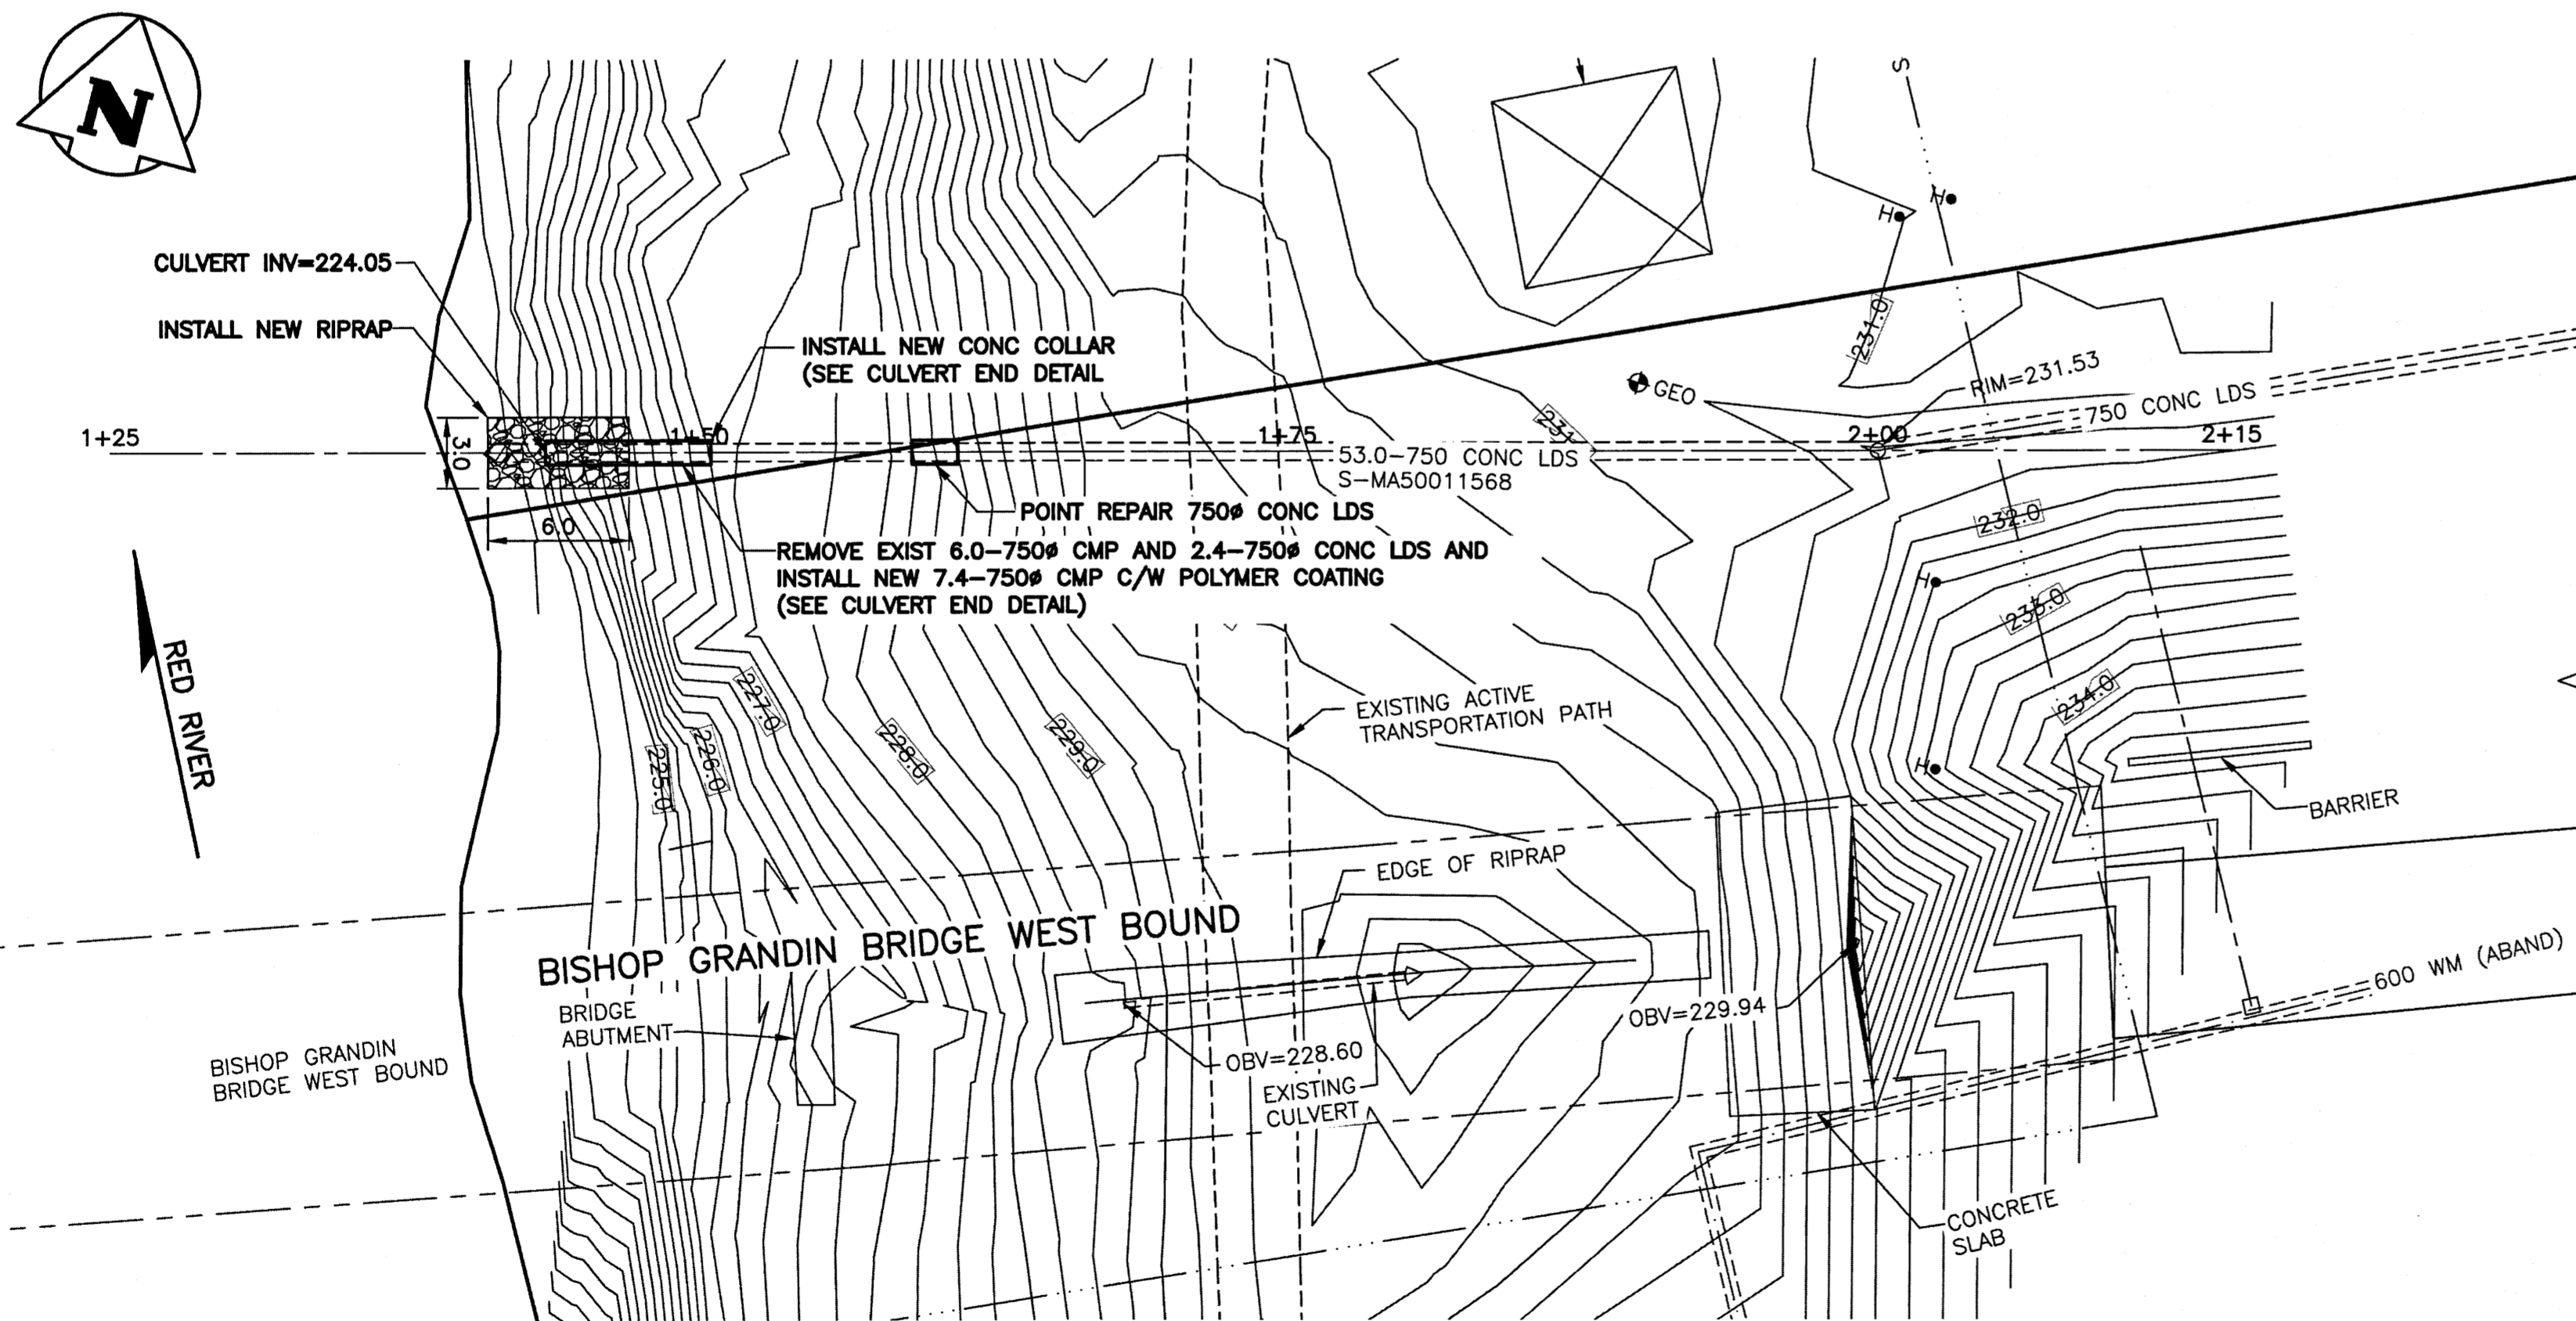

WARNING


1. NOTIFY THE GAS COMPANY OF THE PROPOSED LOCATION OF EXCAVATION.
2. TAKE PRECAUTION TO AVOID DAMAGE TO GAS COMPANY INSTALLATIONS.
3. SEE PROVINCIAL REGULATION 210/72 FOR DETAILS.

PROPERTY LIMITS DELINEATION

DELINEATION OF PROPERTY LIMITS AS SHOWN ON THIS DWG DOES NOT REPRESENT A "LEGAL SURVEY". KGS GROUP MAKES NO REPRESENTATION OR WARRANTY AS TO THE ACCURACY OF PROPERTY LIMITS DELINEATED ON THIS DWG, NOR ON THE DIMENSIONAL ACCURACY OF DWG FEATURES RELATIVE TO THOSE PROPERTY LIMITS.

METRIC

WHOLE NUMBERS INDICATE MILLIMETRES
DECIMALIZED NUMBERS INDICATE METRES

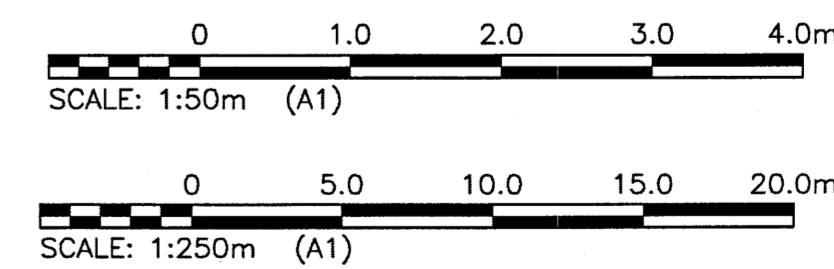

File Name: U:\P15\16-0107-021_CALL.dwg - Tab: C01 Plotted By: dweber 16/11/03 [Thu 3:01pm] A1/PLOT SCALE=1

EXISTING	LEGEND-PLAN	PROPOSED	EXISTING	LEGEND-PLAN	PROPOSED	EXISTING	LEGEND-PROFILE	PROPOSED
150 WM	WATERMAIN	150 WM	---	HYDRO	---			
300 LDS	LAND DRAINAGE SEWER	300 LDS	---	M.T.S.	---			
250 WWS	WASTE WATER SEWER	250 WWS	---	PROPERTY LINE	---			
○	MANHOLE	●	---	SURVEY BAR	---			
□	CATCH BASIN	■	---	LIGHT STANDARD	---			
▽	CURB INLET	○	---	HYDRO POLE	---			
+	JUNCTIONS	+	---	GUY WIRE	---			
---	CULVERT	---	---	SIGN	---			
---	GAS	---	---	BUSH LINE	---			
			---	FENCE	---			
			---	ELEVATION	---			

LOCATION APPROVED UNDERGROUND STRUCTURES

SUPV. U/G STRUCTURES DATE COMMITTEE

NOTE: LOCATION OF UNDERGROUND STRUCTURES AS SHOWN ARE BASED ON THE BEST INFORMATION AVAILABLE BUT NO GUARANTEE IS GIVEN THAT ALL EXISTING UTILITIES ARE SHOWN OR THAT THE GIVEN LOCATIONS ARE EXACT. CONFIRMATION OF EXISTENCE AND EXACT LOCATION OF ALL SERVICES MUST BE OBTAINED FROM THE INDIVIDUAL UTILITIES BEFORE PROCEEDING WITH CONSTRUCTION.

B.M. KGS_BASE	ELEV=249.213	NAD83	CSRS	CGVD28
NO.	ISSUED FOR CONSTRUCTION	03/11/16	BY	
NO.	REVISIONS	DATE	BY	

KGS GROUP CONSULTING ENGINEERS

DESIGNED BY	JB	CHECKED BY	RBO
DRAWN BY	DMW	APPROVED BY	
HOR. SCALE:	1:250	RELEASED FOR CONSTRUCTION:	
VERTICAL:	1:50	DATE	Nov 4/16
DATE	28/09/16		

ENGINEER'S SEAL

THE CITY OF WINNIPEG WATER & WASTE DEPARTMENT

2017 OUTFALL RENEWAL/REHABILITATION PROGRAM
BISHOP GRANDIN OUTFALL (RR-21)
PLAN AND PROFILE
S-MA50011568

PROVINCIAL REGISTERED PROFESSIONAL ENGINEER
Member 34869
2016-11-03

CONSULTANT DRAWING NO. 16-0107-021_C01

SHEET 01 OF 08
CAD FILE DRAWING NUMBER 16-0107-021_CALL
CITY DRAWING NUMBER LD-7986