



1 WALL SECTION
1:10
BGAD-S015

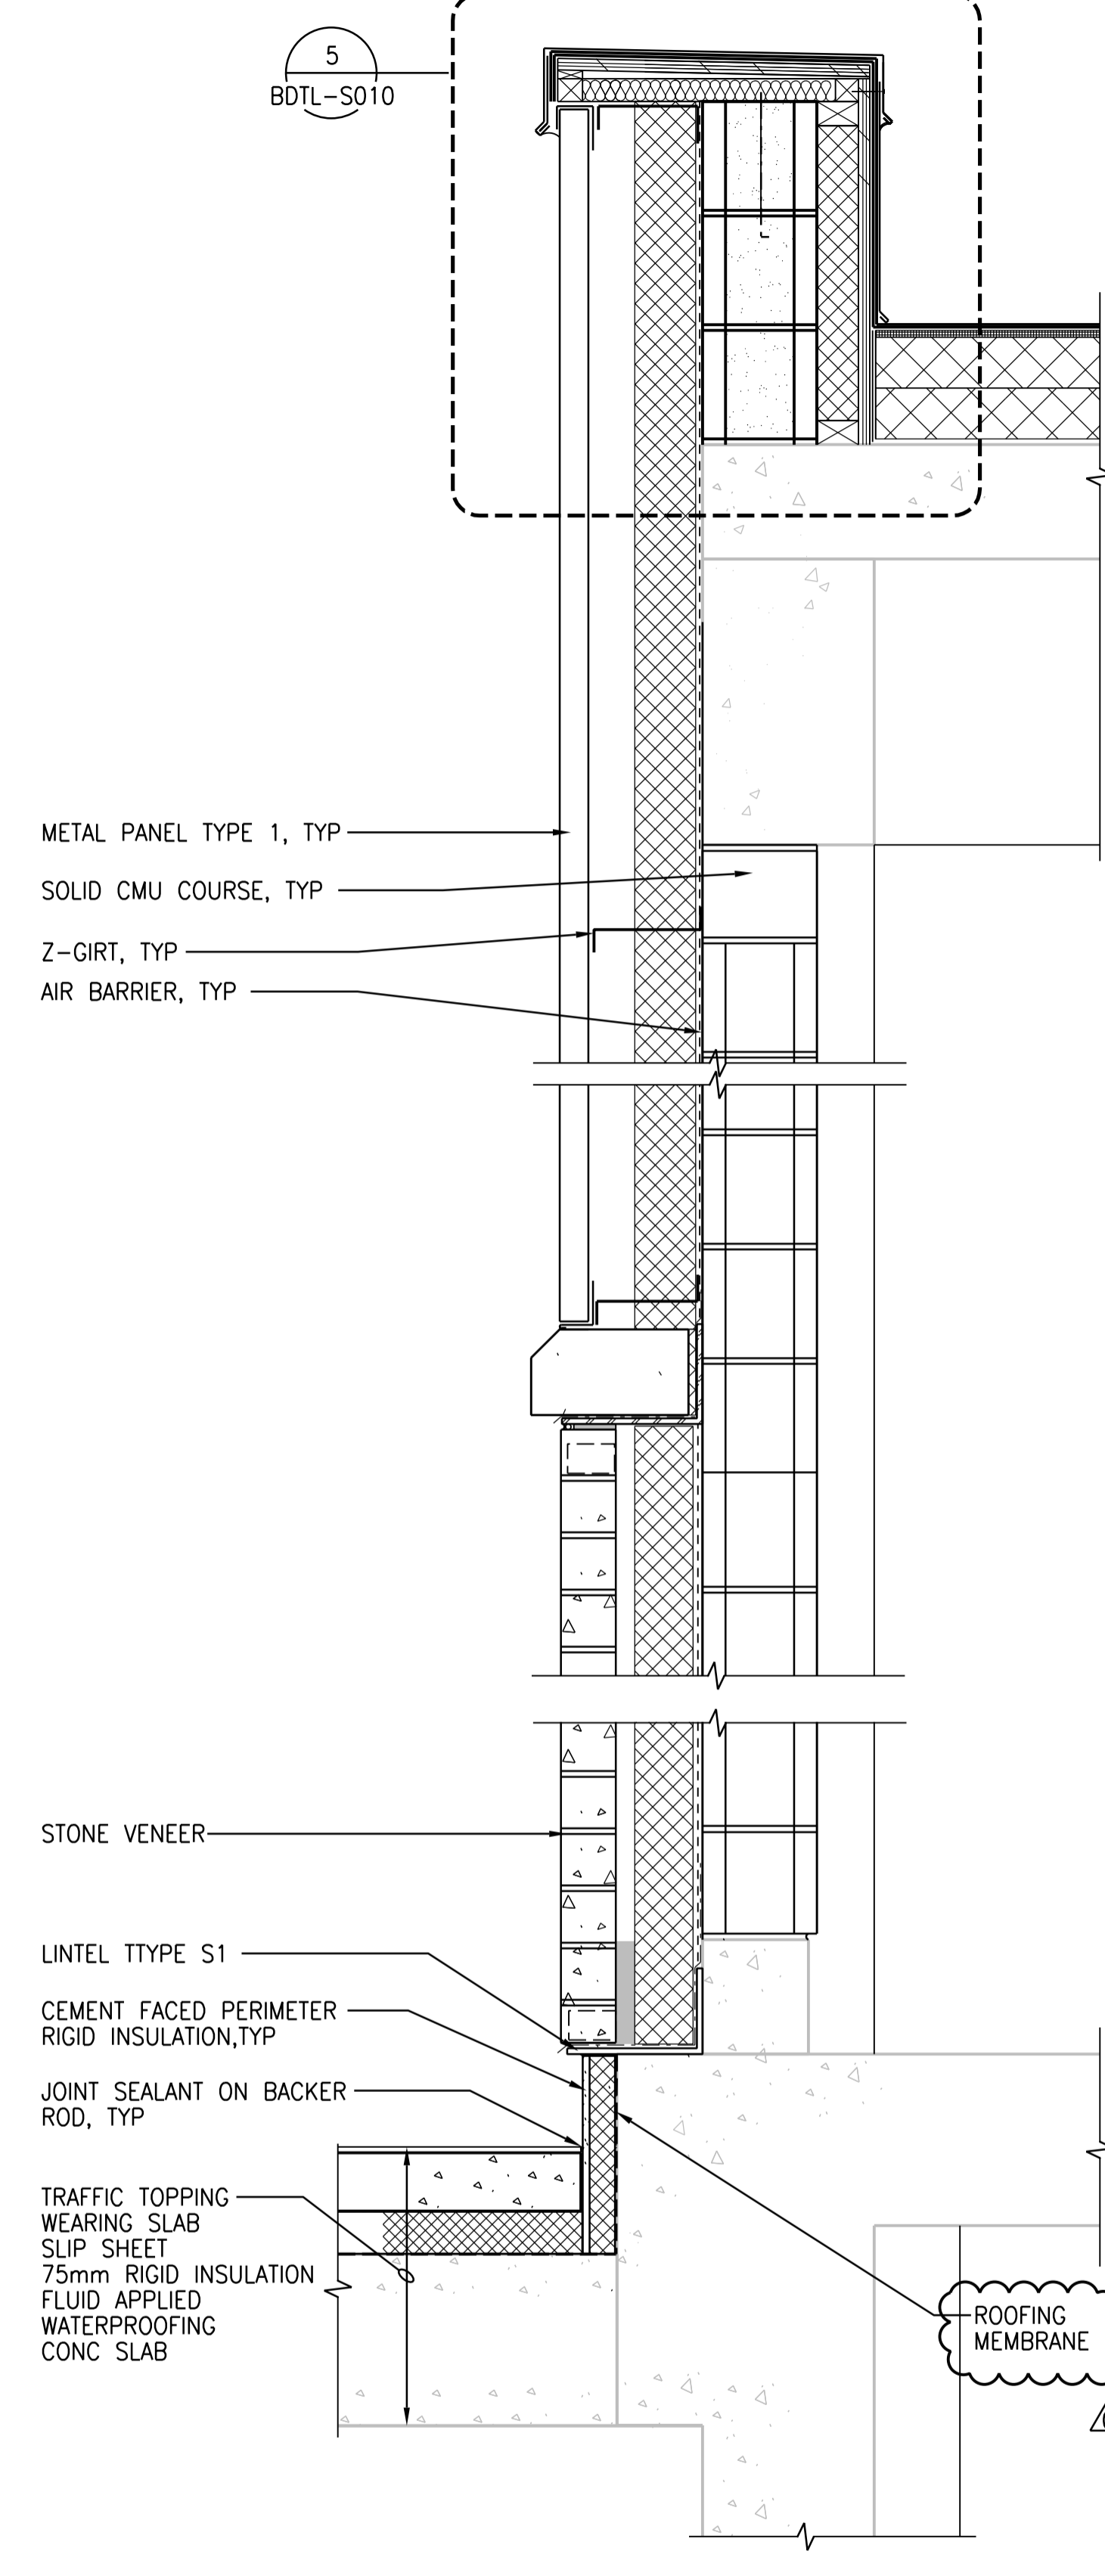

2 WALL SECTION
1:10
BGAD-S015

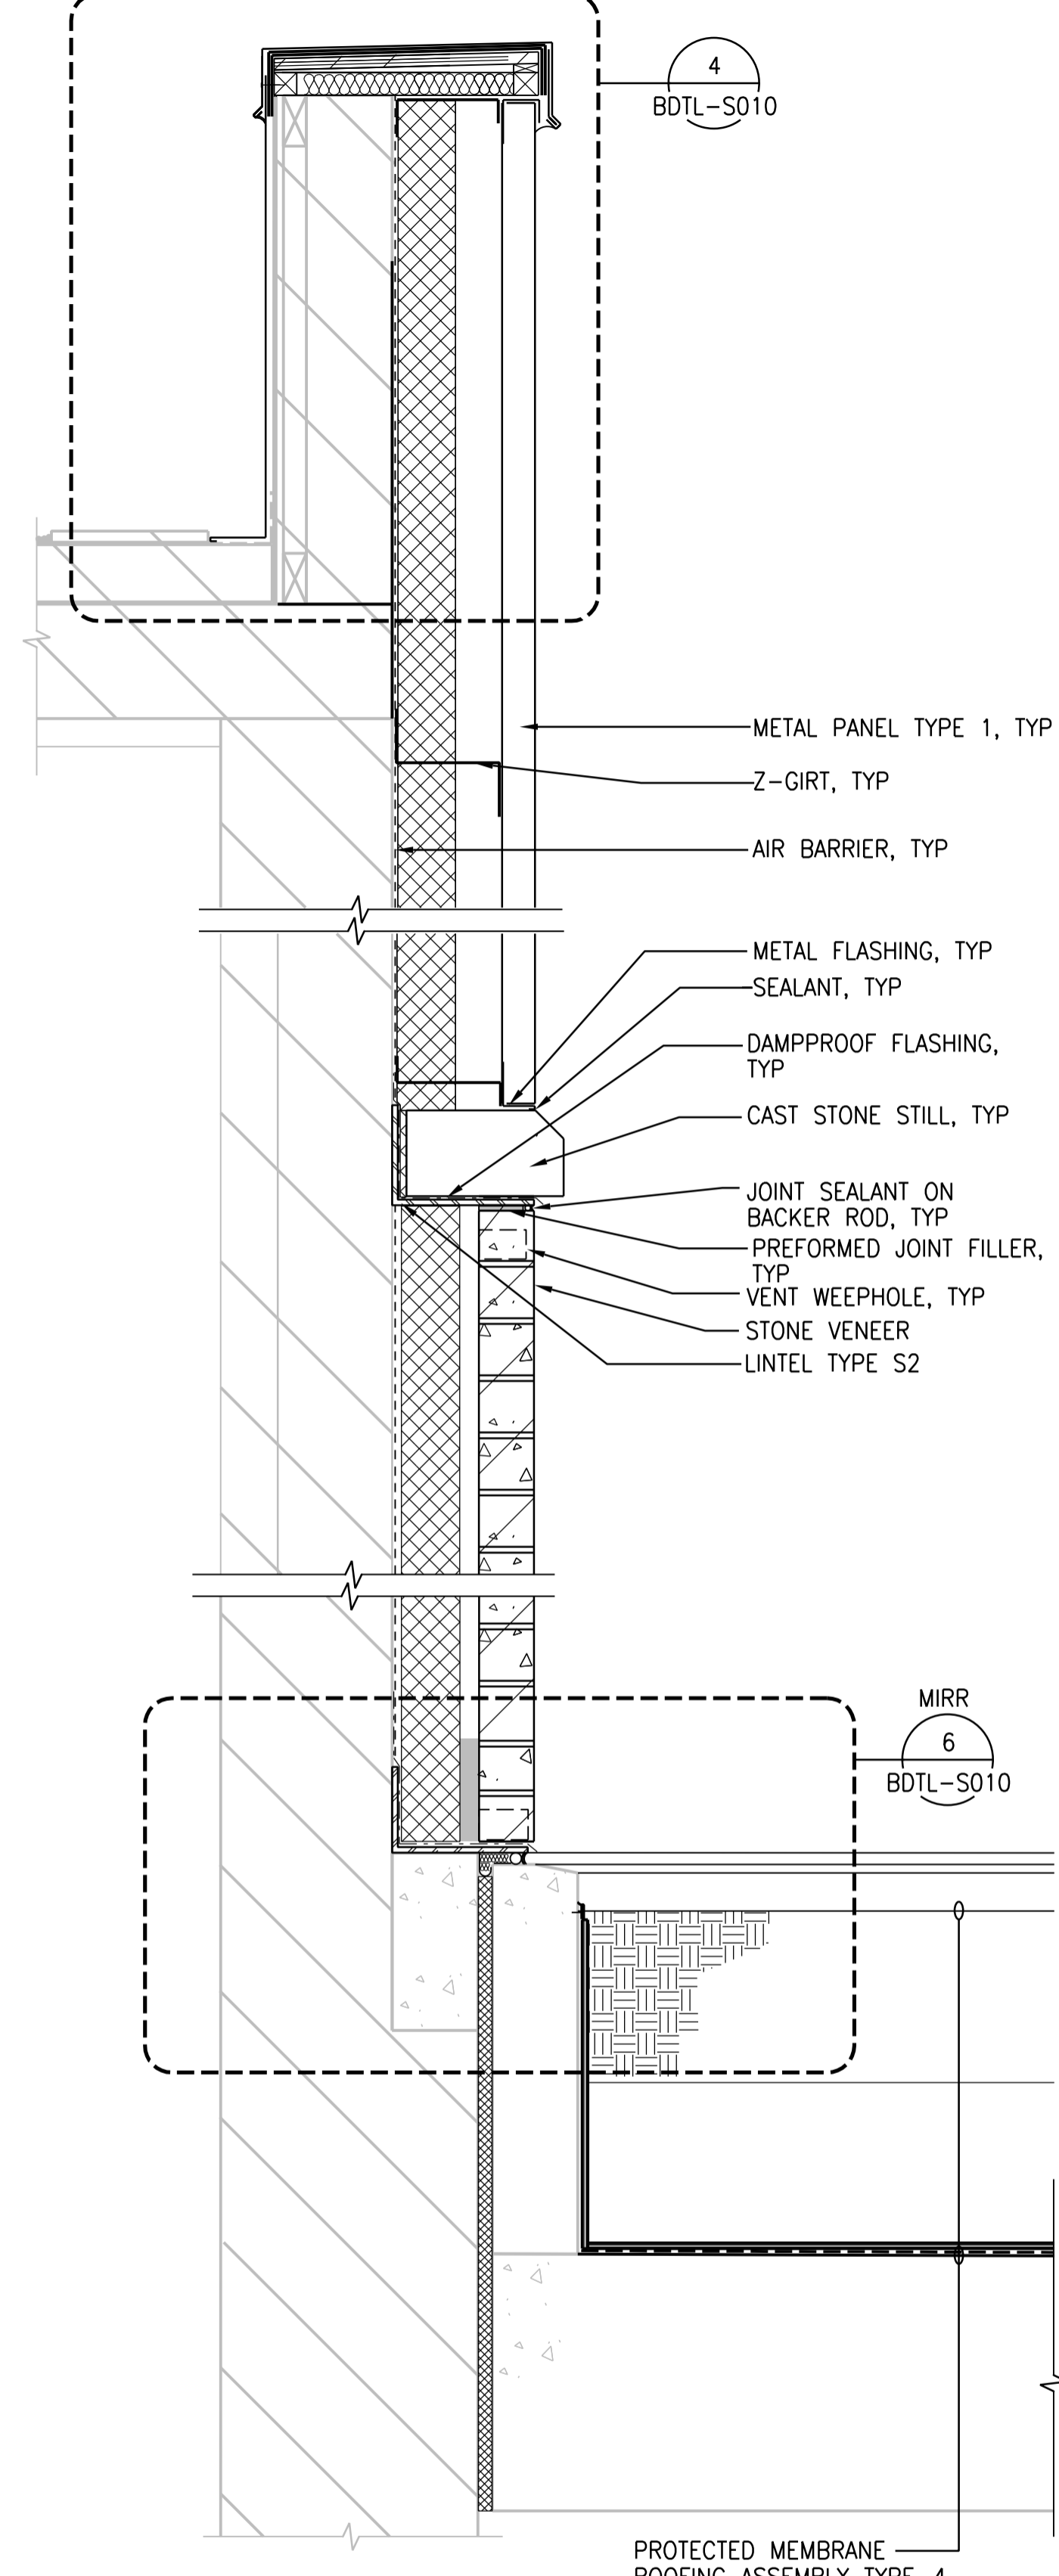


3 WALL SECTION
1:10
BGAD-S011



NO.	REVISIONS	DATE	DESIGN	CHECK
02	ISSUED FOR ADDENDUM 7 - 976-2016	2017/07/21	R.B.	J.C.
01	ISSUED FOR ADDENDUM 5 - 976-2016	2017/07/14	R.B.	J.C.
00	ISSUED FOR CONSTRUCTION - 976-2016	2017/04/05	N.B.	J.C.

CH2MHILL CANADA Architects Inc.	
DESIGNED BY: R. ZAKKO	CHECKED BY: B. KOLIS-HUPA
DRAWN BY: N. BOYCHUK	APPROVED BY: H.T. FREIHAMMER
SCALE: AS SHOWN	ISSUED FOR CONSTRUCTION BY: J. SHUMKA
DATE: 2017/04/05	DATE: 2017/04/05
CONSULTANT NO.: 474248	

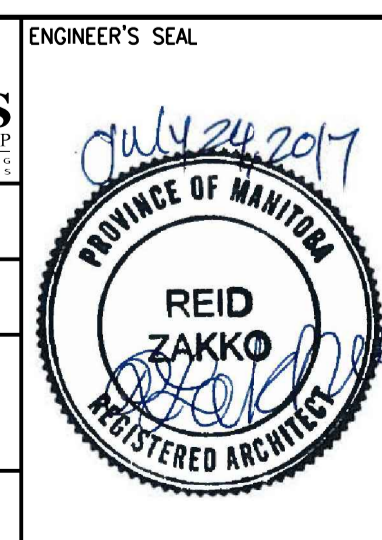

THE CITY OF WINNIPEG
Winnipeg WATER AND WASTE DEPARTMENT

SOUTH END WATER POLLUTION CONTROL CENTRE
SEWPCU UPGRADING/EXPANSION PROJECT
BUILDING
SECONDARY CLARIFIERS 4 AND 5
WALL SECTIONS - PART 5

CITY DRAWING NUMBER: 1-0102-BDTL-S007 | SHEET: 001 | REV: 02 | SIZE: A1