



PLAN, ELEVATIONS AND SECTION

NTS

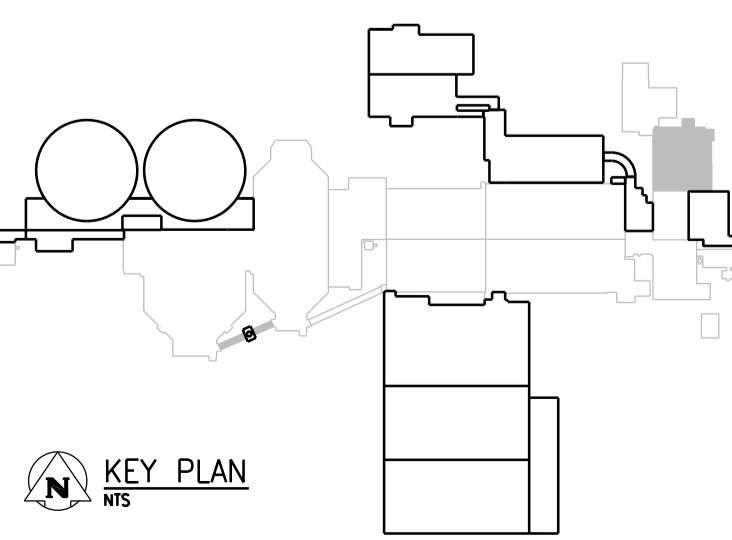

NO.	REVISIONS	DATE	DESIGN	CHECK
02	ISSUED FOR ADDENDUM 8 - 976-2016	2017/07/24	R.B.	J.C.
01	ISSUED FOR ADDENDUM 7 - 976-2016	2017/07/20	JBC	
00	ISSUED FOR CONSTRUCTION - 976-2016	2017/04/05	J.L.	J.C.

CH2MHILL CANADA Architects Inc.	
DESIGNED BY: R. ZAKKO	CHECKED BY: B. KOLIS-HUPA
DRAWN BY: J. LIN	APPROVED BY: H.T. FRIEHAMMER
SCALE: NTS	ISSUED FOR CONSTRUCTION BY: J. SHUMKA
DATE: 2017/04/05	DATE: 2017/04/05
CONSULTANT NO.: 474248	

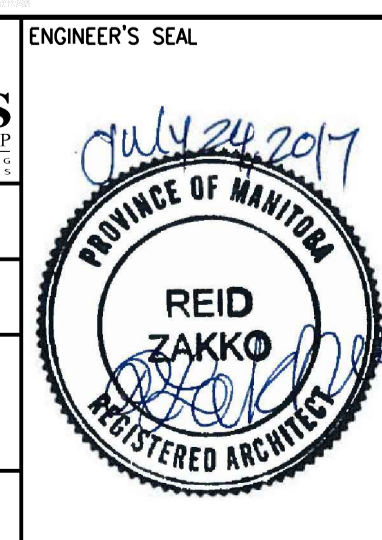

SEALING ARCHITECT OR ENGINEER ACCEPTS RESPONSIBILITY ONLY FOR AREAS IDENTIFIED BY CLOUDING ON THIS DRAWING.

NOTE: THIS DRAWING SUPERSEDES DRAWING SEP-20

THE CITY OF WINNIPEG
Winnipeg WATER AND WASTE DEPARTMENT

SOUTH END WATER POLLUTION CONTROL CENTRE
SEWPPCC UPGRADING/EXPANSION PROJECT
BUILDING
PUMP AND SCREEN BUILDING
GROUND FLOOR PLAN AND ELEVATIONS

CITY DRAWING NUMBER: 1-0102-BGAD-GD51
SHEET: 02
REV: A1
SIZE: A1