






Date  
Sheet no.  
Description  
Project No.  
Address 1277 PACIFIC AVE

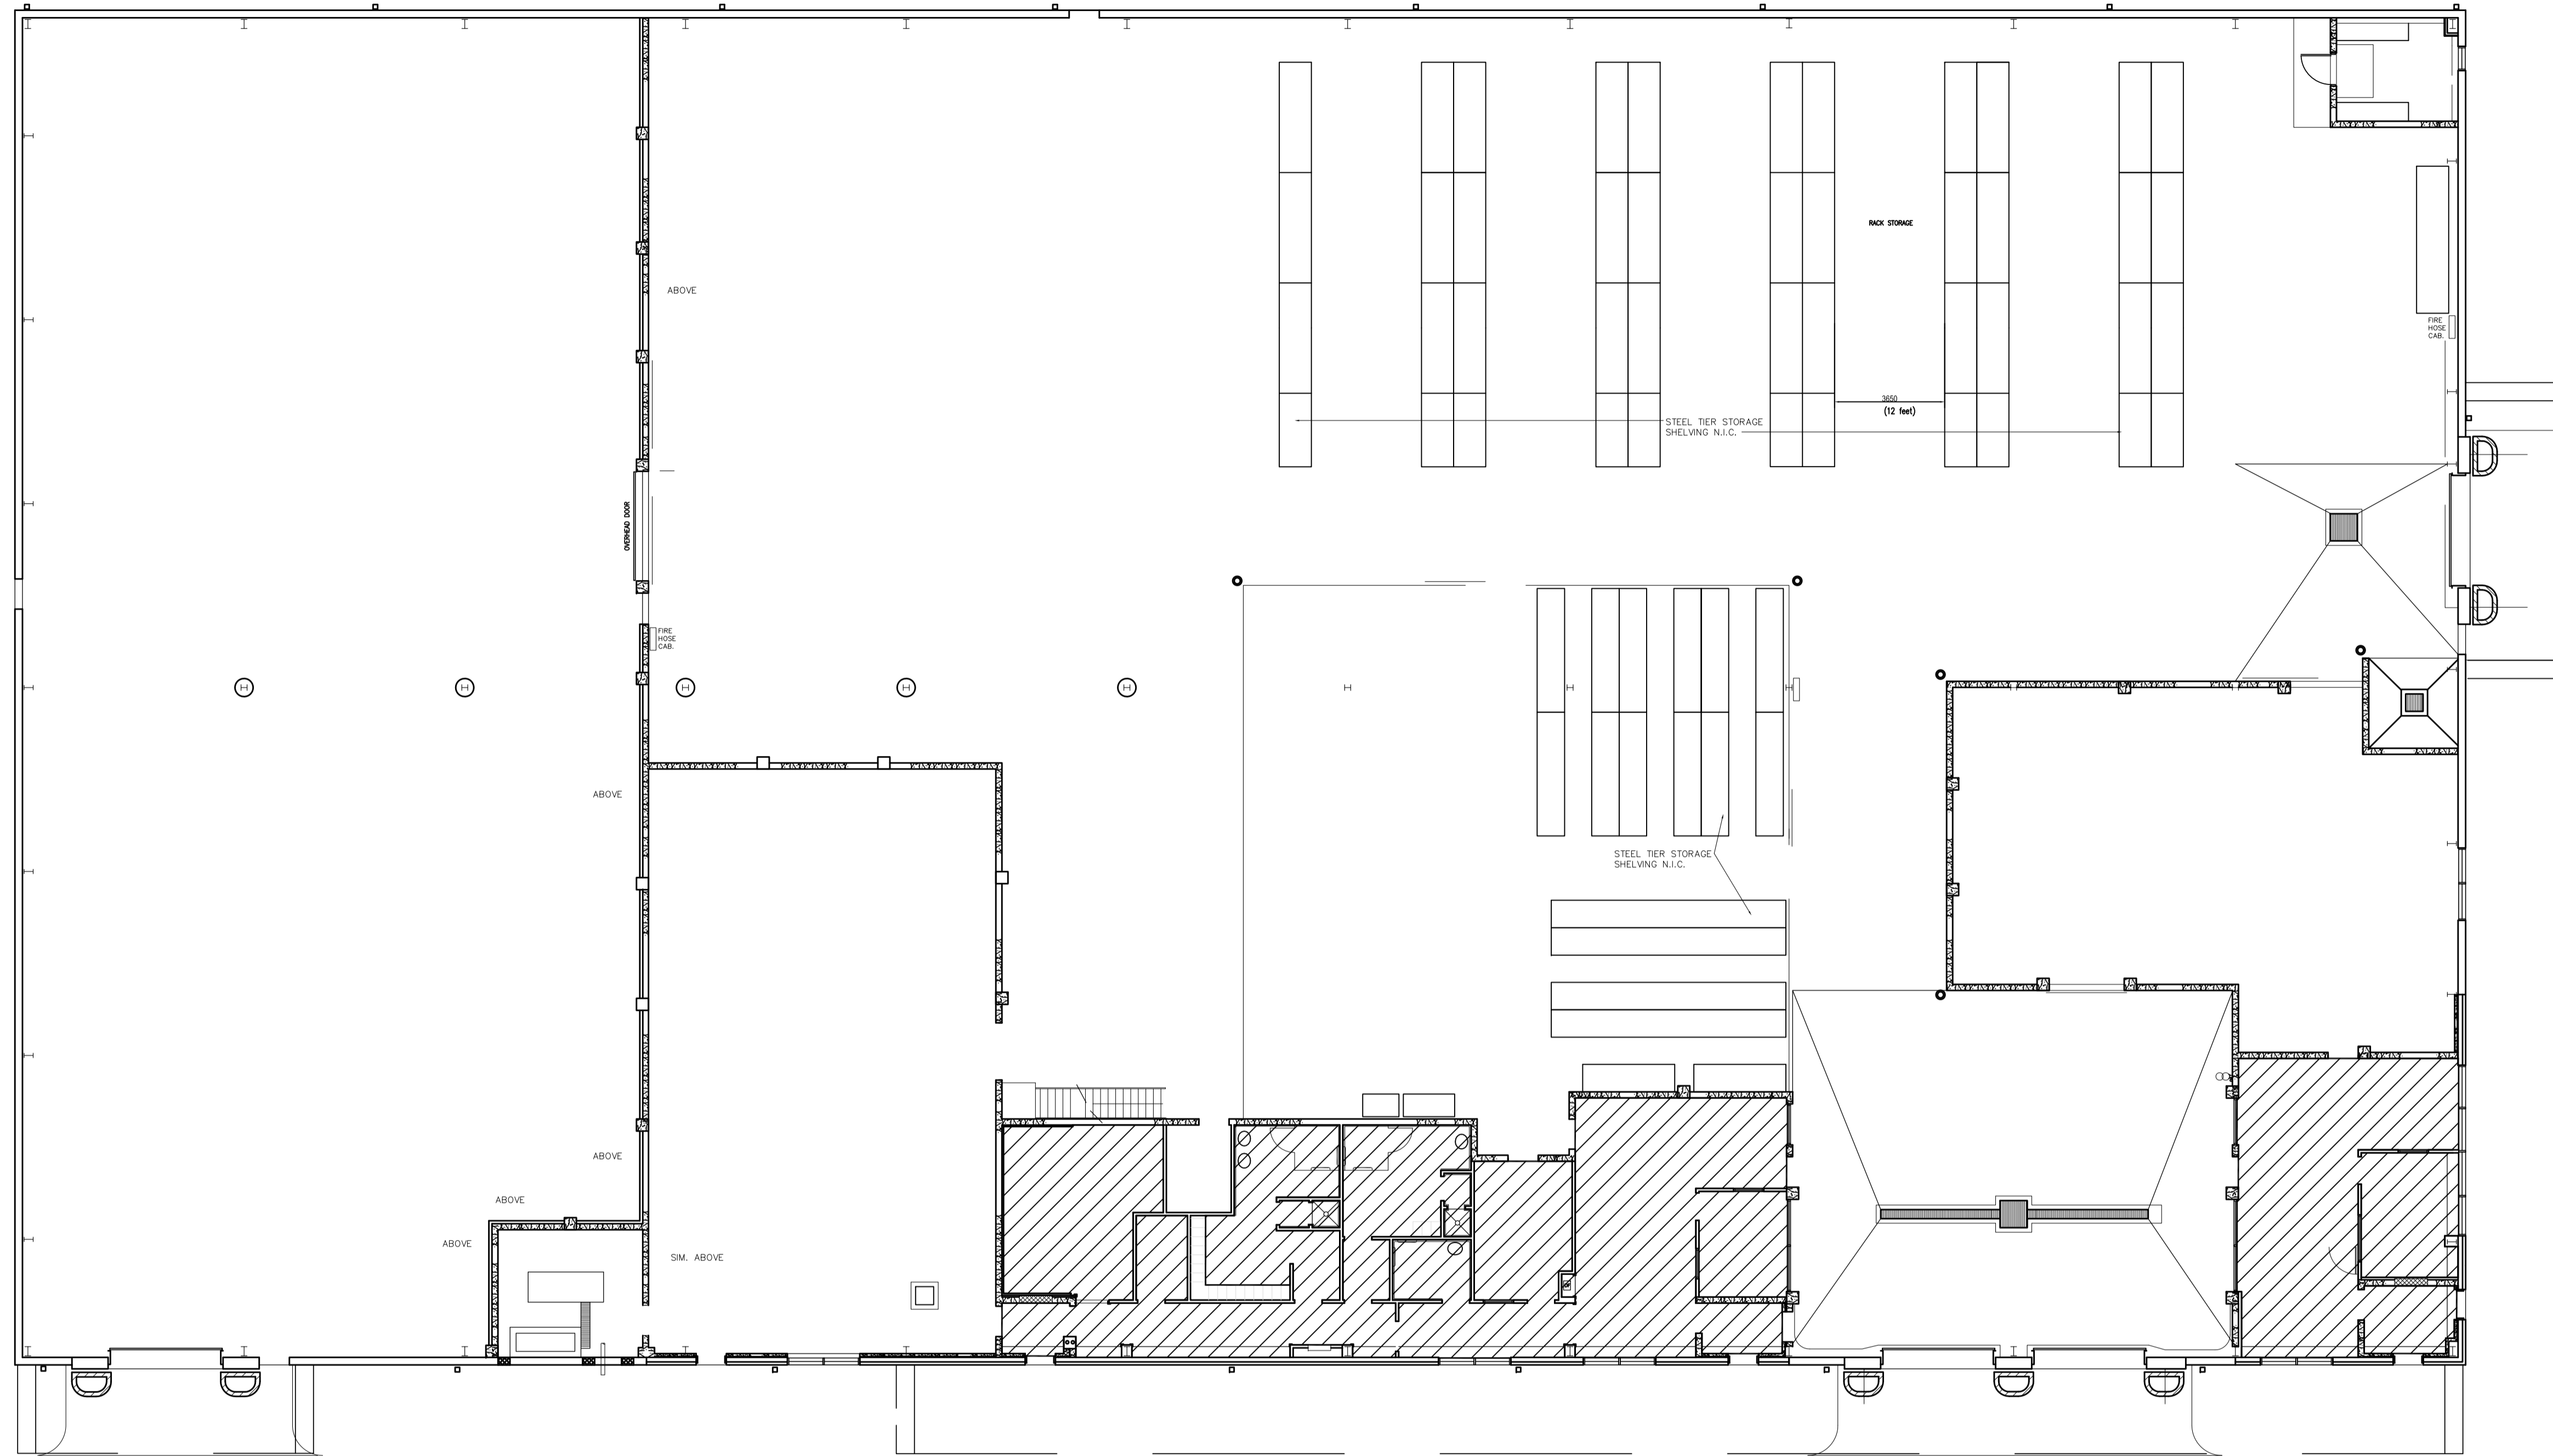

WATER METER REPAIR SHOP  
1277 PACIFIC AVE  
MAIN FLOOR PLAN

AREA TO CLEAN = 2,721 SQ. FT.

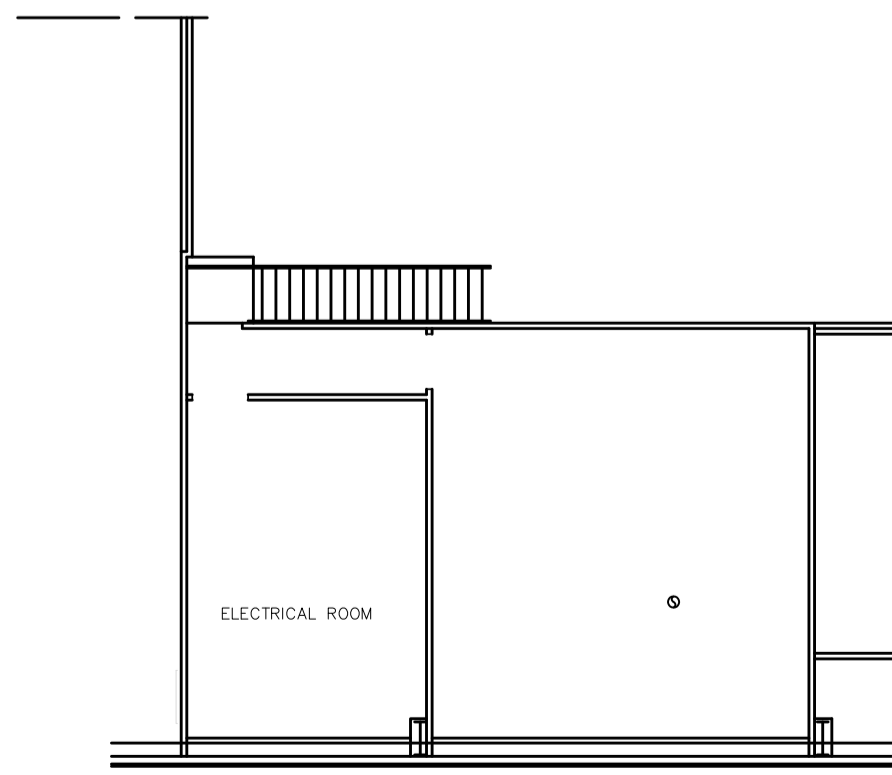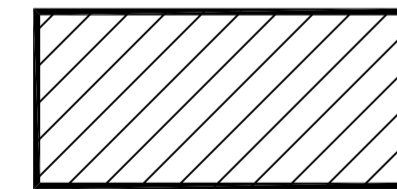

MEZZANINE LEVEL

FLOOR PLAN UPDATED JULY 2003

NO.	REVISION/DESCRIPTION	BY	DATE
SEALS			

DRAWN BY	TC	CHECKED BY	APPROVED
DATE	2010.10.20	USER APPROVAL	

PROJECT

THE CITY OF WINNIPEG  
PLANNING, PROPERTY AND  
DEVELOPMENT DEPARTMENT  
3-65 GARRY STREET  
R3C 4K4

WATER METER REPAIR SHOP  
1277 PACIFIC AVE

SHEET TITLE  
MAIN FLOOR PLAN  
AREAS TO CLEAN

1277PC01

SCALE	BID OPP. #	SHEET NO
NOT TO SCALE	353-2018	A1