



ENTRY LEVEL FLOOR PLAN
1:50

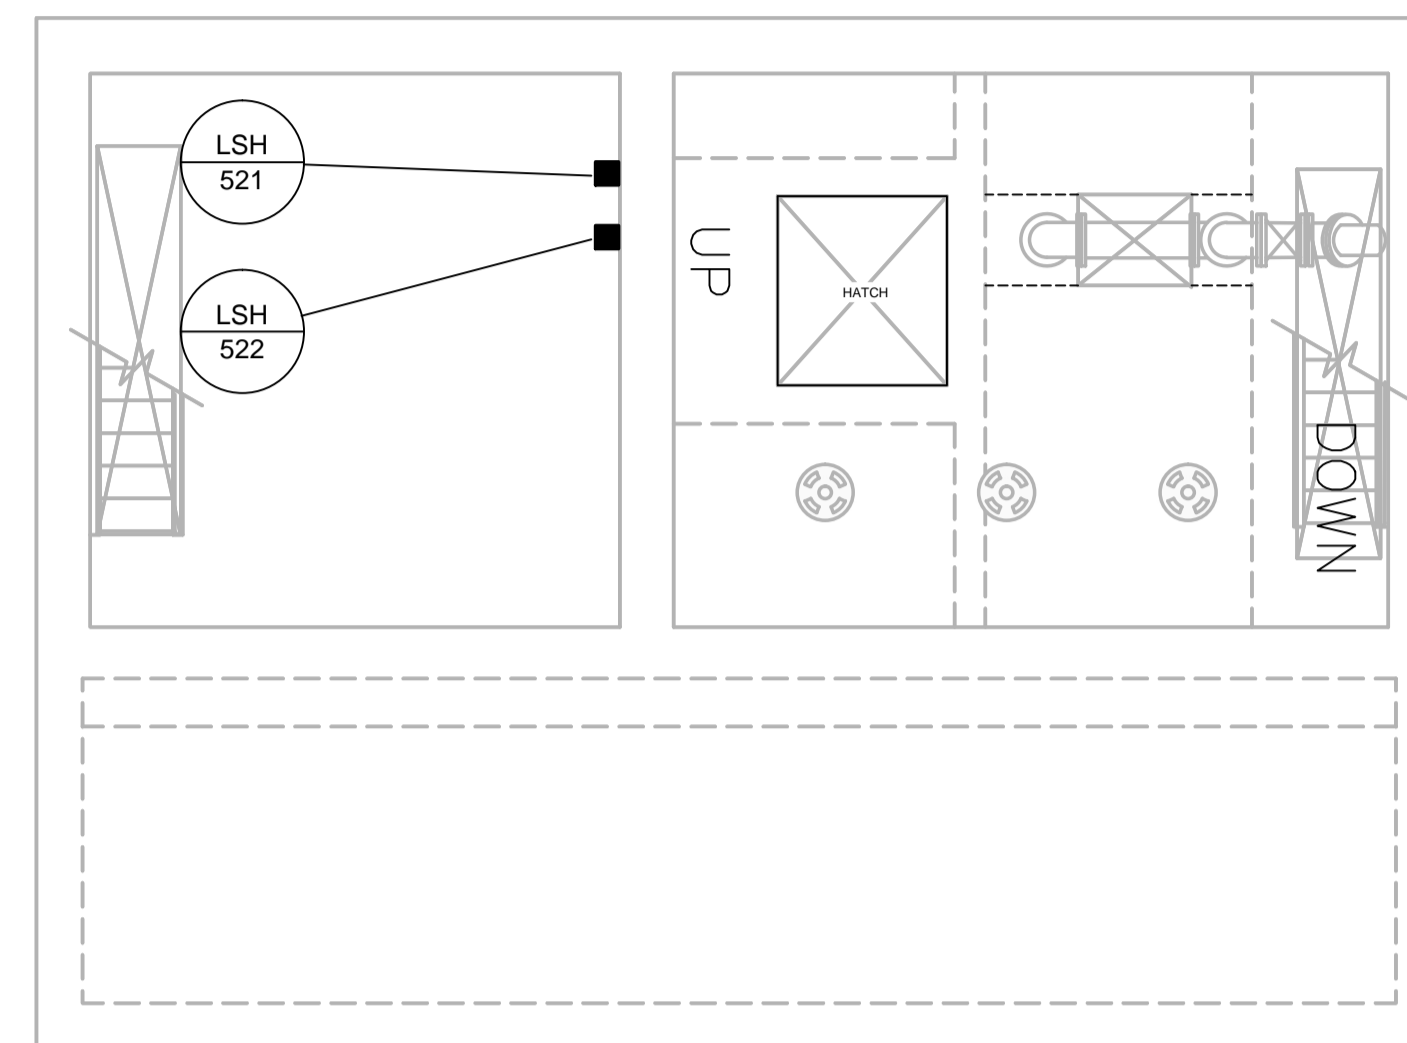

COMM. ROOM, PUMP MOTOR ROOM FLOOR PLAN
1:50

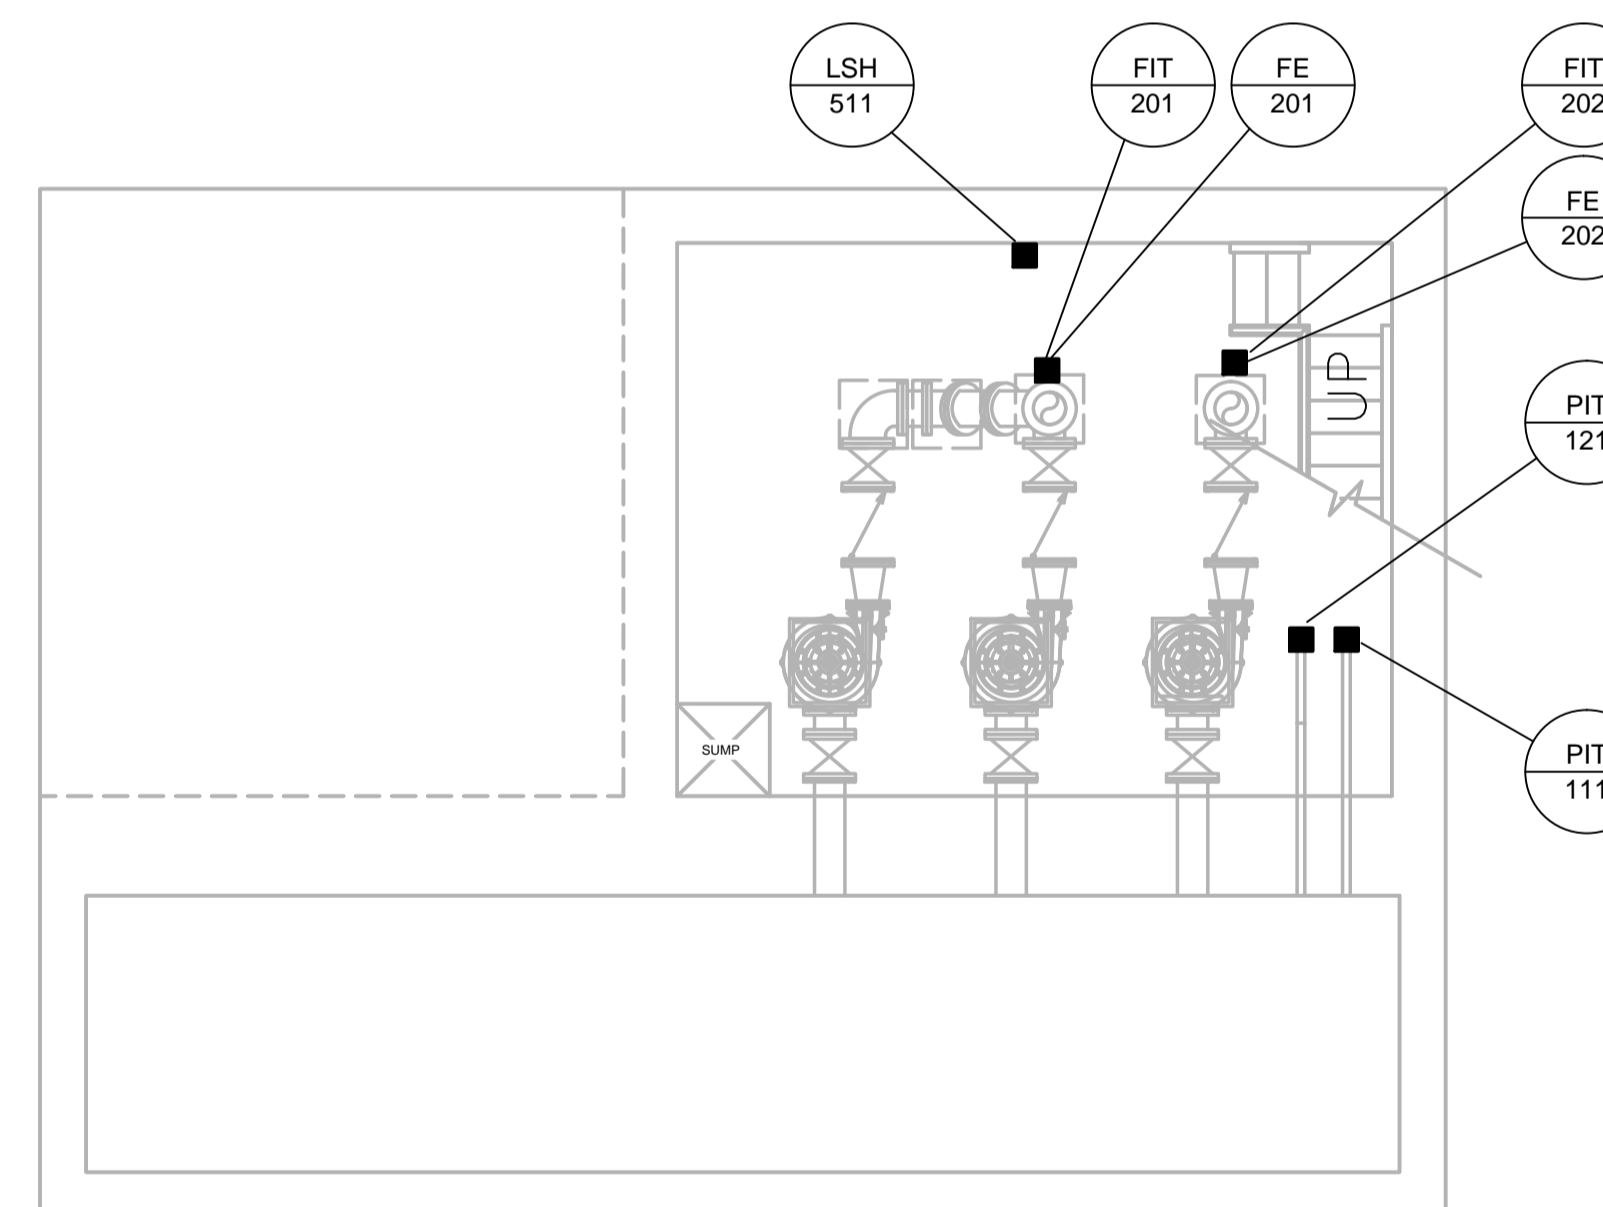

PUMP ROOM FLOOR PLAN
1:50

29 June 2018

186936-E-107.dwg

NOT FOR CONSTRUCTION



NO.	REVISIONS	DATE	BY
0	ISSUED FOR TENDER	06/29/18	BLM

DILLON CONSULTING	
DESIGNED BY B.B.	CHECKED BY B.L.M.
DRAWN BY S.C.K.	APPROVED BY MH
HOR. SCALE AS SHOWN	RELEASED FOR CONSTRUCTION
VERTICAL AS SHOWN	
DATE June 2018	DATE

ENGINEER'S SEAL
CONSULTANT PROJECT NUMBER 18-6936

THE CITY OF WINNIPEG WATER AND WASTE DEPARTMENT	
HAWTHORNE WASTEWATER PUMPING STATION UPGRADES	
ELECTRICAL - INSTRUMENTATION FLOOR PLANS	
CITY DRAWING NUMBER 1-0145L-E0010-001	SHEET 21 OF 21
CONSULTANT DRAWING NUMBER E-07	