




1 FLOOR PLAN
E-01 1:20

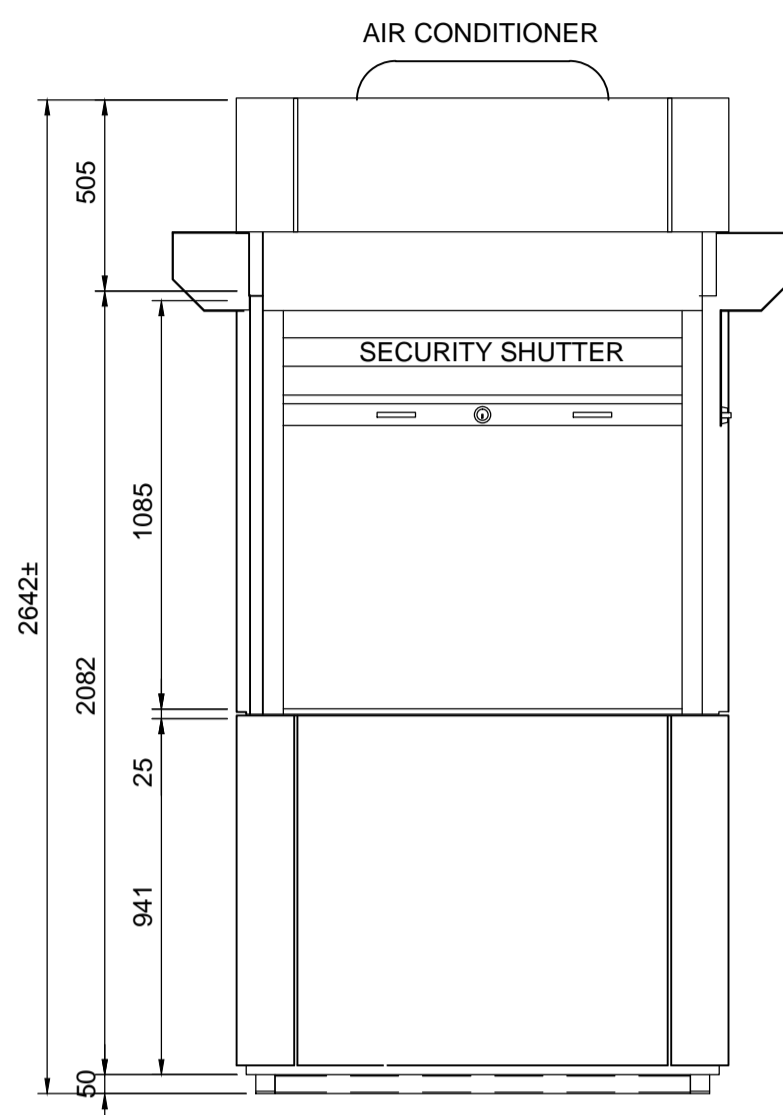


3 ELEVATION
E-01 1:20

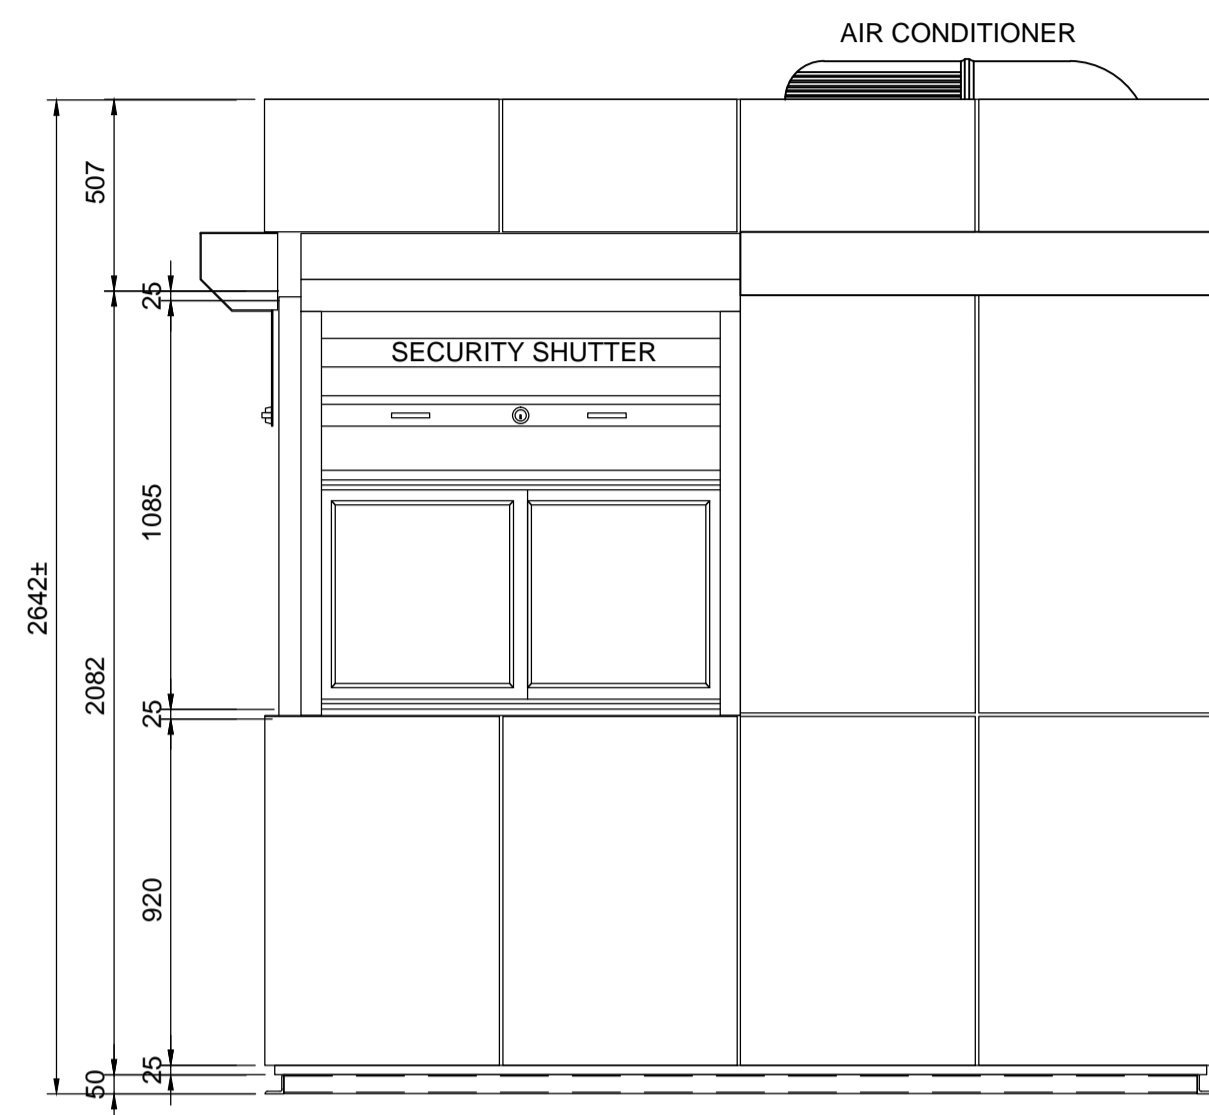

4 ELEVATION
E-01 1:20

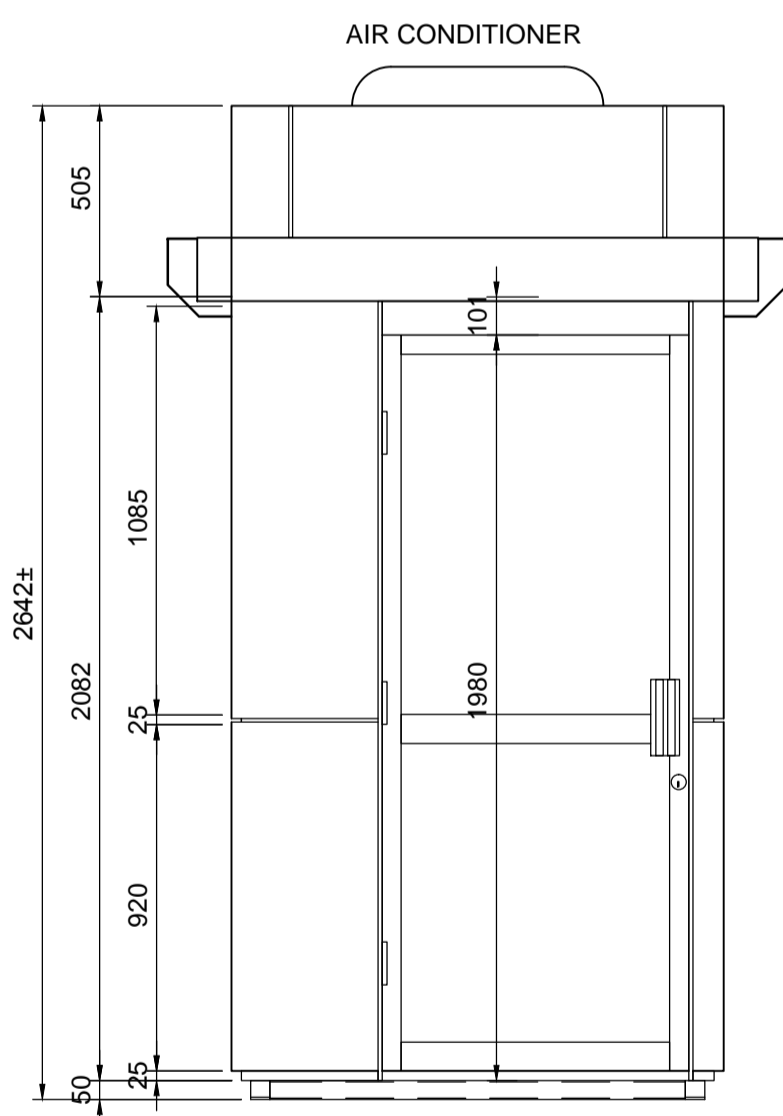

1 ELEVATION
E-01 1:20

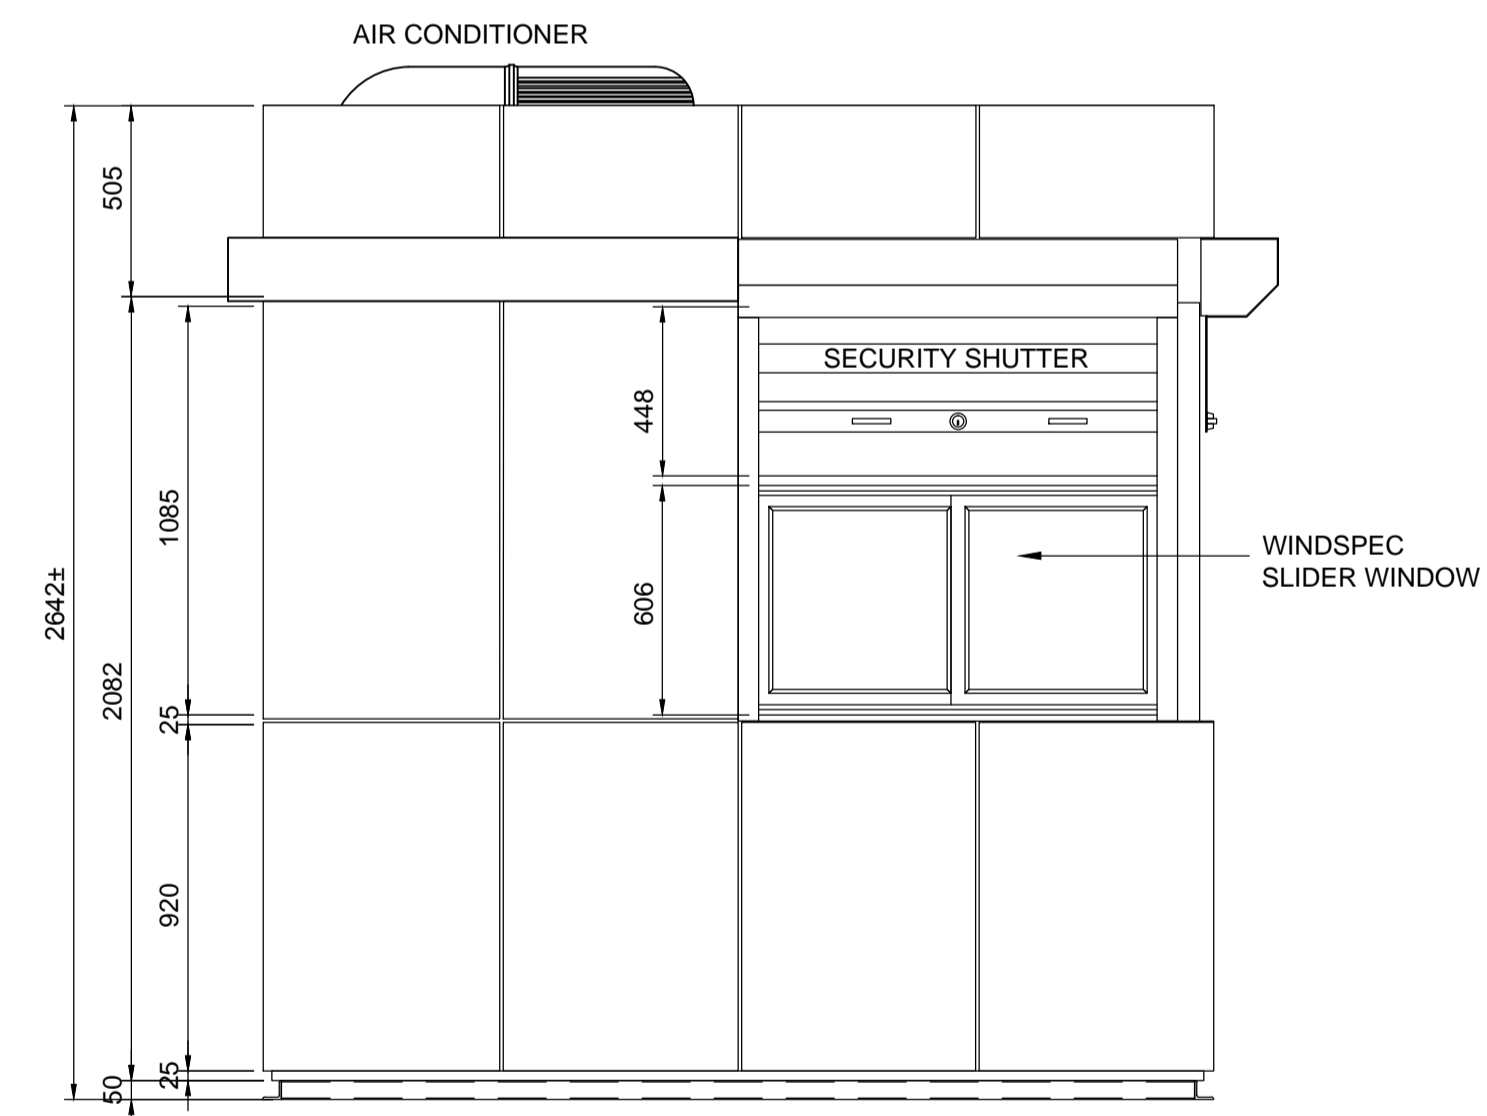

2 ELEVATION
E-01 1:20

DOOR SCHEDULE

HINGED DOOR (1 - LEFT HAND OUTSWING)
 SIZE - 806 x 1937 (31 3/4" X 76 1/4")
 TYPE - COMMERCIAL ALUMINUM DOOR W/ SOLID ALUMINUM PANELS TO MATCH FP1
 FINISH - CLEAR ANODIZED
 HARDWARE:
 PUSH BAR/PULL HANDLE
 3 - 114 (4 1/2") BUTT HINGES
 WEATHERSTRIPPING
 DOOR CLOSER
 DEADBOLT LOCK

ELECTRICAL LEGEND

- (P) 100A, 120/240V, 1Ø, 3 WIRE, 16/32 CCT. ELECTRICAL PANEL C/W 100 AMP MAIN BREAKER
- (H) 4000 WATT FAN FORCED AIR HEATER C/W INTEGRAL THERMOSTAT
- (L) 300 x 1200 RECESSED L.E.D. LIGHT FIXTURE WITH ACRYLIC LENS
- \$ SINGLE POLE LIGHT SWITCH
- Ⓟ DUPLEX RECEPTACLE
- ▨ RACEWAY IN FLOOR FOR INCOMING SERVICES
- (AC) 13500 BTU ROOF TOP AIR CONDITIONER C/W INTEGRAL THERMOSTAT

ELECTRICAL LEGEND

1. ELECTRICAL SITE SERVICE CONNECTION BY OWNER.

METRIC

WHOLE NUMBERS INDICATE MILLIMETRES
 DECIMALIZED NUMBERS INDICATE METRES

B.M. ELEV.		DESIGNED BY BKB		ENGINEER'S SEAL	 Winnipeg Transit Point Patrol Kiosks		
		DRAWN BY SCK		RELEASED FOR CONSTRUCTION NOT FOR CONSTRUCTION	CONSULTANT PROJECT NUMBER 187412	CITY DRAWING NUMBER XXXXXX SHEET 1 OF 1	
		CHECKED BY BLM			GENERAL ARRANGEMENT	CONSULTANT DRAWING NUMBER E-01	
		APPROVED BY MH					
A ISSUED FOR 99% REVIEW 11/05/18 BLM		HOR. SCALE AS SHOWN	VERTICAL -				
NO. REVISIONS		DATE	BY	DATE			