




1 ELECTRICAL SITE PLAN
SCALE: 1:100

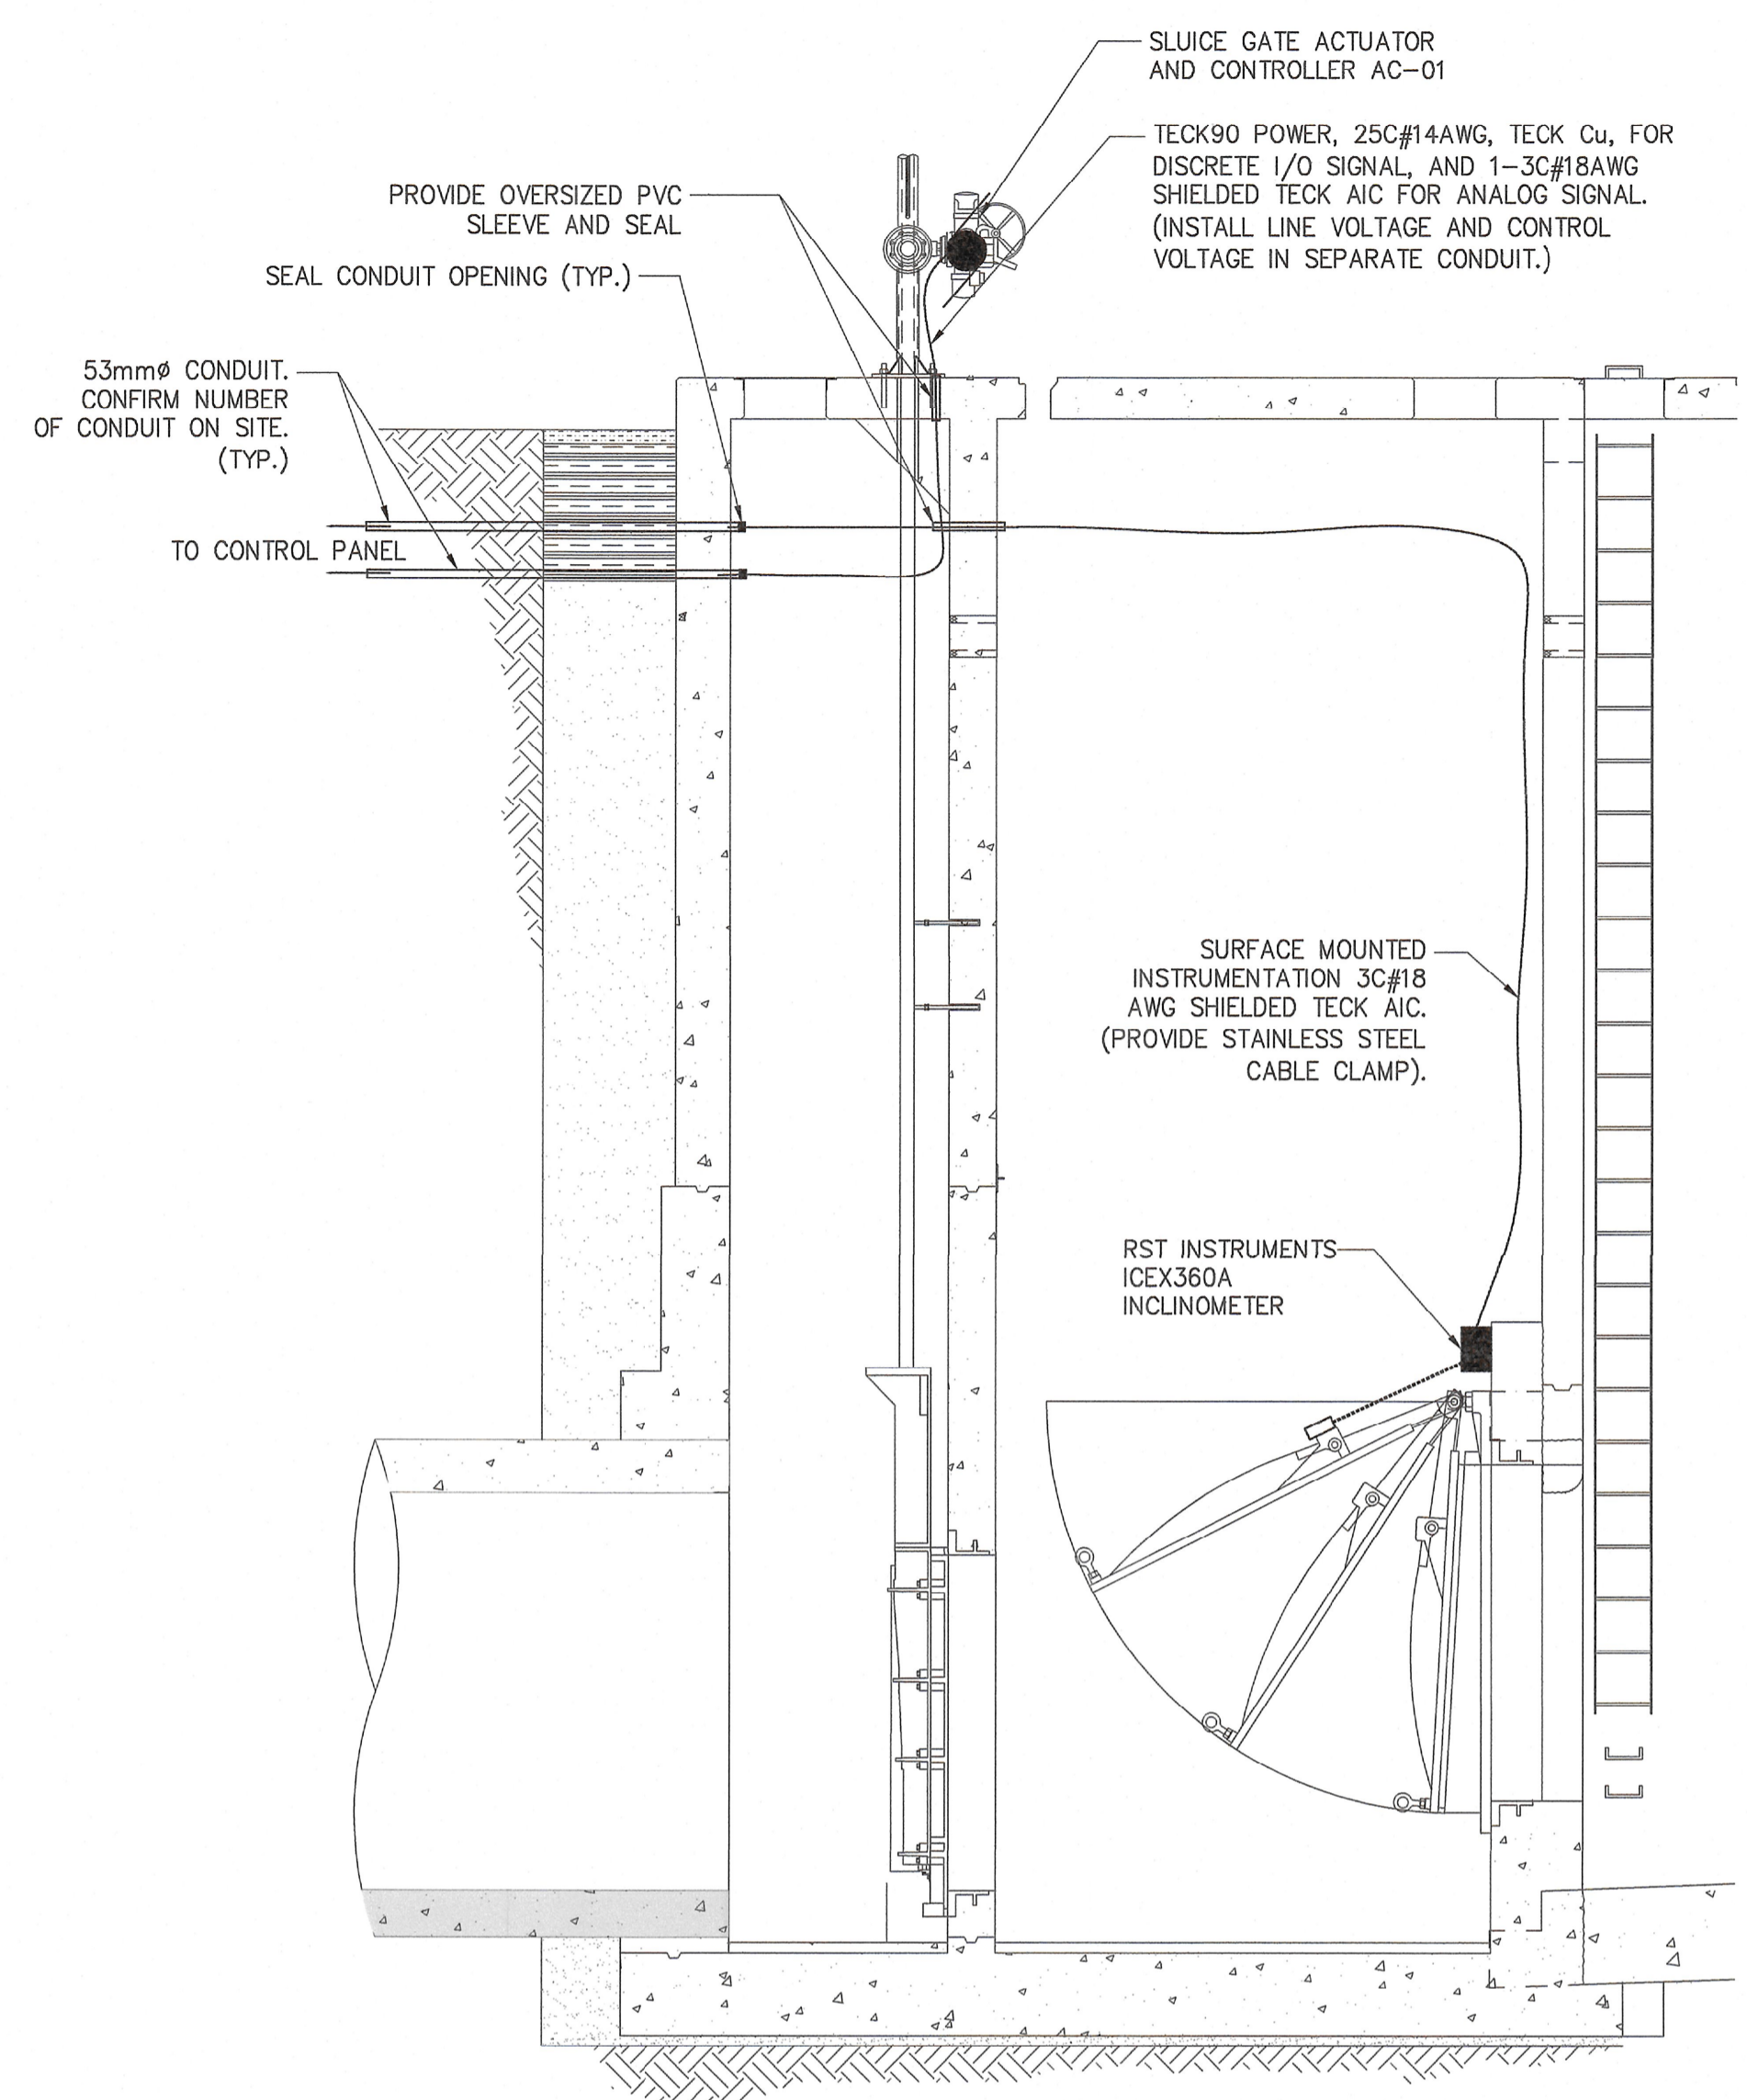

3 GATE CHAMBER
SCALE: NTS

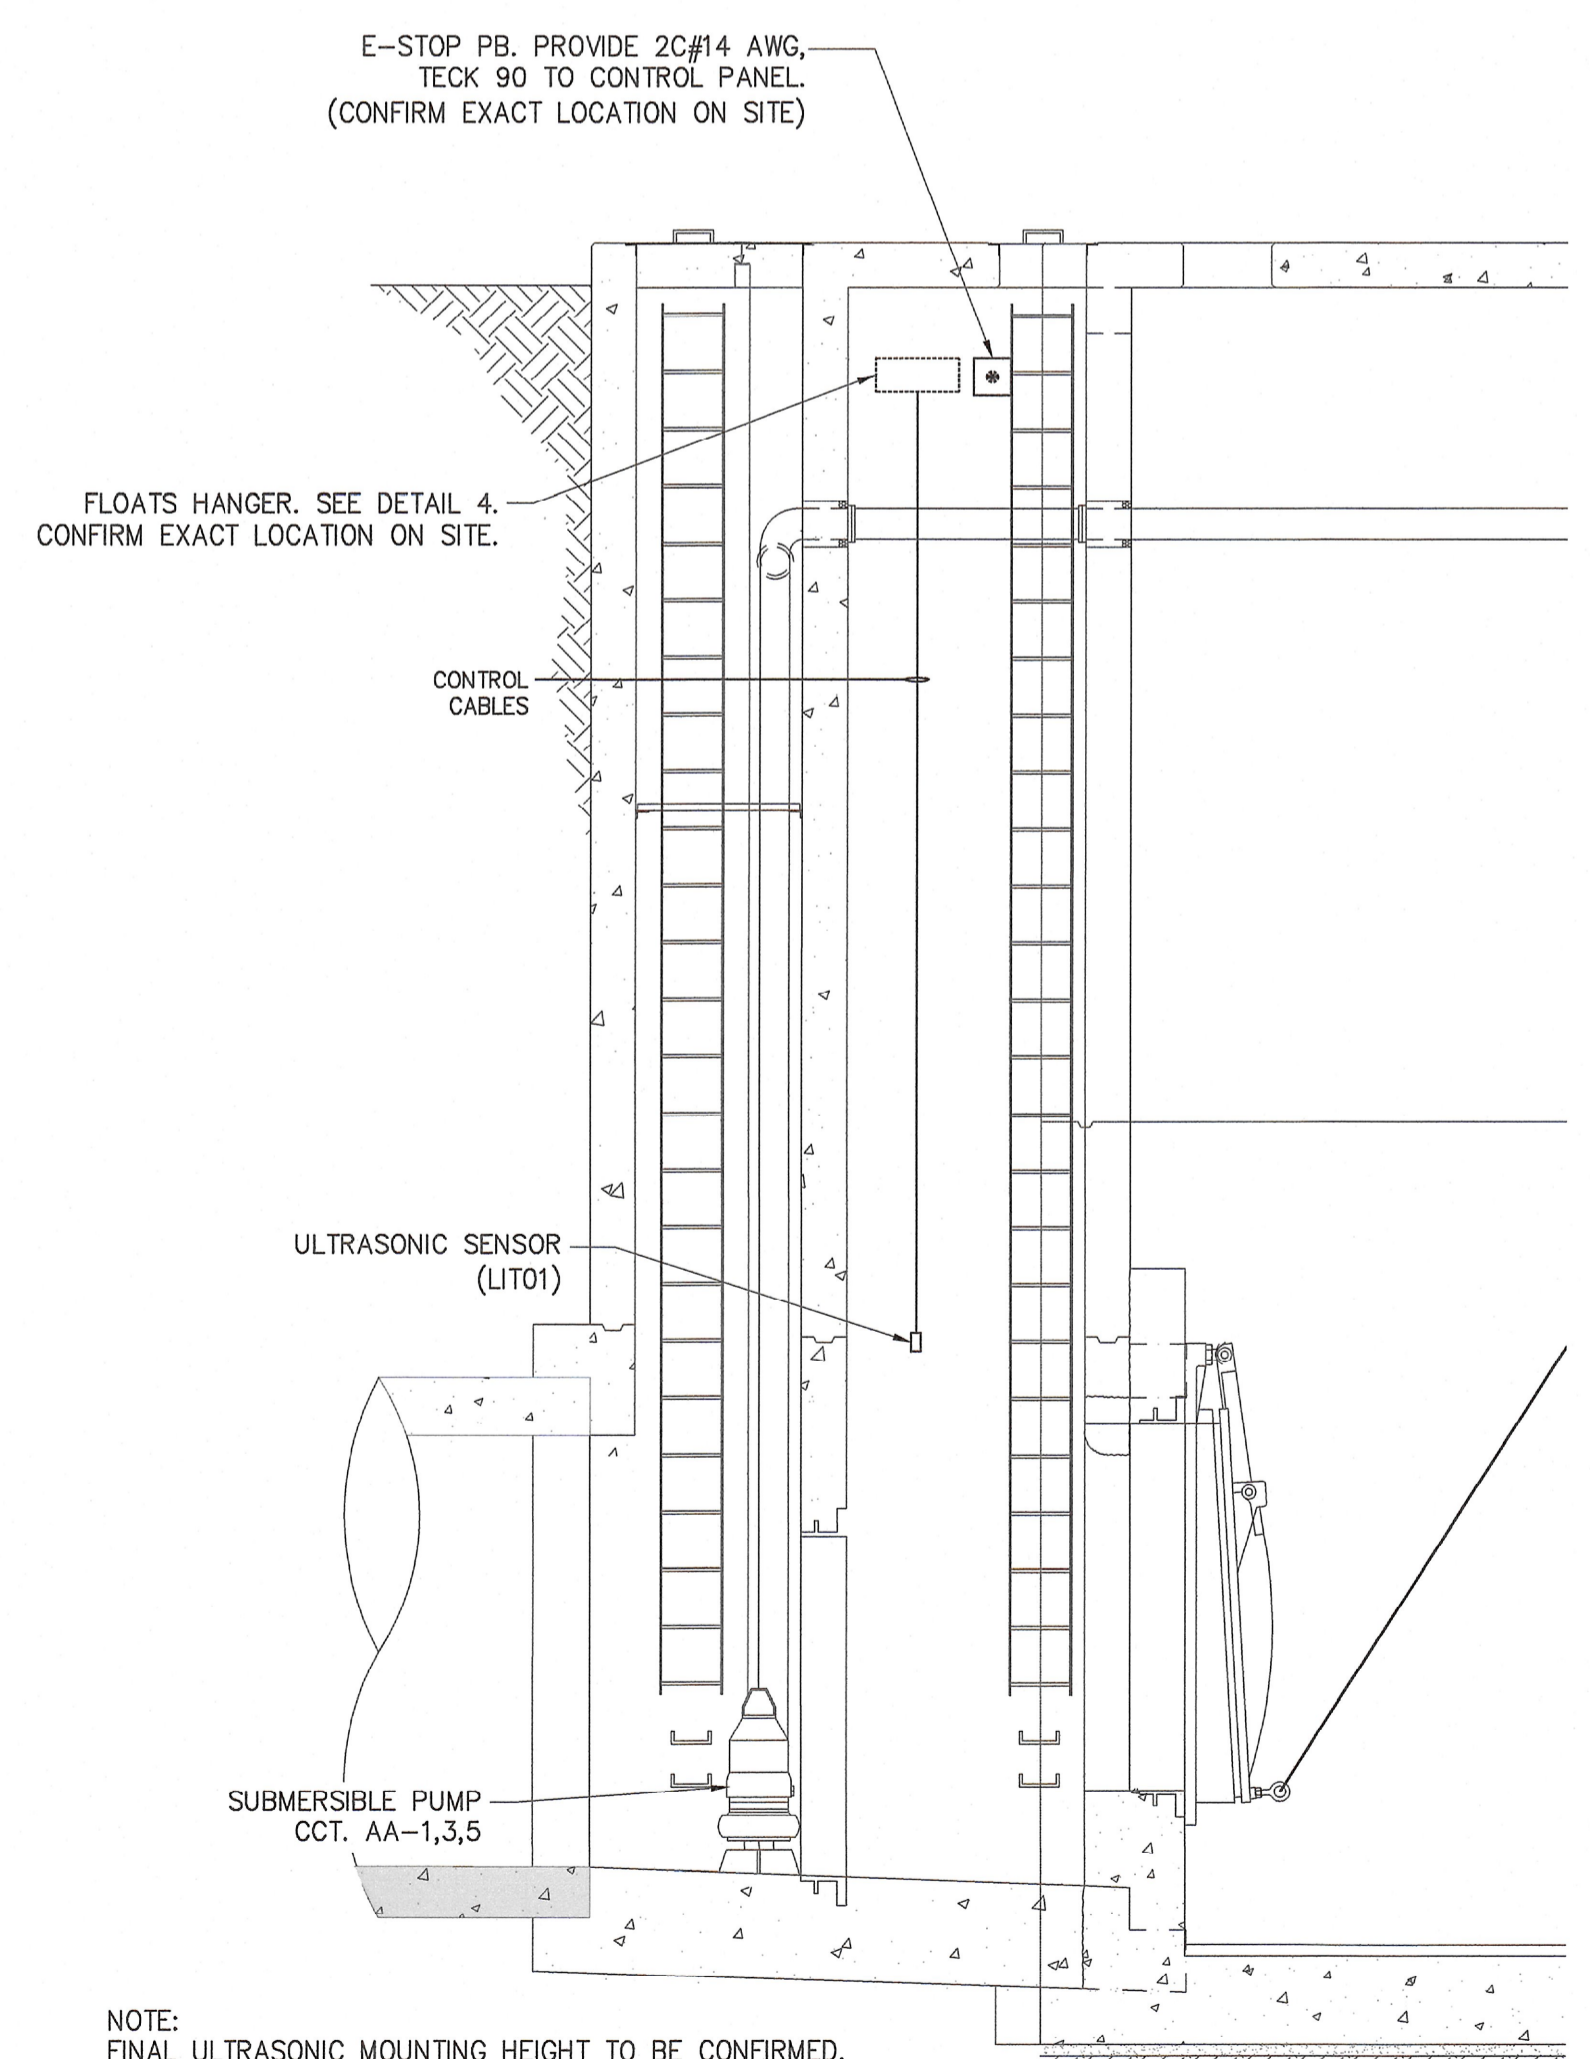


2 SUBMERSIBLE PUMP CHAMBER
SCALE: NTS

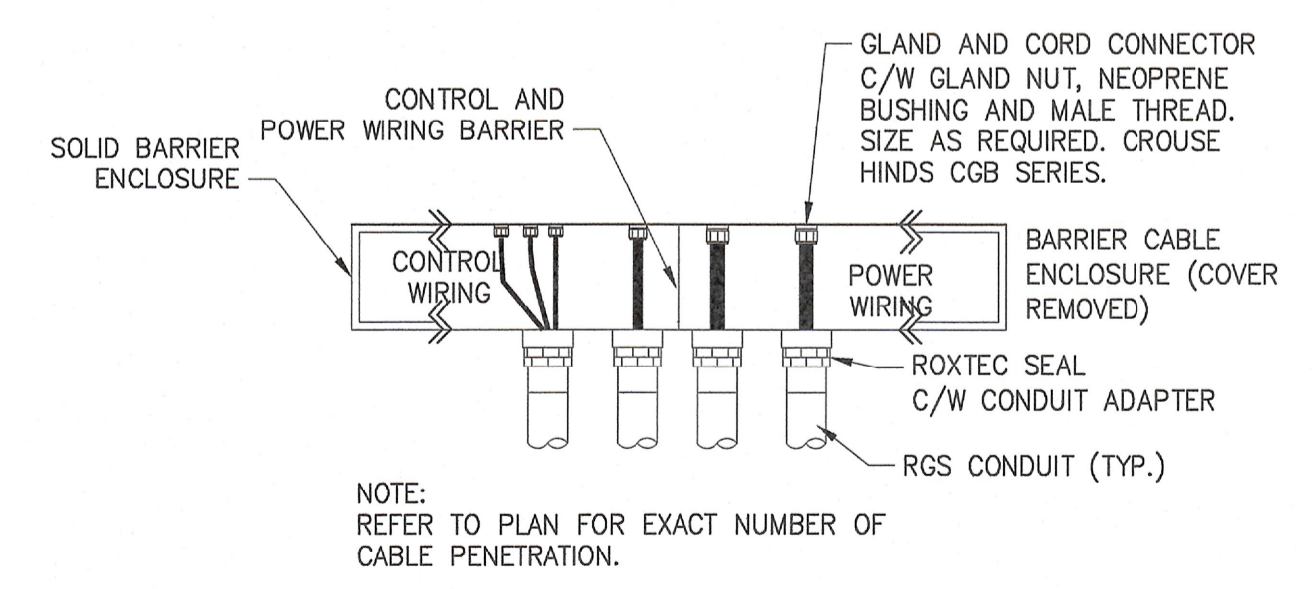

4 WIRING TO CONTROL PANEL (TYP.)
SCALE: NTS



G.R.M.					
ELEV.					
DESIGNED BY	AE	CHECKED BY	ES		
DRAWN BY	AE	APPROVED BY	ES		
3 ISSUED FOR TENDER	14/09/18	ES			
2 ISSUED FOR REVIEW	15/08/18	ES			
1 ISSUED FOR REVIEW	12/12/16	HP			
NO. REVISIONS	DATE	BY	DATE	DATE	

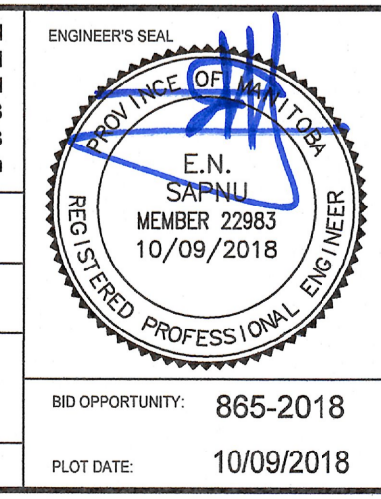

THE CITY OF WINNIPEG
WATER AND WASTE DEPARTMENT

OUTFALL GATE CHAMBER UPGRADES
AUBREY STREET
SRS OUTFALL GATE CHAMBER

ELECTRICAL SITE PLAN
AND CHAMBER DETAILS

CONSULTANT DRAWING NUMBER: 5516047 - E02
SHEET OF: 13 OF 33
CITY DRAWING NUMBER: LD-8025

NO. OPPORTUNITY: 865-2018
PLOT DATE: 10/09/2018

Sep 10, 2018 9:45am
 L:\Projects\2018\1811-2317-00 raby & aubrey st. outfall upgrades (r.m.)\03 - shop\02 working ena\08 Elec\UBREY\sheet\02.dwg - tab E-2

NOTE: These design documents are prepared solely for the use by the party with whom the design professional has entered into a contract and there are no representations of any kind made by the design professional to any party with whom the design professional has not entered into a contract.