


1 MAIN FLOOR PLAN - TRACK 13-24 - DEMOLITION - VENTILATION  
M1.4 SCALE: 1/8" = 1'-0"

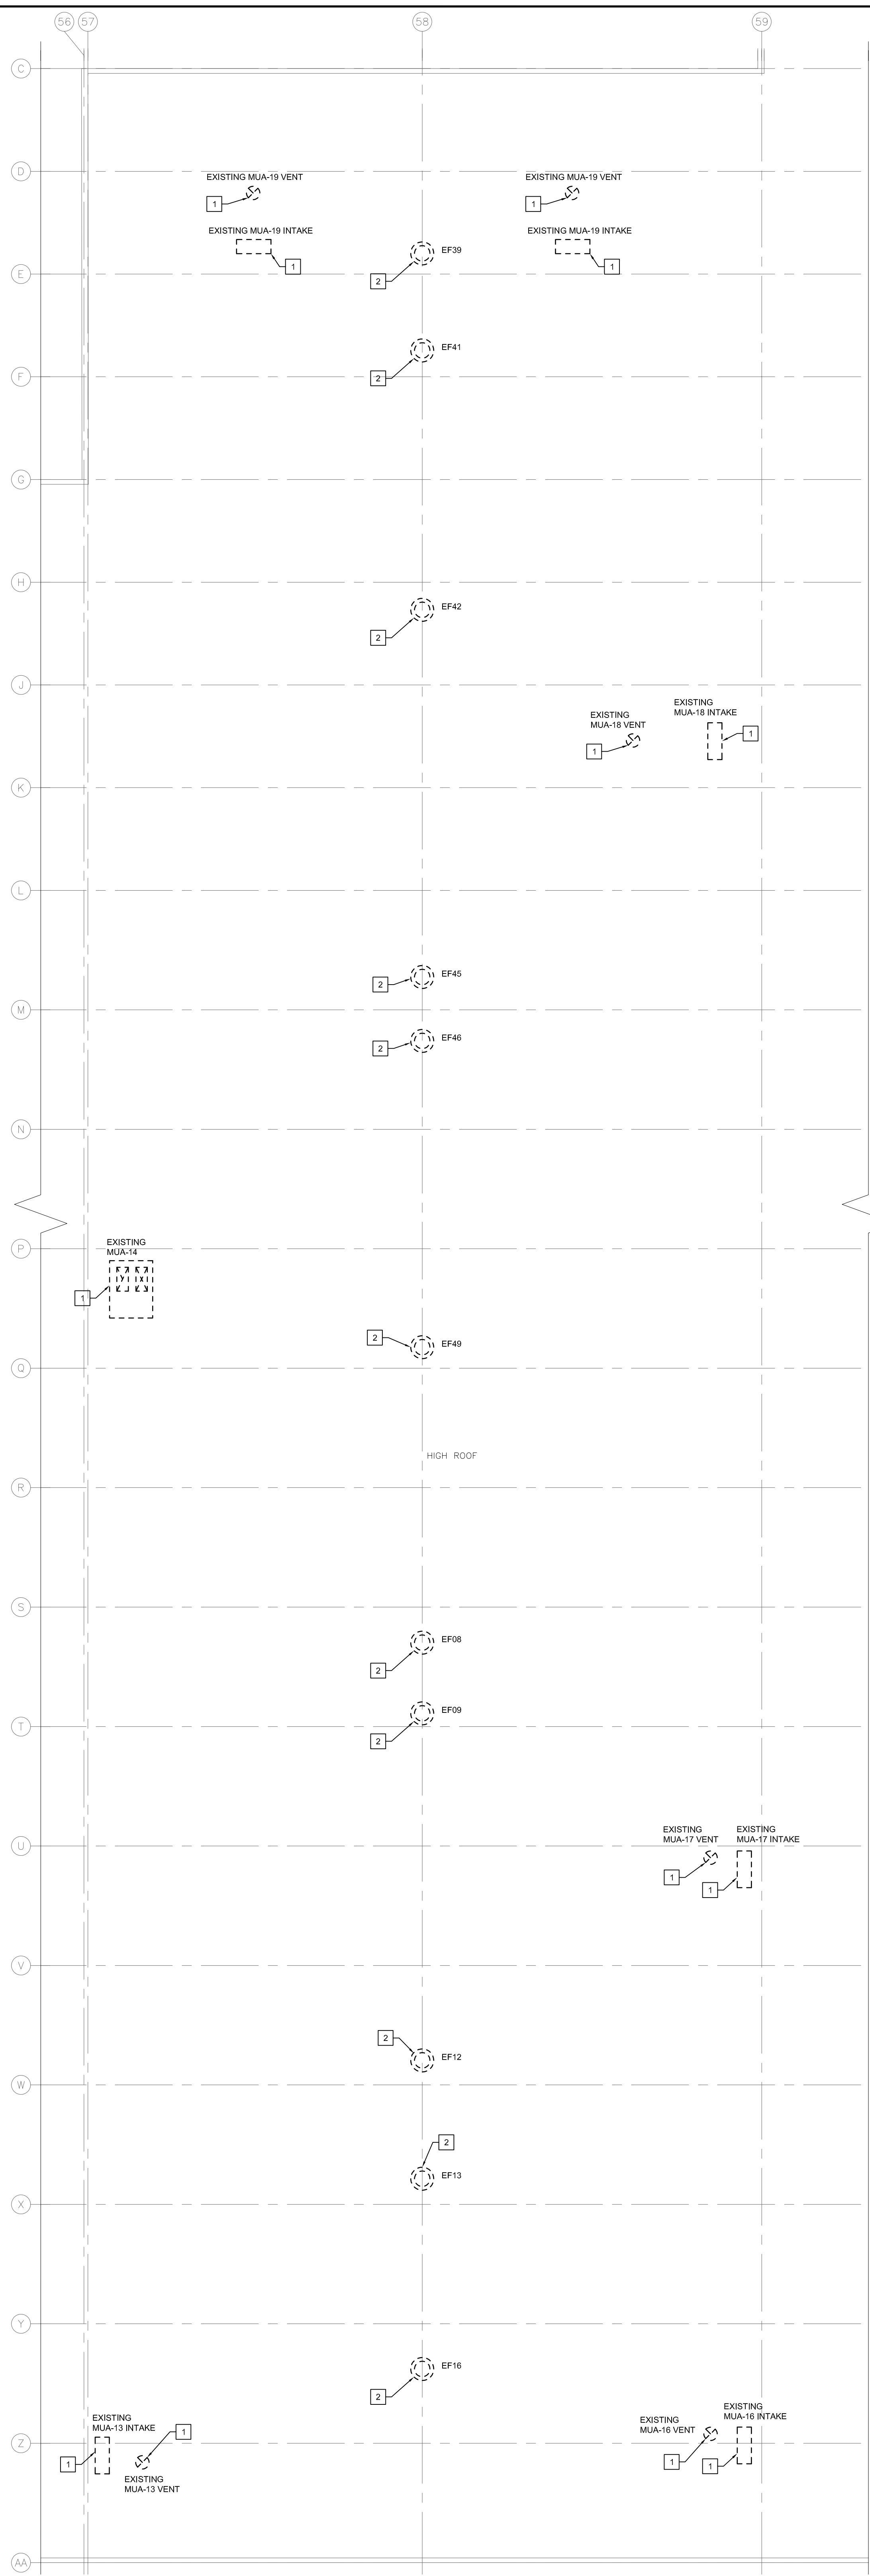


2 ROOF PLAN - TRACK 13-24 - DEMOLITION - VENTILATION  
M1.4 SCALE: 1/8" = 1'-0"

**GENERAL NOTES**

- A. ALL ABANDONED EQUIPMENT AND SERVICES WITHIN AREA OF WORK SHALL BE REMOVED.
- B. THIS BUILDING MAY CONTAIN ASBESTOS. REFER TO FRONT END SPECIFICATIONS FOR FURTHER INFORMATION.
- C. REFER TO ROOF DETAILS AND SPECIFICATIONS FOR ALL NEW AND CAPPED OPENINGS.

**DEMOLITION KEY NOTES**

1. DEMOLISH AND REMOVE EXISTING MUAs AND ASSOCIATED DUCTWORK, VENTING AND INTAKES. REPAIR AND SEAL ROOF OPENING (REFER TO STRUCTURAL AND ROOFING SPECIFICATION DETAILS). REMOVE EXISTING CONTROLLERS AND RETURN TO OWNER FOR SPARES. REMOVE DEMOLISHED UNITS FROM BAS.
2. DEMOLISH AND REMOVE EXISTING EXHAUST FANS. REPAIR AND SEAL ROOF OPENING (REFER TO STRUCTURAL AND ROOFING SPECIFICATION DETAILS). REMOVE DEMOLISHED FAN FROM BAS.
3. DEMOLISH AND REMOVE EXISTING GRILLES AND DUCTWORK.
4. REMOVE EXISTING GRILLES AND DAMPERS AND CAP OFF OPENING. EXISTING DUCTWORK TO REMAIN.
5. REFER TO STRUCTURAL FOR DETAIL FOR INFILLING EXISTING OPENING IN BLOCK WALL TO MAINTAIN FIRE RATINGS.
6. EXISTING ABANDONED UNDERFLOOR VENTILATION SYSTEM CURB TO BE REMOVED. REFER TO STRUCTURAL.
7. EXISTING SUPPLY FAN TO REMAIN.
8. EXISTING FIRE DAMPER TO REMAIN.
9. EXISTING ABANDONED UNDERFLOOR VENTILATION SYSTEM CURB TO REMAIN.

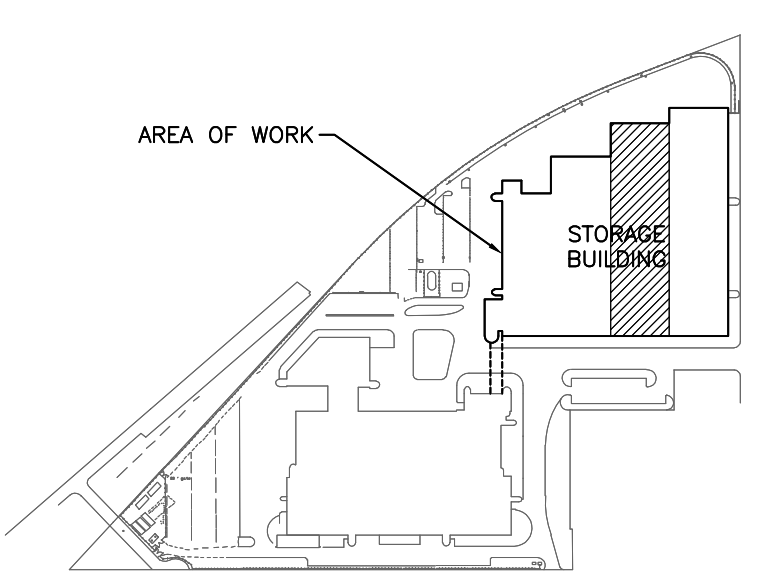

KEY PLAN

NO.	Description	BY	DDMMYY
1	ISSUED FOR ADDENDUM 3	JH	08/2/18
0	ISSUED FOR CONSTRUCTION	JH	08/1/18

ENGINEERS  
GEOSCIENTISTS  
MANITOBA  
Certificate of Authorization  
SMS Engineering Ltd.  
No. 166

ORIGINAL  
CONTRACT DRAWING  
BONED AND SEALED BY  
J.T. HOPKOCKS, P. ENG  
NOVEMBER 9, 2018

770 Bradford Street  
Winnipeg, Canada  
T 204 775 0291  
SMSeng.com

Project Title  
**CITY OF WINNIPEG FORT ROUGE TRANSIT BASE - STORAGE TRACK 13-24 - MECHANICAL UPGRADE**

WINNIPEG MANITOBA

Drawing Title  
**MAIN FLOOR AND ROOF PLAN - TRACK 13-24 - DEMOLITION - VENTILATION**

Drawn By	Checked By	Approved By
JC/AS	XZ	JH
Scale AS NOTED	Date NOVEMBER 2018	Project No. 18-240-01
Revision Number 1	Drawing Number M1.4	Sheet Order 4 OF 12