


1 MAIN FLOOR PLAN - TRACK 13-24 - DEMOLITION - PLUMBING
SCALE: 1/8" = 1'-0"

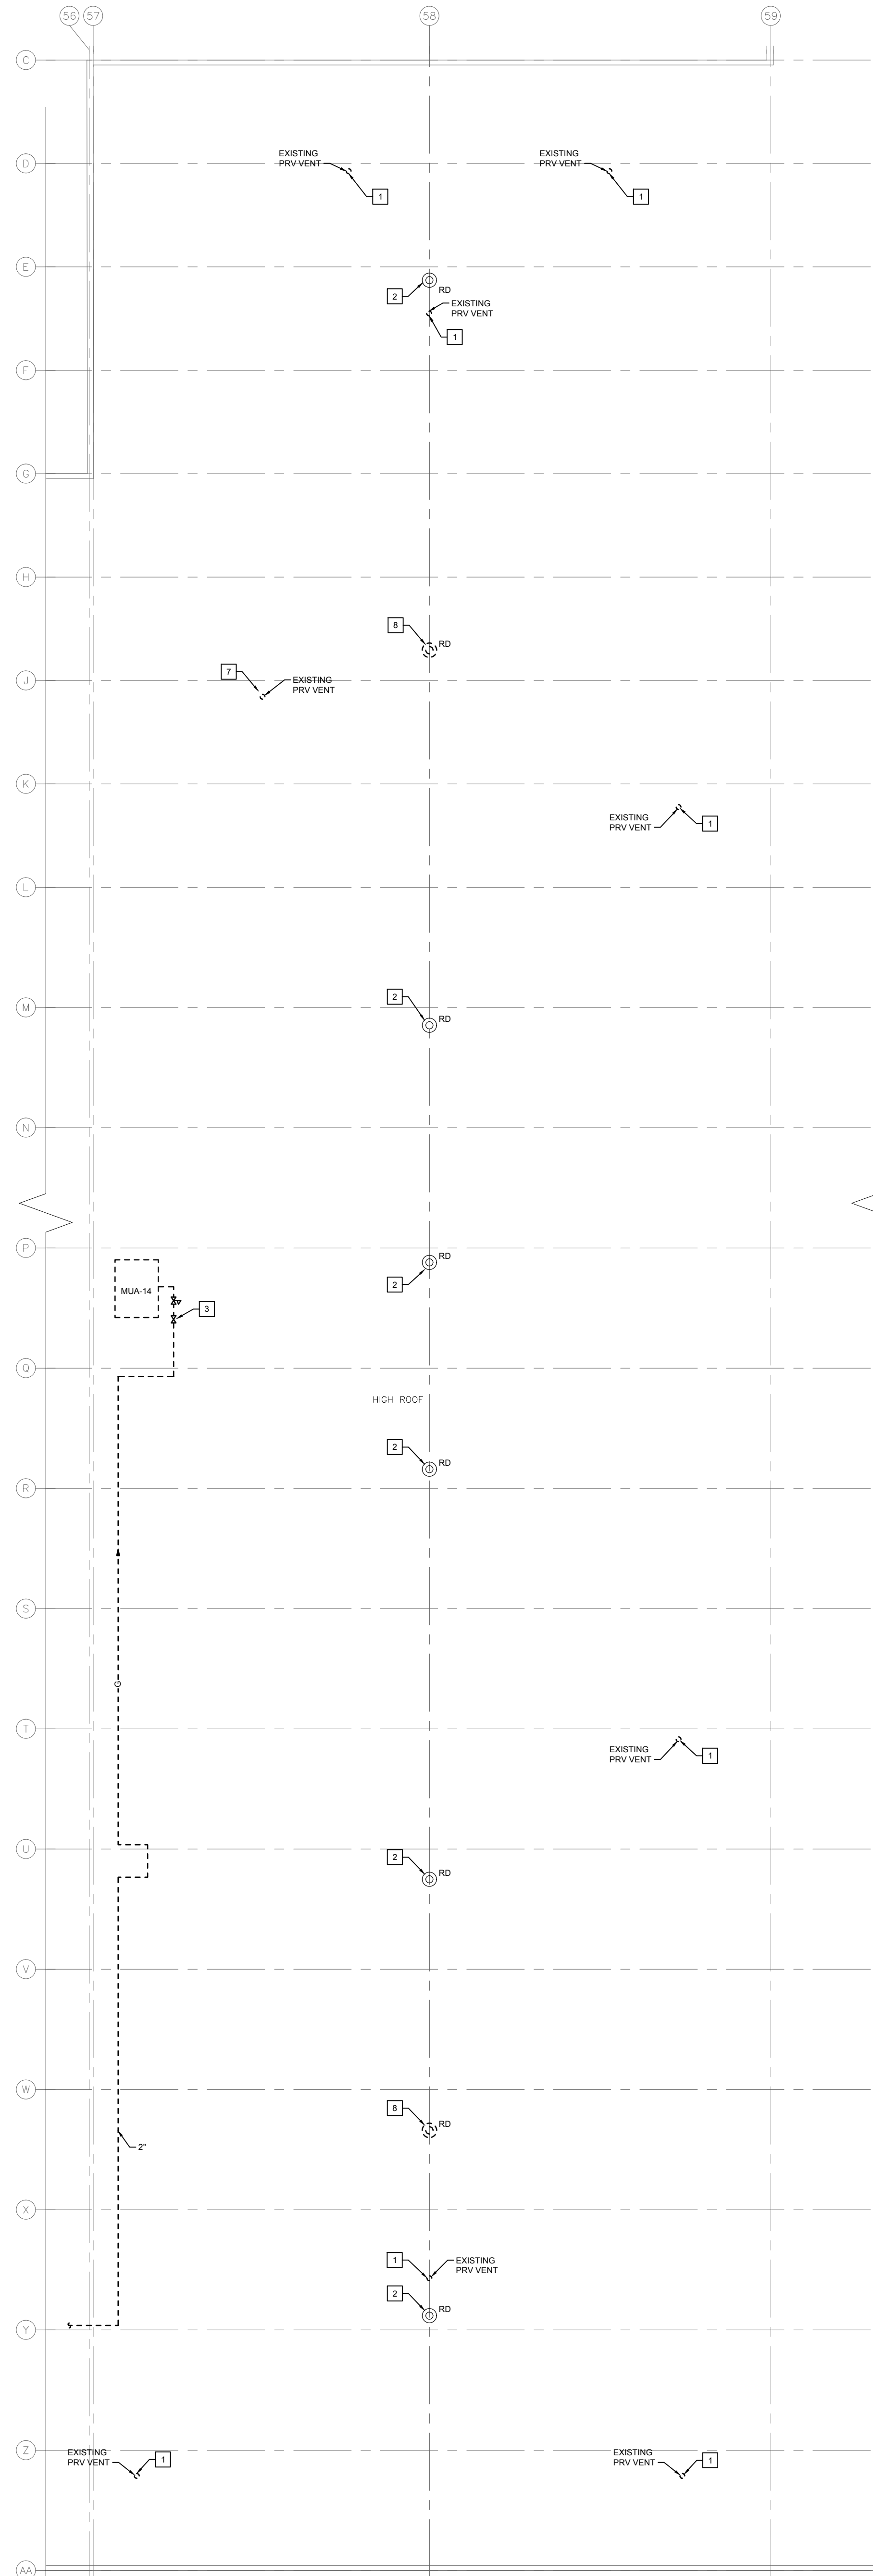


2 ROOF PLAN - TRACK 13-24 - DEMOLITION - PLUMBING
SCALE: 1/8" = 1'-0"

GENERAL NOTES

- A. ALL ABANDONED EQUIPMENT AND SERVICES WITHIN AREA OF WORK SHALL BE REMOVED.
- B. THIS BUILDING MAY CONTAIN ASBESTOS. REFER TO FRONT END SPECIFICATIONS FOR FURTHER INFORMATION.
- C. REFER TO ROOF DETAILS AND SPECIFICATIONS FOR ALL NEW AND CAPPED OPENINGS.

DEMOLITION KEY NOTES

- 1. DEMOLISH AND REMOVE NATURAL GAS PIPING AND VENT BACK TO ISOLATION VALVE AS SHOWN, REPAIR AND SEAL PRV VENT ROOF OPENING (REFER TO STRUCTURAL AND ROOFING SPECIFICATION / DETAILS).
- 2. EXISTING ROOF DRAINS TO REMAIN.
- 3. REMOVE EXISTING NATURAL GAS LINE SERVING MUA-14 ON THE ROOF BACK TO SOURCE IN MECHANICAL ROOM 004 (REFER TO DRAWING M1-2 FOR CONTINUATION). REPAIR AND SEAL ROOF OPENINGS (REFER TO STRUCTURAL AND ROOFING SPECIFICATION / DETAILS).
- 4. REMOVE EXISTING INFRARED HEATER AND ASSOCIATED CONTROLLER AND THERMOSTAT.
- 5. REMOVE EXISTING THERMOSTAT SERVING INFRARED HEATERS.
- 6. EXISTING INFRARED HEATER TO REMAIN.
- 7. RELOCATE EXISTING PRV VENT THROUGH THE ROOF AWAY FROM LOCATION OF NEW HRU (REFER TO DRAWING M2-1).
- 8. RELOCATE EXISTING ROOF DRAIN AWAY FROM LOCATION OF NEW HRU STEEL PLATFORM STANDS. REFER TO M2-1 NEW CONSTRUCTION DRAWING.

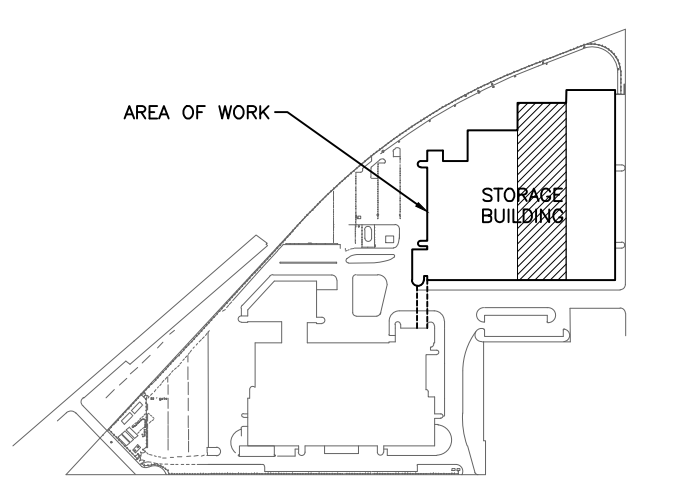

KEY PLAN

NO.	Description	BY	DATE
0	ISSUED FOR CONSTRUCTION	JH	09/11/18



770 Bradford Street
Winnipeg, Canada
T 204 775 0352
SMS Engineering Ltd.
SMSeng.com

Project Title
CITY OF WINNIPEG FORT ROUGE TRANSIT BASE - STORAGE TRACK 13-24 - MECHANICAL UPGRADE

Winnipeg Manitoba
Drawing Title
MAIN FLOOR AND ROOF PLAN - TRACK 13-24 - DEMOLITION - PLUMBING

Drawn By JC/AS	Checked By XZ	Approved By JH
Scale AS NOTED	Date NOVEMBER 2018	Project No. 18-240-01
Revision Number 0	Drawing Number M1.1	Sheet Order 1 OF 12